



LAST SAVE: 02/19/14 @ 16:27:02 BY: BK PLOT: 50, 1/2"=1'

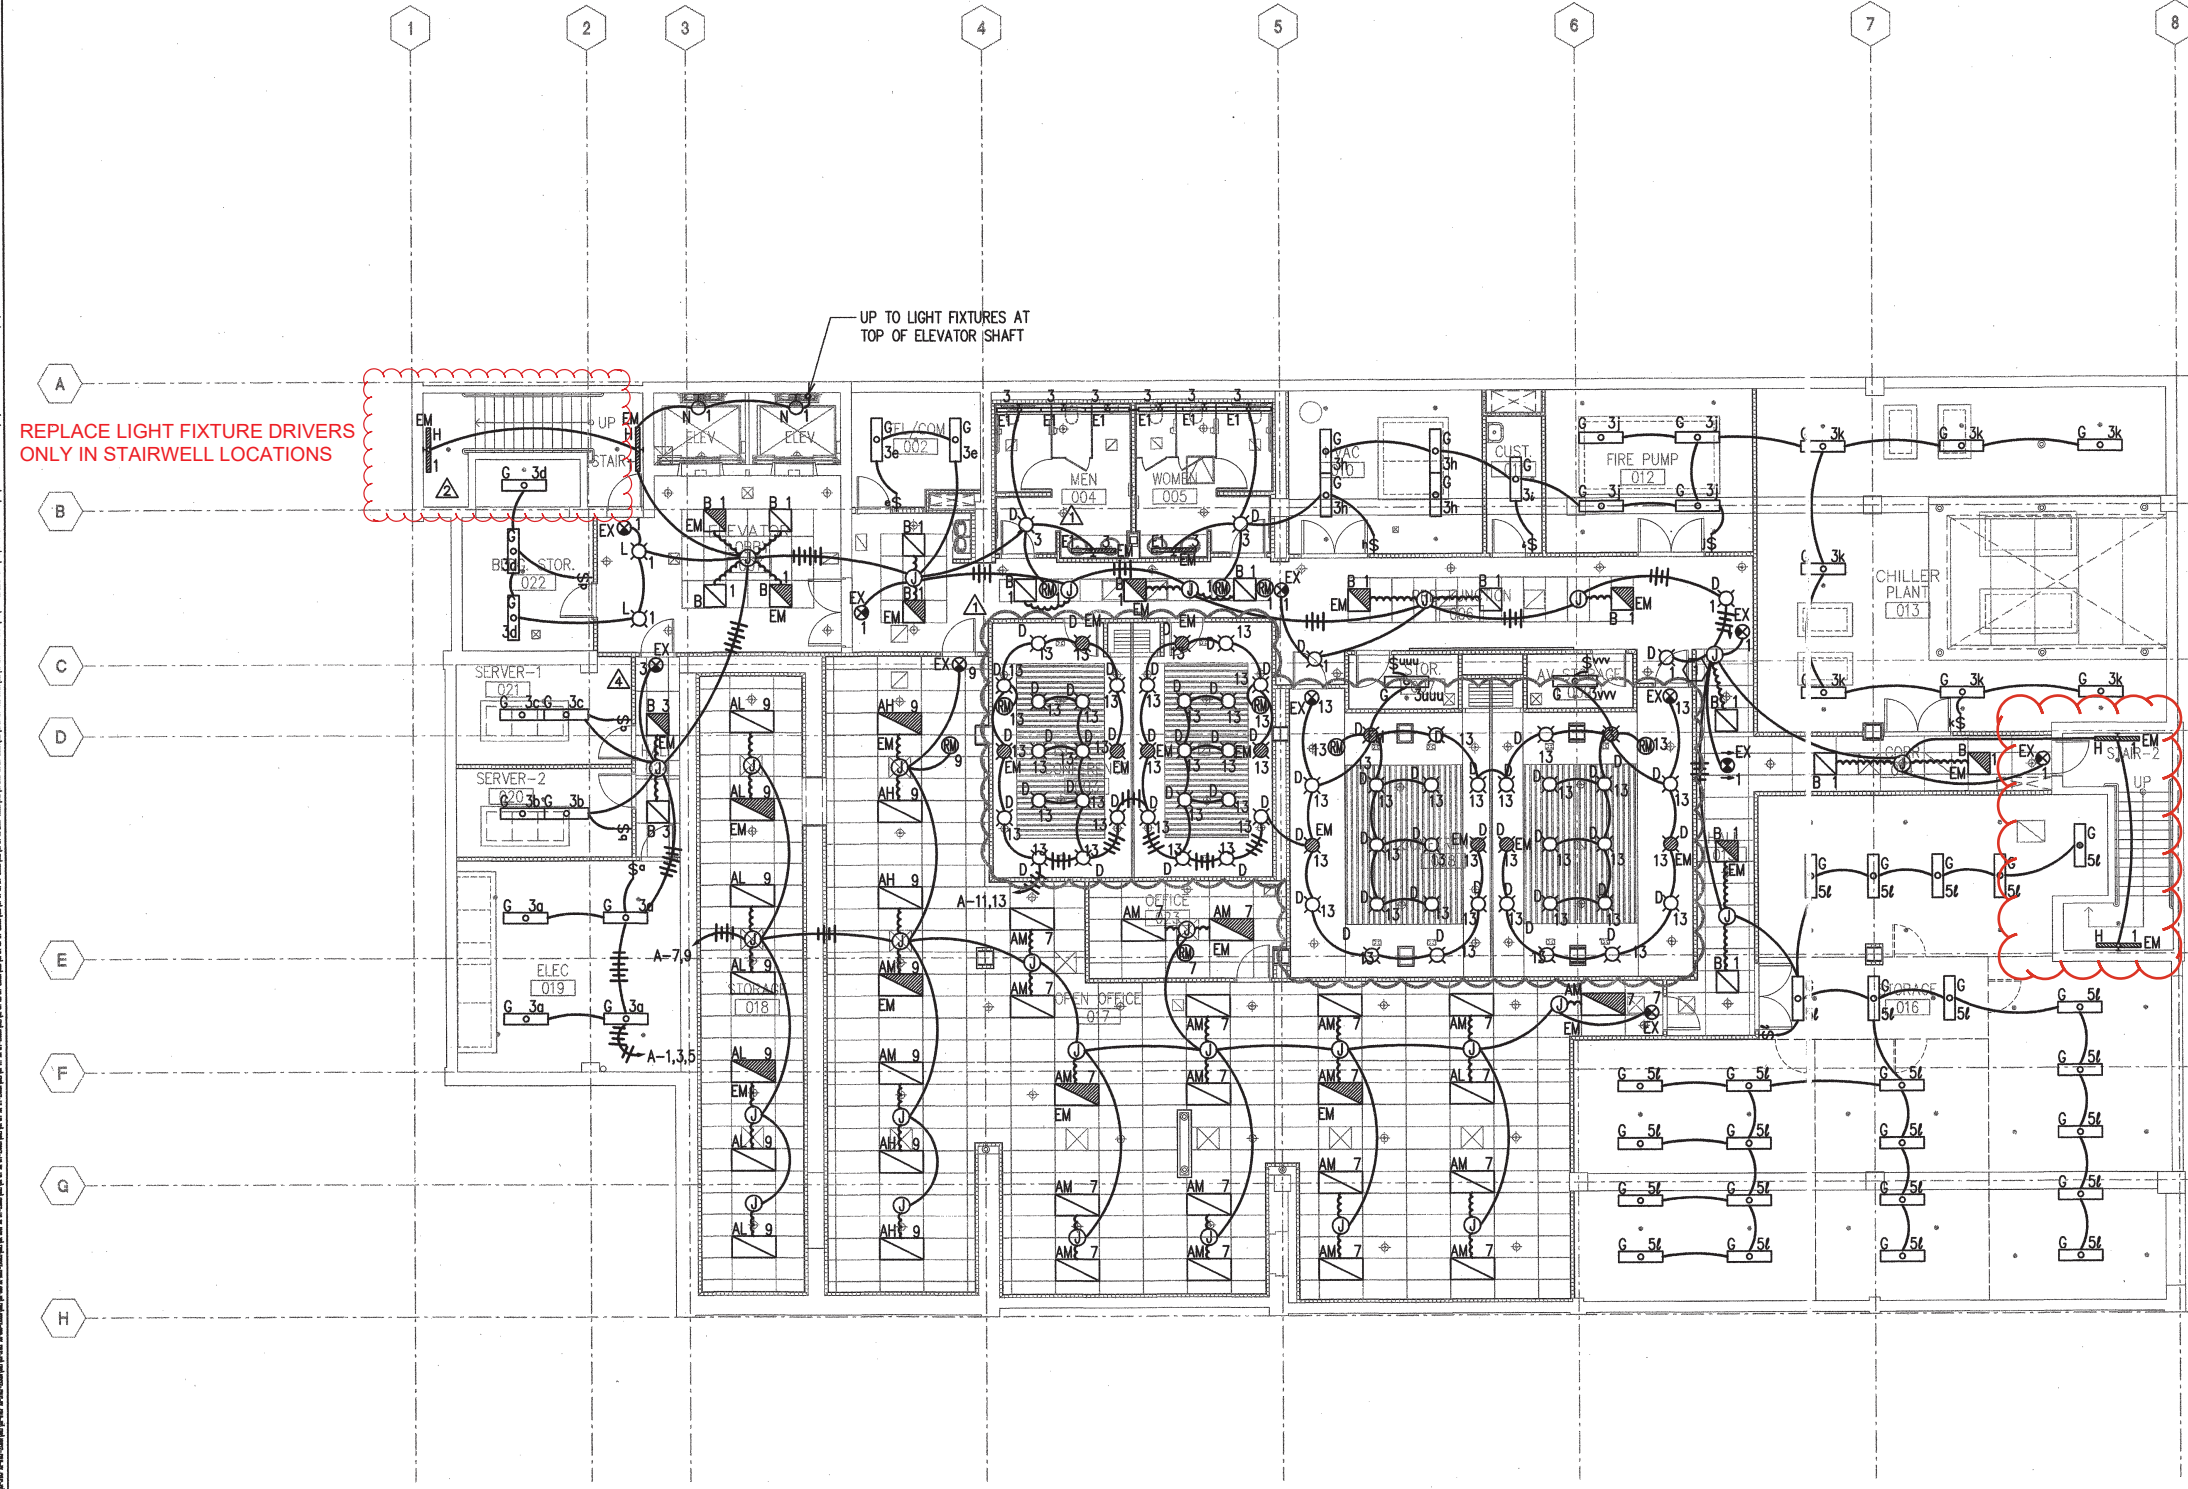


NOTES:

- 1. PROVIDE UNSWITCHED HOT TO EMERGENCY FIXTURES AND EXIT SIGNS.

BASEMENT LIGHTING PLAN
SCALE: 1/8"=1'-0"

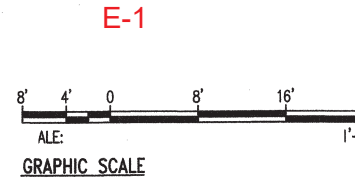

E-1

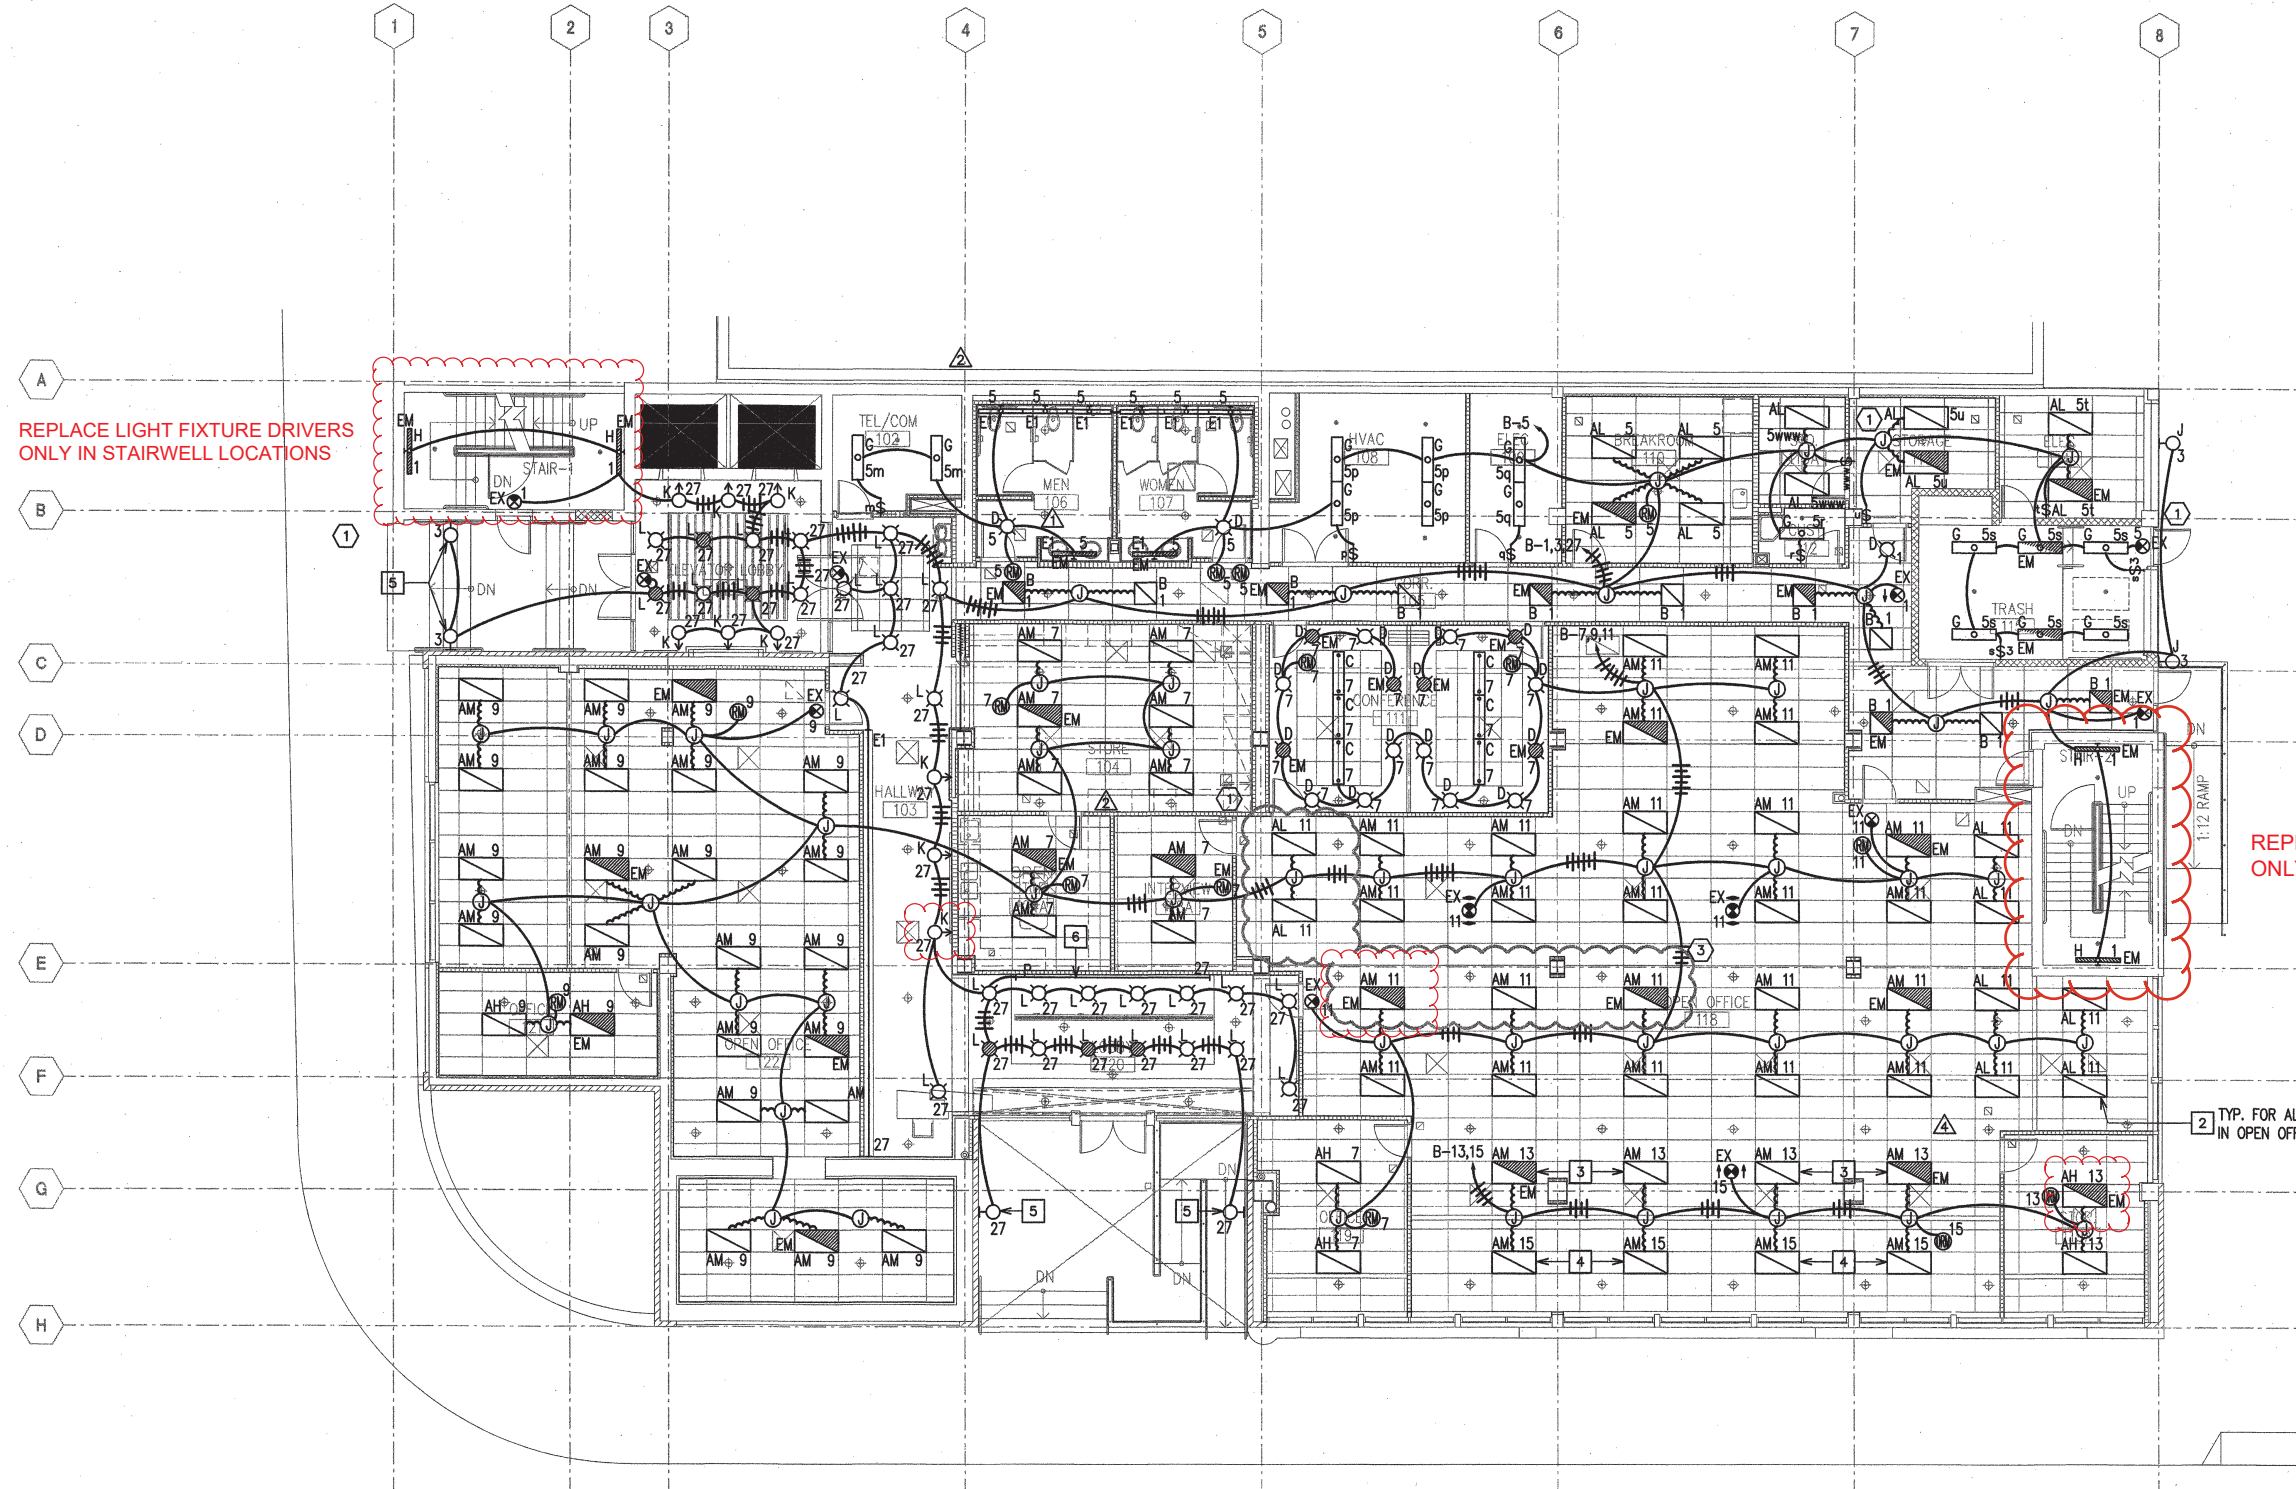

REPLACE LIGHT FIXTURE DRIVERS ONLY IN STAIRWELL LOCATIONS

REPLACE LIGHT FIXTURE DRIVERS ONLY IN STAIRWELL LOCATIONS

2 TYP. FOR ALL IN OPEN OFFICE

NOTES:

- 1. PROVIDE UNSWITCHED HOT TO EMERGENCY FIXTURES AND EXIT SIGNS.
- 2. LIGHTING CONTROL ZONE 1.
- 3. LIGHTING CONTROL ZONE 2.
- 4. LIGHTING CONTROL ZONE 3.
- 5. SEE ARCHITECTURAL DRAWINGS FOR LIGHT FIXTURE.
- 6. SEE ARCHITECTURAL ELEVATION FOR LIGHT FIXTURE INSTALLATION.

LIGHT FIXTURES TO BE REPLACED

FIRST FLOOR LIGHTING PLAN


SCALE: 1/8"=1'-0"



E-2



GRAPHIC SCALE

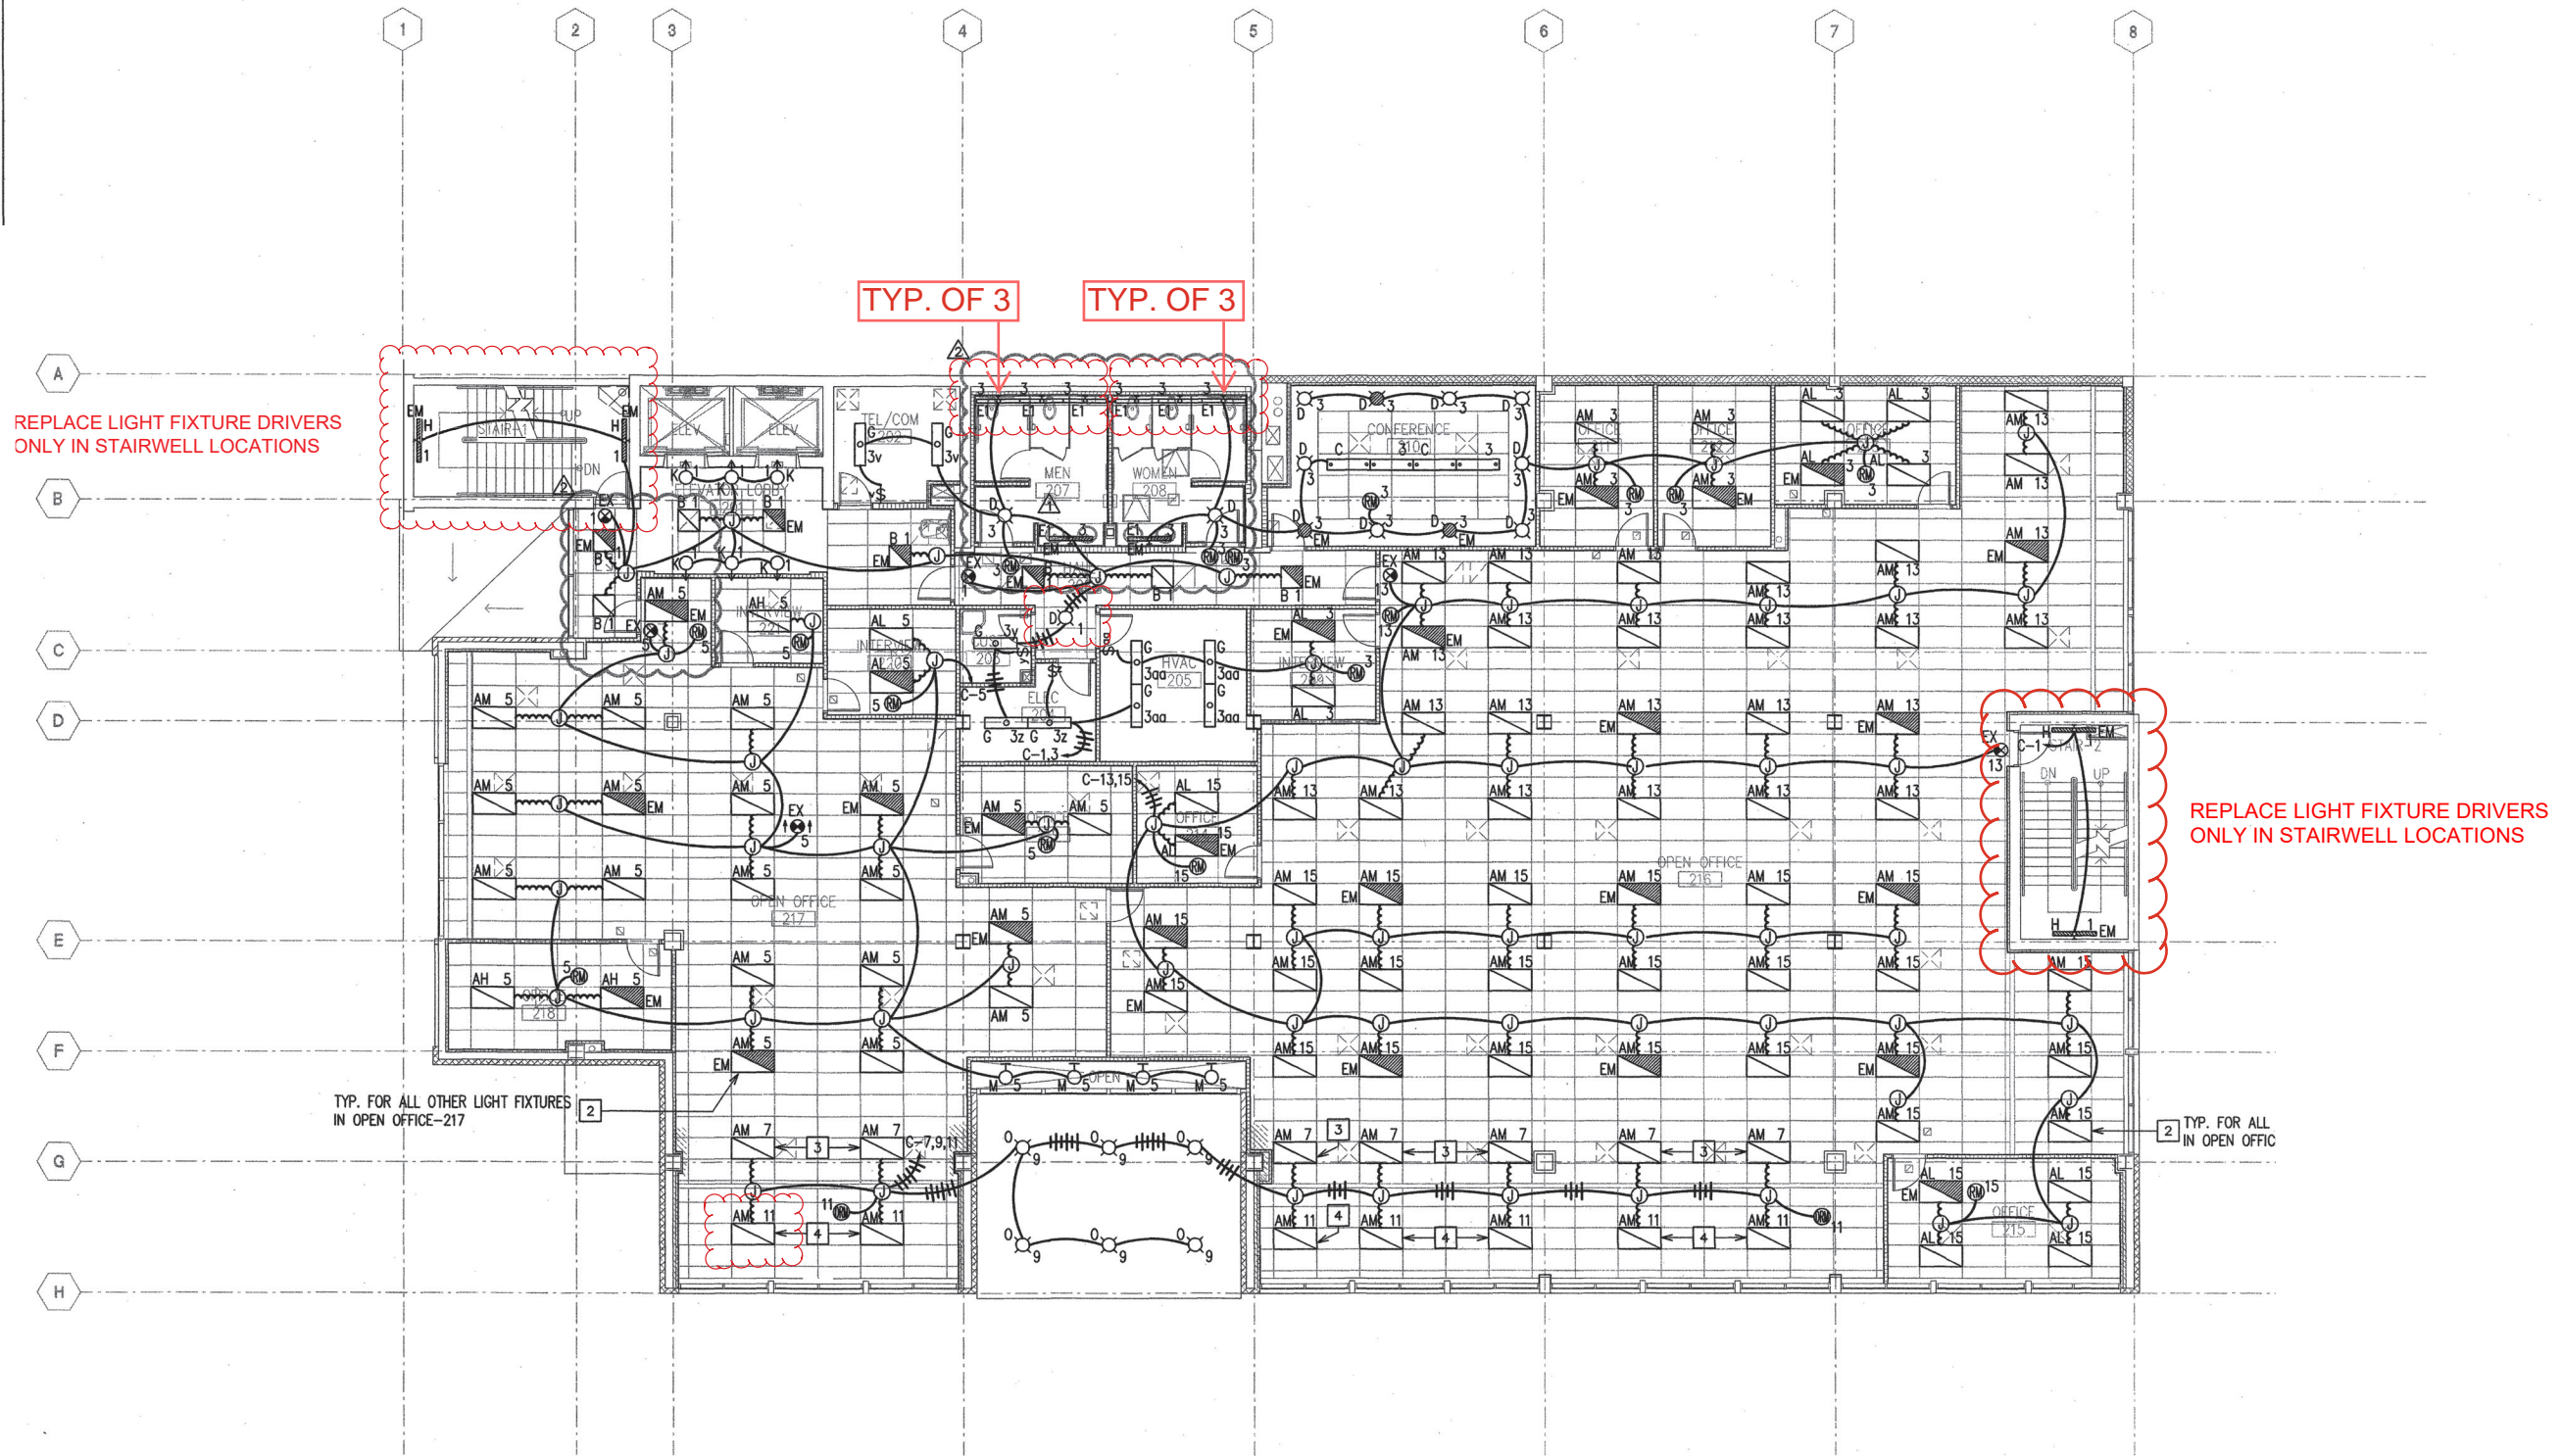


NOTES:

- 1. PROVIDE UNSWITCHED HOT TO EMERGENCY FIXTURES AND EXIT SIGNS.
- 2. LIGHTING CONTROL ZONE 1.
- 3. LIGHTING CONTROL ZONE 2.
- 4. LIGHTING CONTROL ZONE 3.


LIGHT FIXTURES TO BE REPLACED

E-3

 SECOND FLOOR LIGHTING PLAN
SCALE: 1/8"=1'-0"



GRAPHIC SCALE

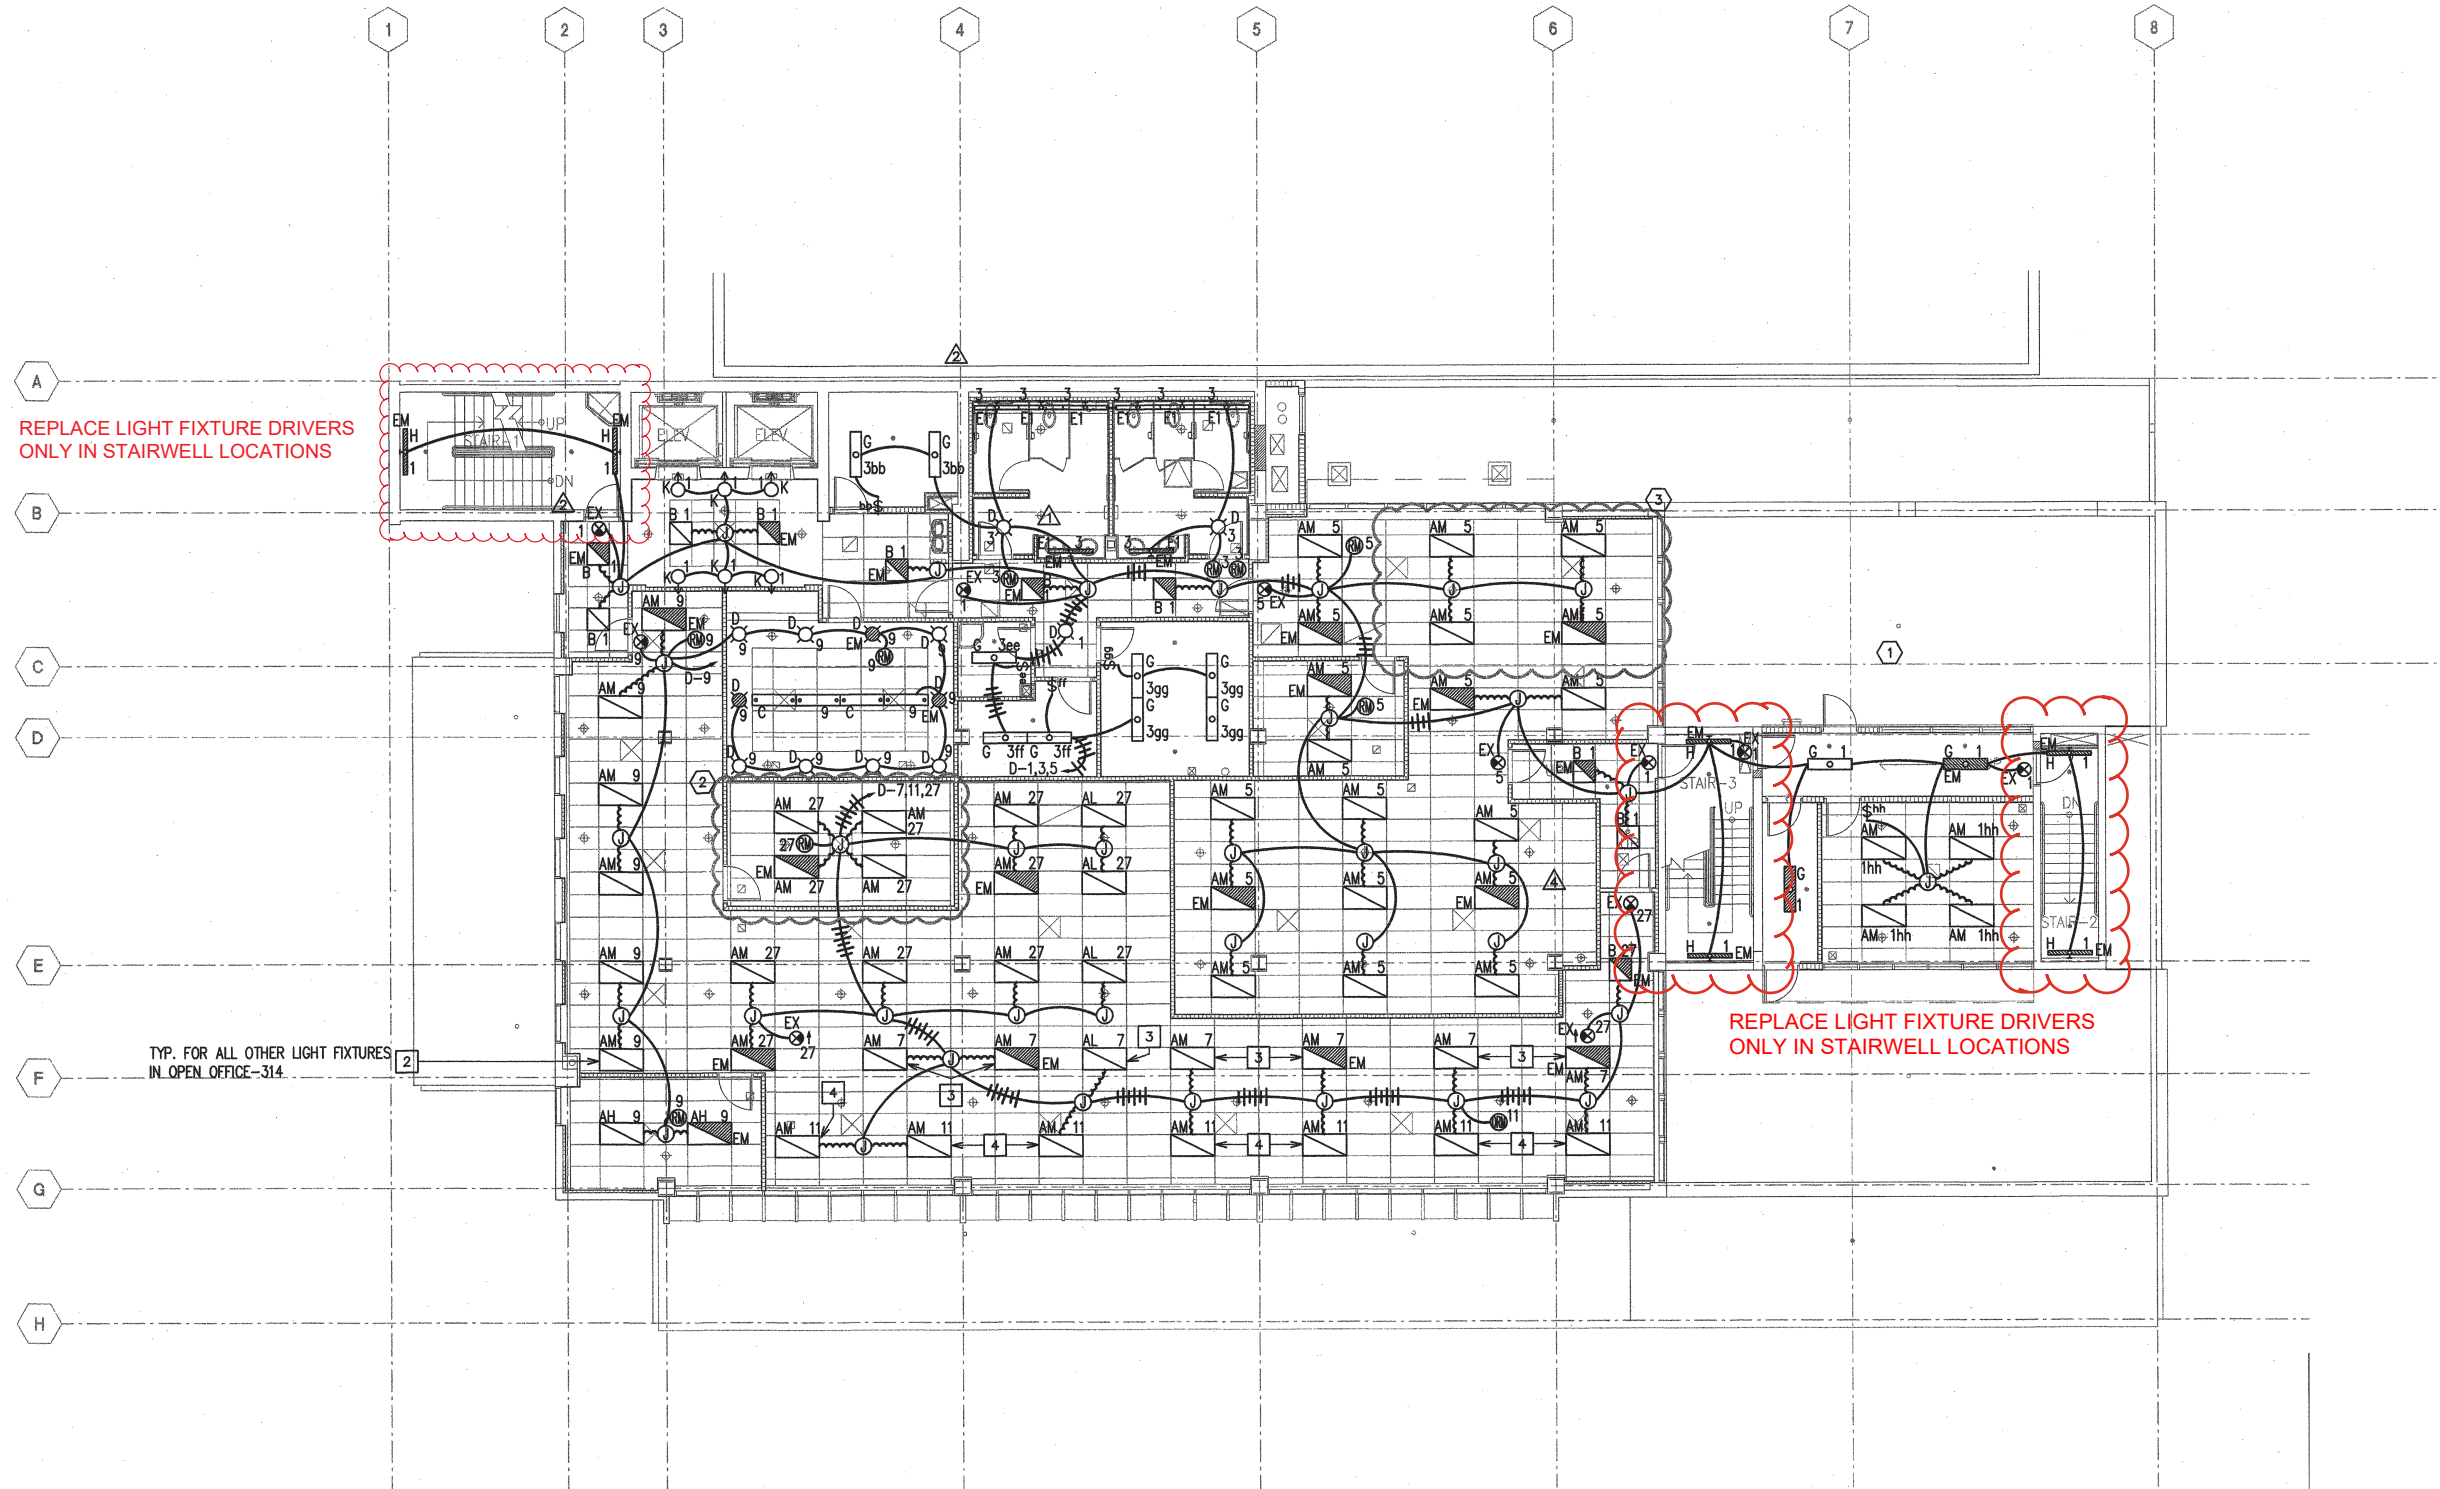

NOTES:

- 1. PROVIDE UNSWITCHED HOT TO EMERGENCY FIXTURES AND EXIT SIGNS.
- 2 LIGHTING CONTROL ZONE 1.
- 3 LIGHTING CONTROL ZONE 2.
- 4 LIGHTING CONTROL ZONE 3.


THIRD FLOOR LIGHTING PLAN
SCALE: 1/8"=1'-0"



E-4



GRAPHIC SCALE

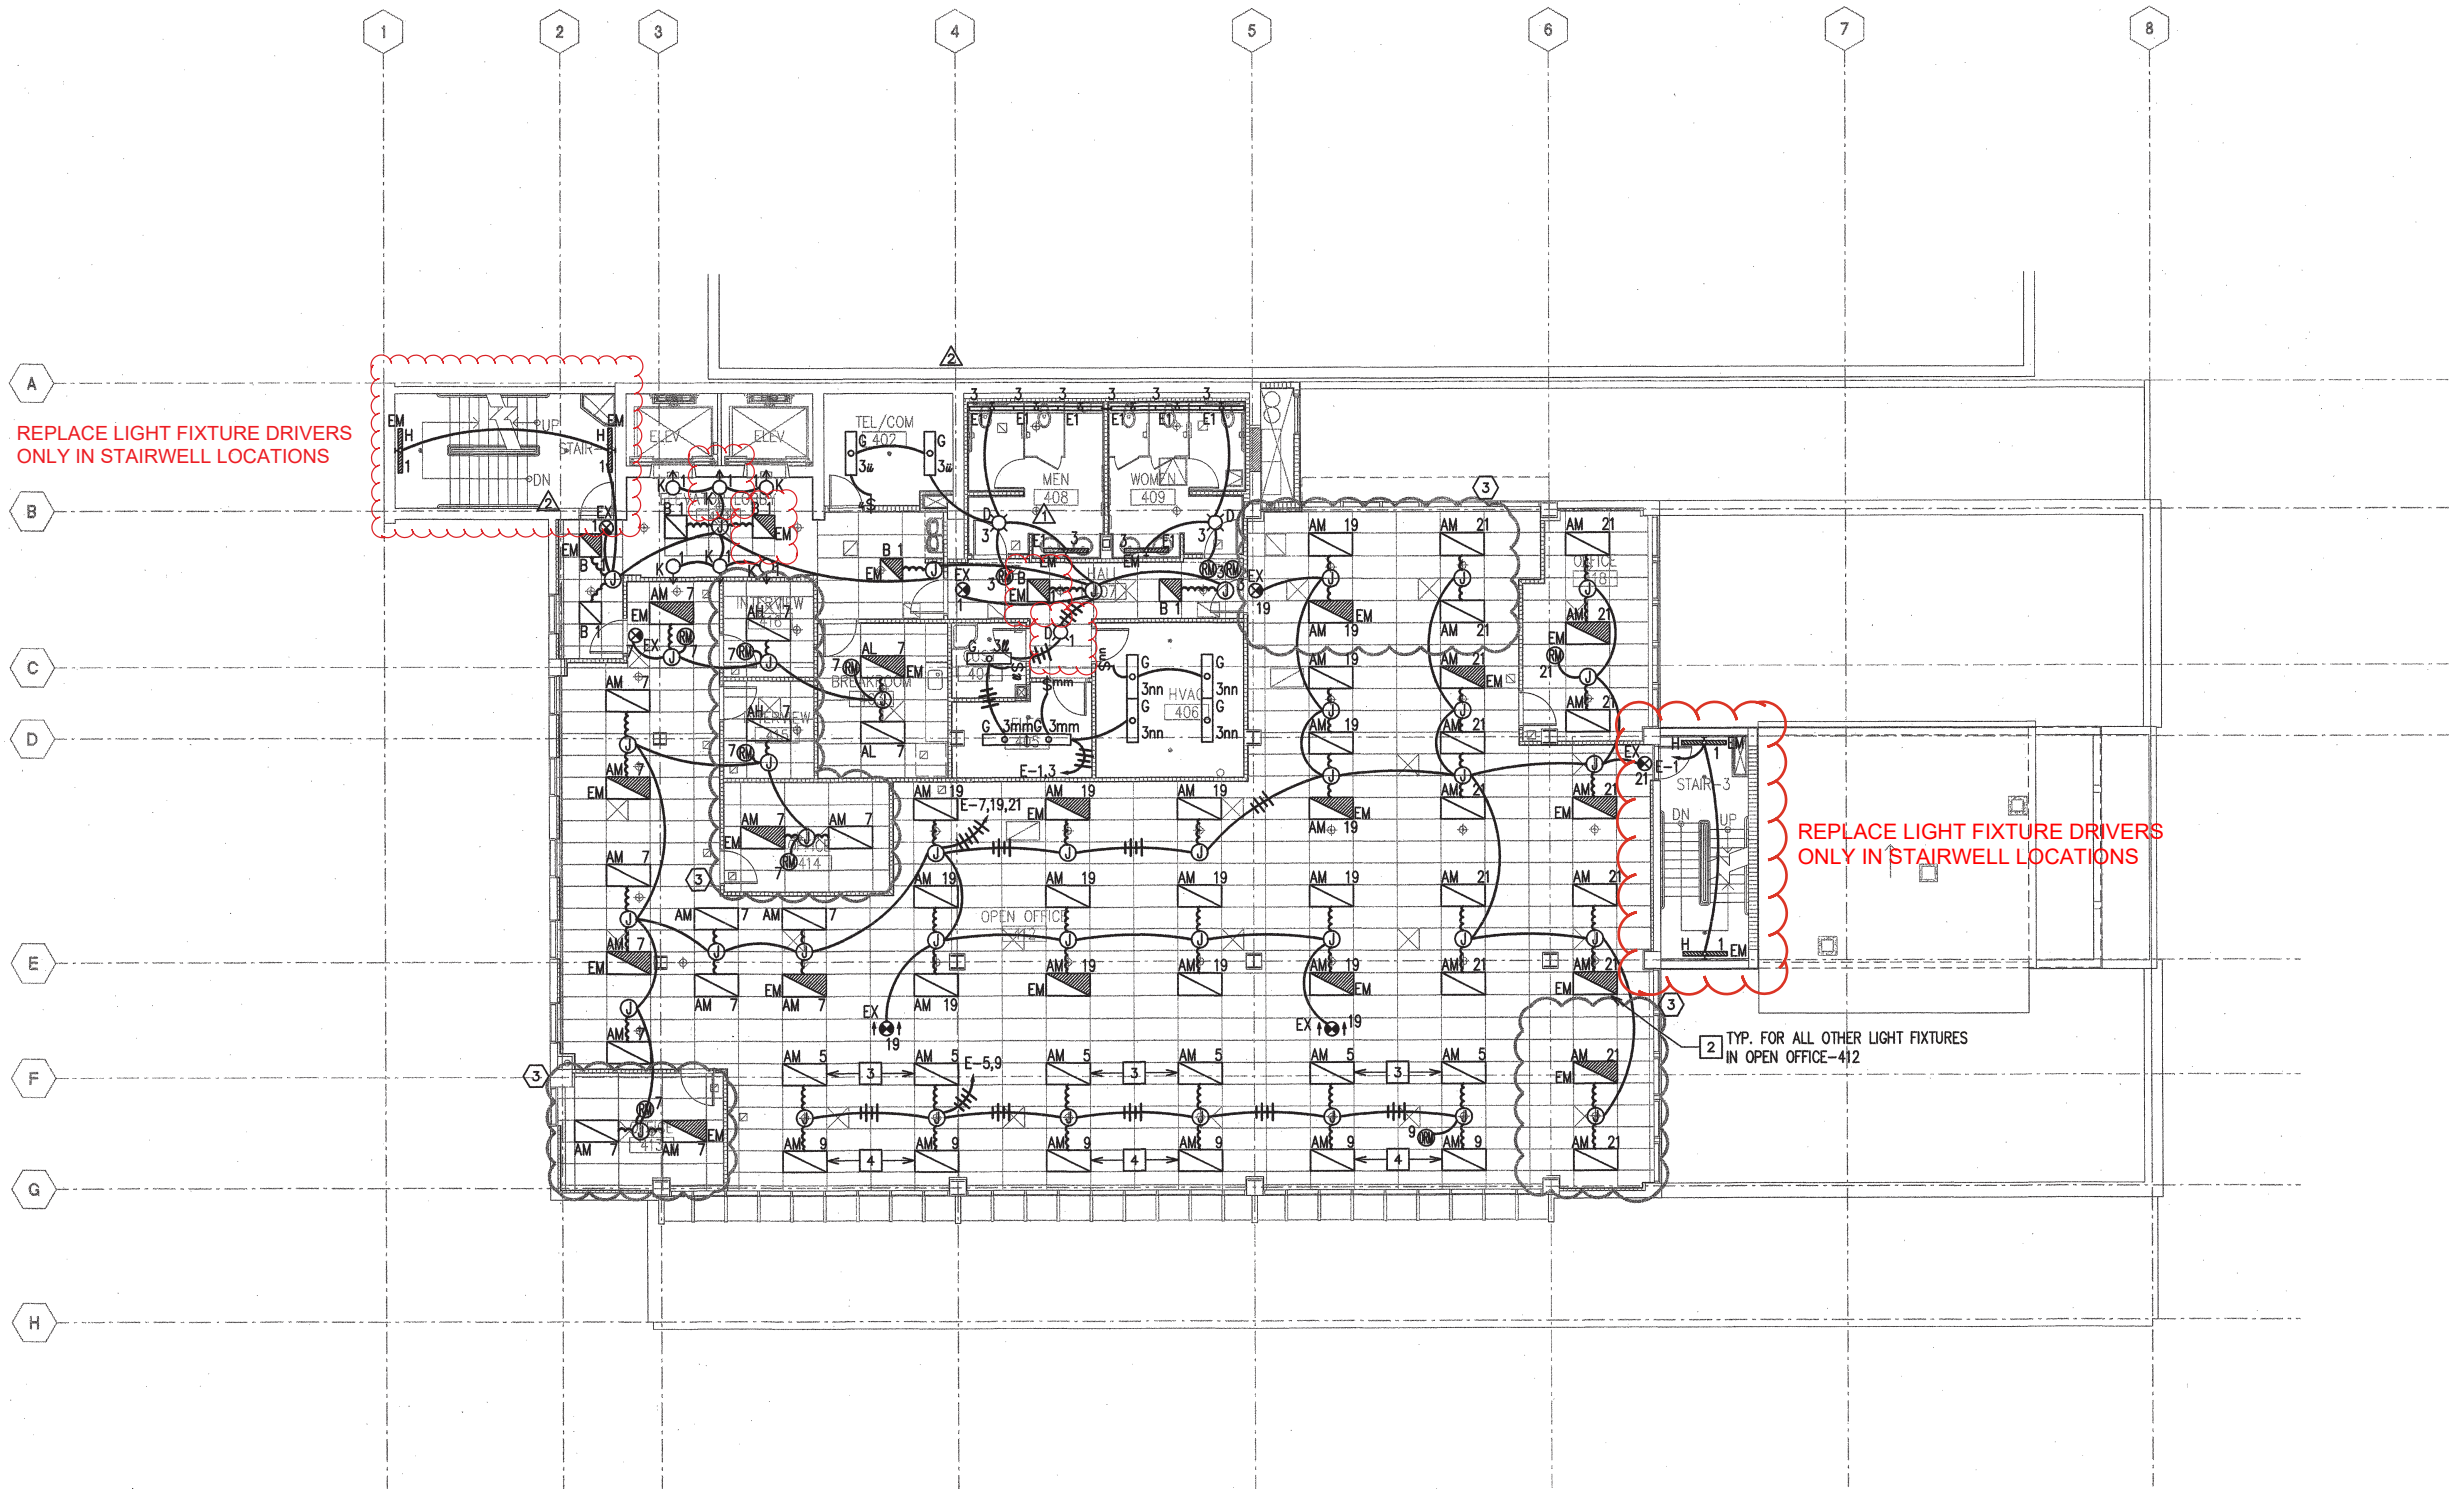

REPLACE LIGHT FIXTURE DRIVERS ONLY IN STAIRWELL LOCATIONS


REPLACE LIGHT FIXTURE DRIVERS ONLY IN STAIRWELL LOCATIONS


2 TYP. FOR ALL OTHER LIGHT FIXTURES IN OPEN OFFICE-412

LIGHT FIXTURES TO BE REPLACED

- NOTES:**
1. PROVIDE UNSWITCHED HOT TO EMERGENCY FIXTURES AND EXIT SIGNS.
 - 2 LIGHTING CONTROL ZONE 1.
 - 3 LIGHTING CONTROL ZONE 2.
 - 4 LIGHTING CONTROL ZONE 3.

FOURTH FLOOR LIGHTING PLAN
SCALE: 1/8"=1'-0"

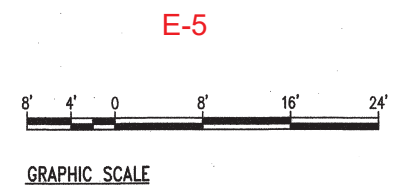

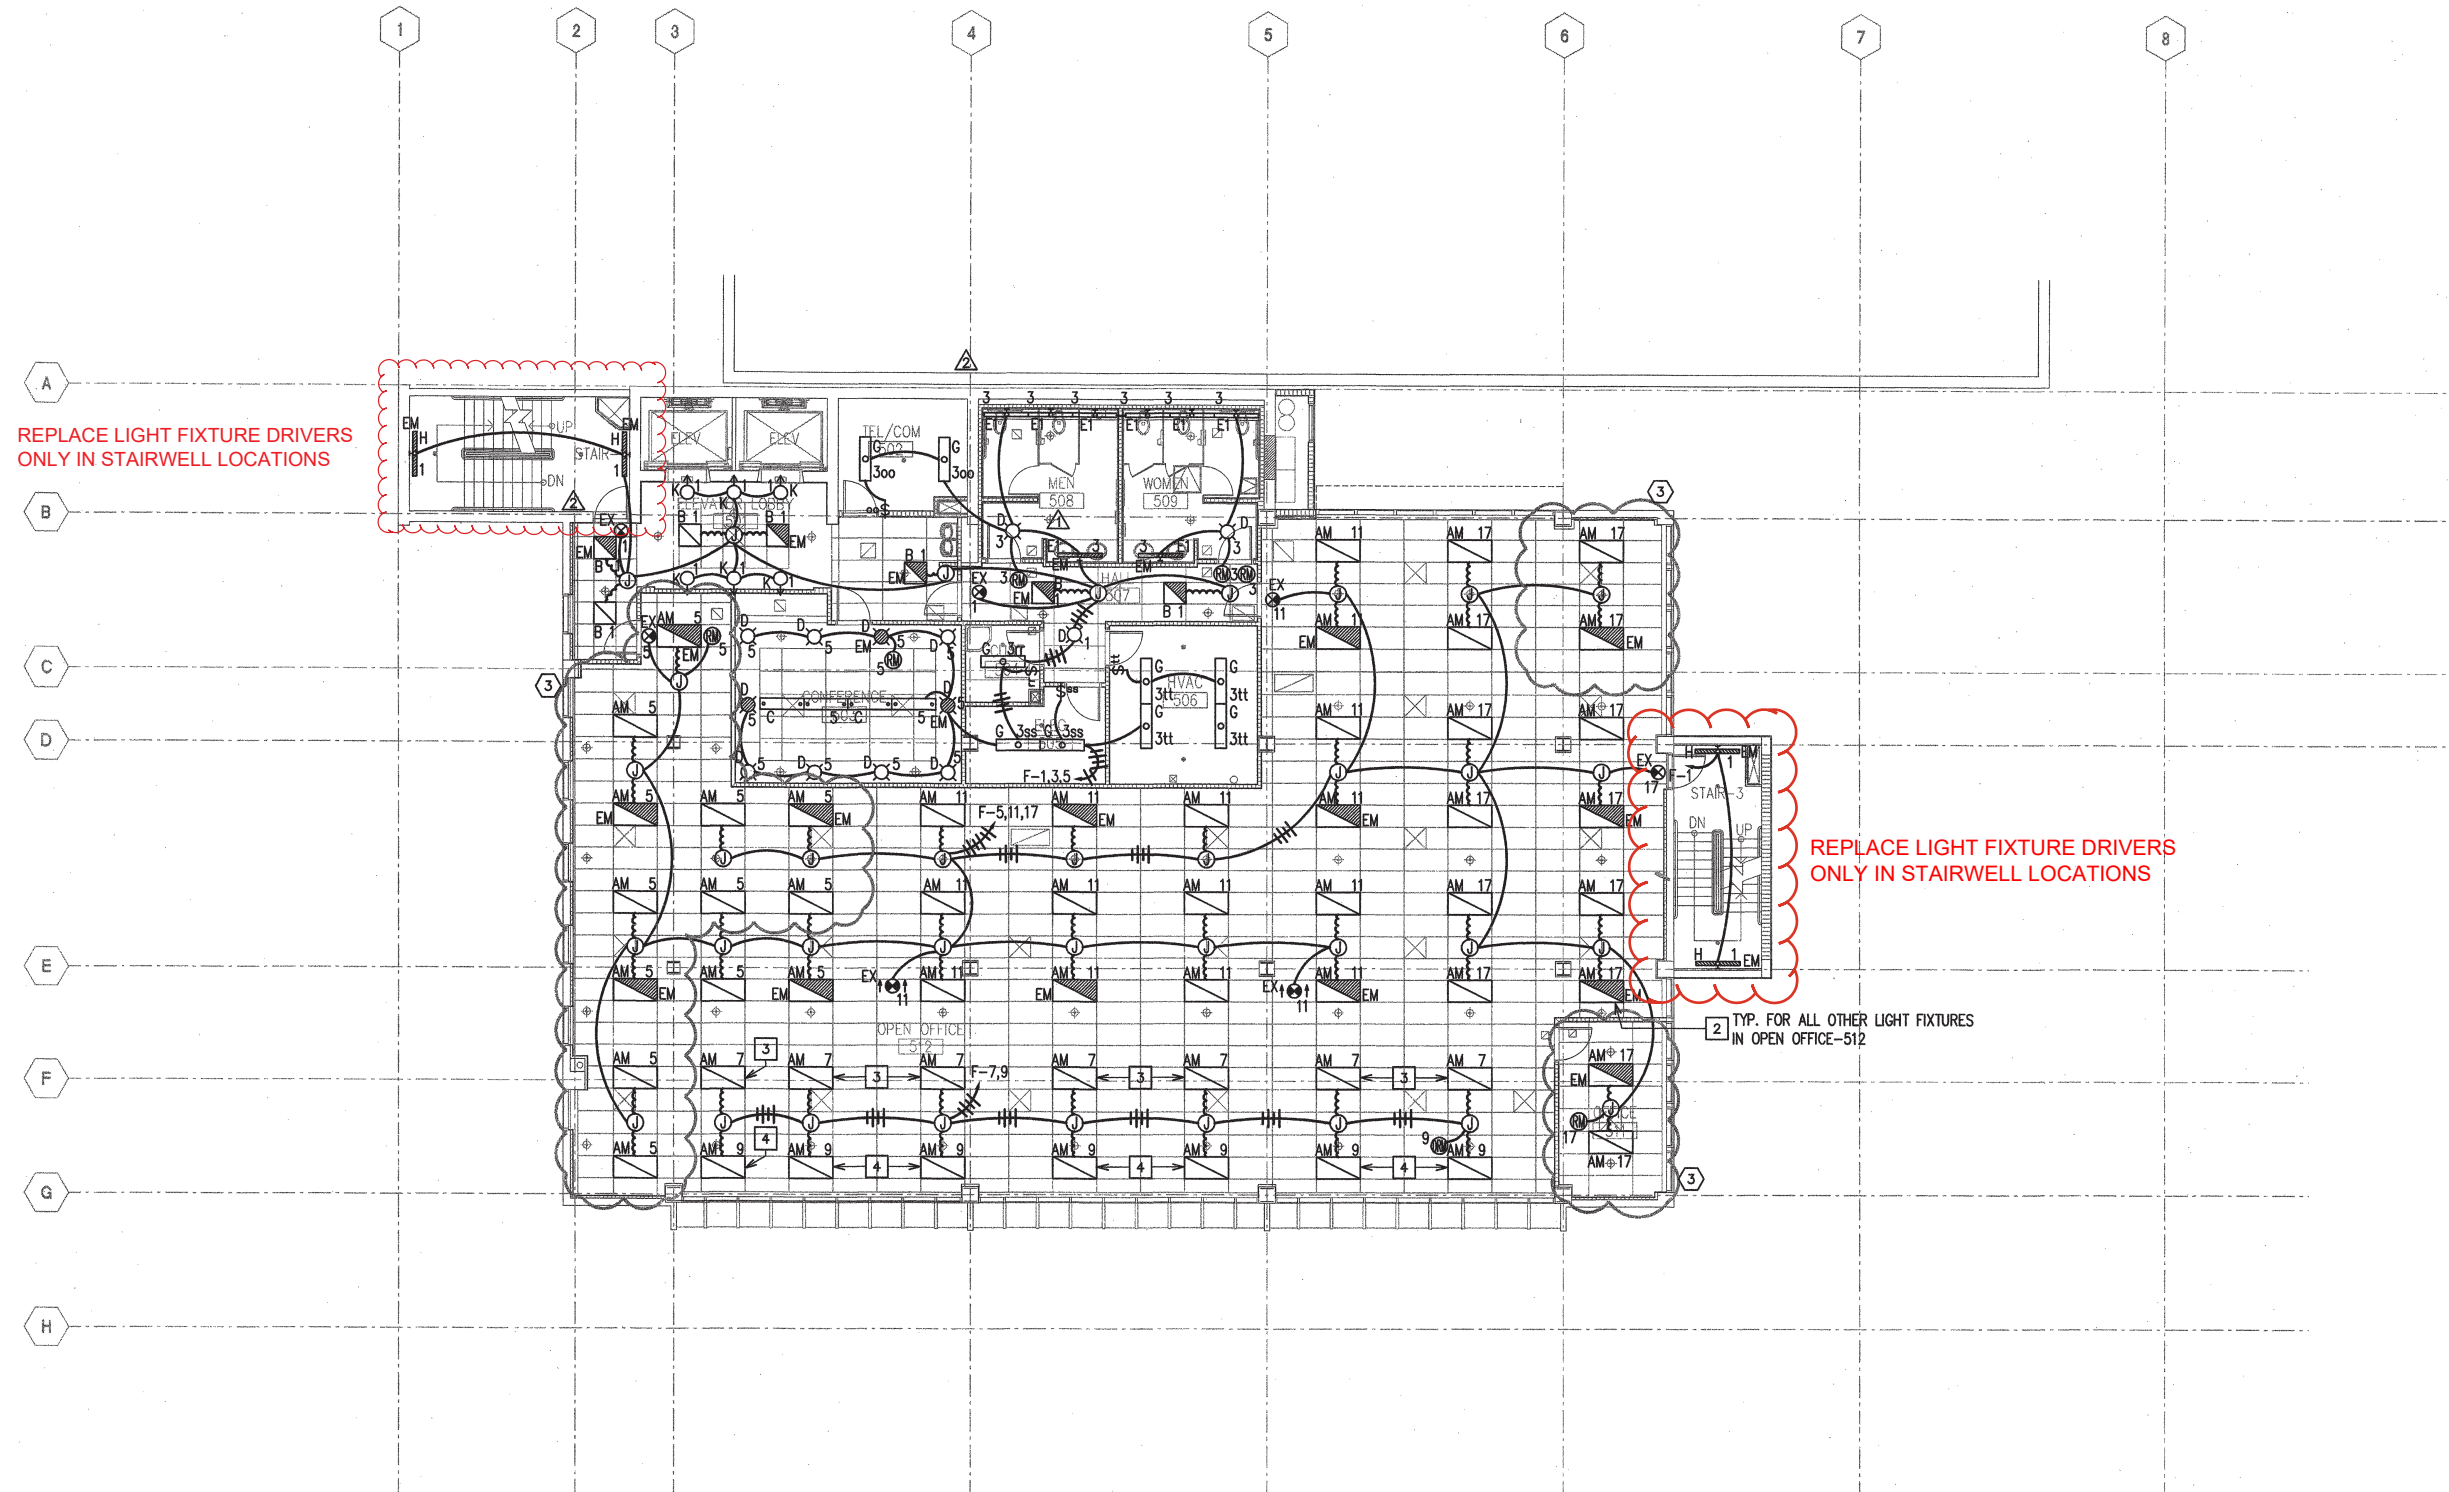

REPLACE LIGHT FIXTURE DRIVERS
ONLY IN STAIRWELL LOCATIONS

REPLACE LIGHT FIXTURE DRIVERS
ONLY IN STAIRWELL LOCATIONS

2 TYP. FOR ALL OTHER LIGHT FIXTURES
IN OPEN OFFICE-512

 
NOTES:

- 1. PROVIDE UNSWITCHED HOT TO EMERGENCY FIXTURES AND EXIT SIGNS.
- 2 LIGHTING CONTROL ZONE 1.
- 3 LIGHTING CONTROL ZONE 2.
- 4 LIGHTING CONTROL ZONE 3.


FIFTH FLOOR LIGHTING PLAN
SCALE: 1/8"=1'-0"



E-6



GRAPHIC SCALE

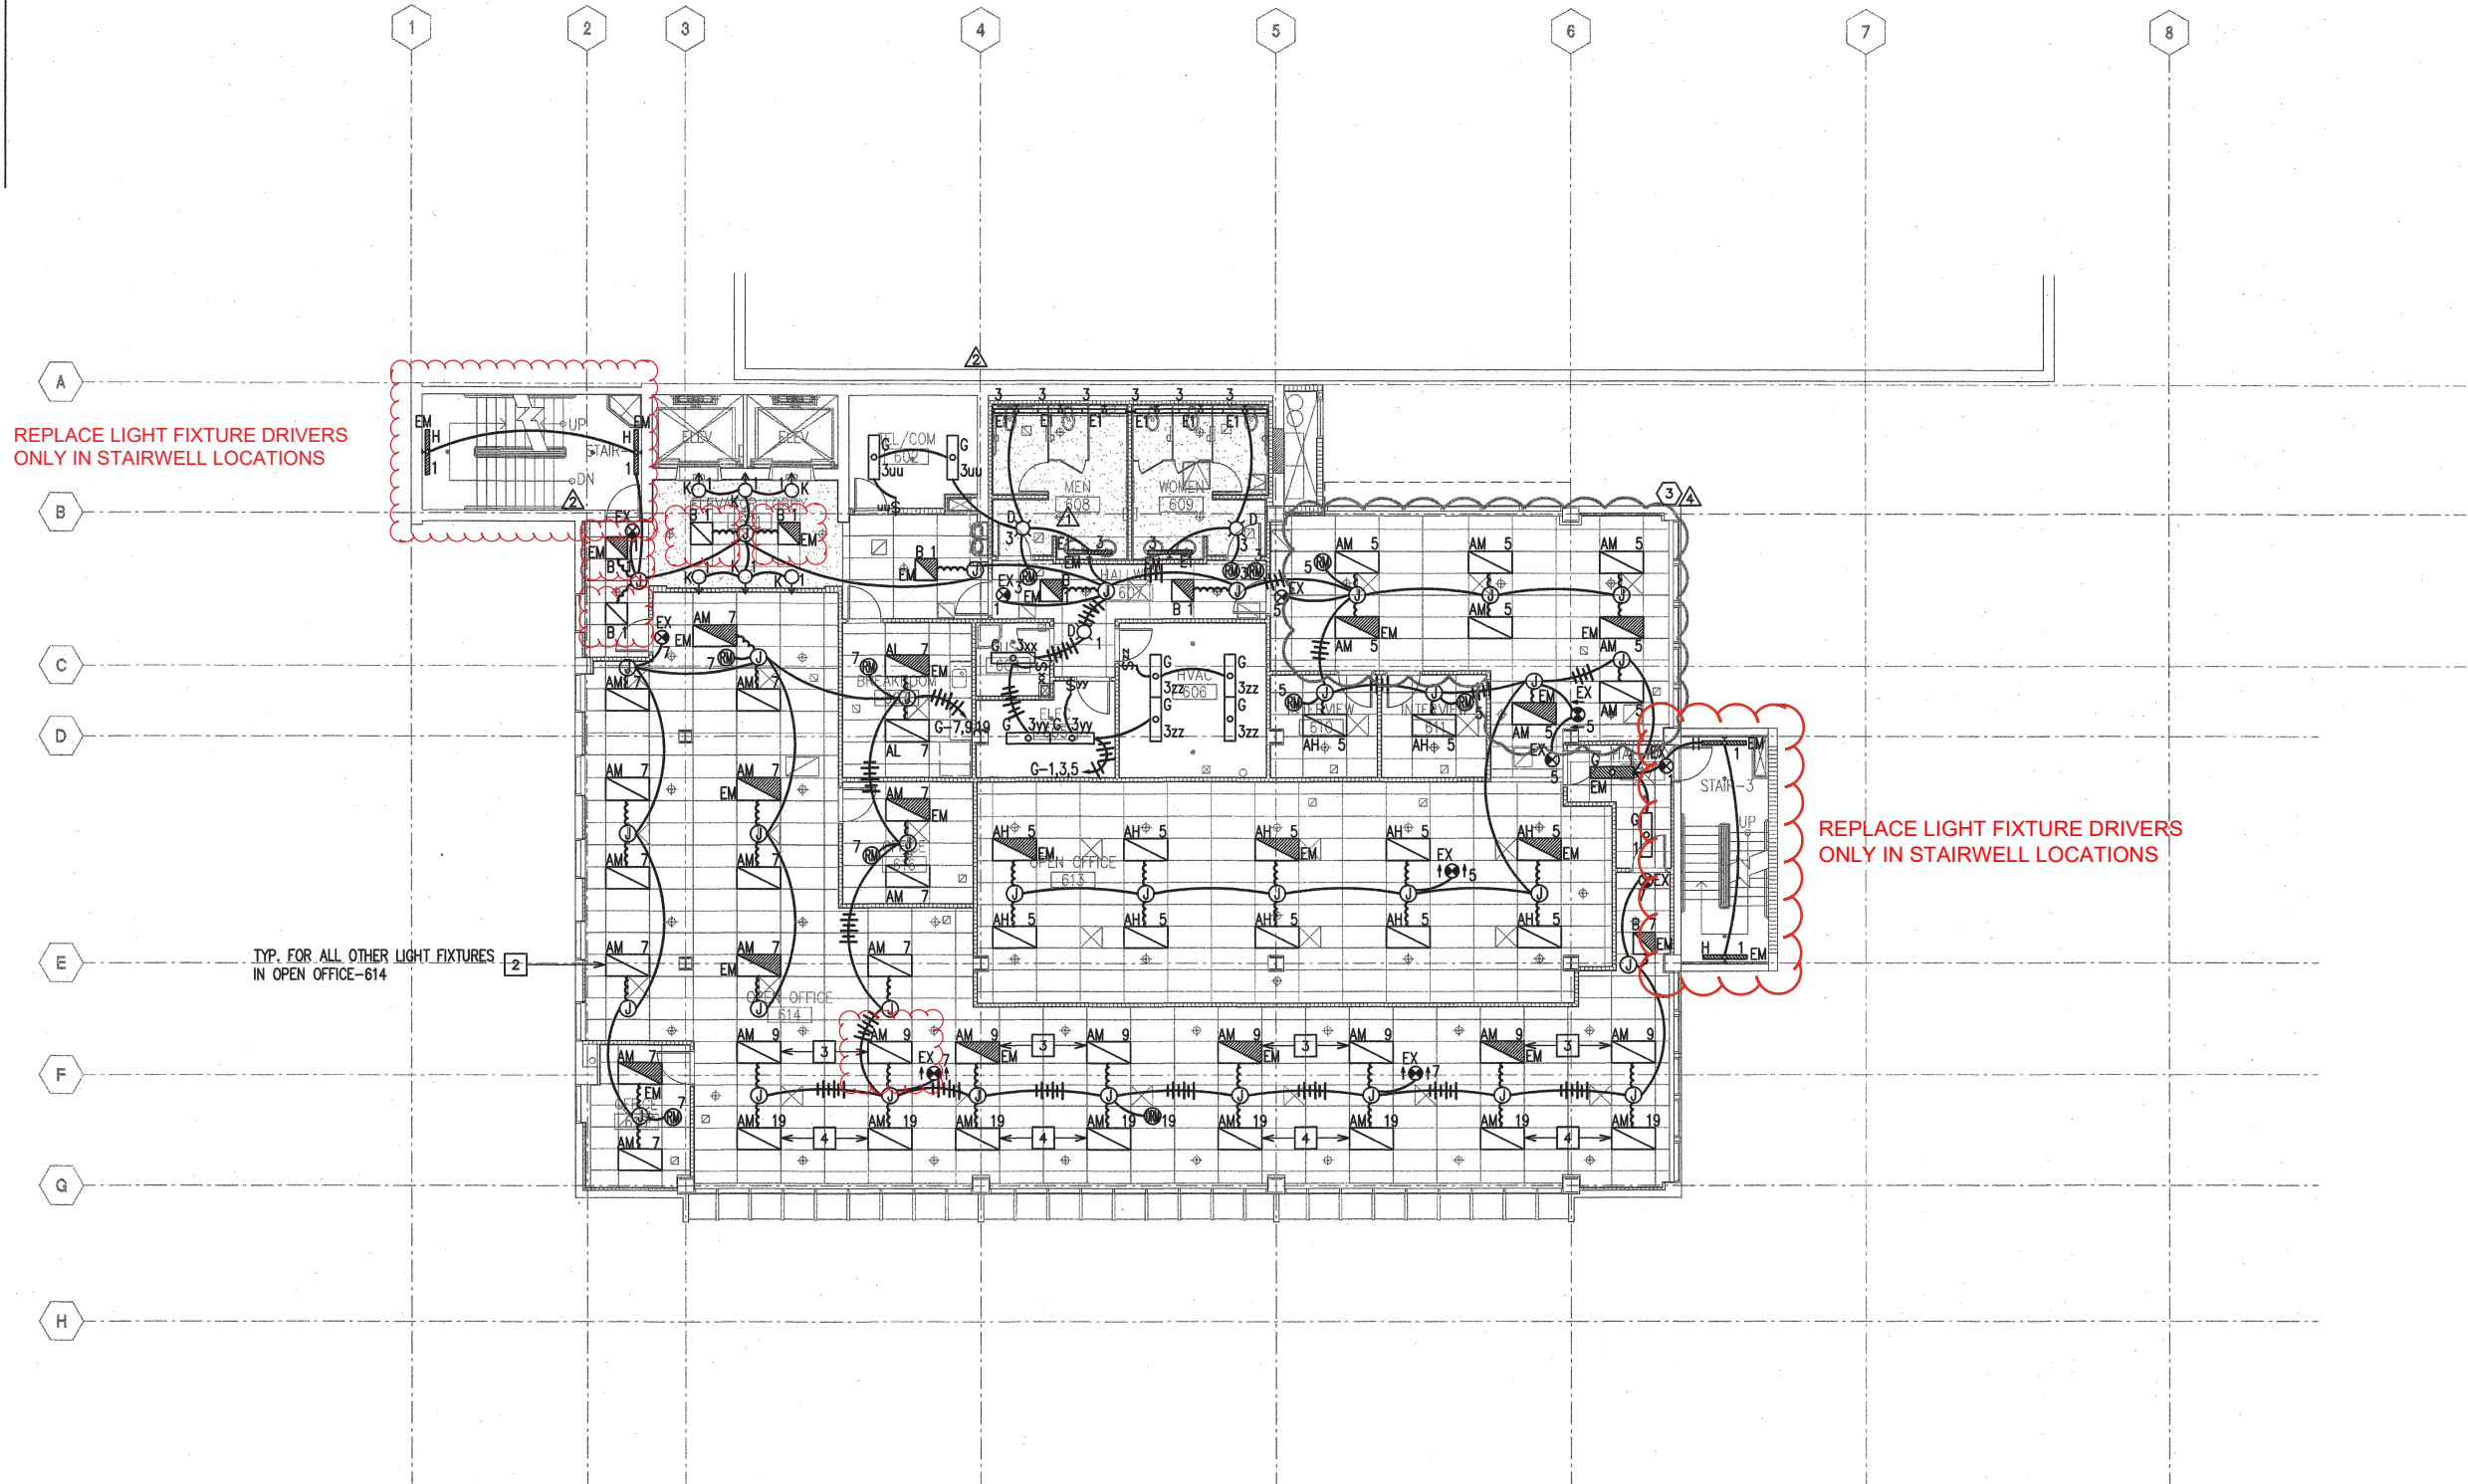

REPLACE LIGHT FIXTURE DRIVERS ONLY IN STAIRWELL LOCATIONS

REPLACE LIGHT FIXTURE DRIVERS ONLY IN STAIRWELL LOCATIONS


TYP. FOR ALL OTHER LIGHT FIXTURES IN OPEN OFFICE-614


LIGHT FIXTURES TO BE REPLACED

NOTES:

- 1. PROVIDE UNSWITCHED HOT TO EMERGENCY FIXTURES AND EXIT SIGNS.
- 2. LIGHTING CONTROL ZONE 1.
- 3. LIGHTING CONTROL ZONE 2.
- 4. LIGHTING CONTROL ZONE 3.

SIXTH FLOOR LIGHTING PLAN
SCALE: 1/8"=1'-0"

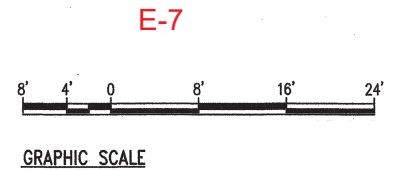

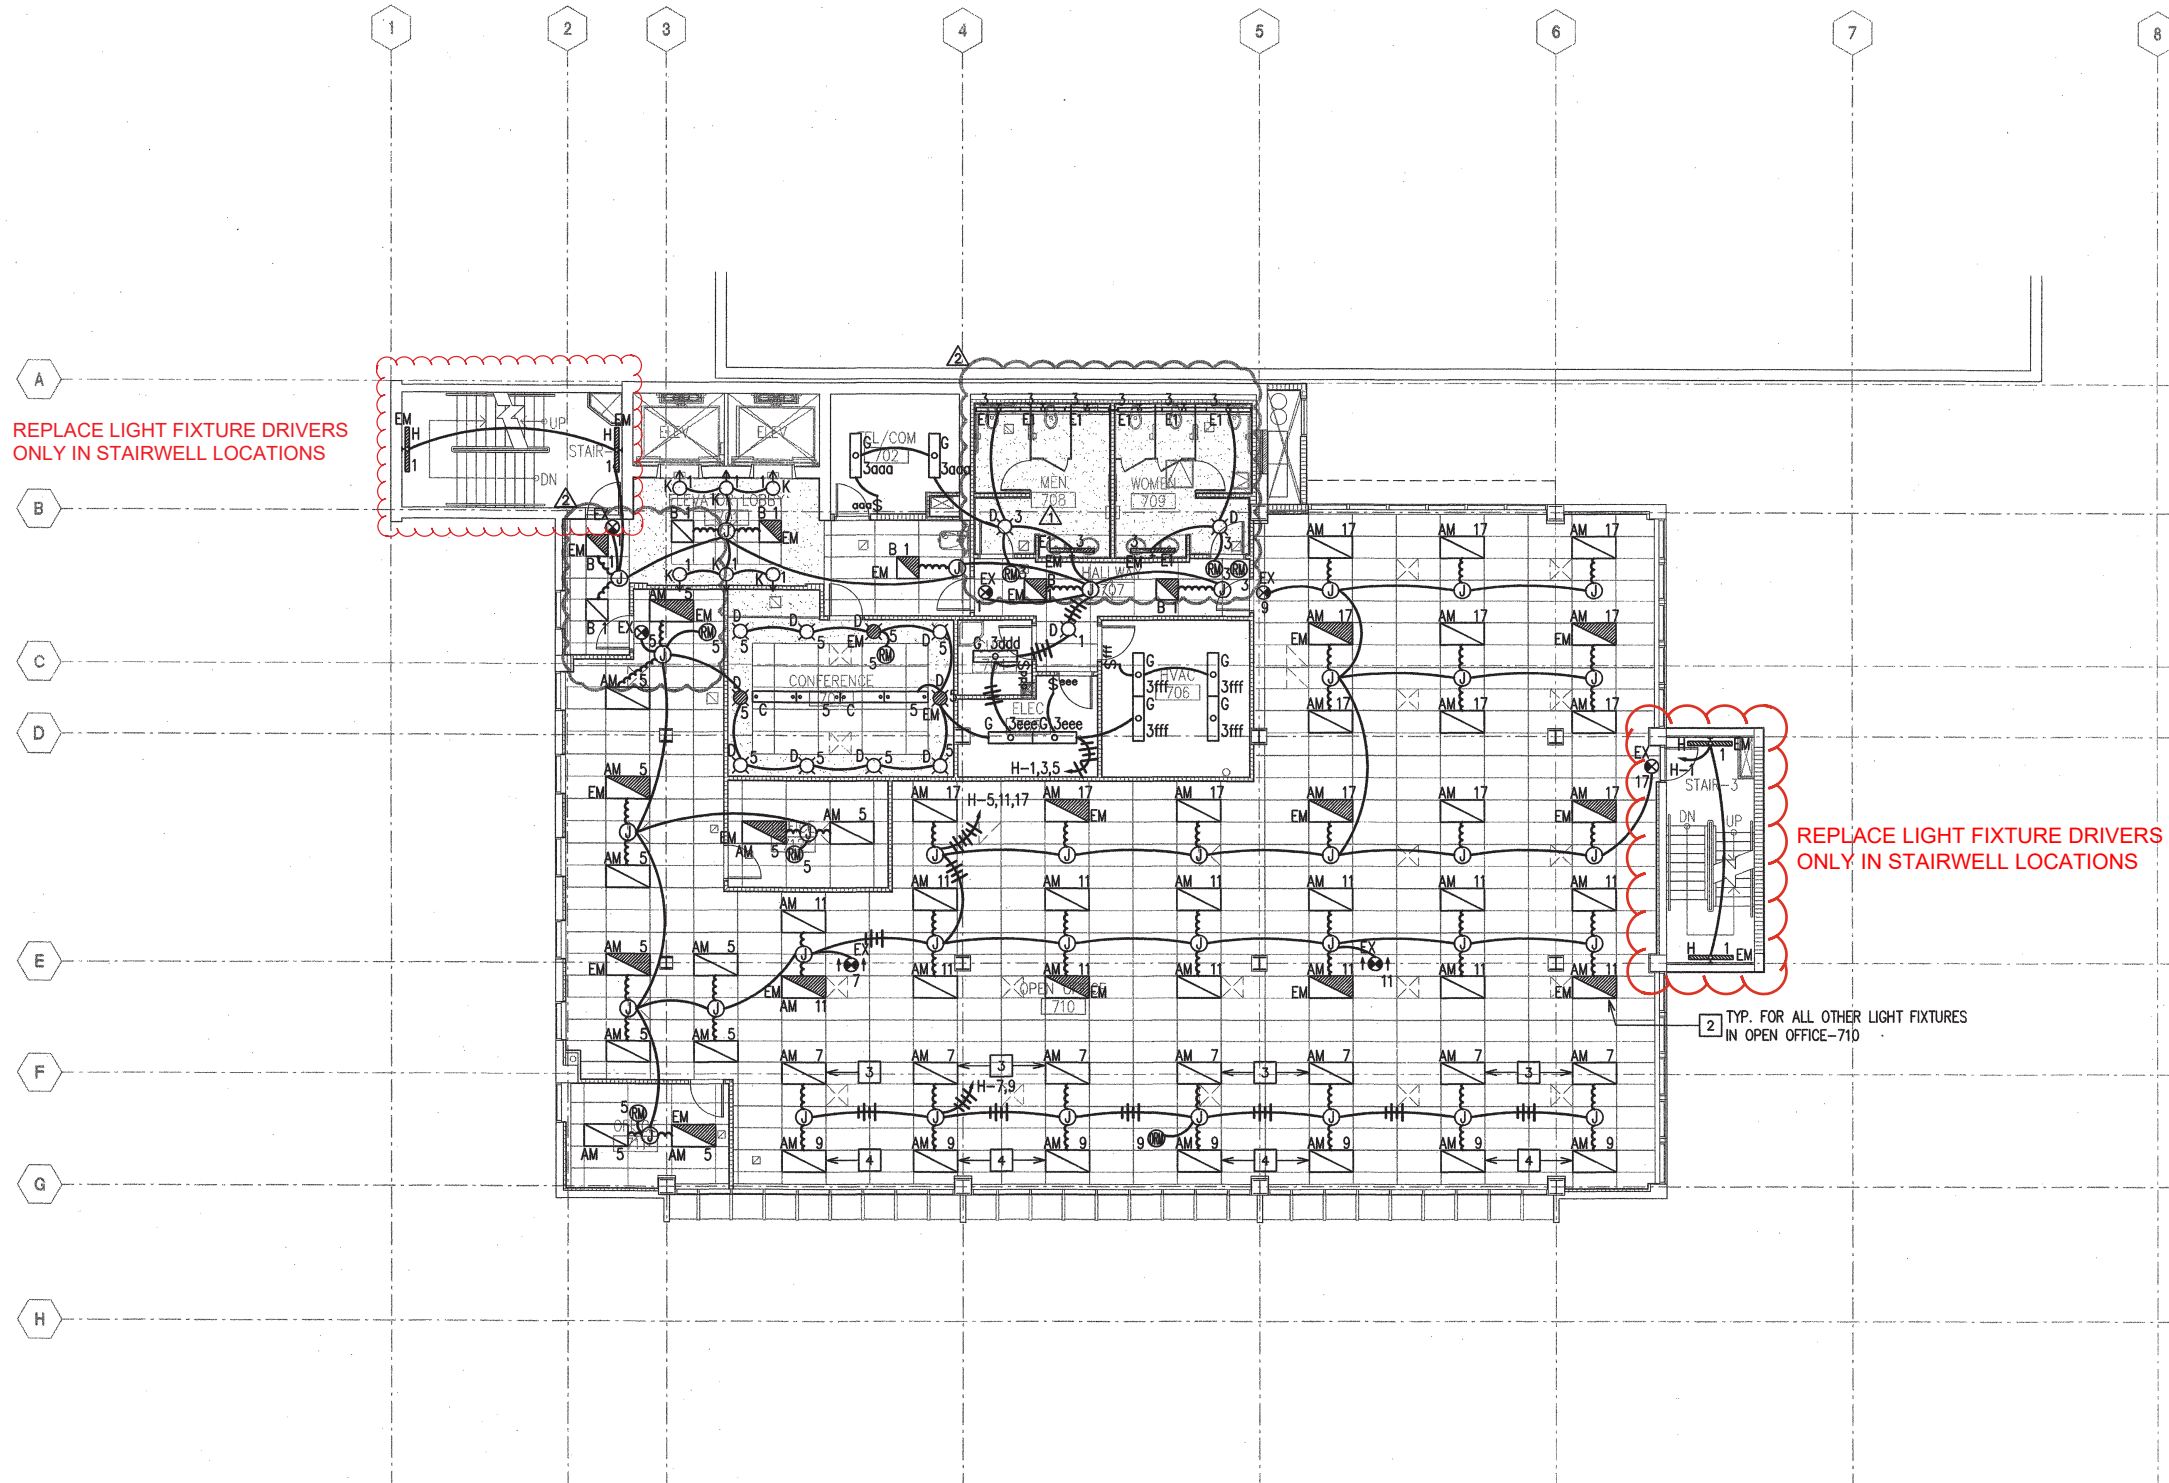


- NOTES:**
1. PROVIDE UNSWITCHED HOT TO EMERGENCY FIXTURES AND EXIT SIGNS.
 - 2 LIGHTING CONTROL ZONE 1.
 - 3 LIGHTING CONTROL ZONE 2.
 - 4 LIGHTING CONTROL ZONE 3.

SEVENTH FLOOR LIGHTING PLAN


SCALE: 1/8"=1'-0"



 E-8




GRAPHIC SCALE

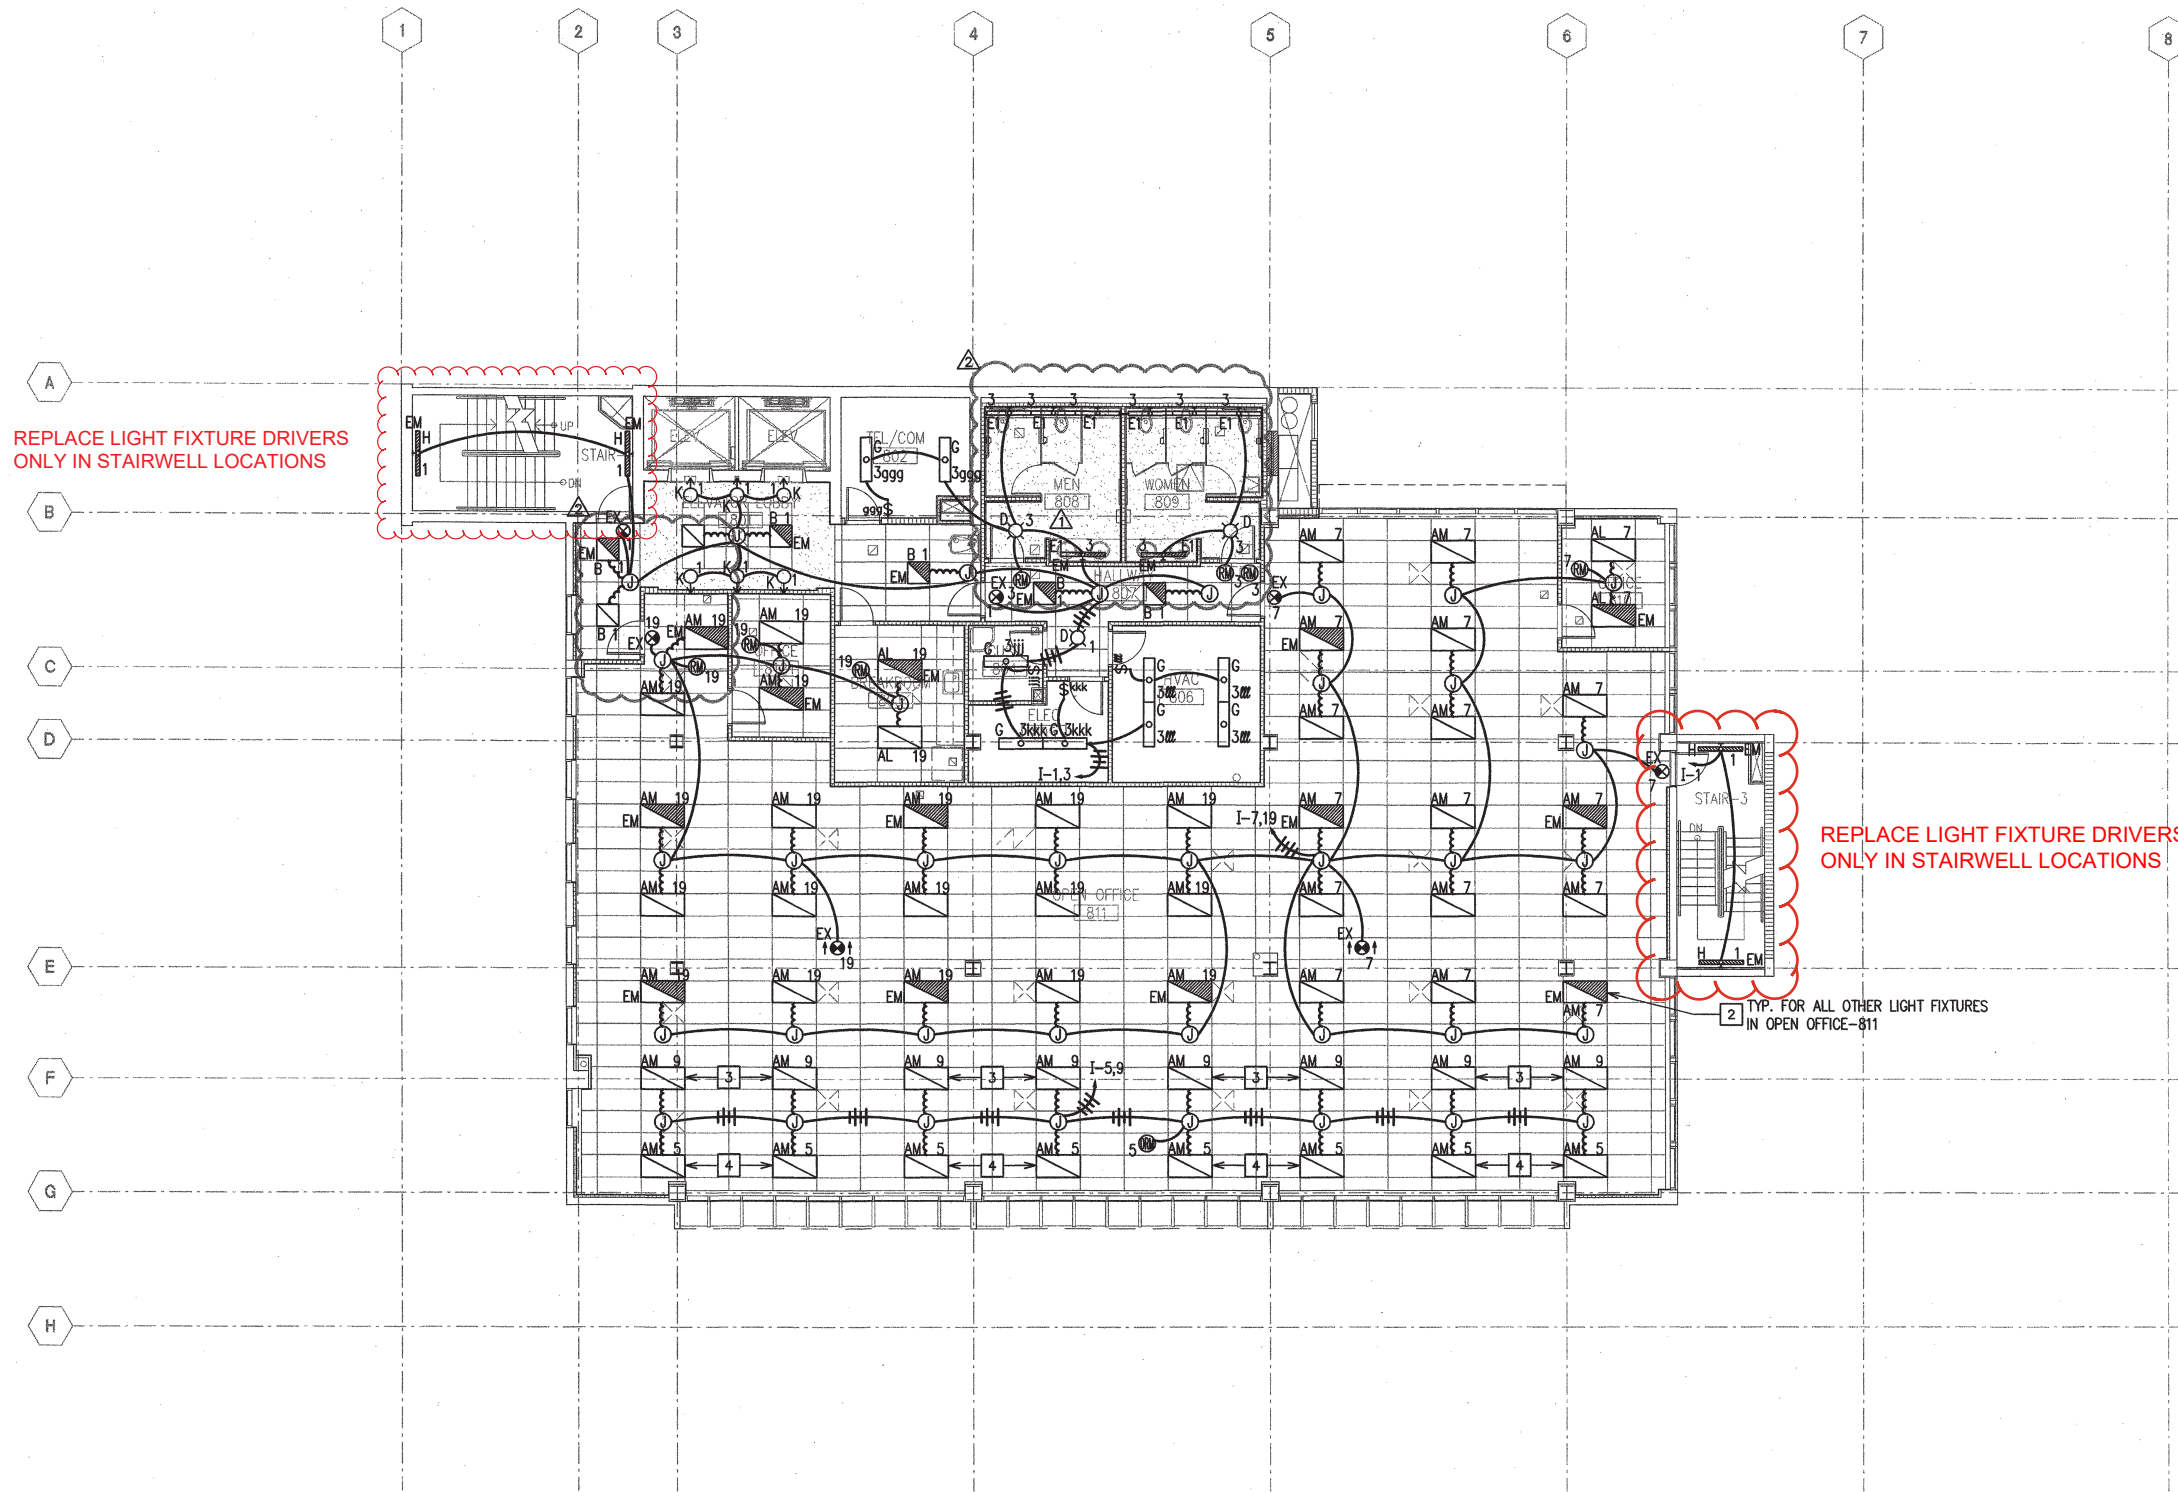


- NOTES:**
- 1. PROVIDE UNSWITCHED HOT TO EMERGENCY FIXTURES AND EXIT SIGNS.
 - 2 LIGHTING CONTROL ZONE 1.
 - 3 LIGHTING CONTROL ZONE 2.
 - 4 LIGHTING CONTROL ZONE 3.

EIGHTH FLOOR LIGHTING PLAN


SCALE: 1/8"=1'-0"

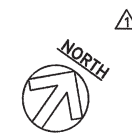

E-9

 

GRAPHIC SCALE

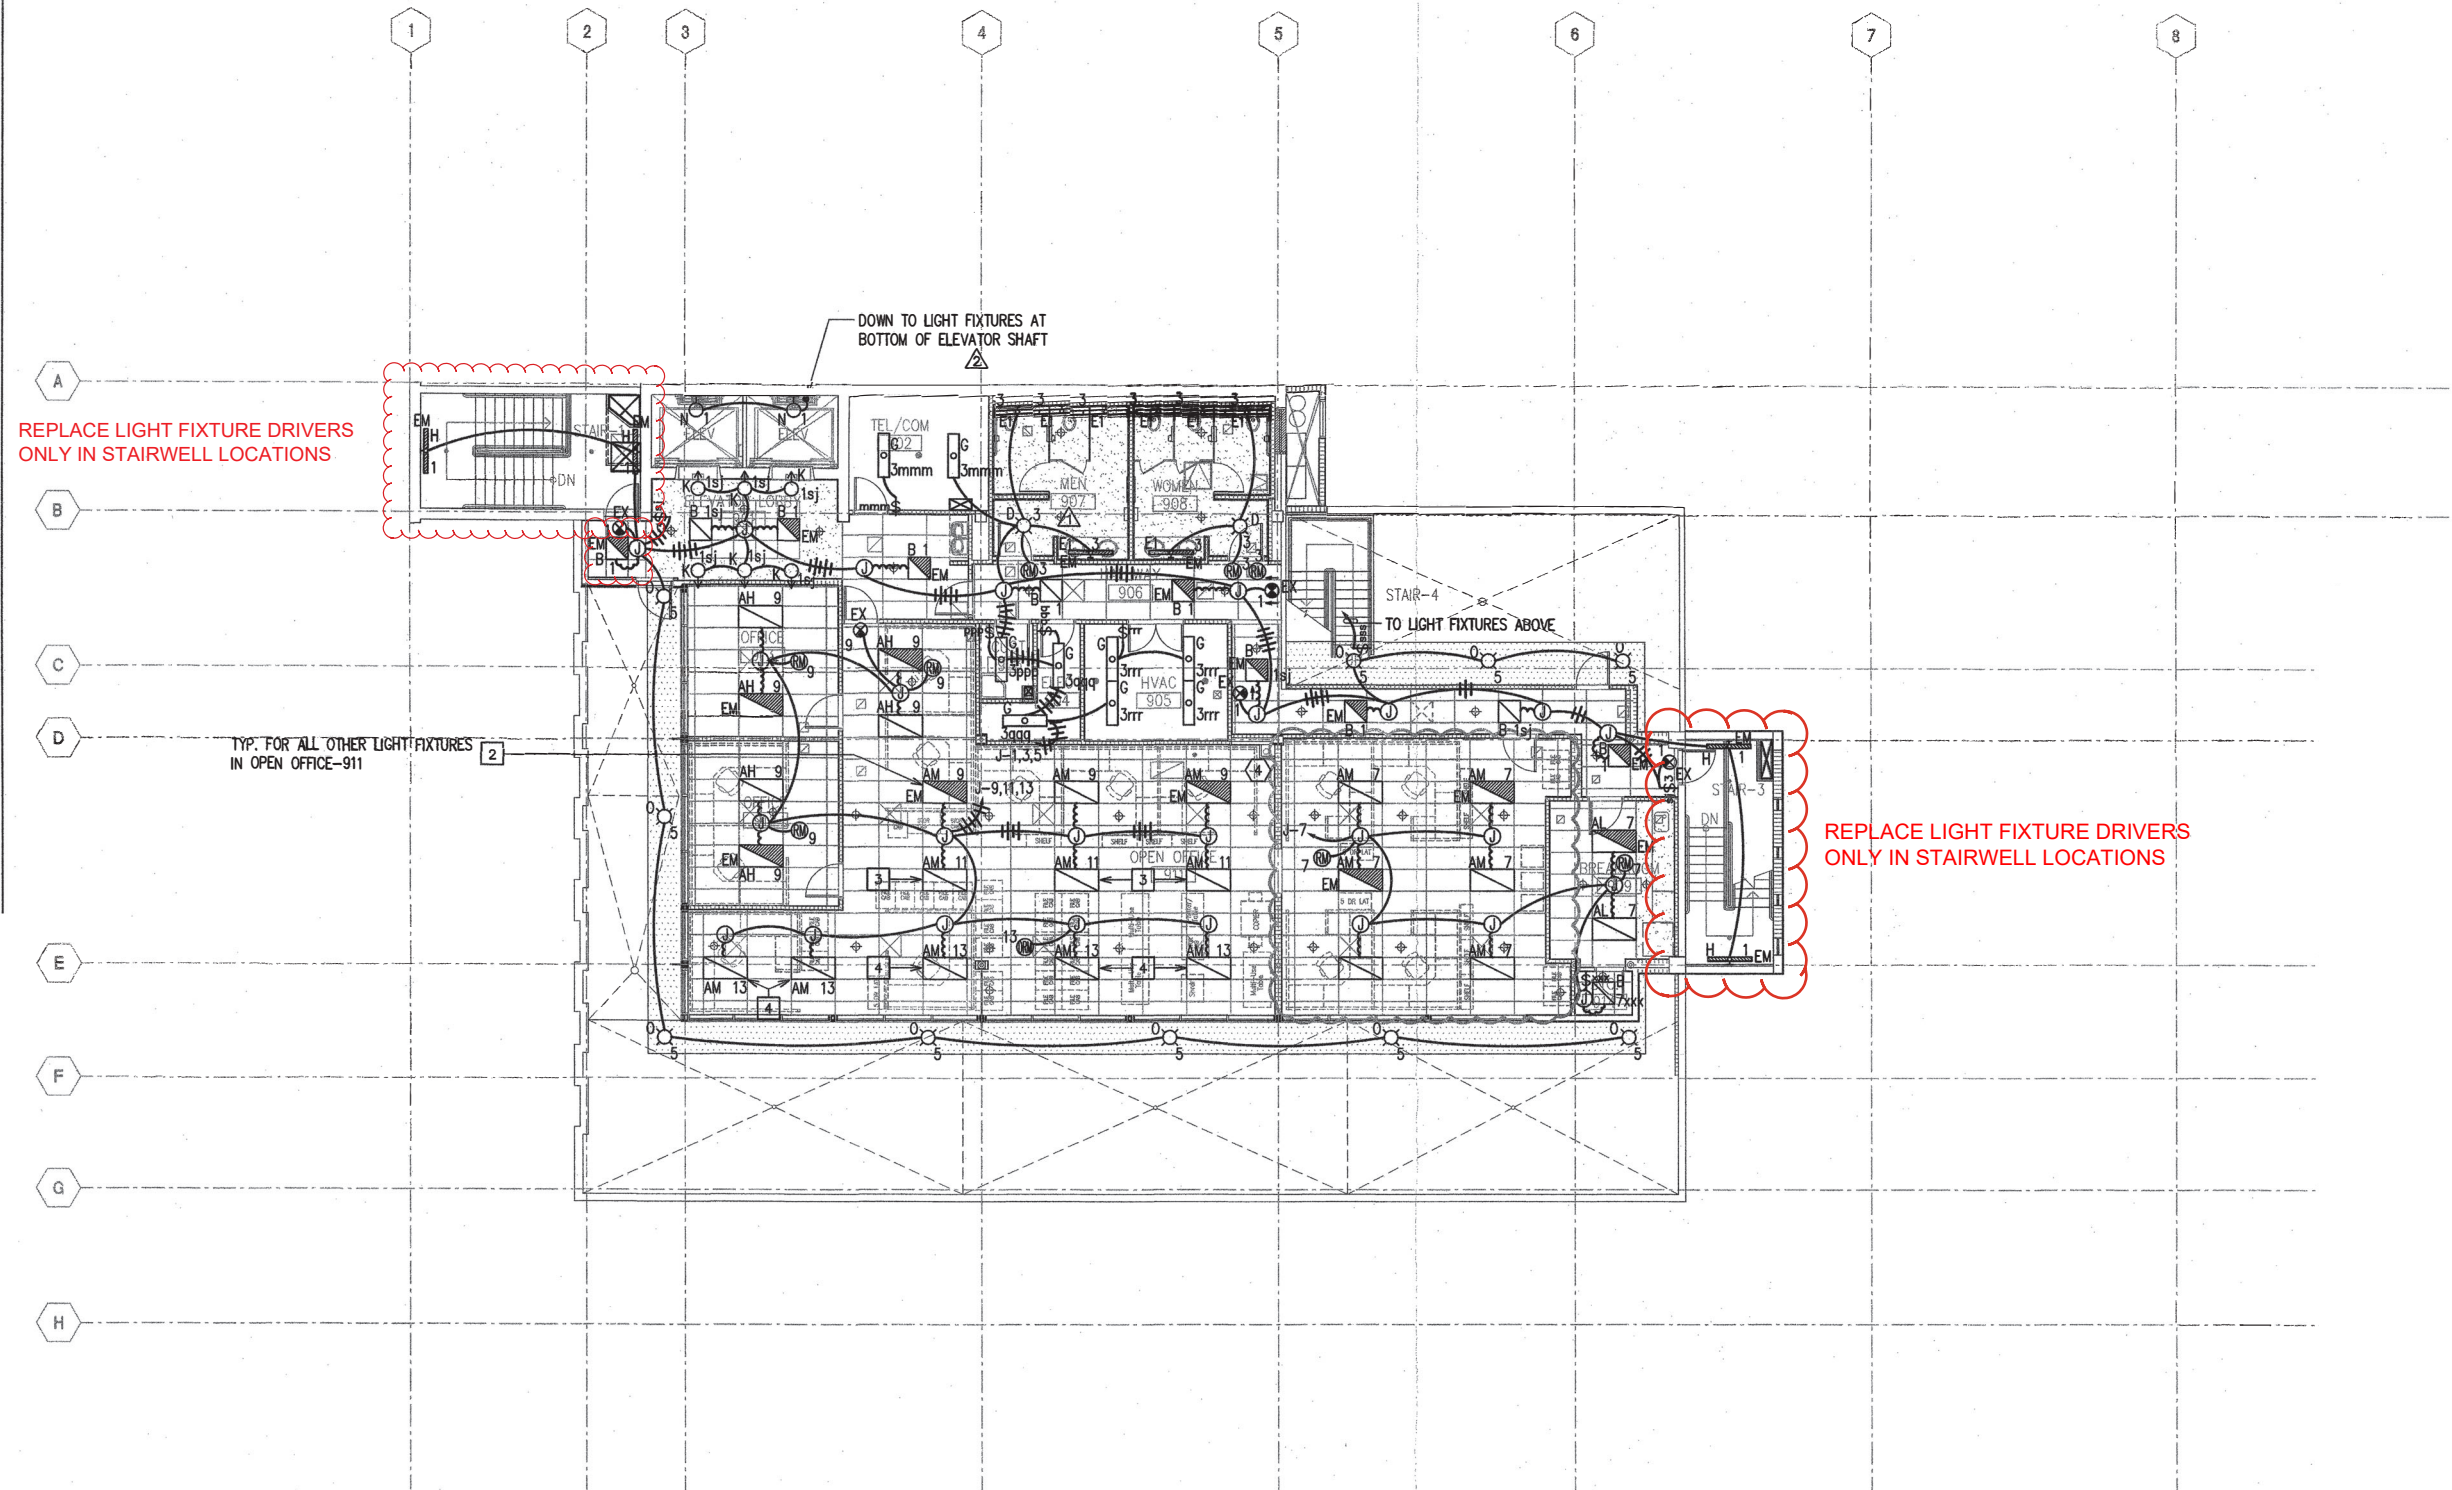

REPLACE LIGHT FIXTURE DRIVERS ONLY IN STAIRWELL LOCATIONS

REPLACE LIGHT FIXTURE DRIVERS ONLY IN STAIRWELL LOCATIONS

TYP. FOR ALL OTHER LIGHT FIXTURES IN OPEN OFFICE-911


DOWN TO LIGHT FIXTURES AT BOTTOM OF ELEVATOR SHAFT

LIGHT FIXTURES TO BE REPLACED


NOTES:

- 1. PROVIDE UNSWITCHED HOT TO EMERGENCY FIXTURES AND EXIT SIGNS.
- 2. LIGHTING CONTROL ZONE 1.
- 3. LIGHTING CONTROL ZONE 2.
- 4. LIGHTING CONTROL ZONE 3.

NINTH FLOOR LIGHTING PLAN
SCALE: 1/8"=1'-0"

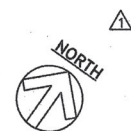

E-10

 

GRAPHIC SCALE