


FOR ALL WORK DONE IN THIS FACILITY, CONTRACTOR SHALL HIRE AT LEAST ONE STATE SHERIFF AS AN ESCORT FOR WORKERS IN EACH AREA WHERE CONTRACTOR'S PERSONNEL ARE PRESENT. THIS IS DUE TO THE NATURE OF THE FACILITY AS A SENSITIVE RECORDS STORAGE AREA AND IS DONE TO ENSURE THE SECURITY AND CONFIDENTIALITY OF RECORDS AND ITEMS STORED. ALL COSTS FOR THE SHERIFF ESCORT SHALL BE SOLELY AT THE EXPENSE OF THE CONTRACTOR. THE STATE SHERIFF ESCORT SHALL BE PRESENT AT ALL TIMES CONTRACTOR PERSONNEL ARE PRESENT IN THE FACILITY DURING CONTRACT EXECUTION.


ALL STORAGE SHELVES SHALL REMAIN IN THEIR ORIGINAL LOCATIONS DURING WORK. PROVIDE PROTECTIVE BARRIERS, COVERINGS, TARPS OR OTHER PROTECTION TO PREVENT DAMAGE TO SHELVES AND RECORDS DURING LIGHTING REPLACEMENT WORK.

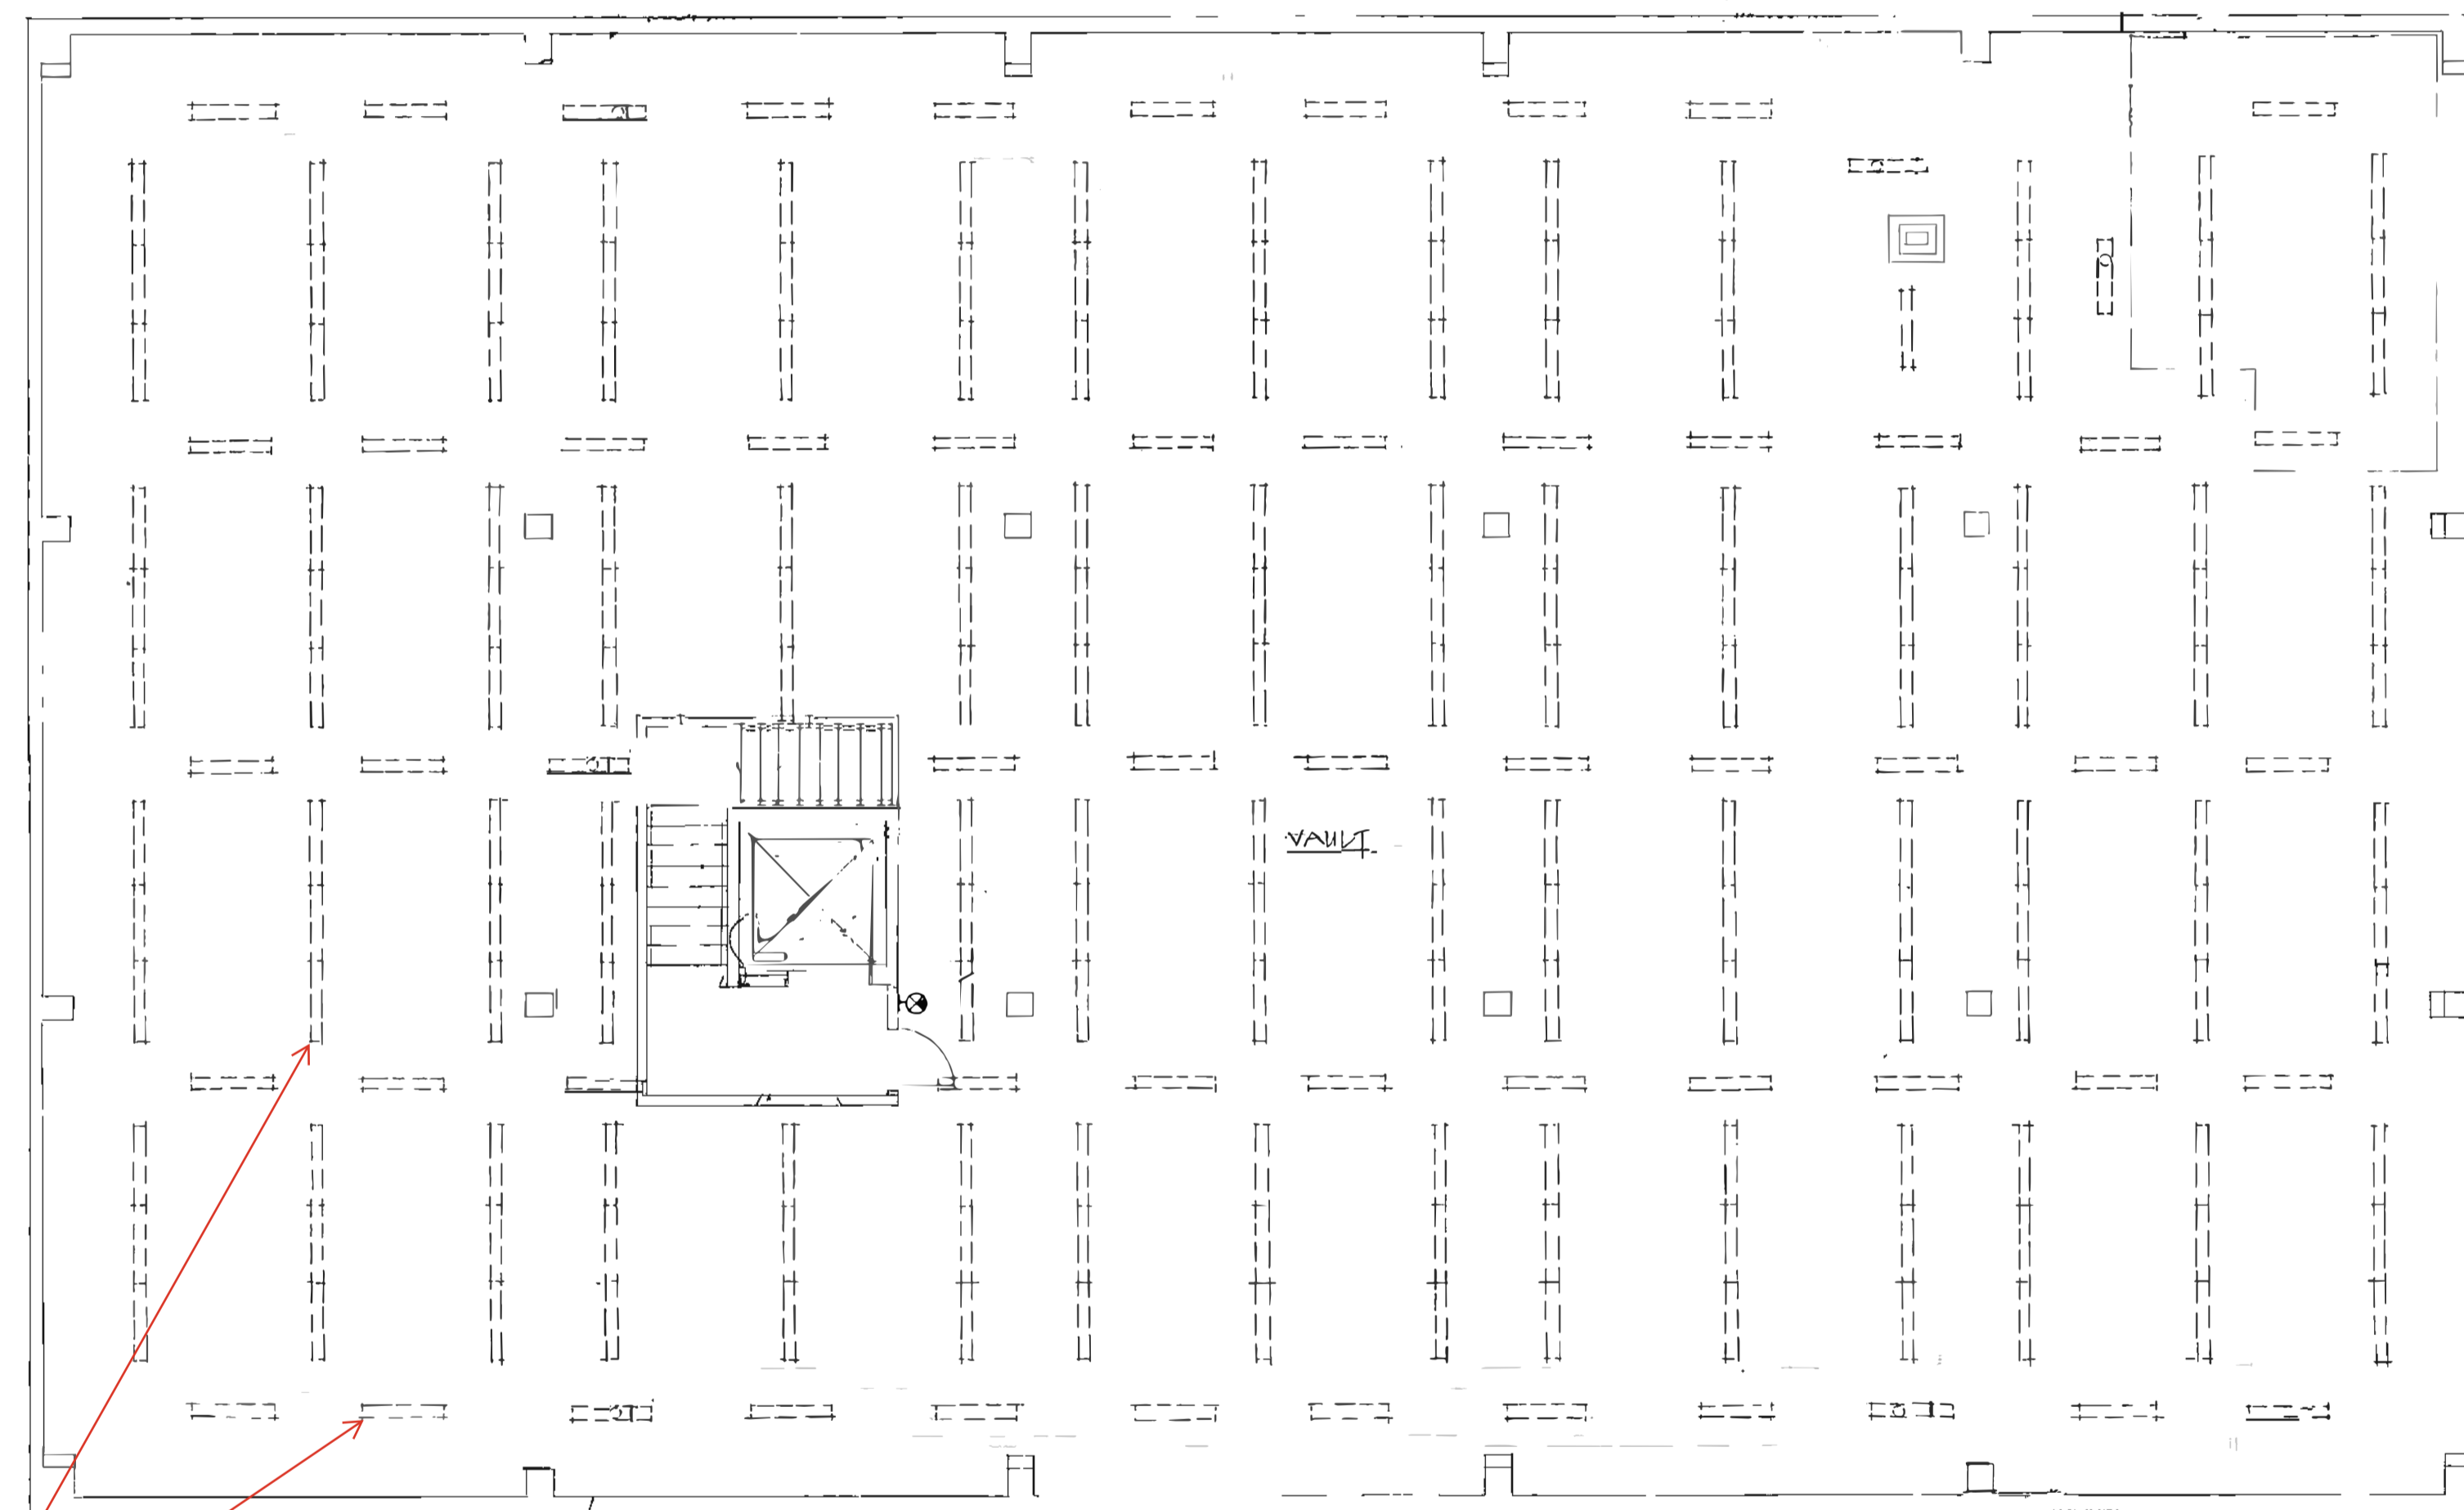


1 SECOND FLOOR ELECTRICAL PLAN
SCALE: 1/8" = 1'-0"

EXISTING 4' PENDANT MOUNTED LIGHT FIXTURE (TYPICAL FOR 233 EACH LIGHT FIXTURES SHOWN) - PROVIDE NEW FIXTURE "A" LIGHT FIXTURE IN SAME LOCATIONS. SURFACE MOUNT TO CEILING, UTILIZE SAME/ EXISTING CIRCUITING. EXTEND WIRING IN EXPOSED EMT AS NECESSARY. PAINT ANY NEW CONDUIT TO MATCH CEILING COLOR. REMOVE EXISTING PULL STRINGS AND ASSOCIATED SWITCHES. PROVIDE NEW OCCUPANCY SENSORS FOR EACH CIRCUIT TO TURN OFF LIGHTS AFTER 30 MINUTES WHEN SPACE IS NOT OCCUPIED. OCCUPANCY SENSORS MAY BE PROVIDED INTEGRAL TO THE NEW LIGHT FIXTURES.

E-1

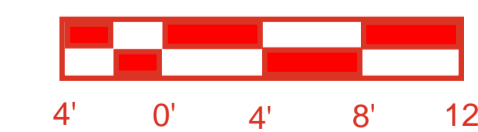

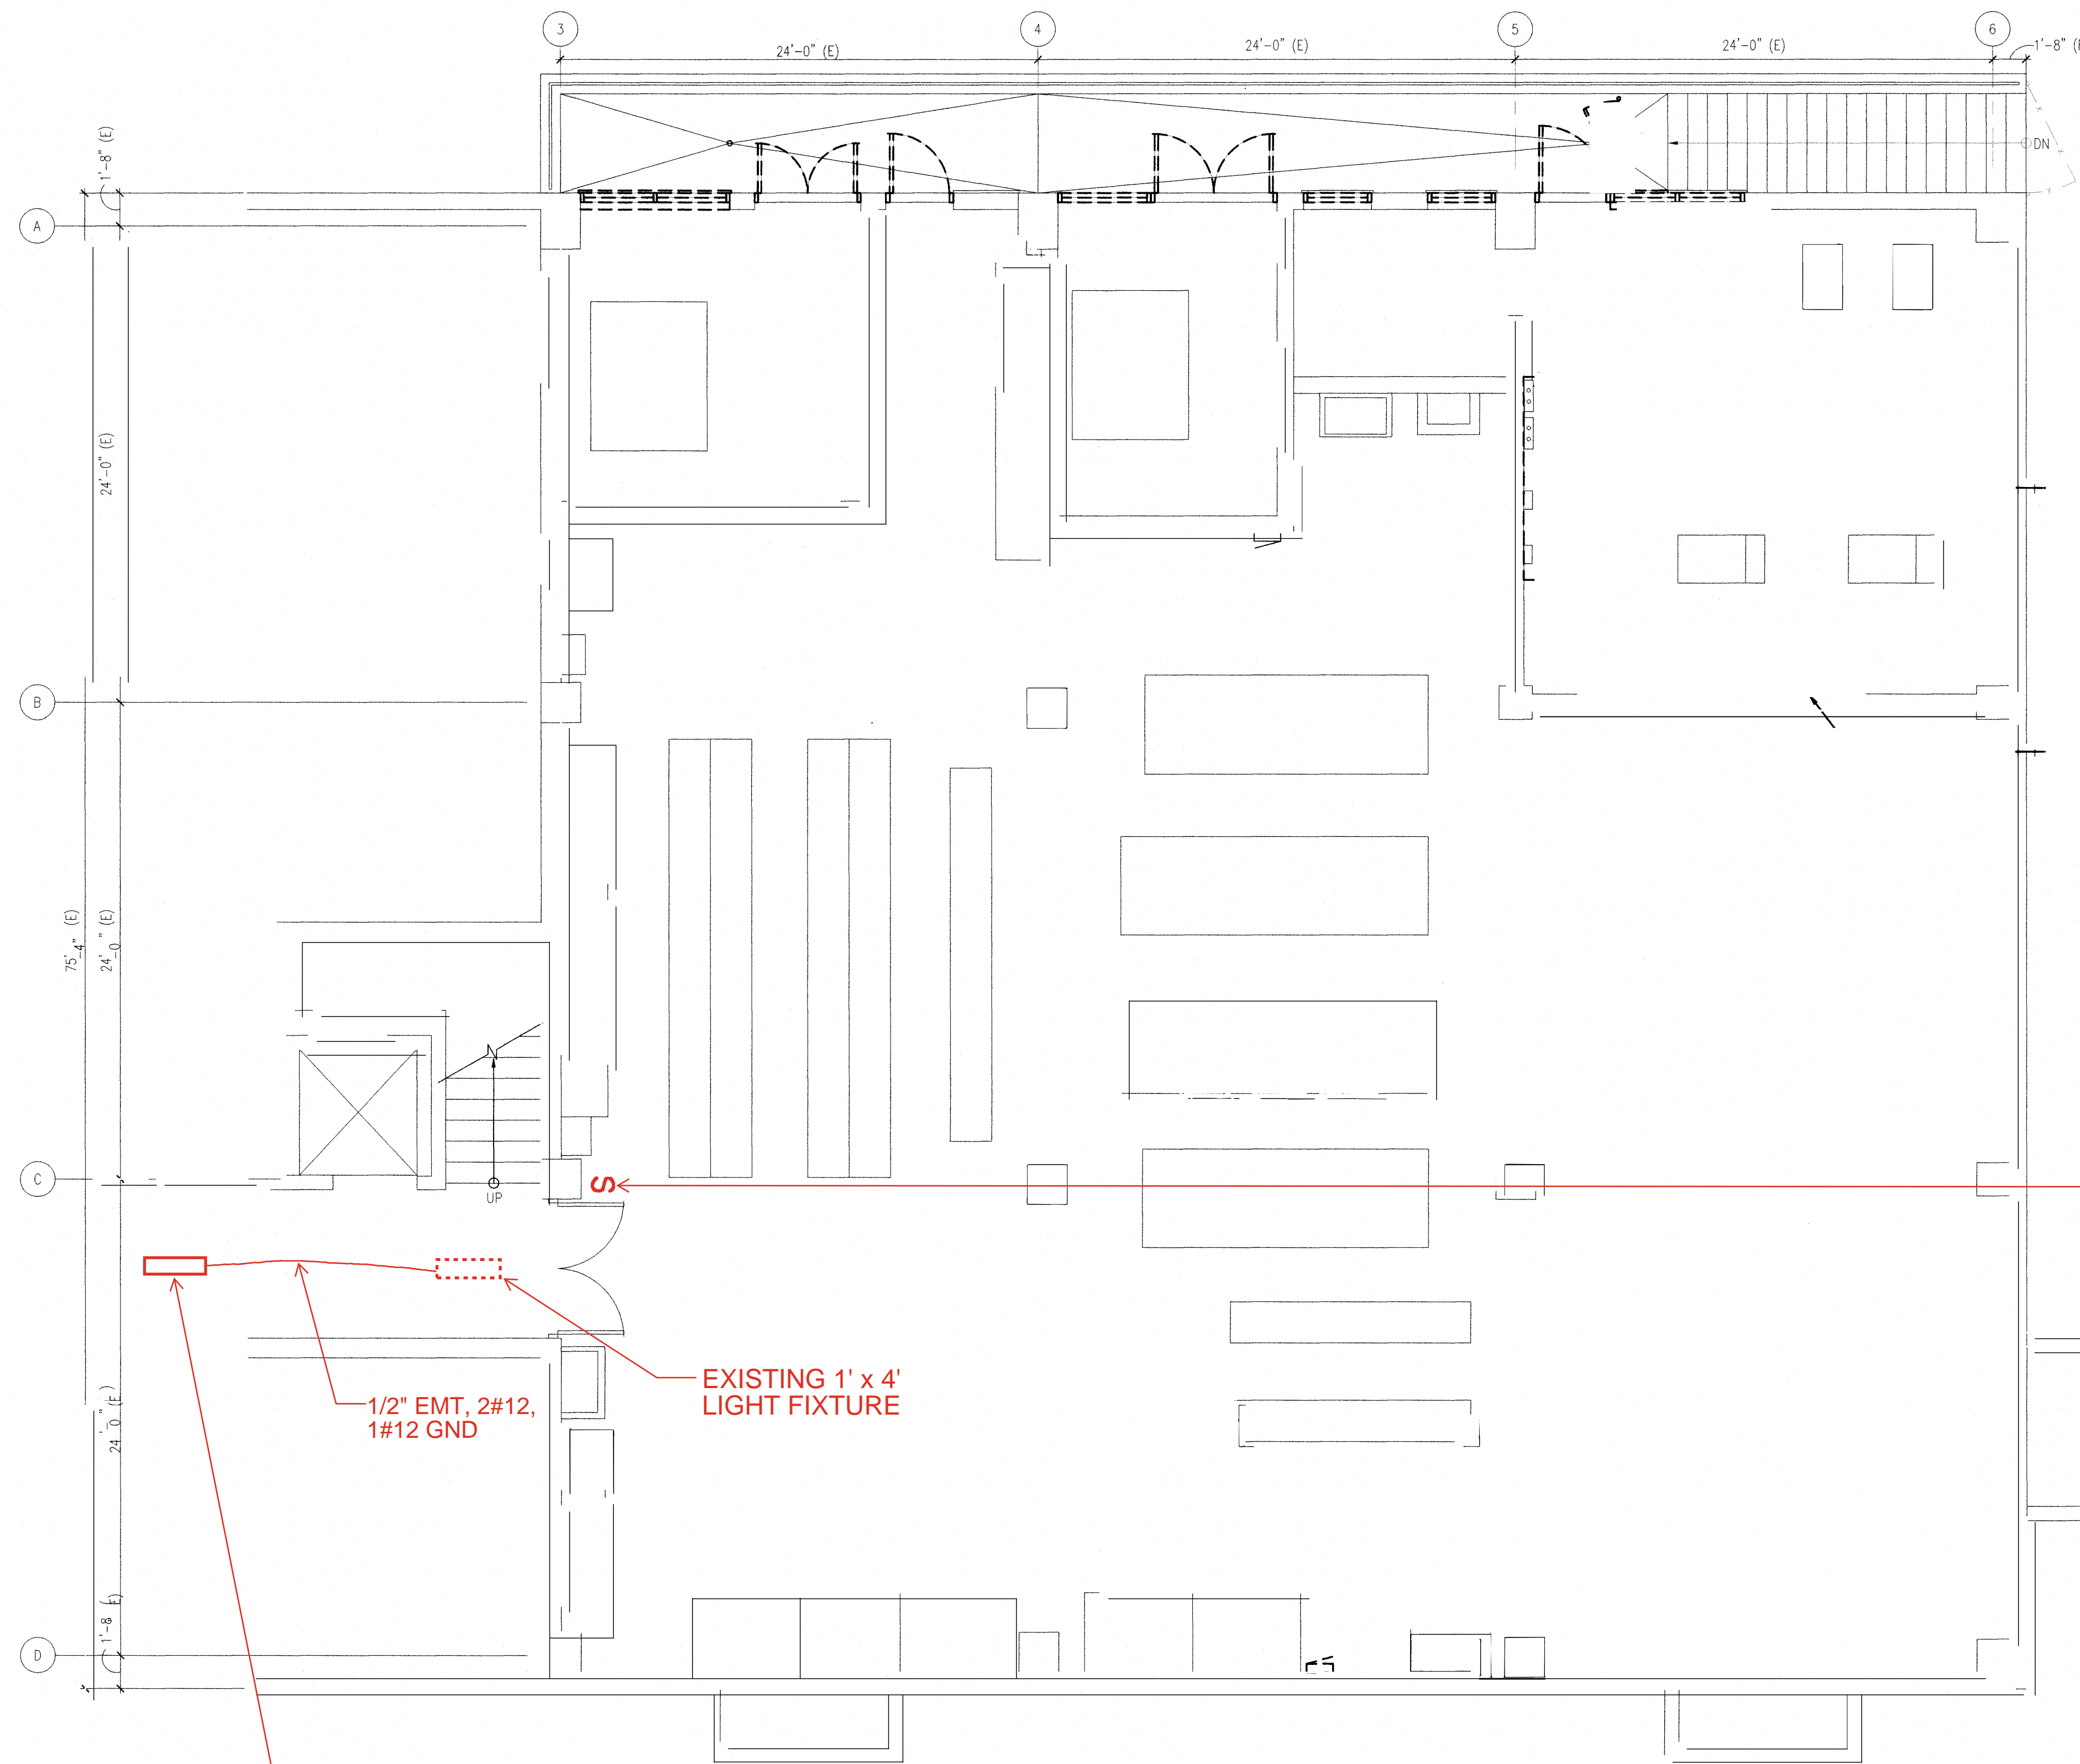

EXISTING LIGHTING SWITCH BANK (5 EA SWITCHES).
 PROVIDE OCCUPANCY SENSORS FOR EACH SWITCHED
 CIRCUIT TO POWER OFF LIGHTING AFTER 30 MINUTES
 OF SENSING MOTION .


OCCUPANCY SENSOR TO SENSE MOTION AT DOUBLE
 DOOR ENTRY FROM ELEVATOR/STAIRS LANDING.

EXISTING 1' x 4'
 LIGHT FIXTURE


1/2" EMT, 2#12,
 1#12 GND


PROVIDE NEW TYPE "B" SURFACE MOUNTED LIGHT
 FIXTURE TO CEILING IN DARK AREA. EXTEND CIRCUITING
 FROM EXISTING 1' x 4' LIGHT FIXTURE WITH 1/2" EMT, 2#12,
 1#12 GND IN EXPOSED EMT. PAINT EMT TO MATCH
 CEILING COLOR. FIXTURE SHALL HAVE EMERGENCY
 BATTERY BACKUP UNIT INCLUDED.

BASEMENT - ELECTRICAL PLAN
 SCALE: 3/16" = 1'-0"

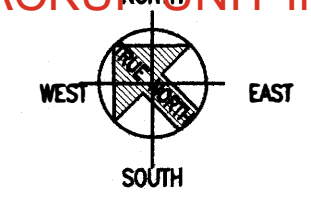

E-2

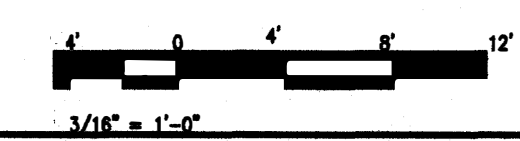

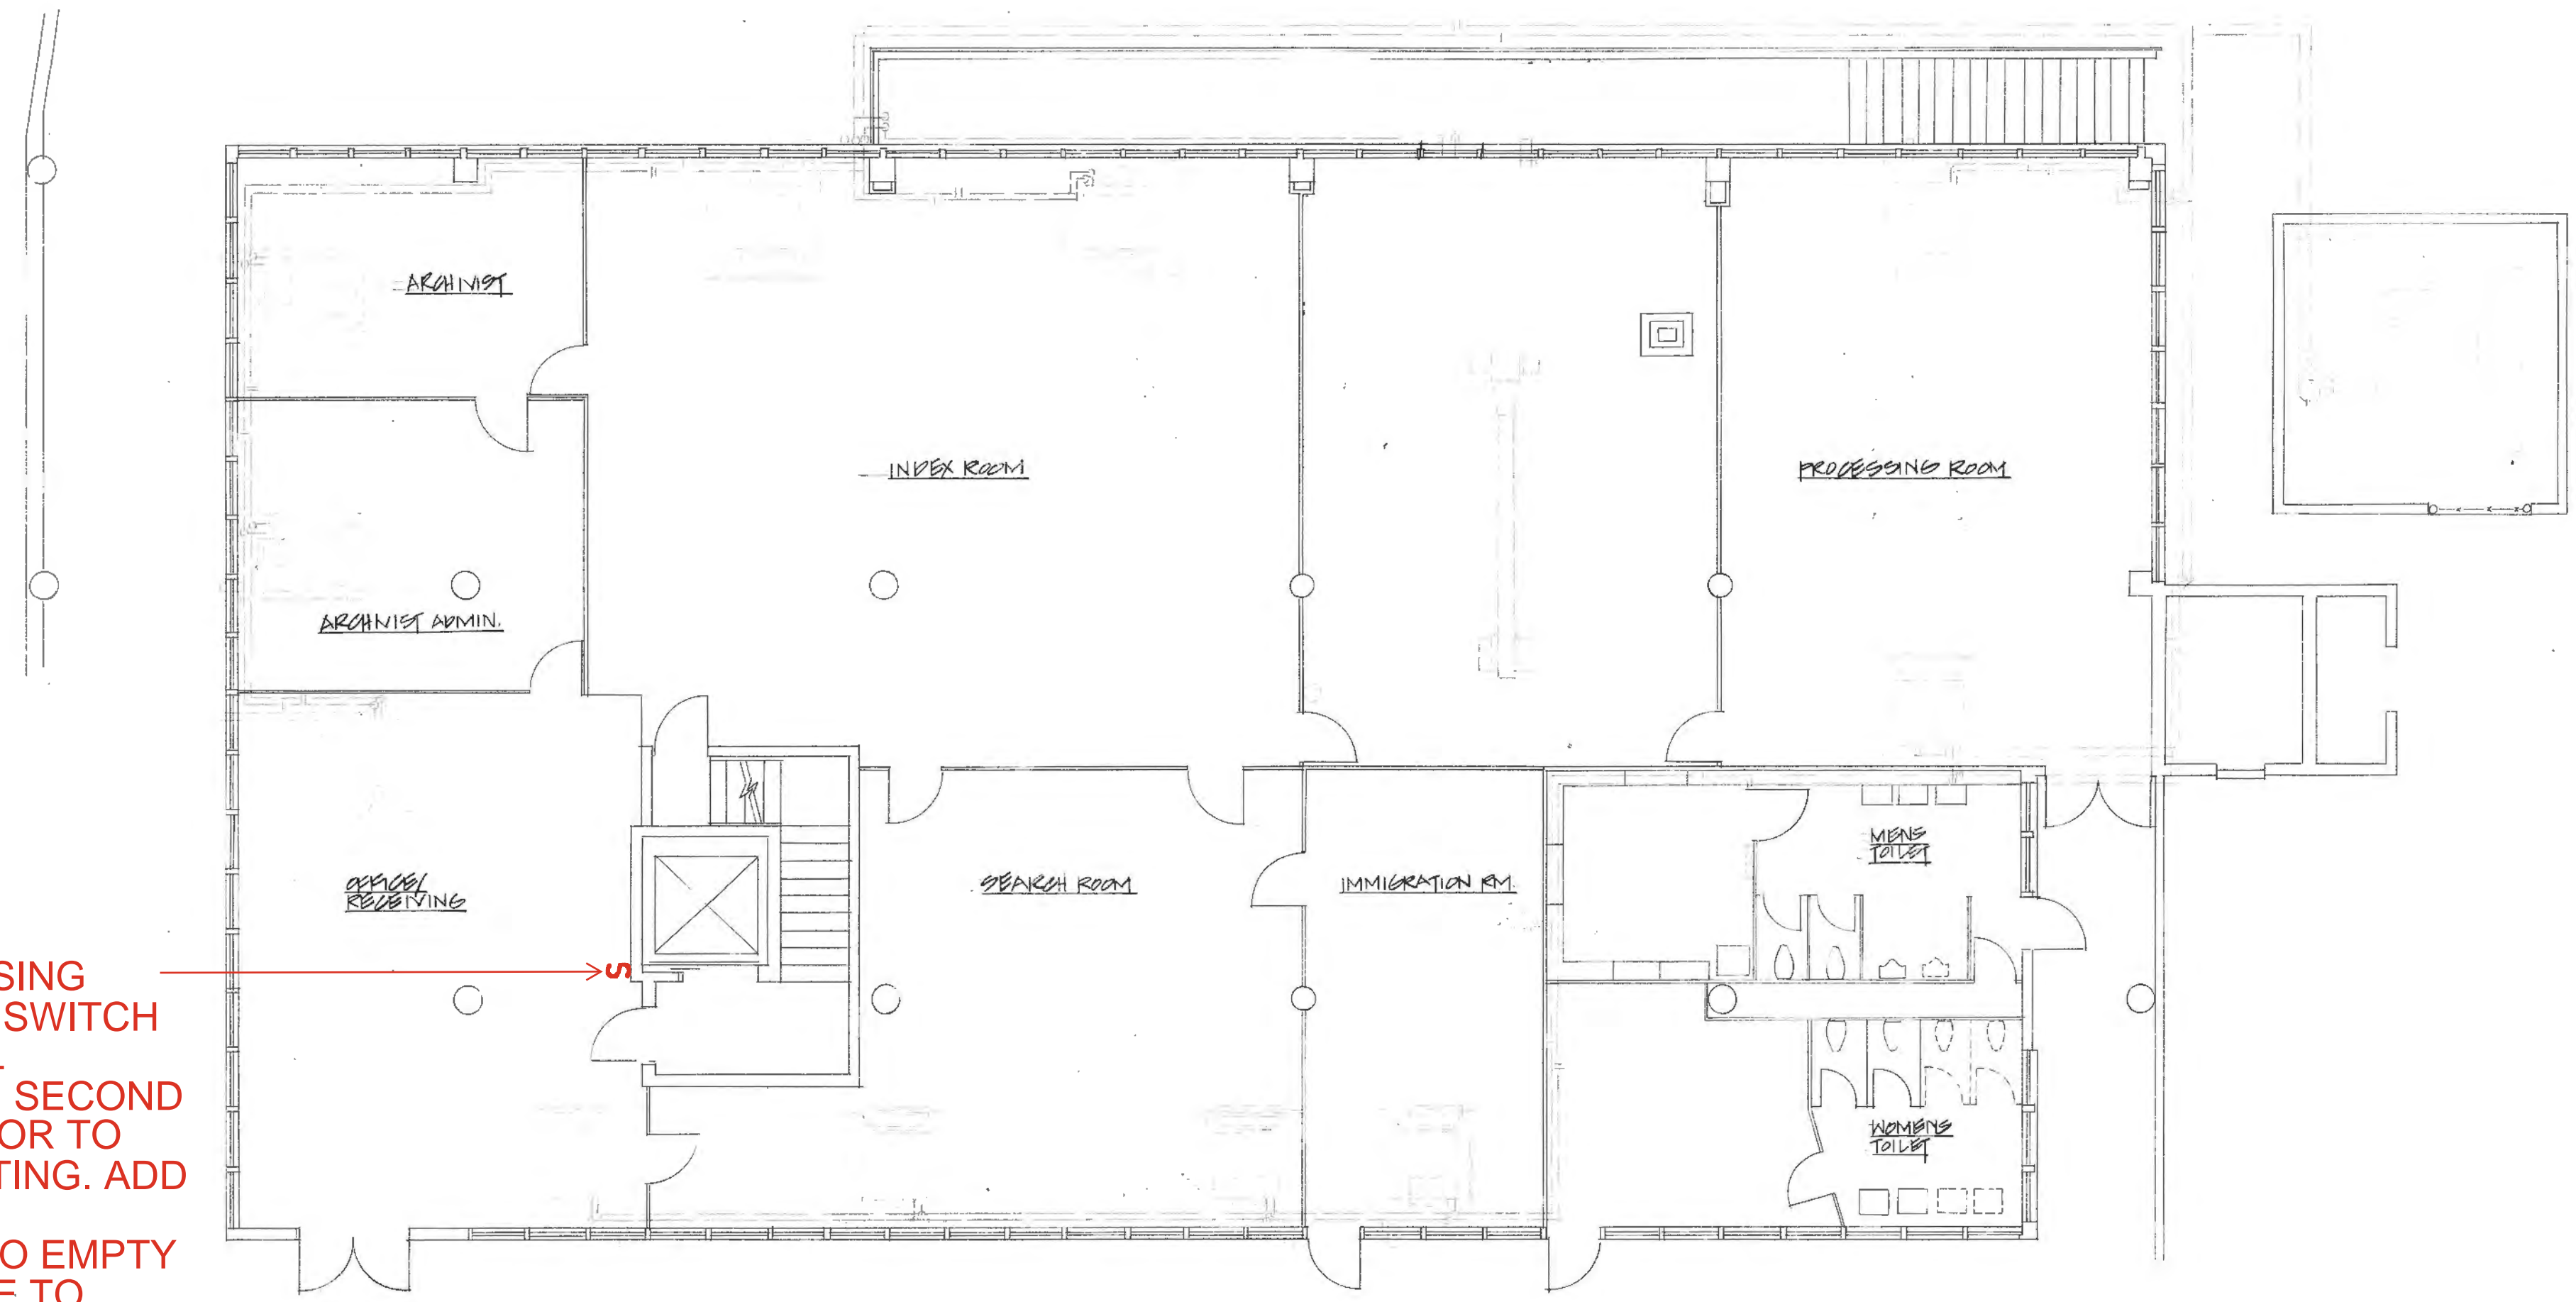

REPACE MISSING
1P LIGHTING SWITCH
TO CONTROL
LIGHTING ON SECOND
FLOOR. COLOR TO
MATCH EXISTING. ADD
PILOT LIGHT
INDICATOR TO EMPTY
GANG SPACE TO
INDICATE POWER IS
SWITCHED "ON".

1 FIRST FLOOR ELECTRICAL PLAN -
E-3 SCALE: 1/8" = 1'-0"