

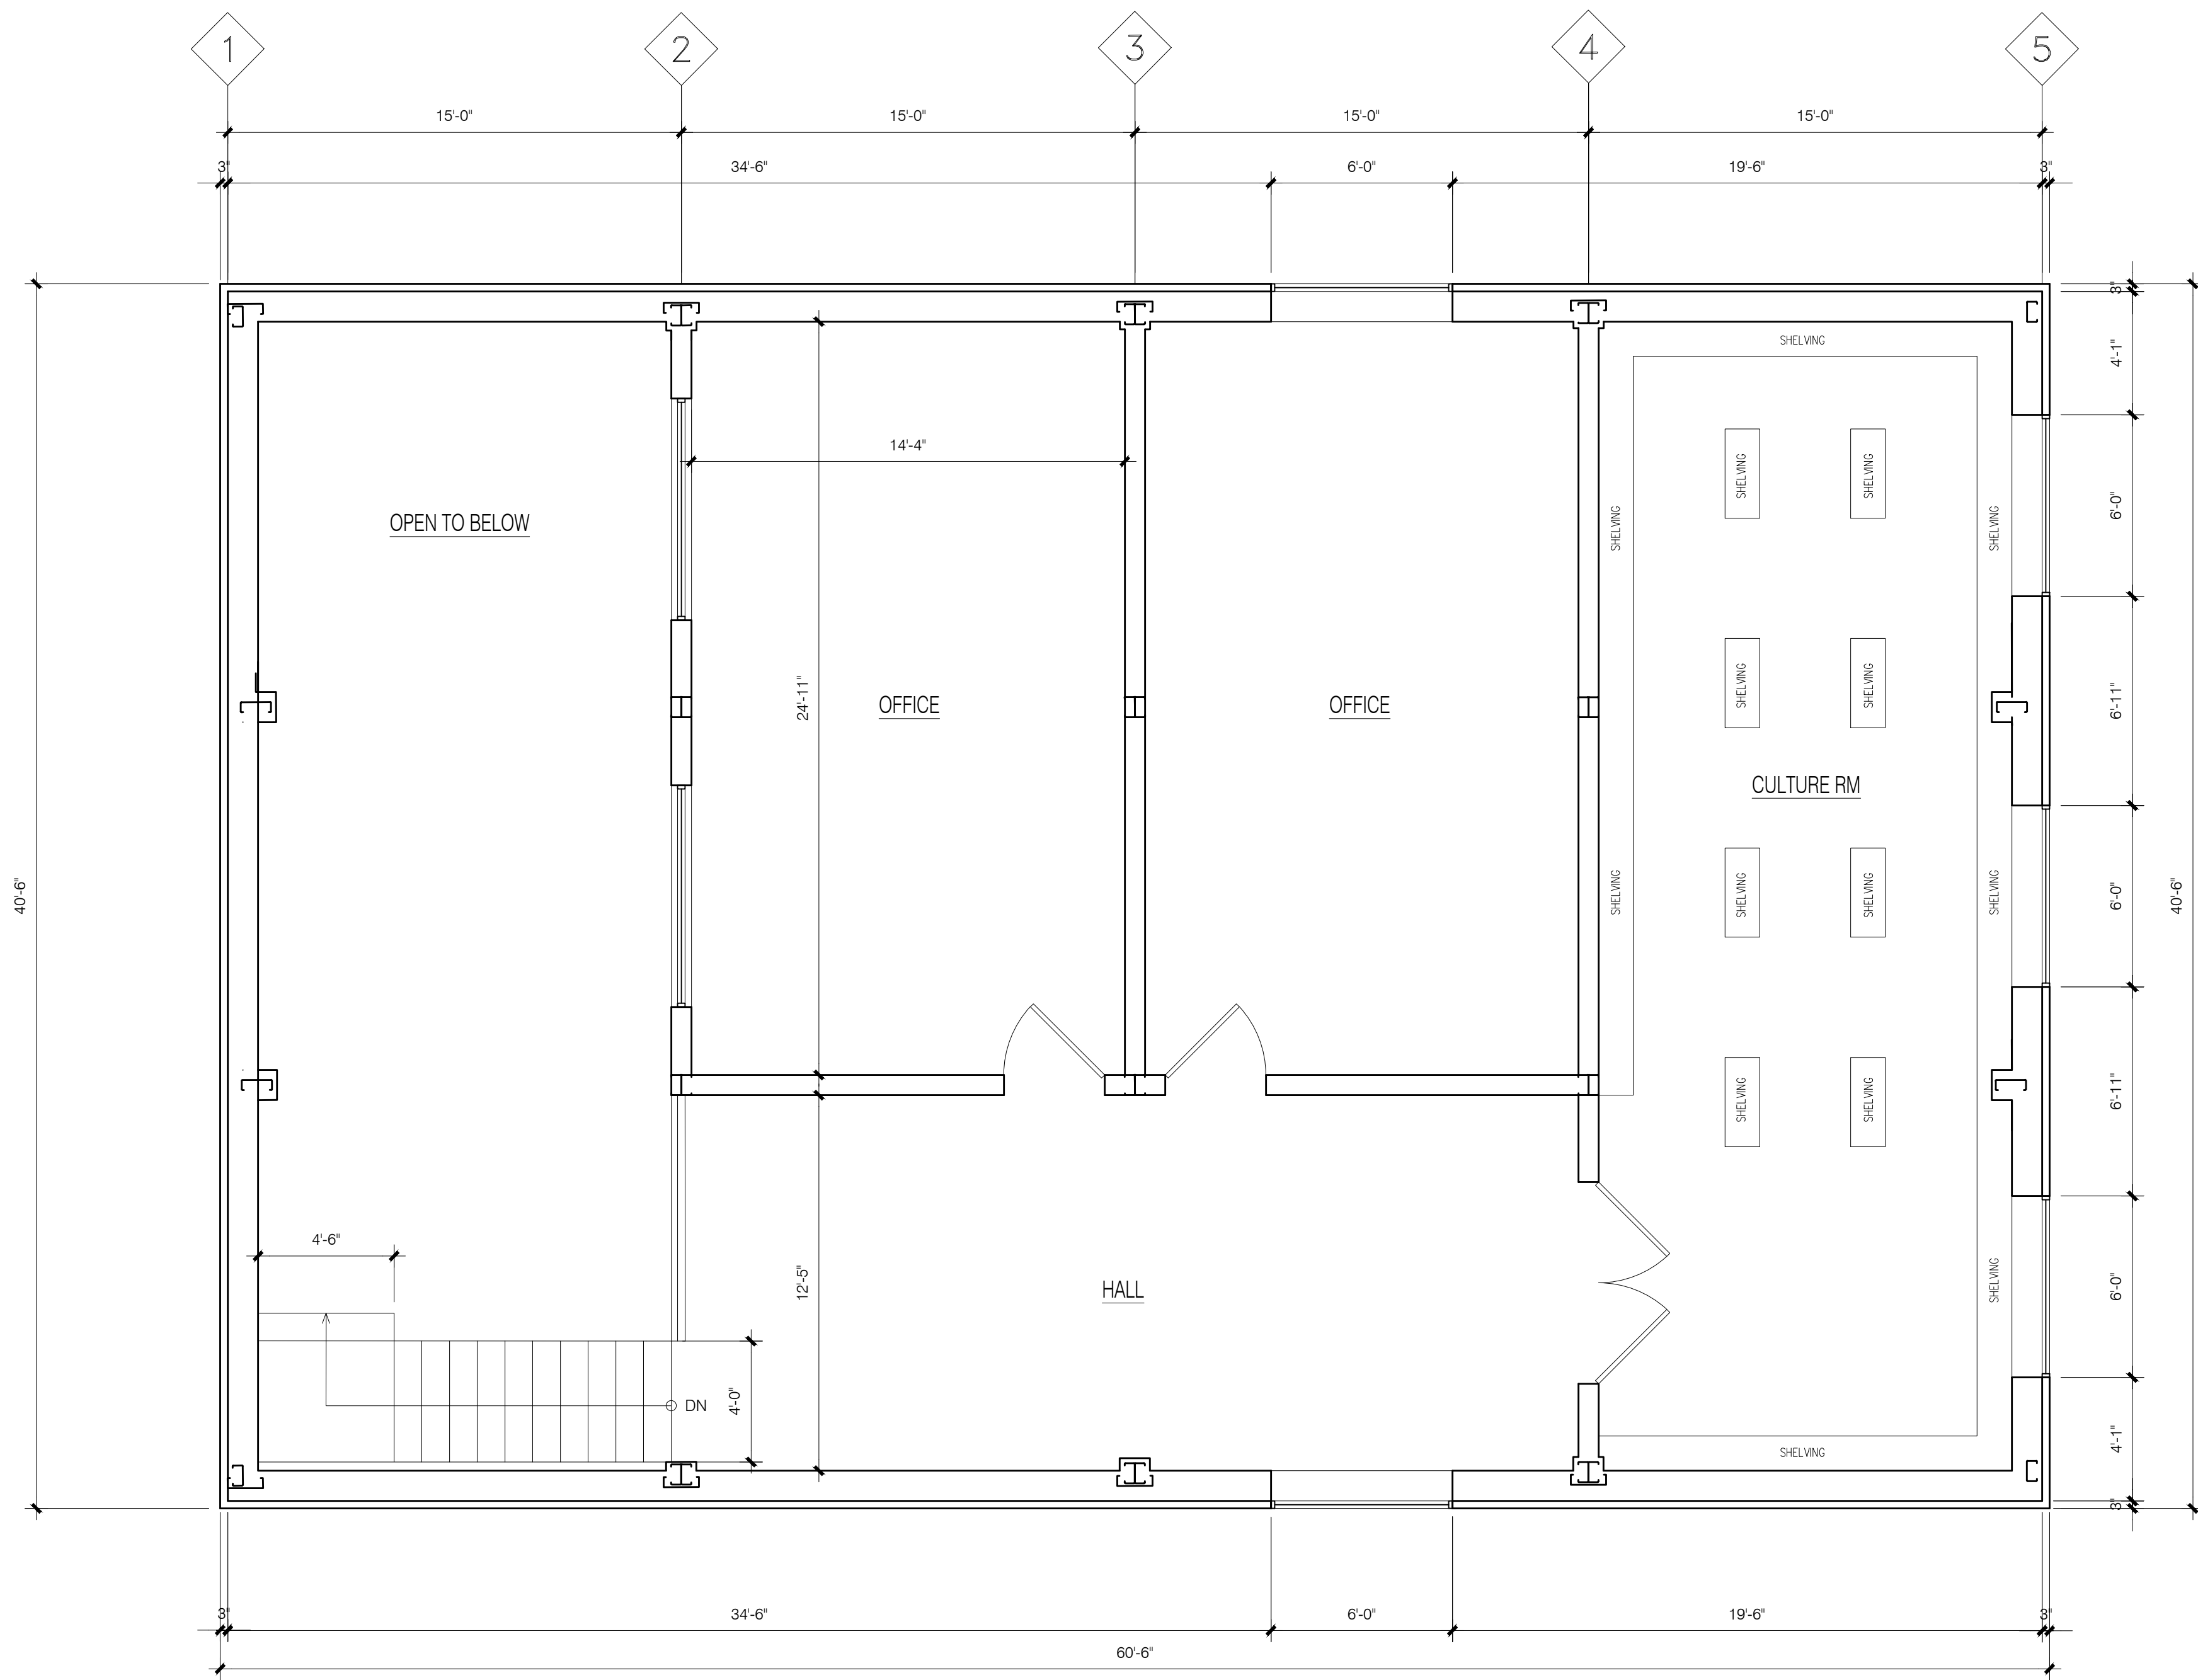


1
A1 OLINDA LABORATORY - MAIN FLOOR PLAN
SCALE: 1/4" = 1'-0"


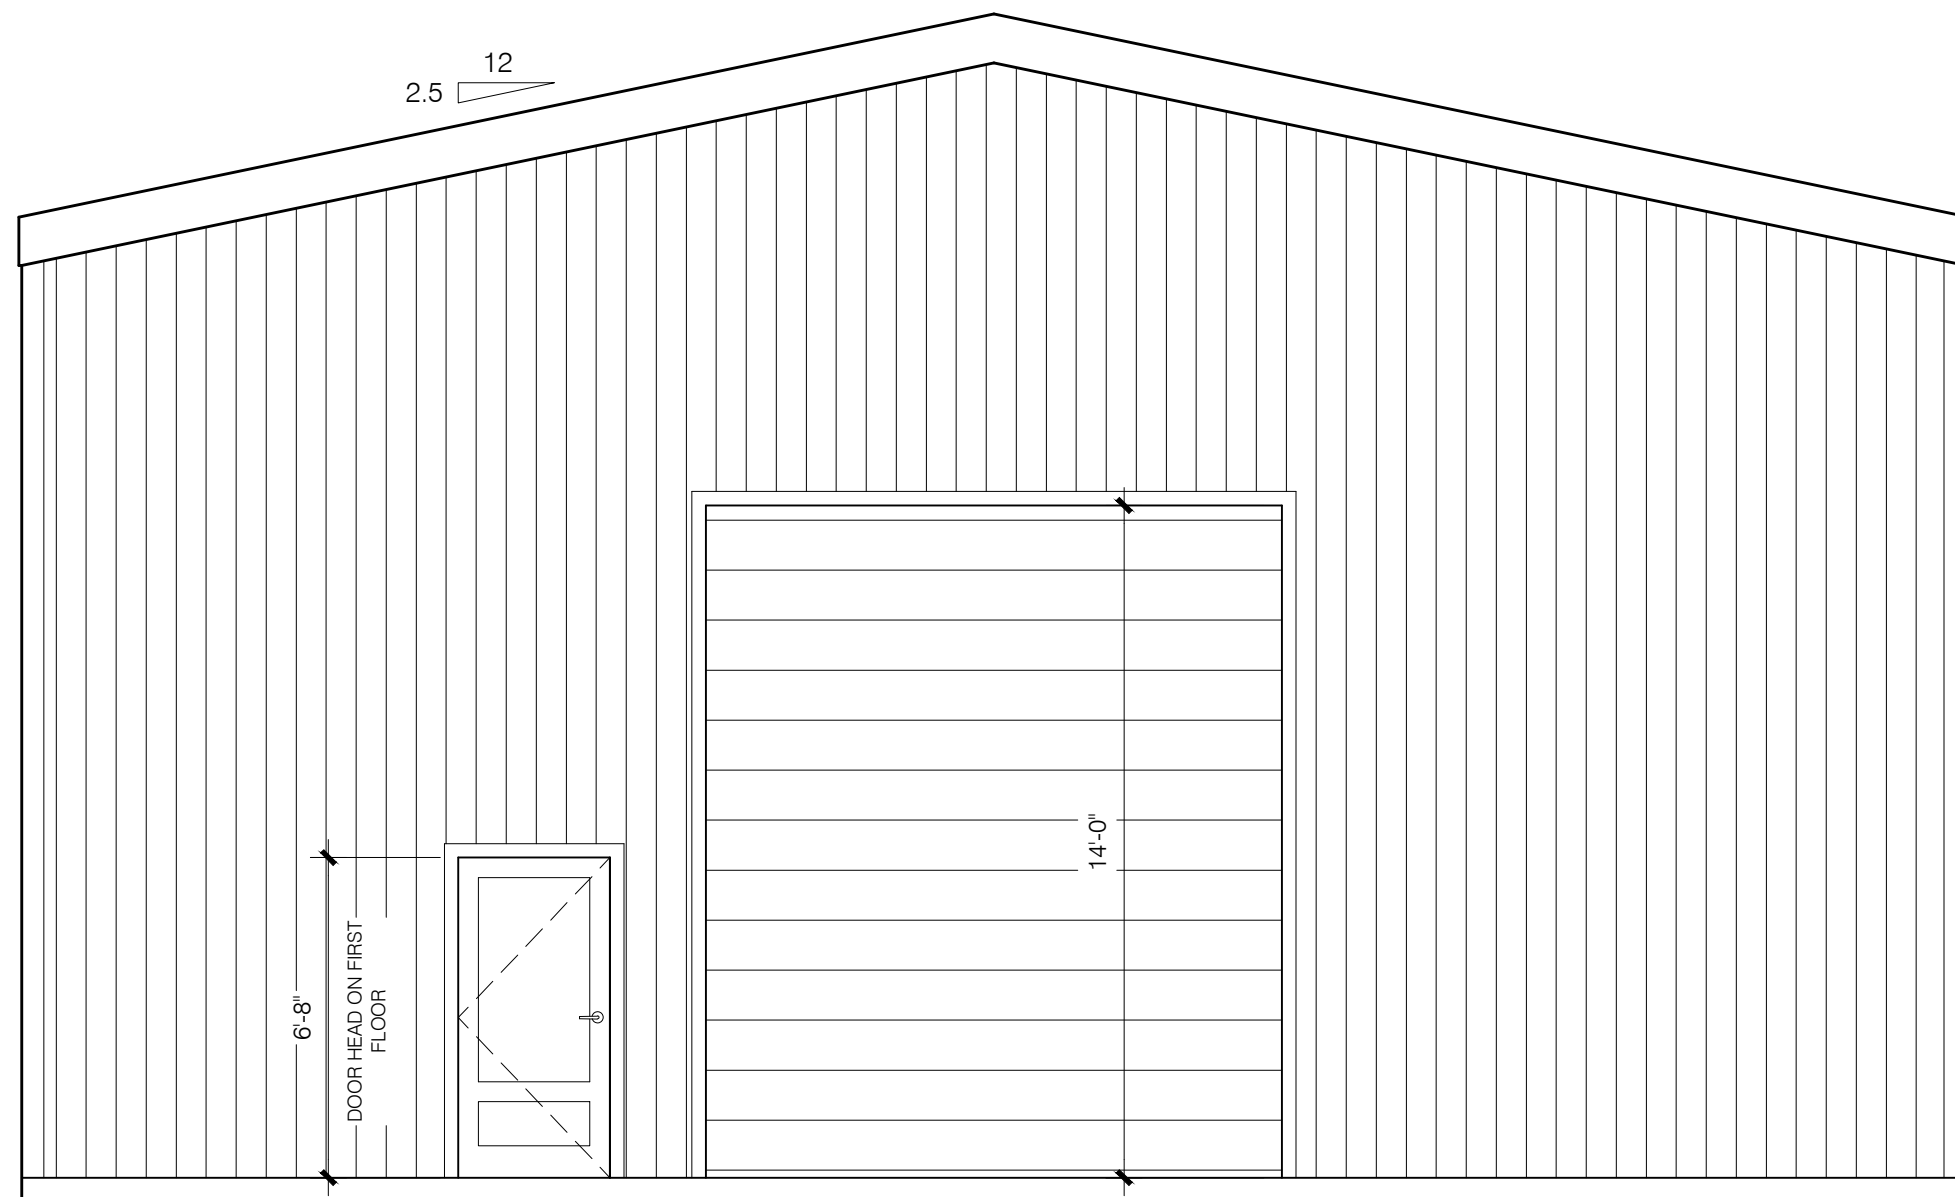


2
A2



OLINDA LABORATORY - MEZZANINE LEVEL PLAN
SCALE: 1/4" = 1'-0"

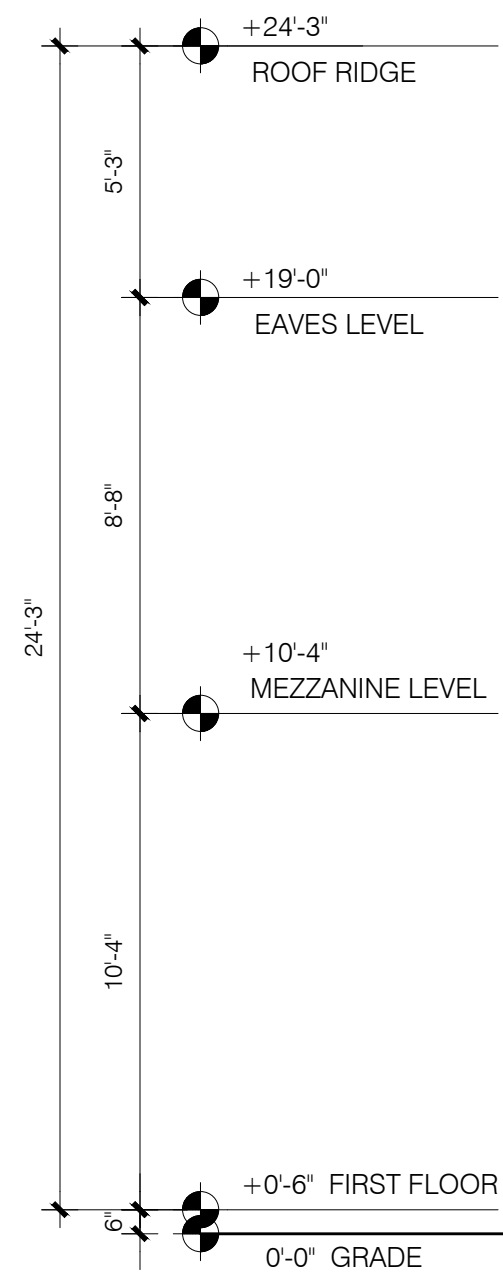

1
A3 FRONT ELEVATION
SCALE: 1/4" = 1'-0"

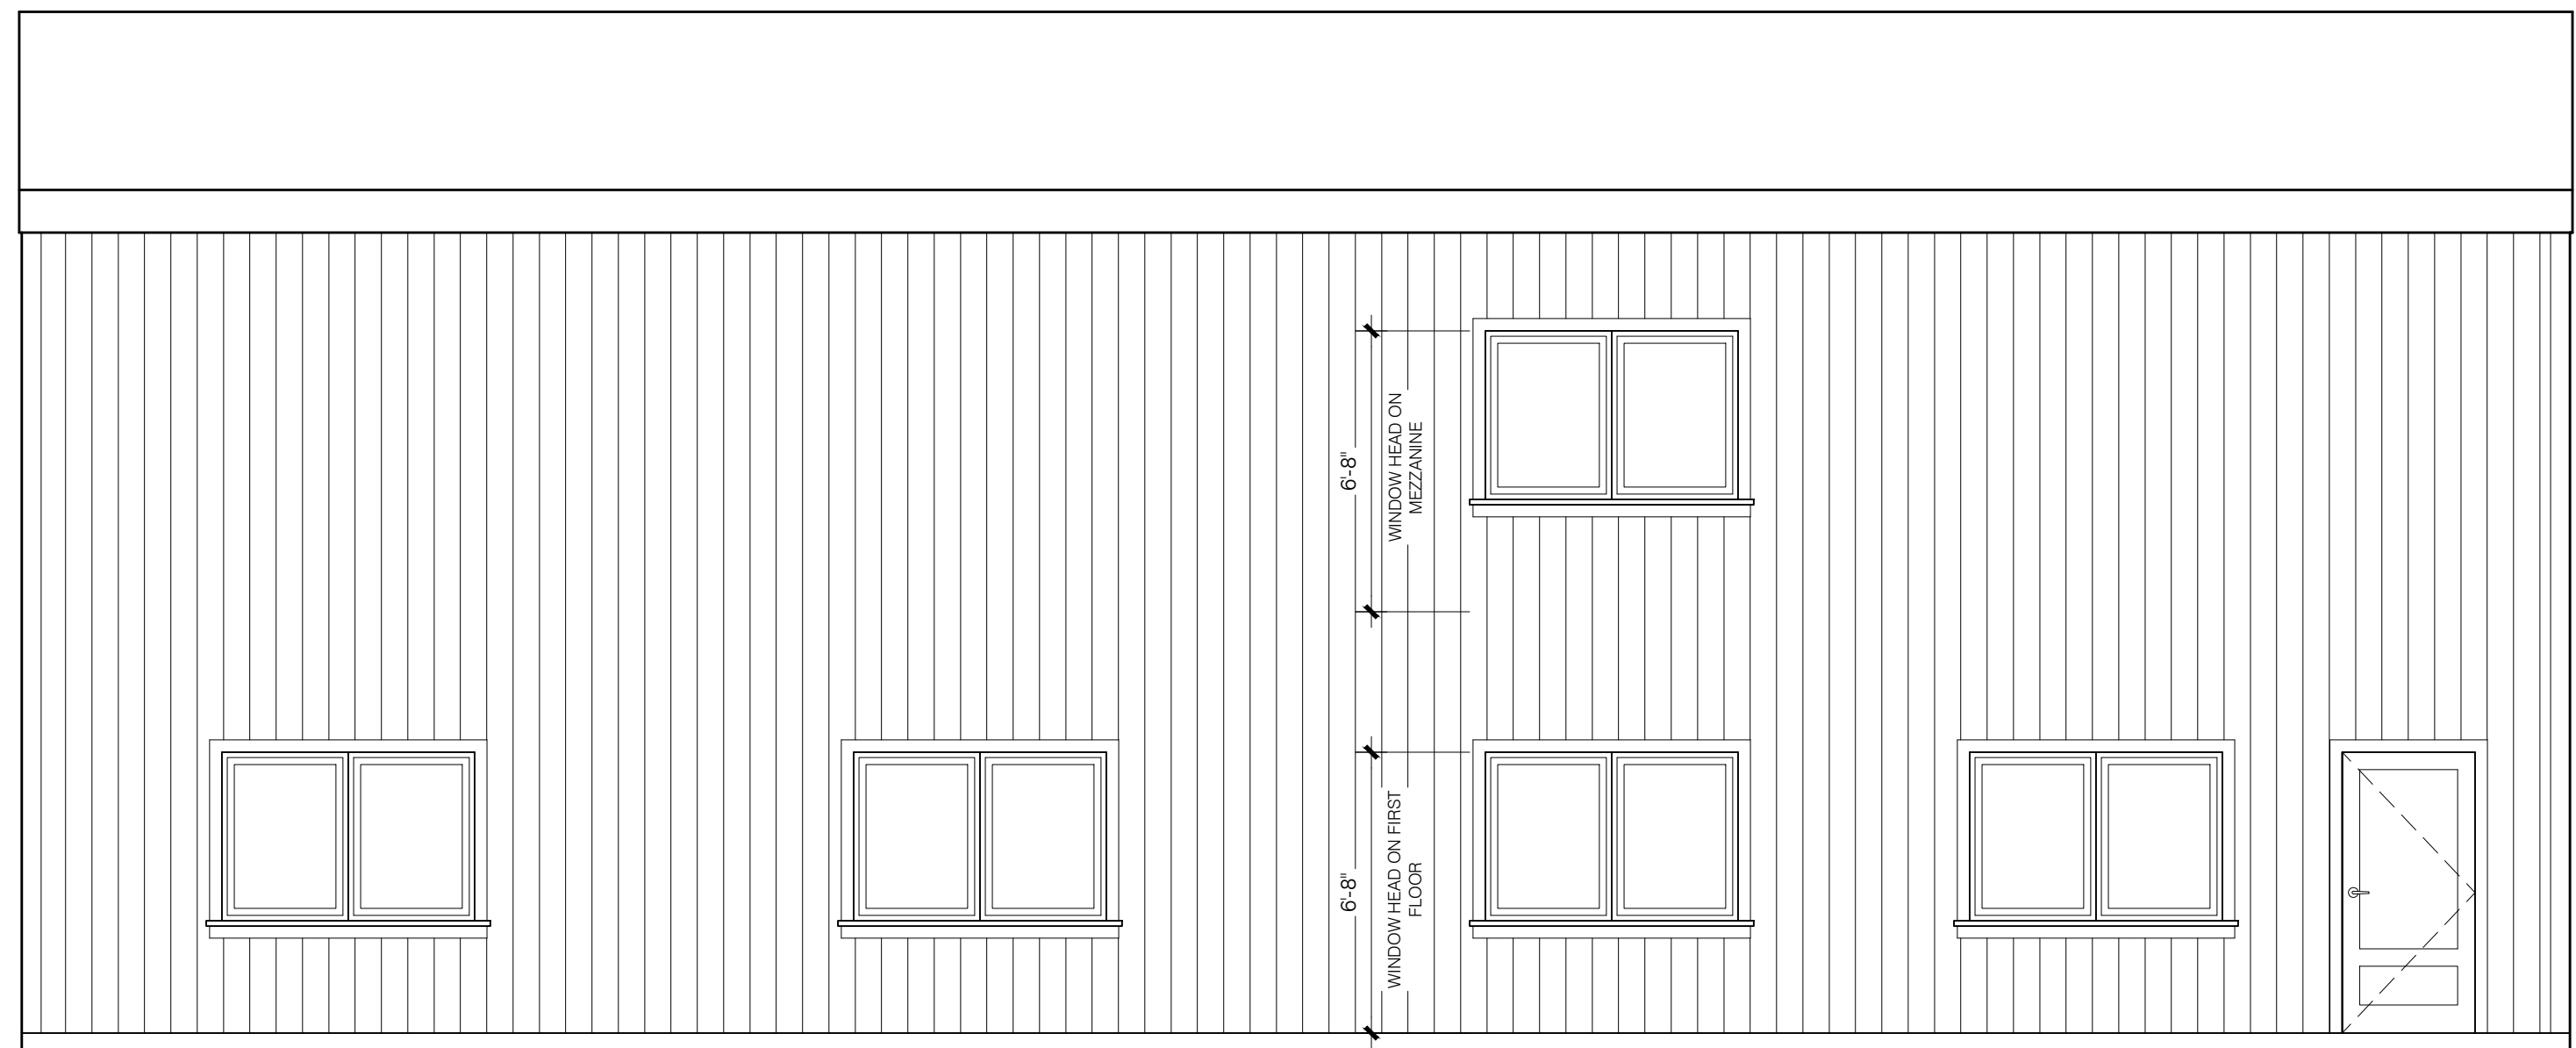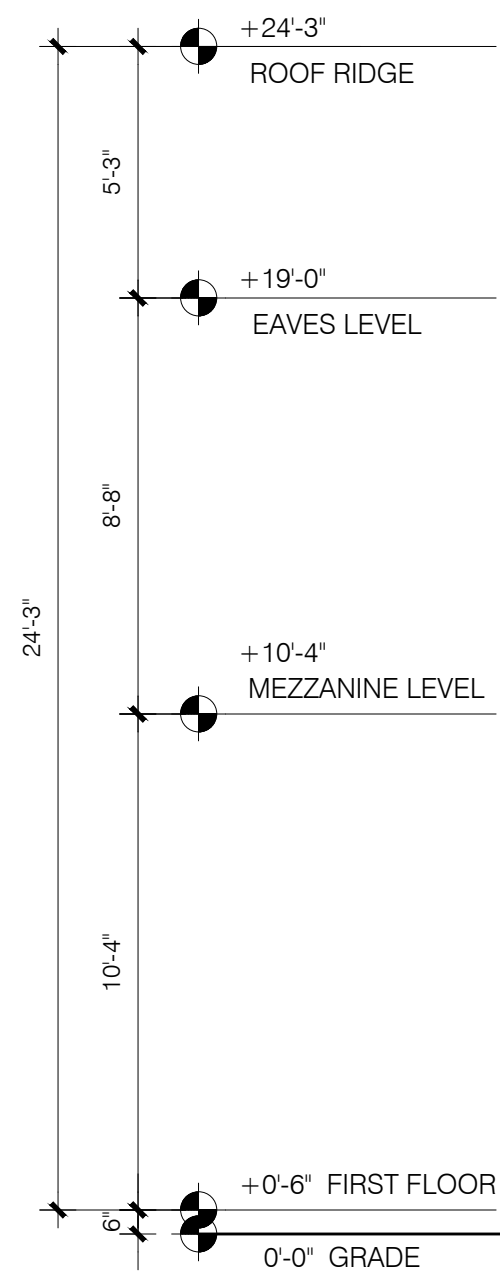


2
A3 SIDE ELEVATION
SCALE: 1/4" = 1'-0"

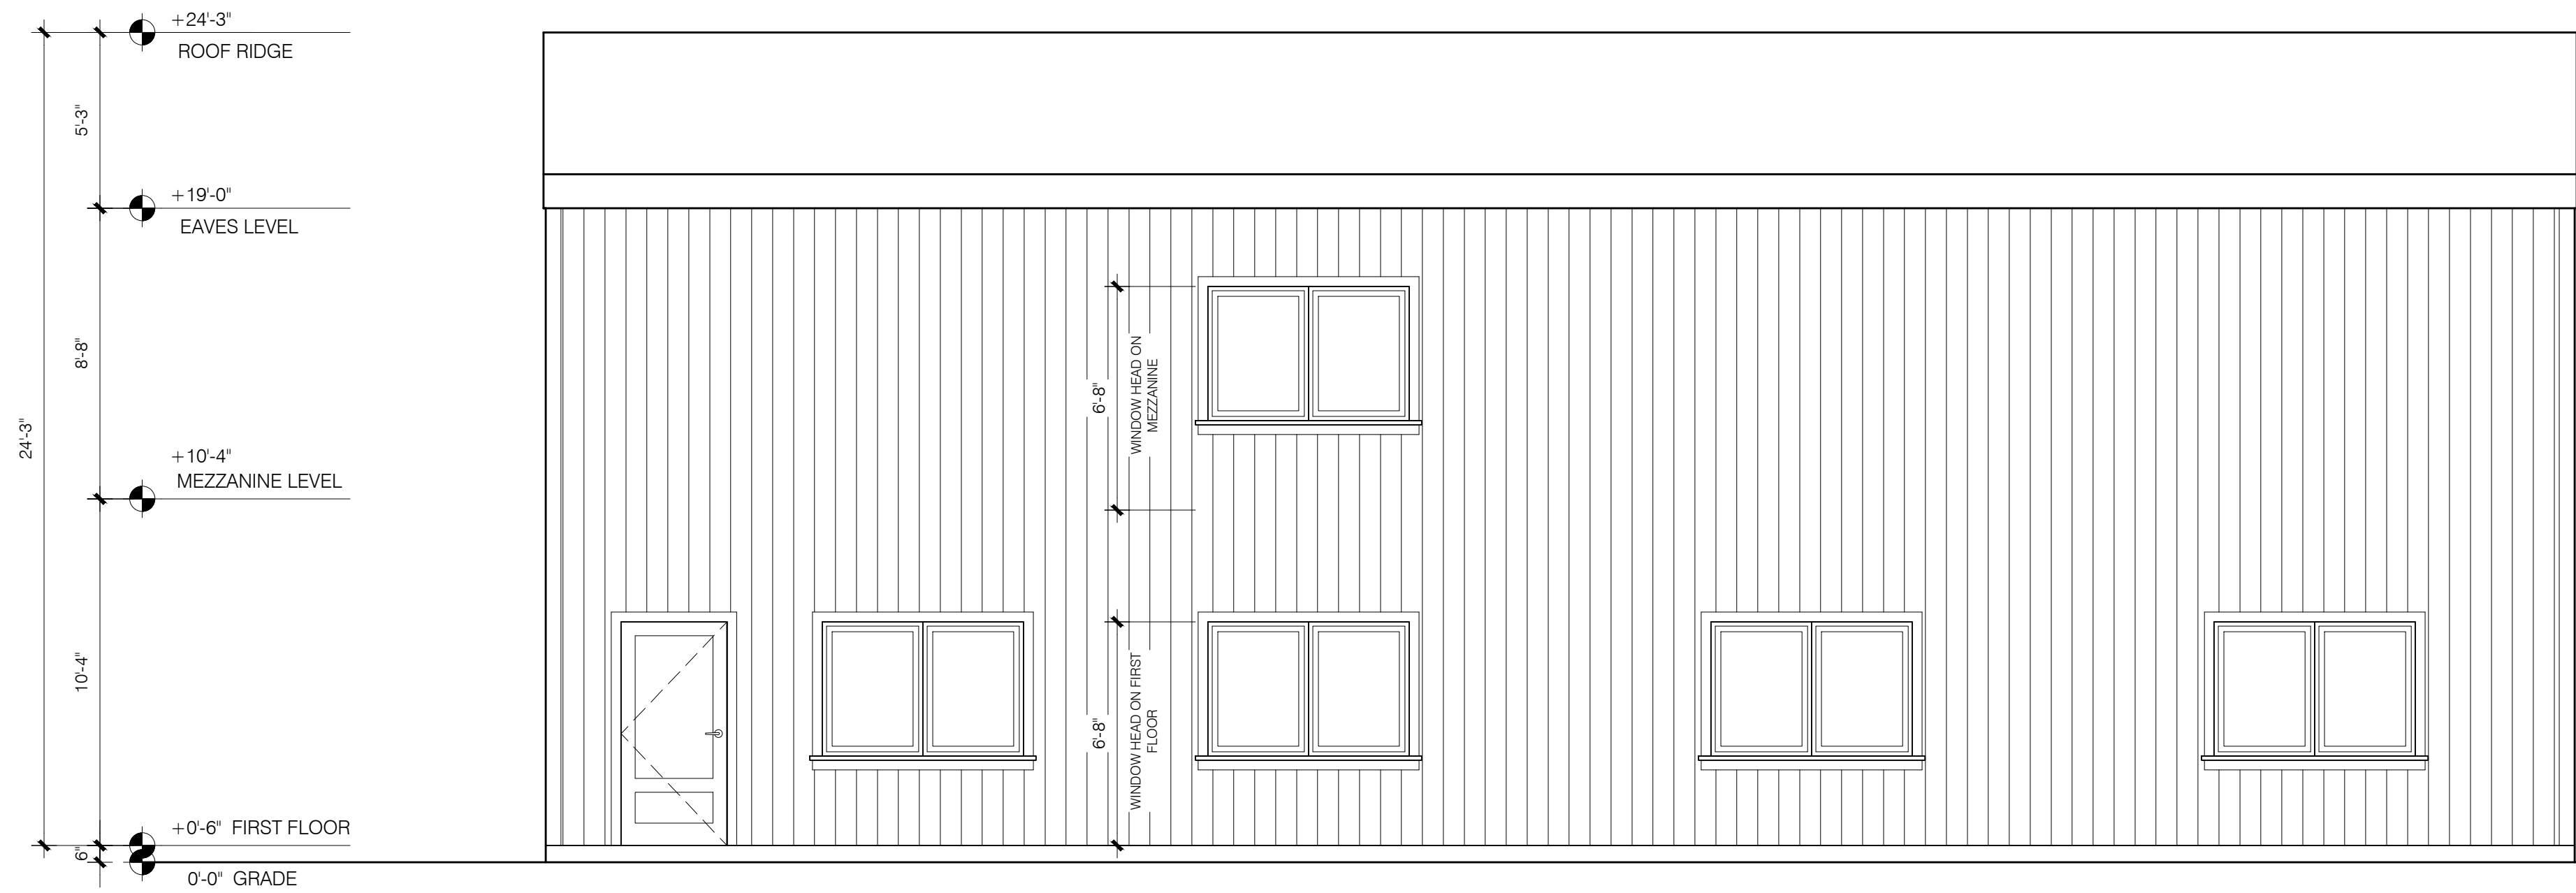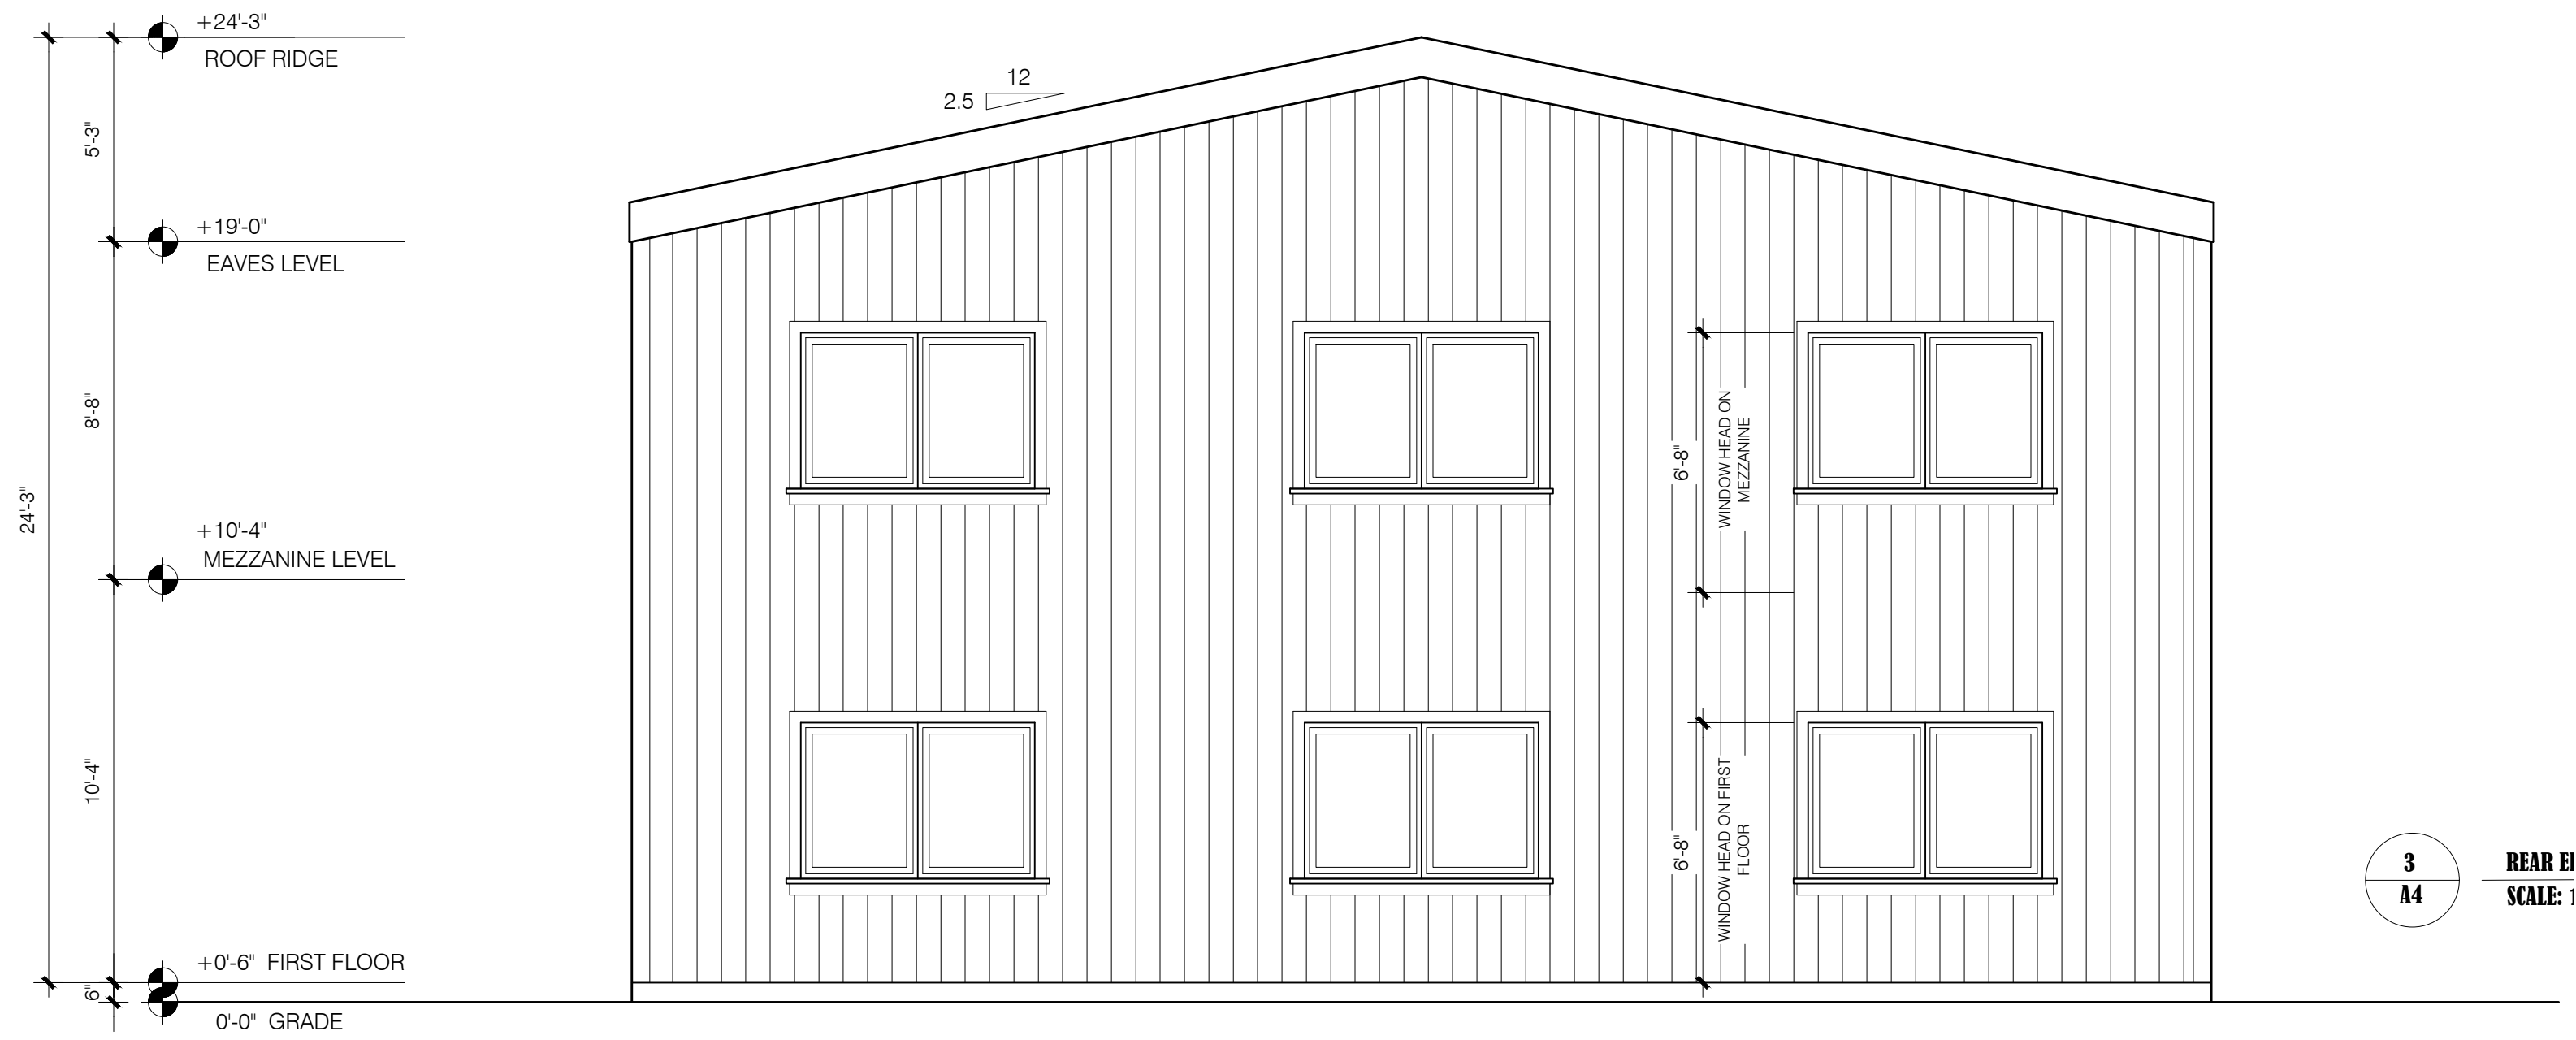


4
A4

SIDE ELEVATION
SCALE: 1/4" = 1'-0"

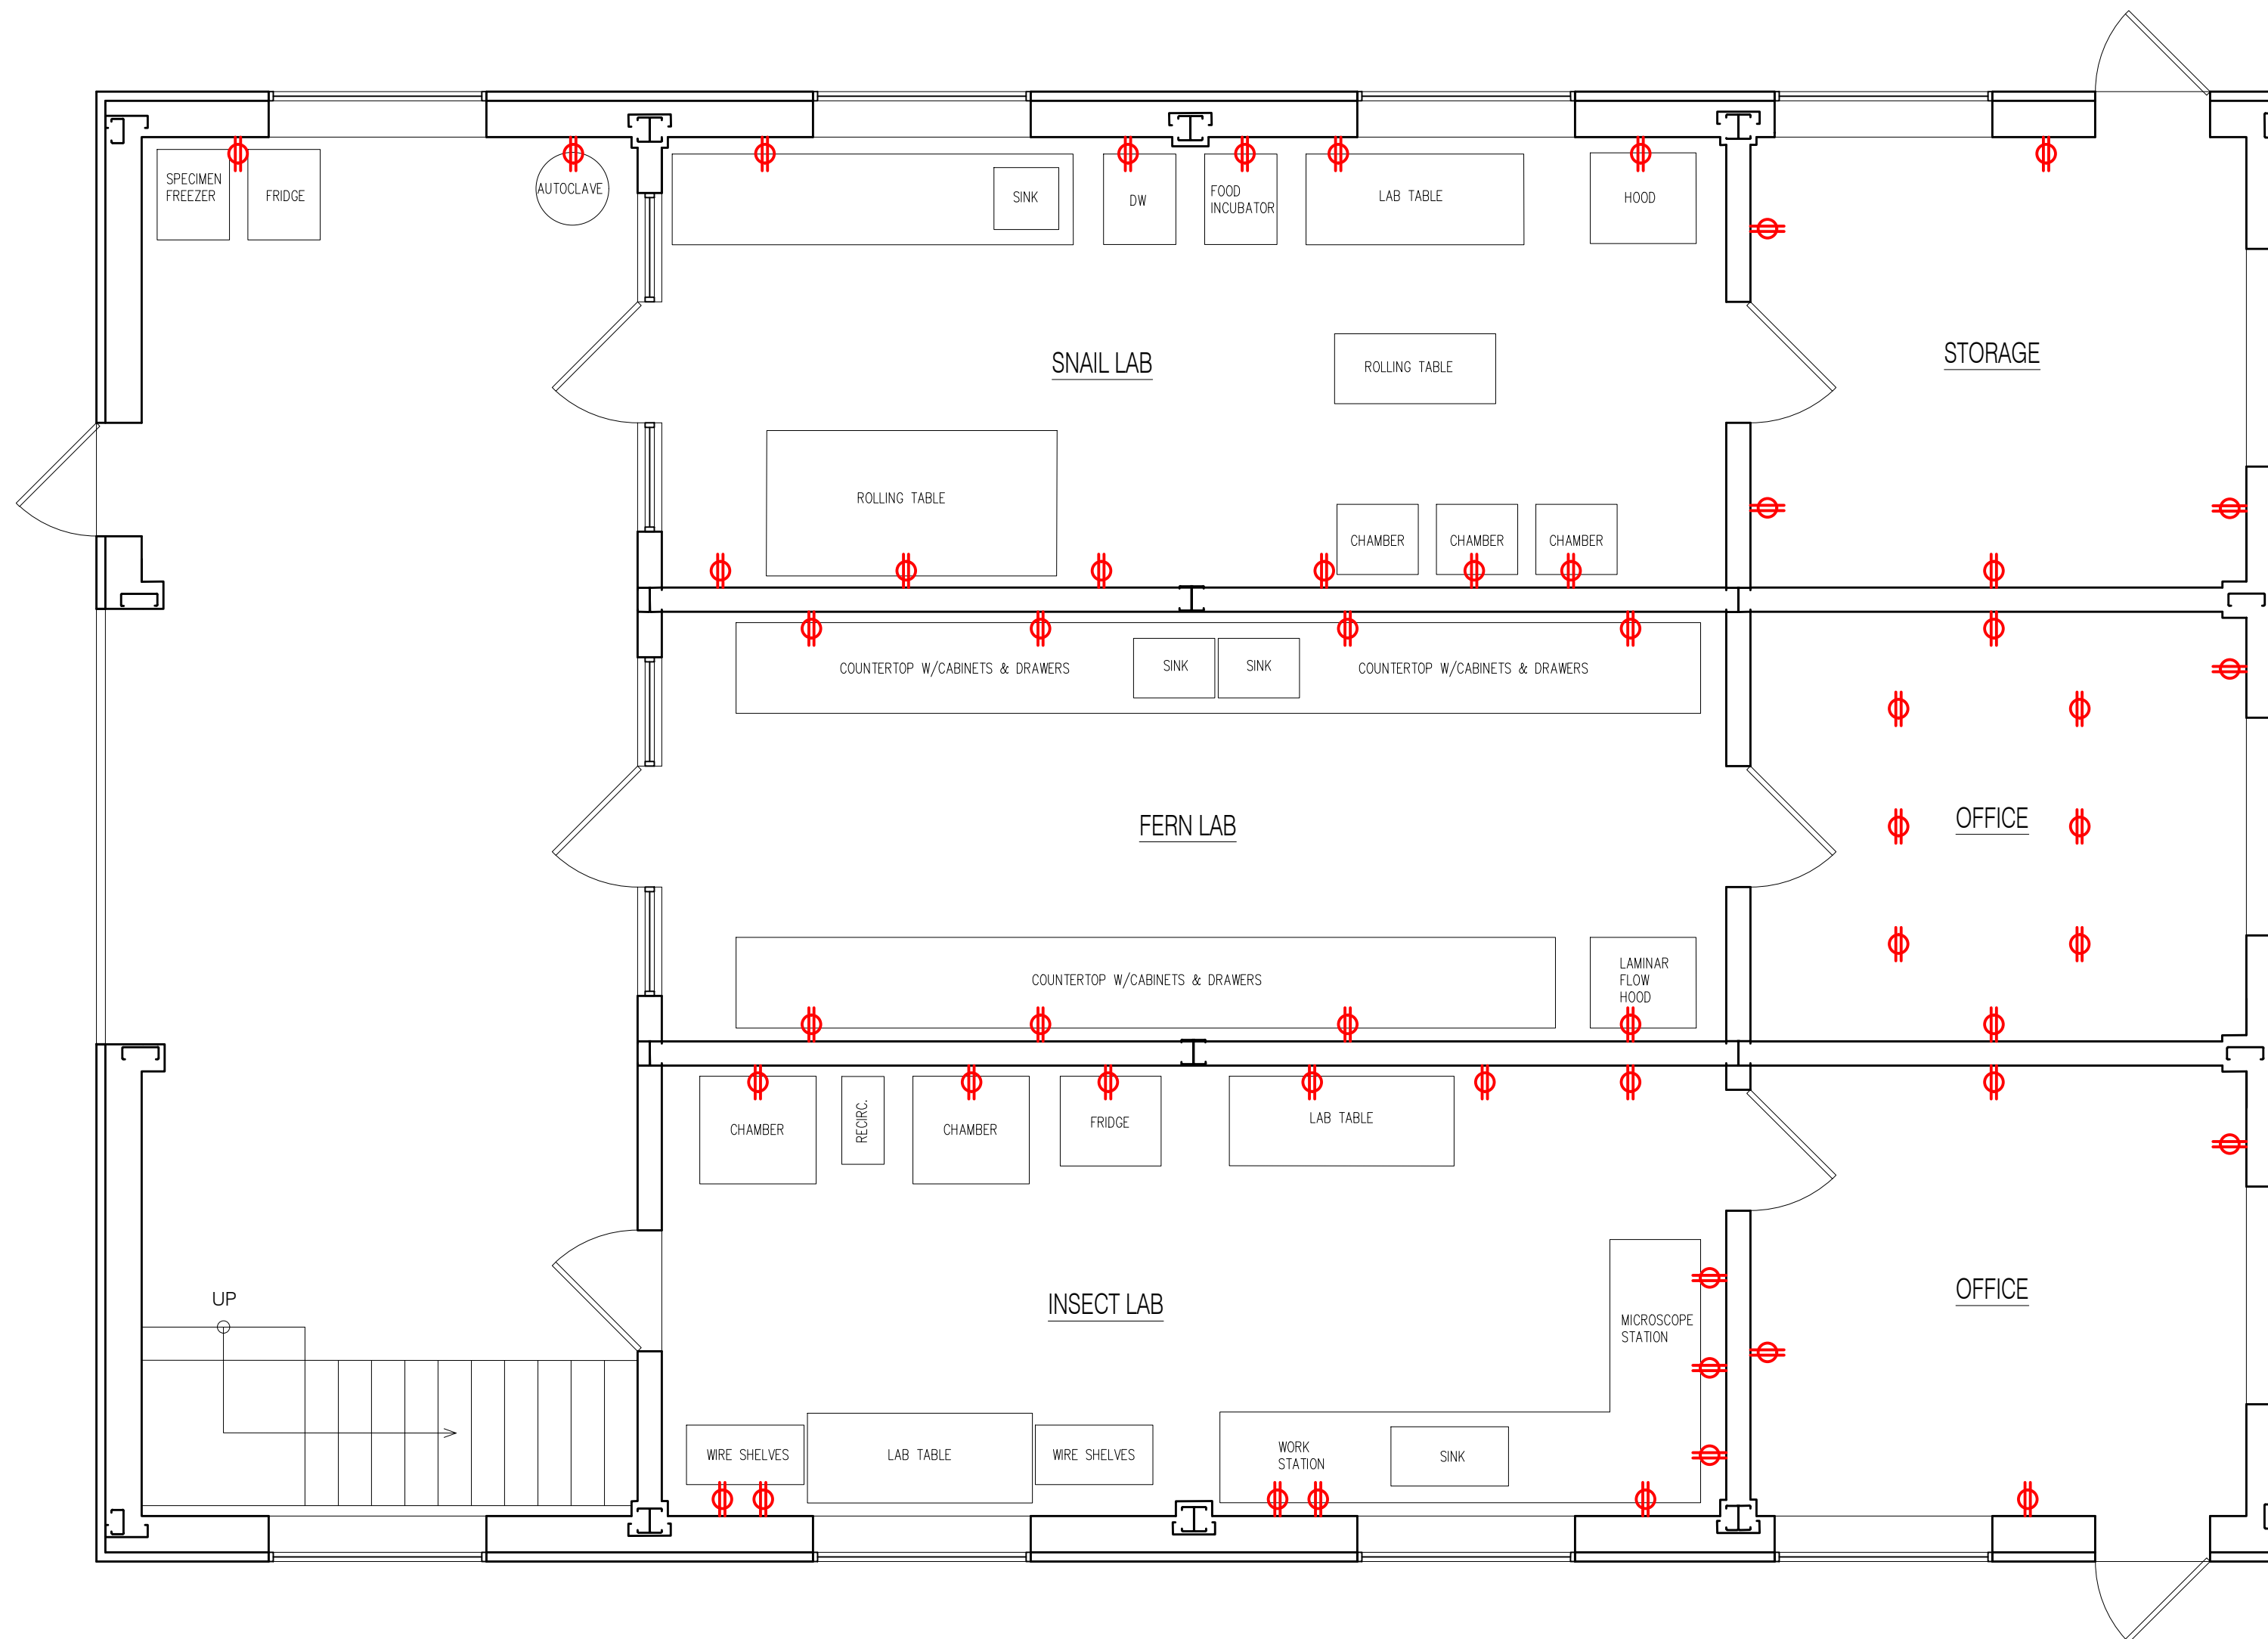

1
A5

ELECTRICAL PLAN - MAIN FLOOR
SCALE: 1/4" = 1'-0"

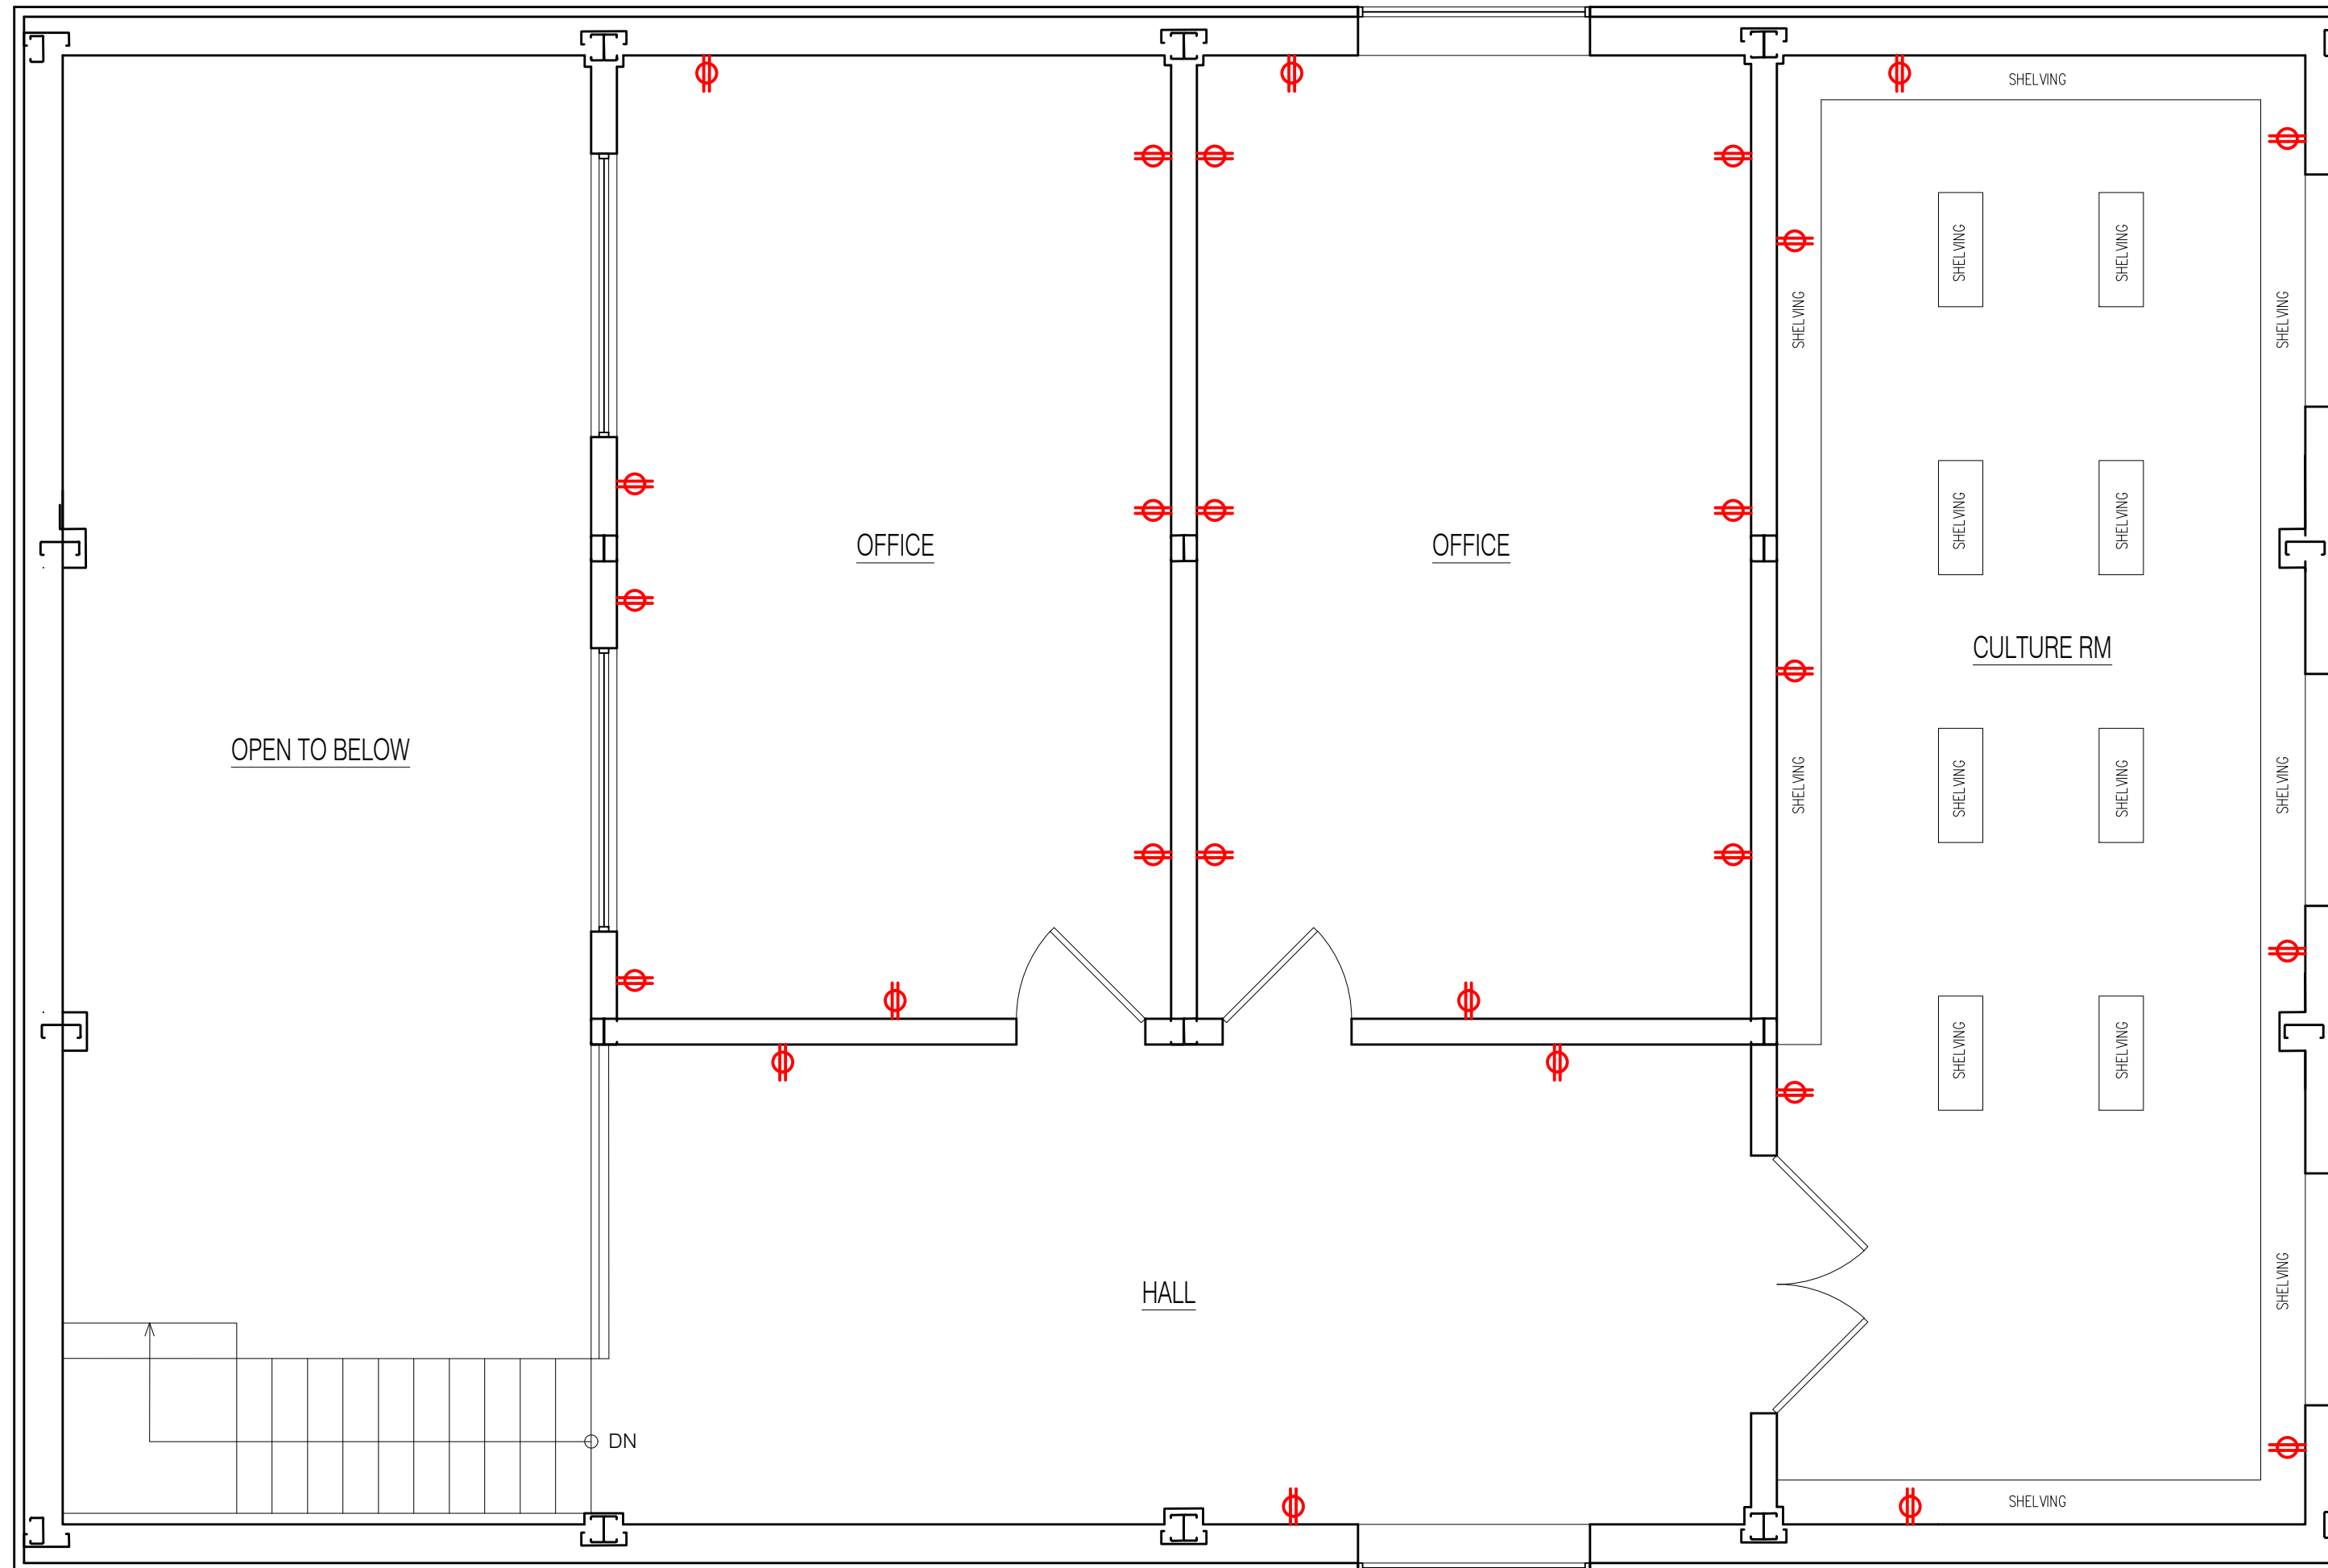

2
A6
ELECTRICAL PLAN - MEZZANINE LEVEL PLAN
SCALE: 1/4" = 1'-0"