

FOREIGN TRADE ZONE NO. 9 RENOVATIONS & ALTERATIONS

OF PIER 2

HONOLULU, HAWAII

TAX MAP KEY: 2-1-15, 28, 57

FOR THE
DEPARTMENT OF PLANNING & ECONOMIC DEVELOPMENT

BY THE
DEPARTMENT OF
ACCOUNTING AND GENERAL SERVICES
STATE OF HAWAII
D.A.G.S. JOB NO. 02-26-2015

WONG SUEDA CHING & ASSOC. INC.
RICHARD M. SATO & ASSOCIATES, INC.
KENNETH THOM ASSOCIATES, LTD.
GERRIC D.O. CHONG & ASSOCIATES, INC.

CHIEF, WATER TRANSPORTATION FACILITIES DIVISION
DEPARTMENT OF TRANSPORTATION
STATE OF HAWAII


DIRECTOR
DEPARTMENT OF PLANNING AND ECONOMIC DEVELOPMENT
STATE OF HAWAII

COMPTROLLER
DEPARTMENT OF ACCOUNTING AND GENERAL SERVICES
STATE OF HAWAII

STATE PUBLIC WORKS ENGINEER
DEPARTMENT OF ACCOUNTING AND GENERAL SERVICES
STATE OF HAWAII

CHIEF, ENVIRONMENTAL PROTECTION AND HEALTH SERVICES DIVISION
DEPARTMENT OF HEALTH
STATE OF HAWAII

ARCHITECTS PLANNERS
STRUCTURAL ENGINEERS
MECHANICAL ENGINEERS
ELECTRICAL ENGINEERS

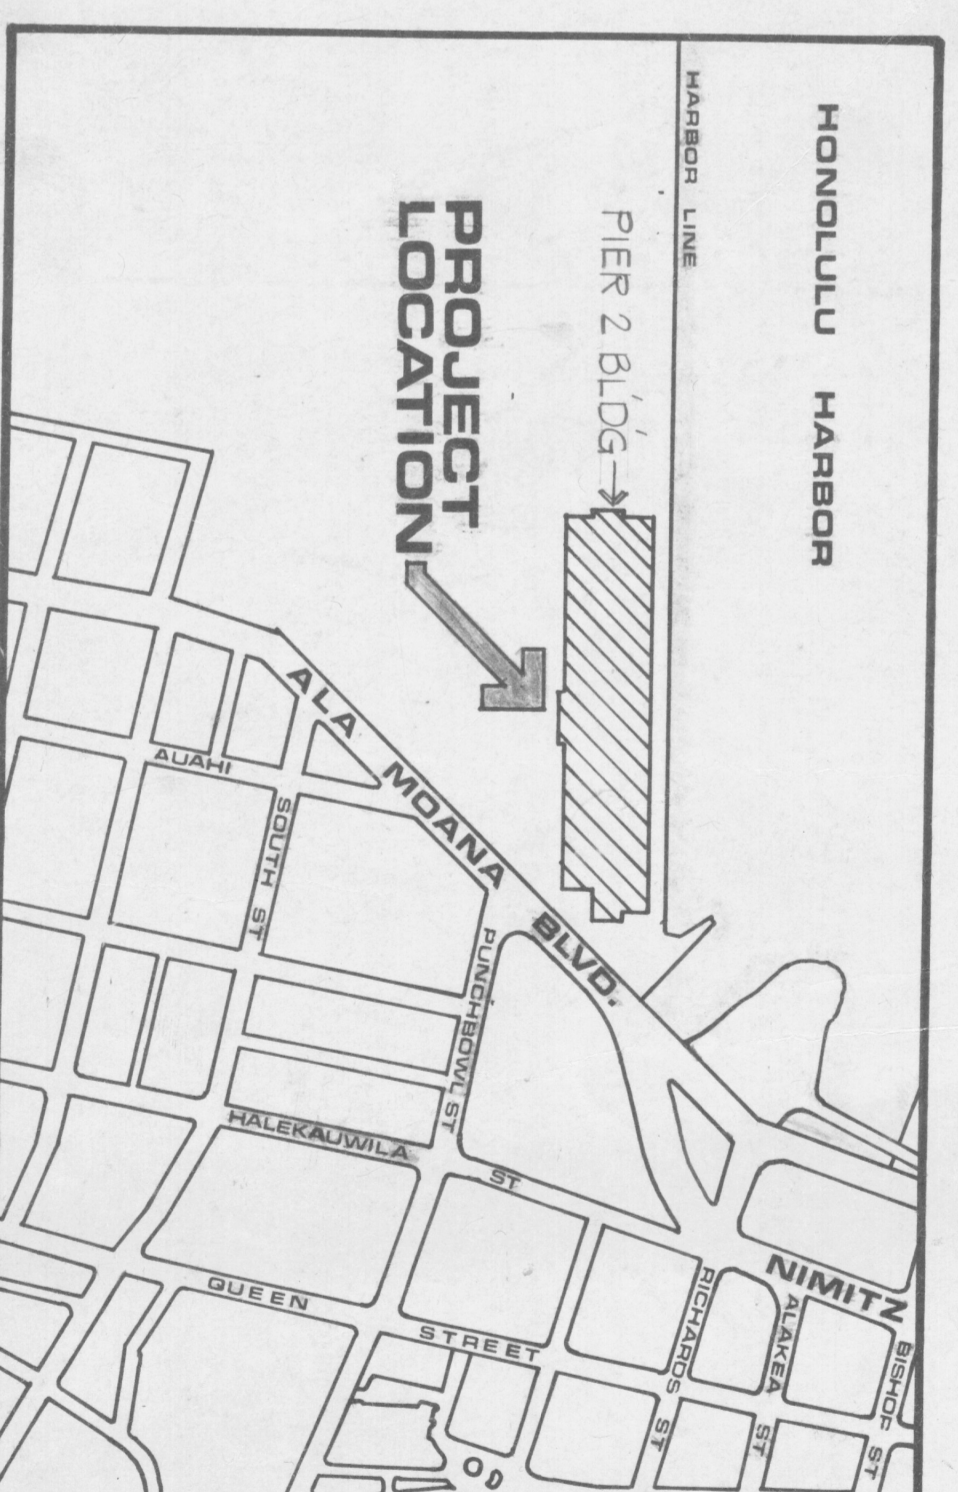

INDEX TO DRAWINGS

1	T-1	TITLE SHEET
2	A-1	ARCHITECTURAL EXISTING SITE & FIRST FLOOR BUILDING PLAN
3	A-2	EXISTING FIRST & SECOND FLOOR OFFICE PLANS & THIRD FLOOR PLAN
4	A-3	NEW FIRST FLOOR OFFICE PLAN, INTERIOR ELEVATIONS, & ROOM FINISH SCHEDULE
5	A-4	NEW SECOND FLOOR OFFICE PLAN, INTERIOR ELEVATIONS, & ROOM FINISH SCHEDULE
6	A-5	WALL TYPES & DETAILS, TYPICAL WALL SECTIONS, INTERIOR CABINET & COUNTER DETAILS
7	A-6	NEW/REFLECTED CEILING PLANS - FIRST & SECOND FLOOR OFFICES
8	A-7	TYPICAL CROSS & LONGITUDINAL SECTIONS
9	A-8	3/4" WALL SECTIONS - MENS & WOMENS TOILET PLANS & INTERIOR ELEVATIONS
10	A-9	ELEVATOR & WALKWAY DETAILS, CONCRETE ROOFING DETAILS
11	A-10	WINDOW & DOOR TYPES, SCHEDULES & DETAILS, MISCELLANEOUS DETAILS
12	S-1	STRUCTURAL FOUNDATION PLAN & DETAILS
13	S-2	SECOND FLOOR FRAMING PLAN & DETAILS
14	S-3	GENERAL NOTES & DETAILS
15	S-4	CEILING FRAMING PLAN & DETAILS
16	M-1	MECHANICAL FIRST & SECOND FLOOR PLUMBING PLANS
17	M-2	FIRST & SECOND FLOOR FIRE SPRINKLER PLANS & DETAILS
18	M-3	SANITARY & WATER DIAGRAMS
19	M-4	AIR CONDITIONING PLANS, LEGEND
20	M-5	DETAIL PLANS & SECTIONS
21	M-6	CHILLED WATER PIPING DIAGRAMS
22	M-7	EQUIPMENT SCHEDULE, DETAILS & DIAGRAMS
23	E-1	ELECTRICAL SITE & SERVICE PLANS, UNDERGROUND DUCT SECTIONS, GENERAL NOTES & LEGEND
24	E-2	EXISTING PLANS, REMOVAL WORK & GENERAL NOTES
25	E-3	FIRST FLOOR POWER PLAN SWITCH-PLAN & DETAILS, GENERAL NOTES
26	E-4	SECOND FLOOR POWER PLAN & AIR-CONDITIONING DETAILS
27	E-5	FIRST FLOOR LIGHTING PLAN & LIGHTING FIXTURE DETAILS
28	E-6	SECOND FLOOR LIGHTING PLAN & FIRE ALARM ZONING PLAN & RISER DIAGRAM
29	E-7	PANEL SCHEDULES

REVISION NO.	DATE	DESCRIPTION	BY	CHKD	APPROVED DATE

WONG SUEDA CHING & ASSOC. INC.	3040 JOE NO.	DRAWING NO.
1000 S. KING ST.	HONOLULU, HI 96813	1
PHONE: 808-533-1111	FAX: 808-533-1112	TITLE SHEET
WWW.WSCINC.COM		

DEPT. OF ACCOUNTING & GENERAL SERVICES	STATE OF HAWAII
FOREIGN TRADE ZONE NO. 9 -	RENOVATIONS & ALTERATIONS OF PIER 2
HONOLULU	CAHU HAWAII
TITLE SHEET	