



SECOND FLOOR AC PLAN
SCALE: 1/8" = 1'-0" (AT CENTER MAINLINE OF BUILDING)

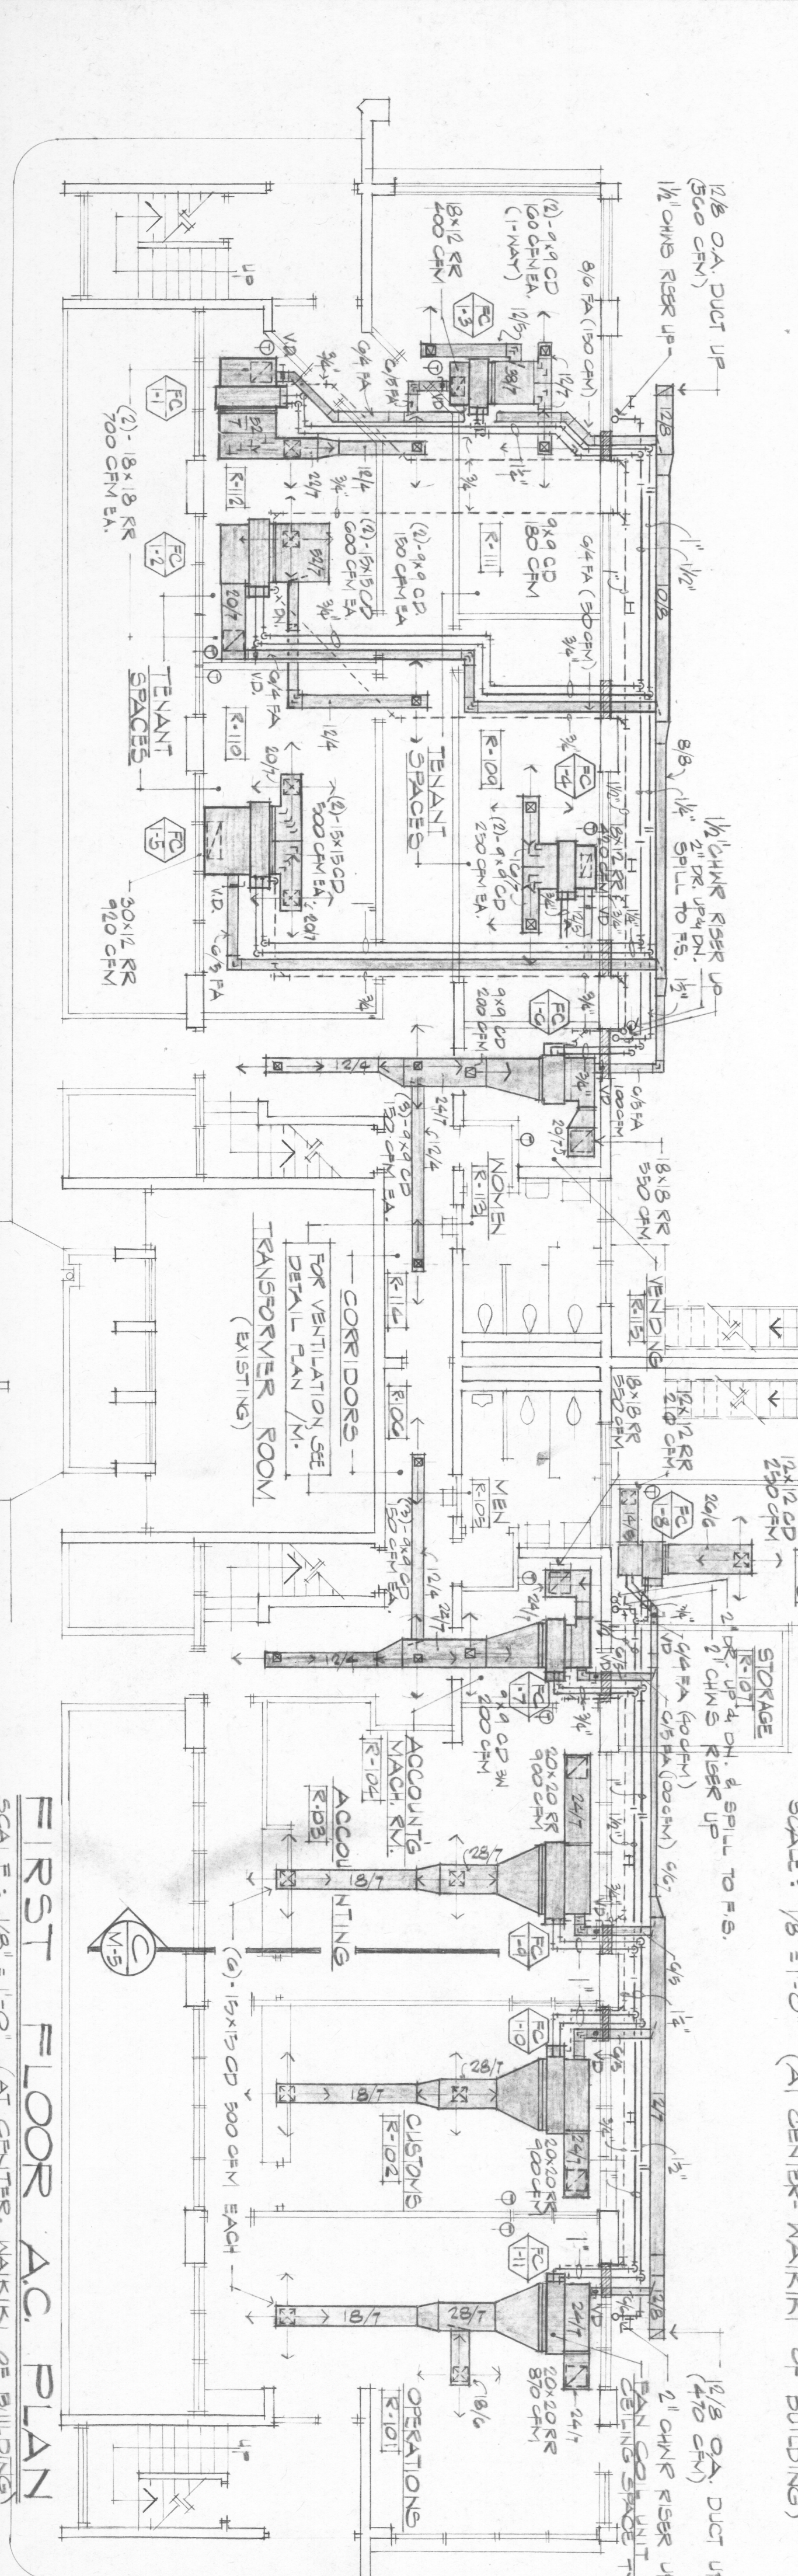

FIRST FLOOR AC PLAN
SCALE: 1/8" = 1'-0" (AT CENTER MAINLINE OF BUILDING)

LEGEND:

SYMBOL	DESCRIPTION
[Symbol]	AIR HANDLER
[Symbol]	DIFFUSER
[Symbol]	DUCTWORK
[Symbol]	CHILLED WATER SUPPLY
[Symbol]	CHILLED WATER RETURN
[Symbol]	CONDENSATE DRAIN
[Symbol]	SUPPLY AIR
[Symbol]	RETURN AIR
[Symbol]	CEILING DIFFUSER
[Symbol]	EXHAUST REGISTER
[Symbol]	FLEX CONNECTION
[Symbol]	FIRE DAMPER
[Symbol]	THRESHOLD AND SWITCH

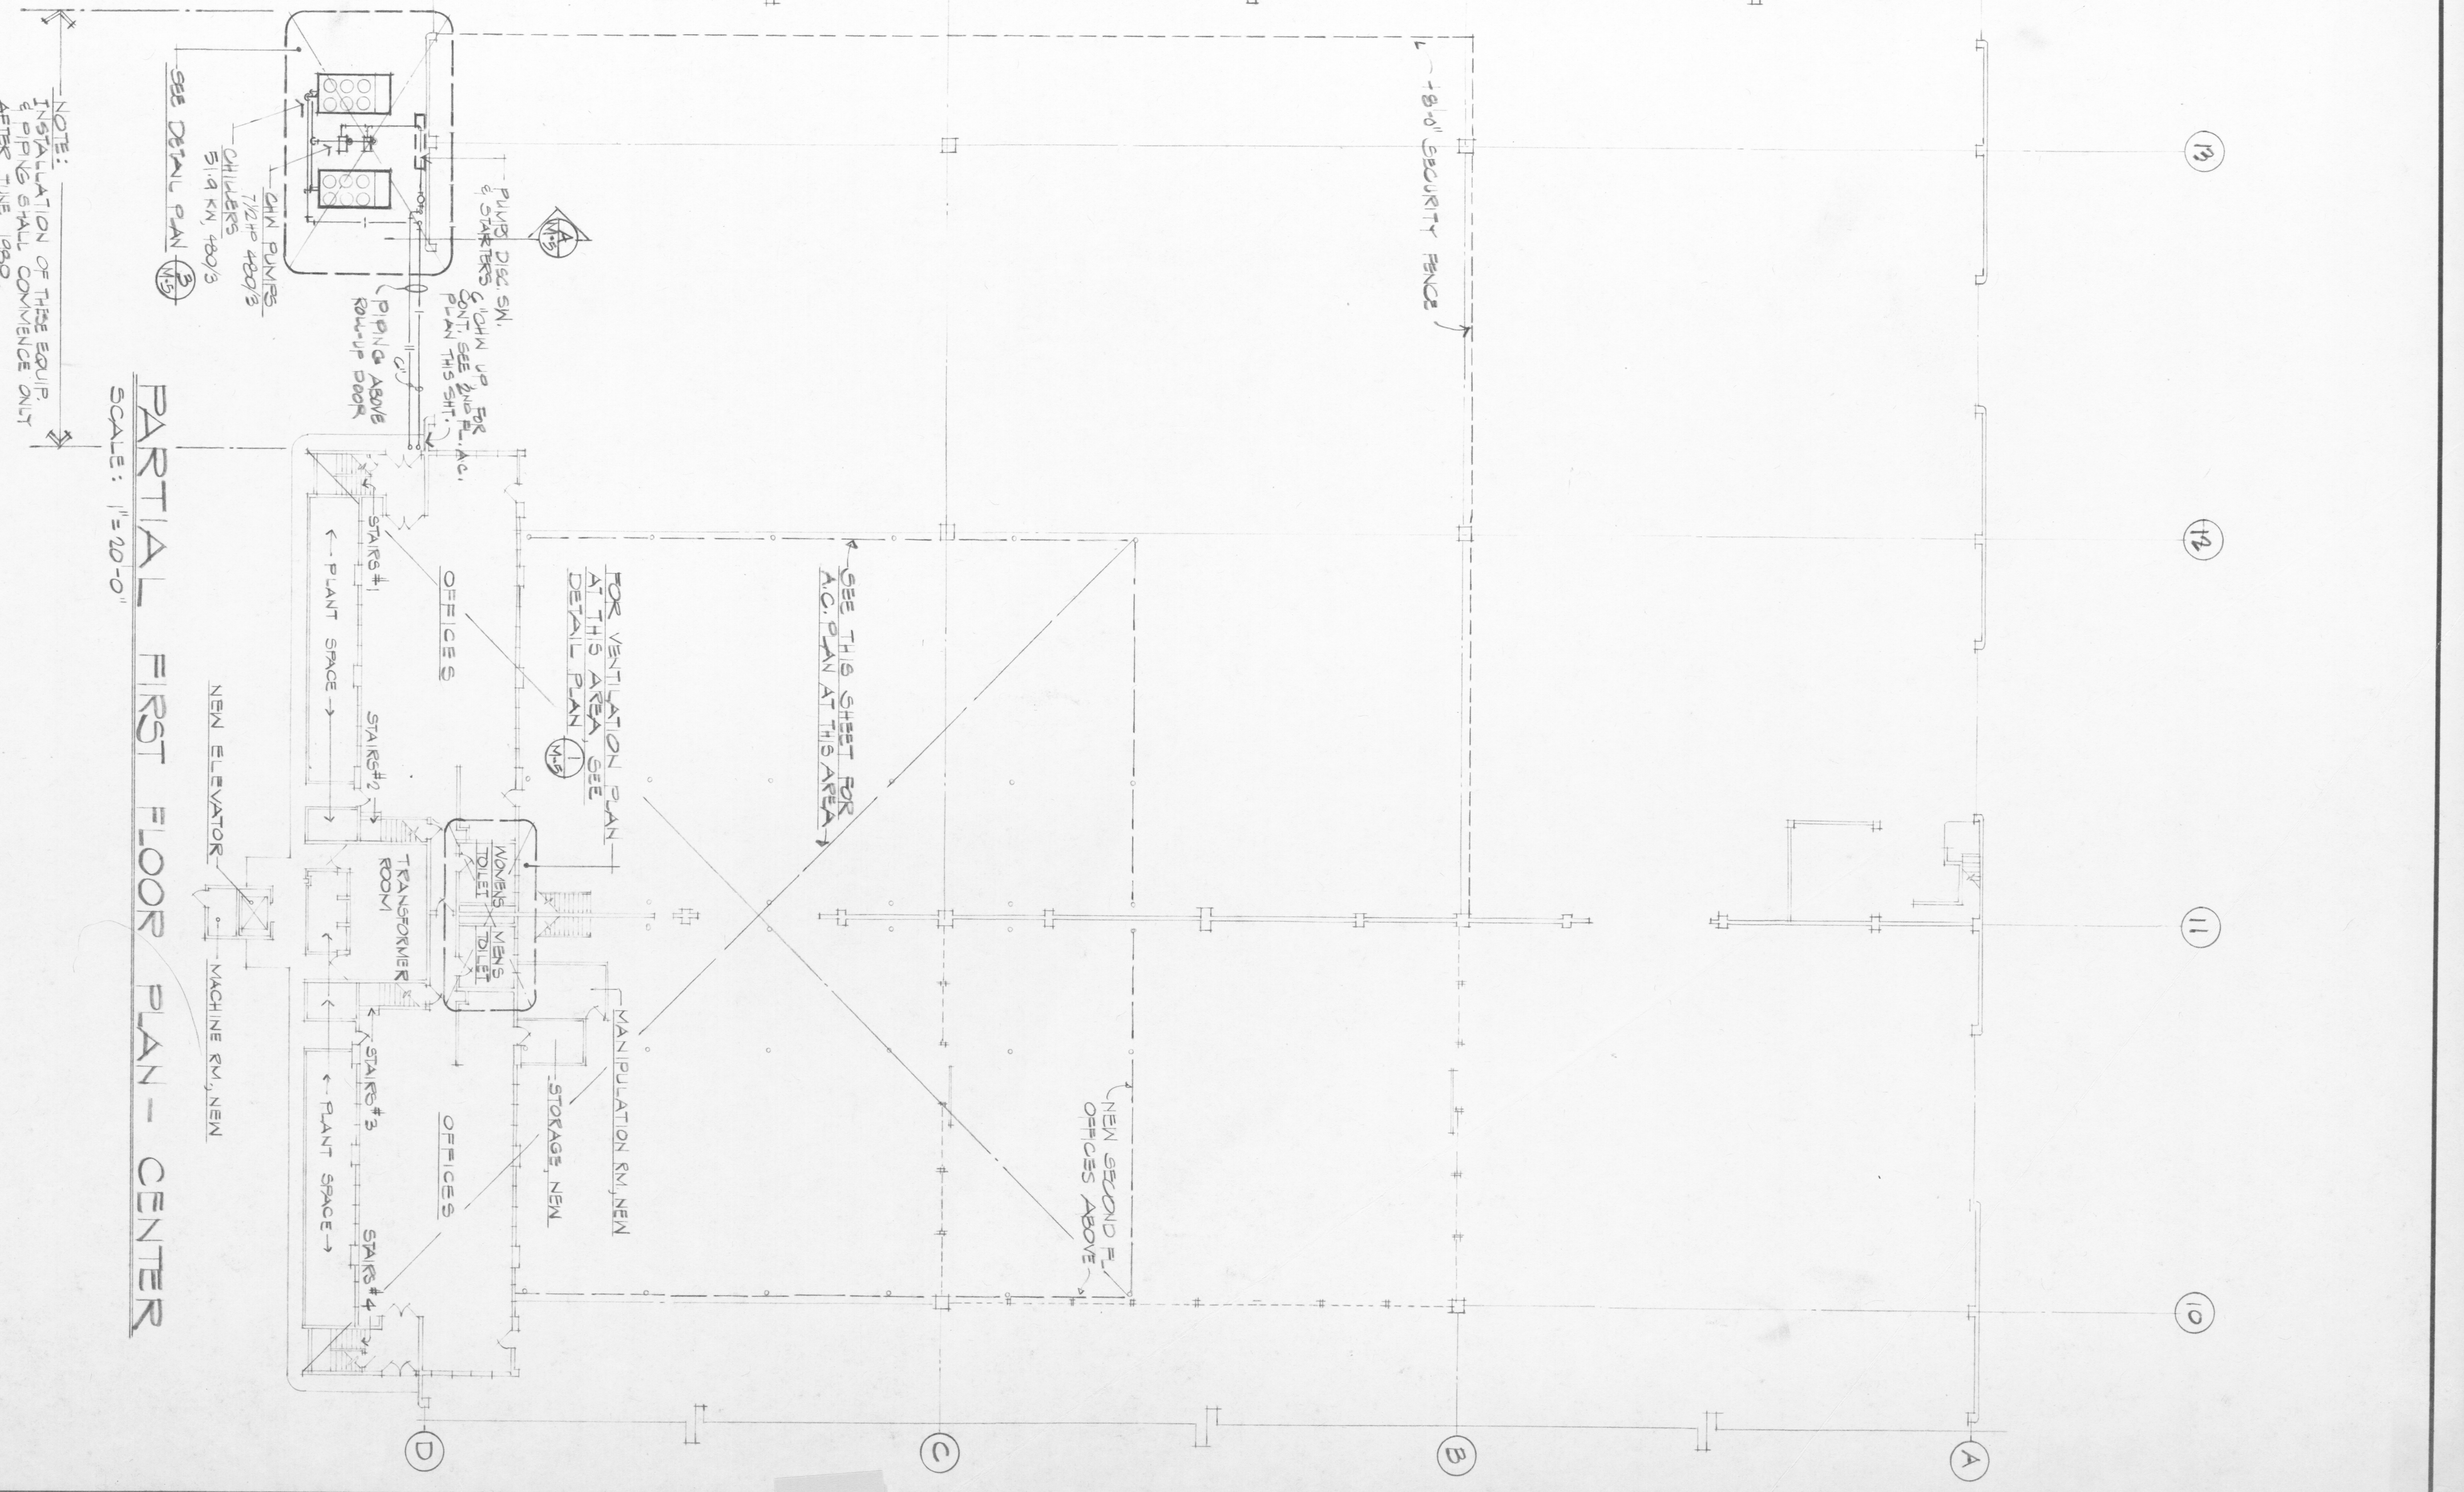

PARTIAL FIRST FLOOR PLAN - CENTER
SCALE: 1/8" = 1'-0"

REVISION NO.	DATE	DESCRIPTION
1	02-15-2013	ISSUED FOR PERMITS
2	02-15-2013	ISSUED FOR PERMITS
3	02-15-2013	ISSUED FOR PERMITS

DEPT. OF ACCOUNTING & GENERAL SERVICES
 HONOLULU, HAWAII
 FOREIGN TRADE ZONE NO. 1
 RENOVATIONS & ALTERATIONS OF FLOOR 2
 HONOLULU, HAWAII
 AIR CONDITIONING PLANS - LEGEND
 DRAWING NO. M-7-1
 SHEET 5 OF 23