



1 FIRST FLOOR TOILETS VENTILATION PLAN
SCALE: 1/4" = 1'-0"

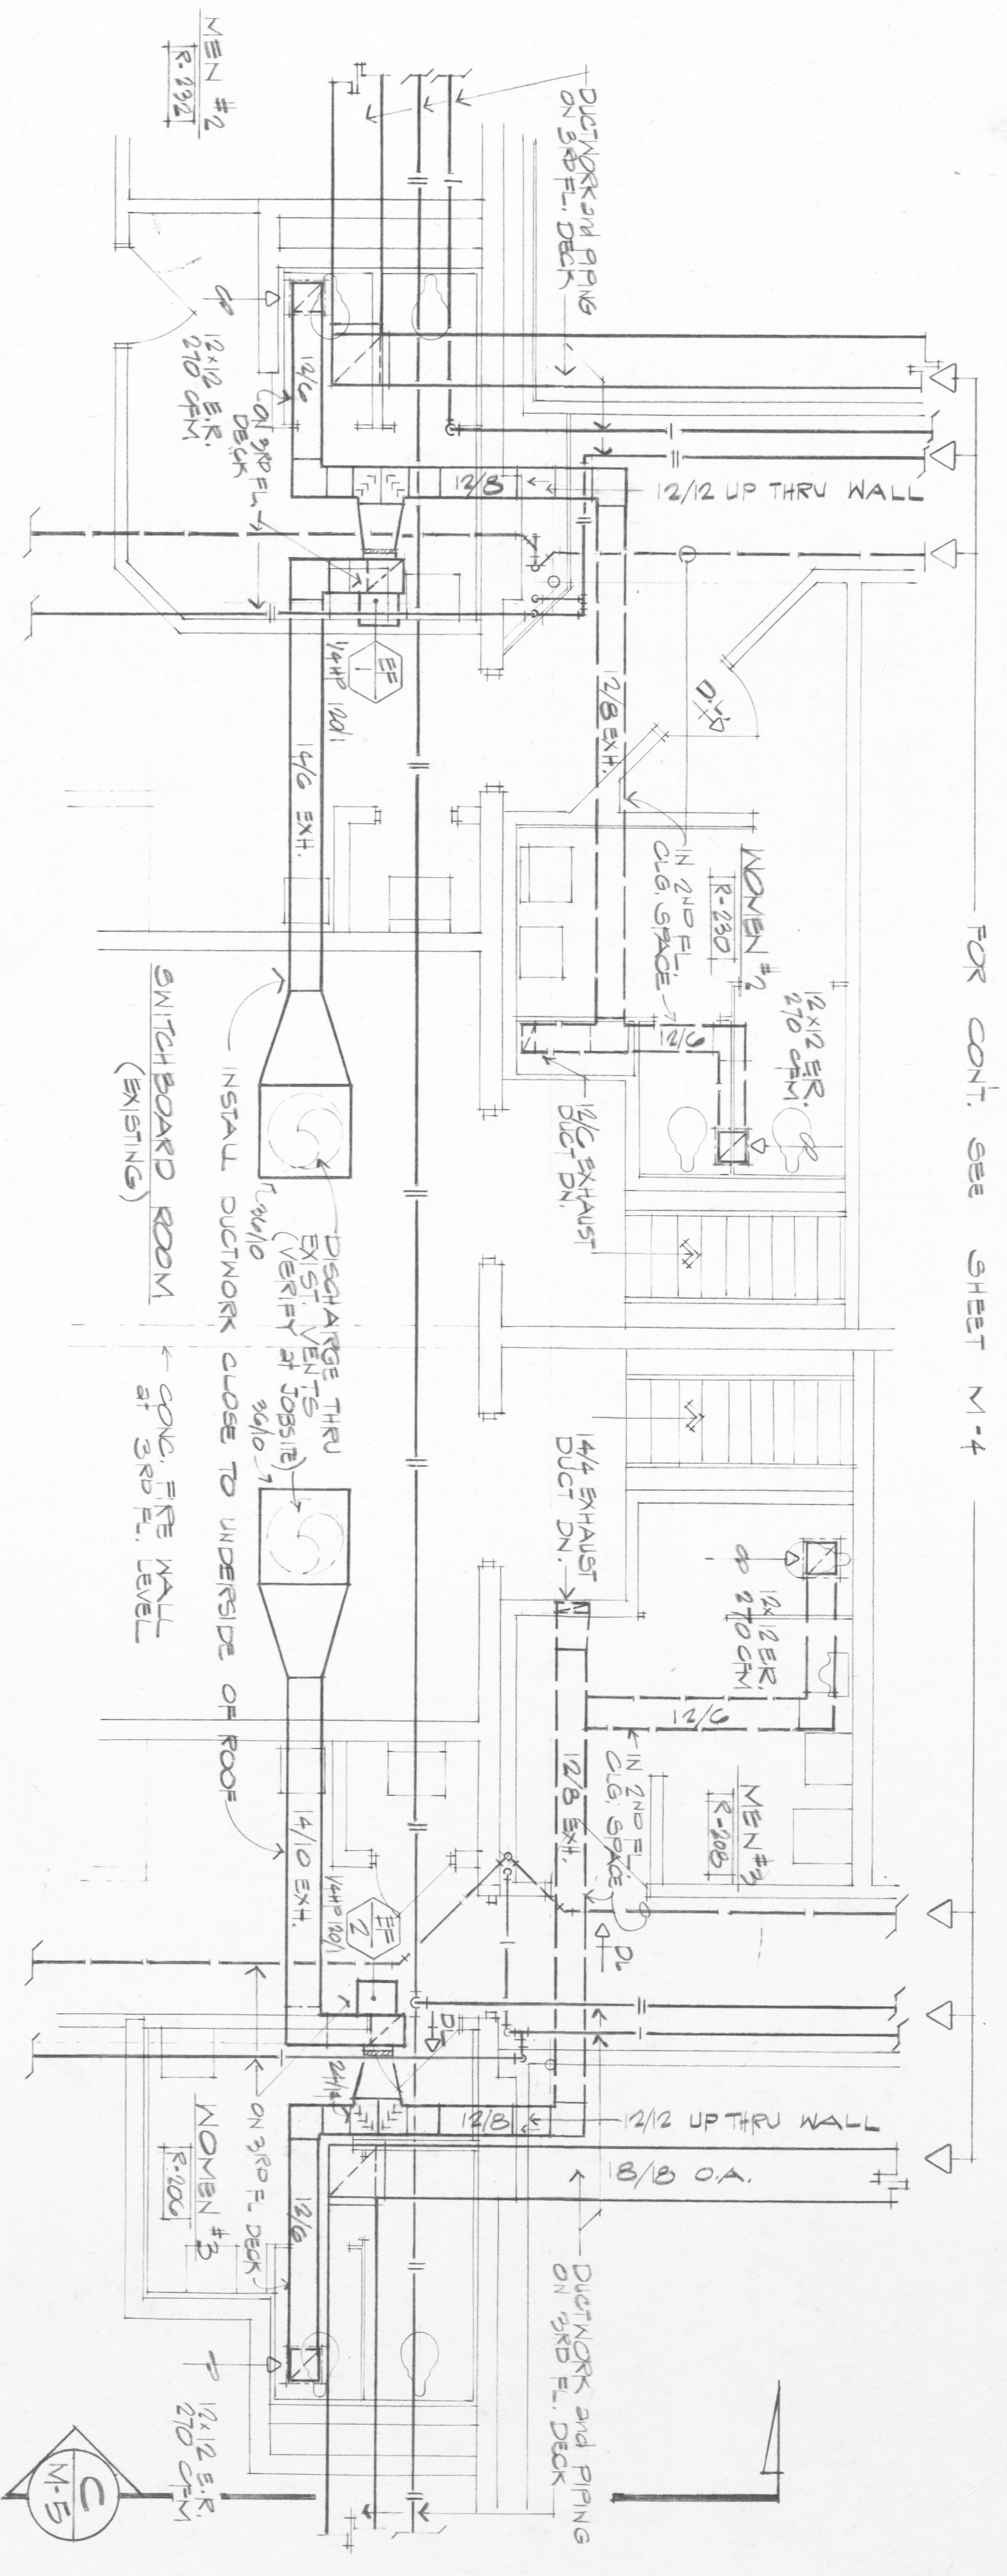


2 SECOND FLOOR TOILETS VENTILATION PLAN
SCALE: 1/4" = 1'-0"

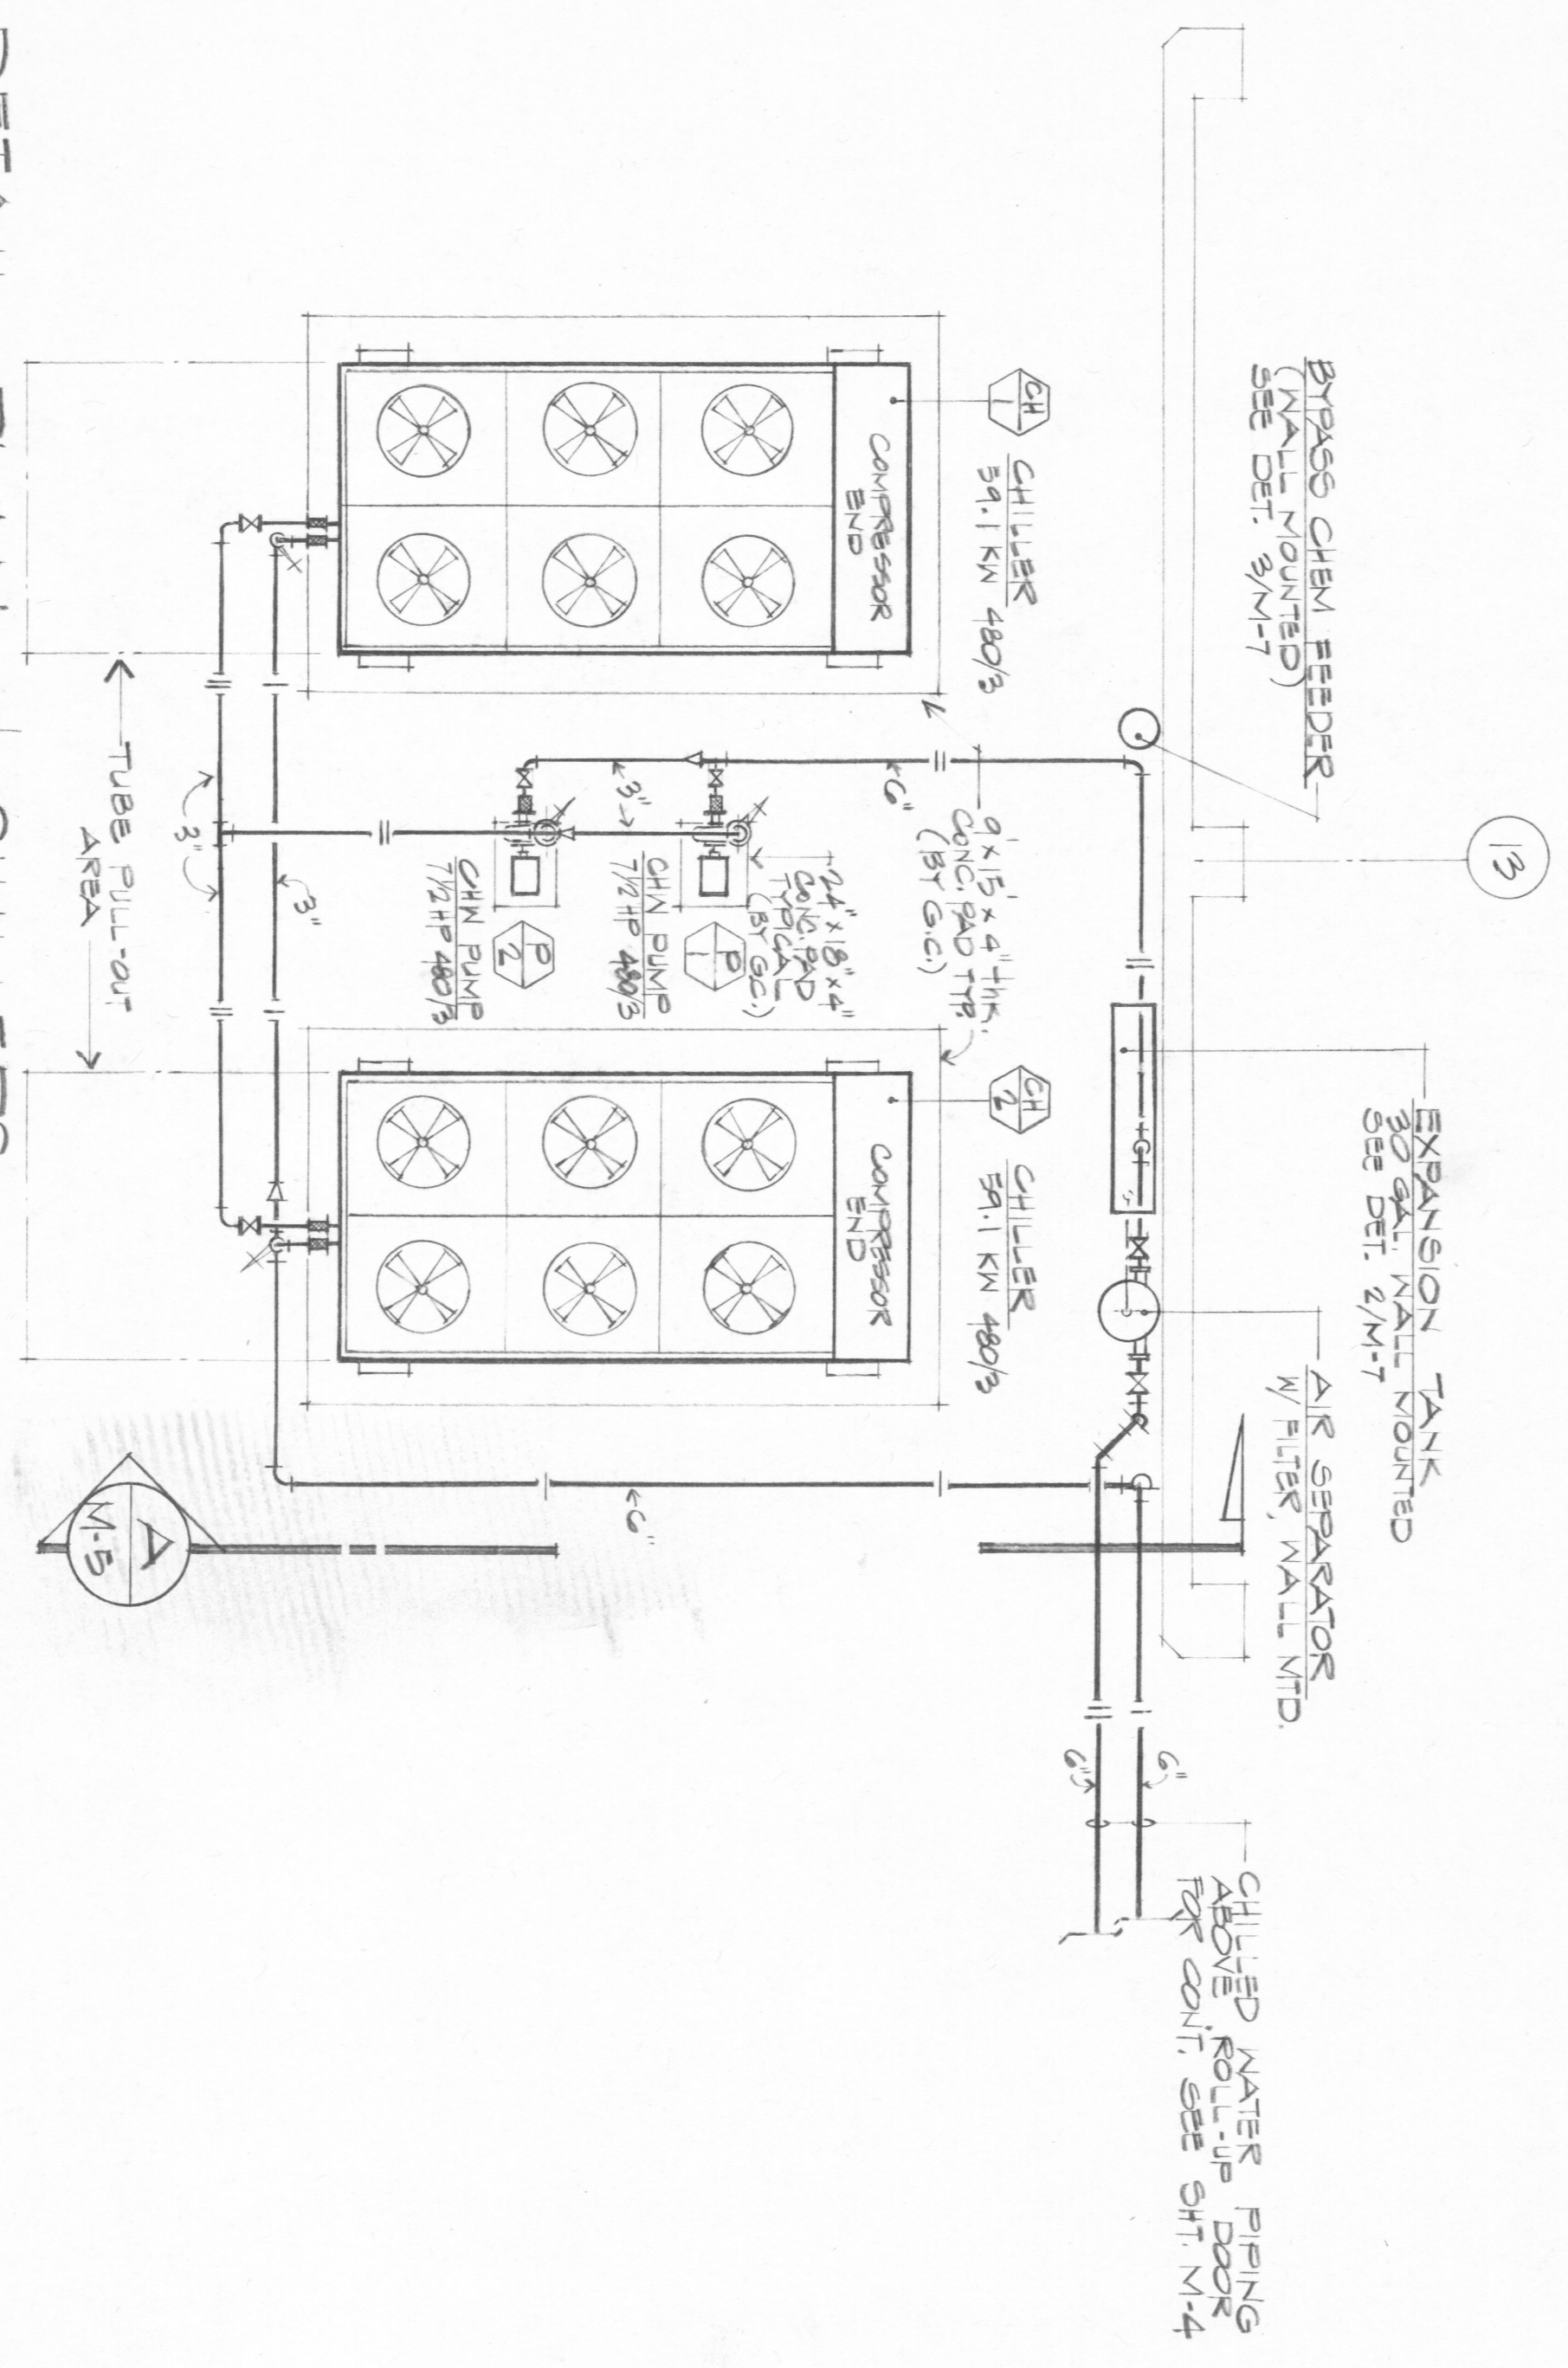


3 DETAIL PLAN OF CHILLERS
SCALE: 1/4" = 1'-0"

NOTE:
ALL OUTDOOR EQUIPMENT AND PIPING SHALL
ONLY BE INSTALLED NOT EARLIER THAN JUNE 1980.
SEE SHEET M-4.

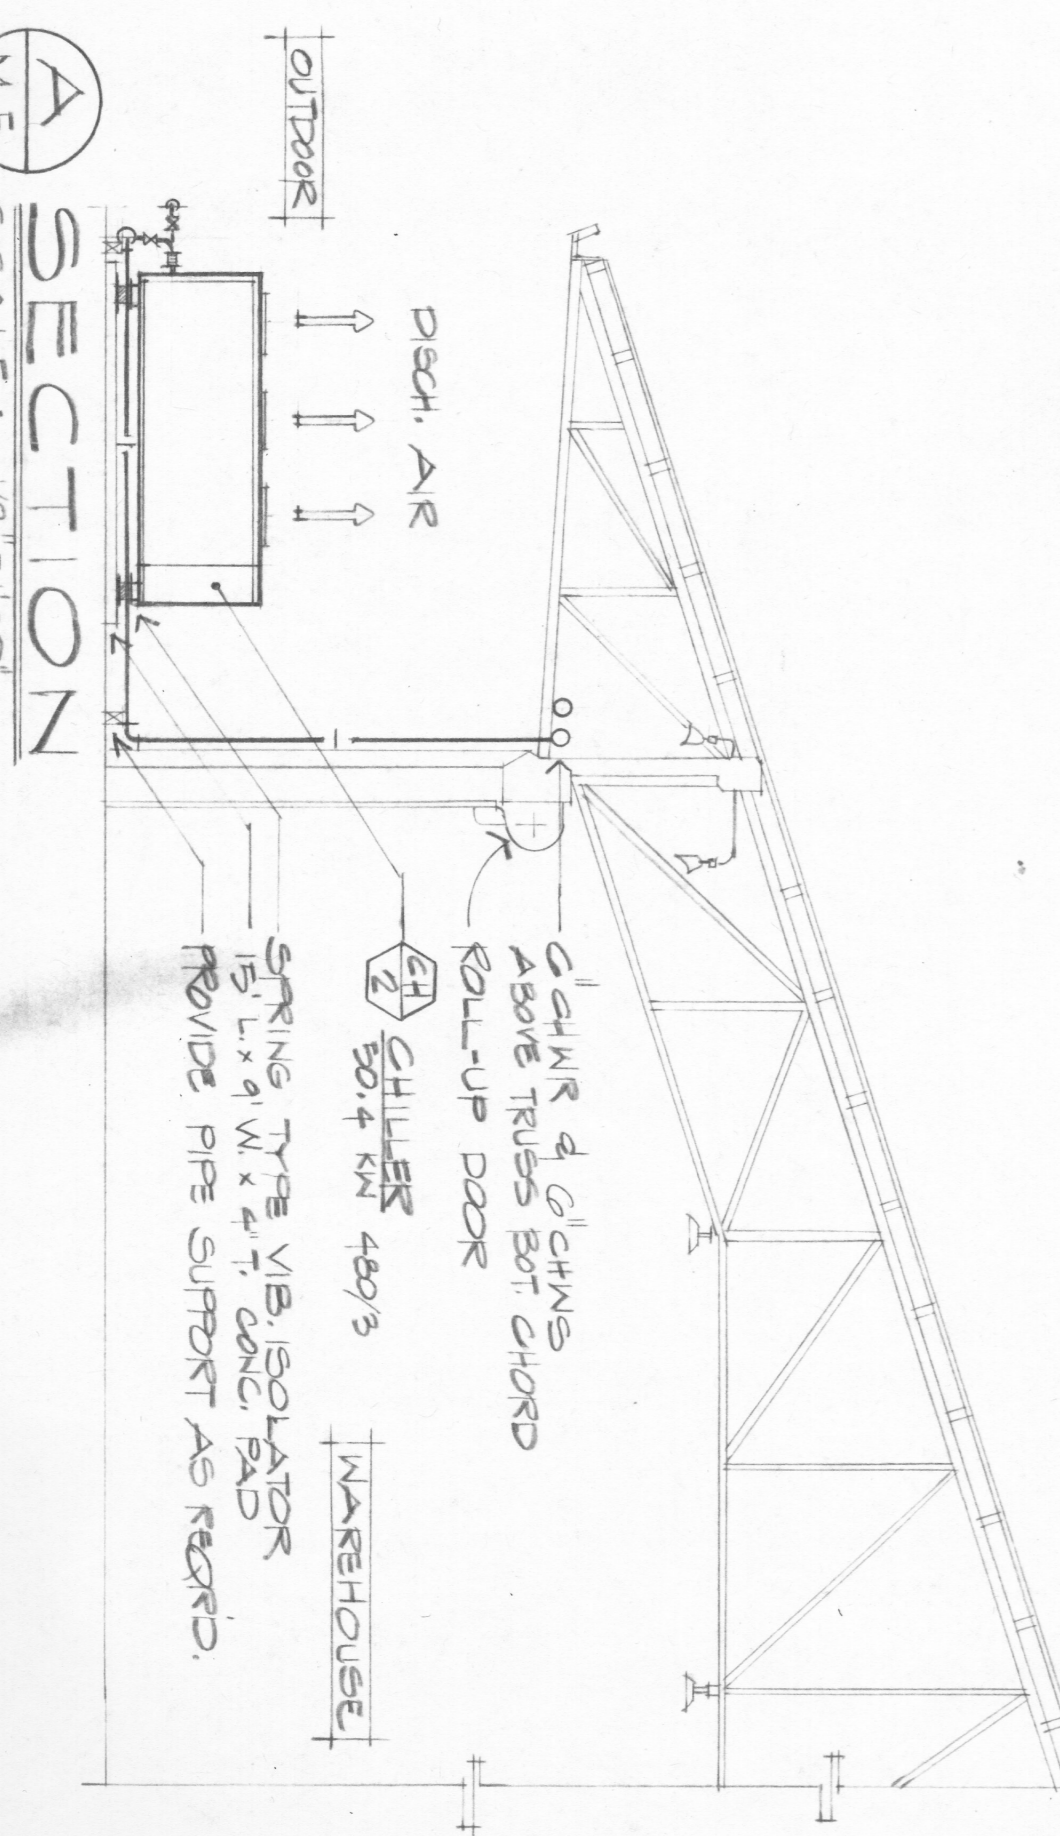

A SECTION
SCALE: 1/8" = 1'-0"

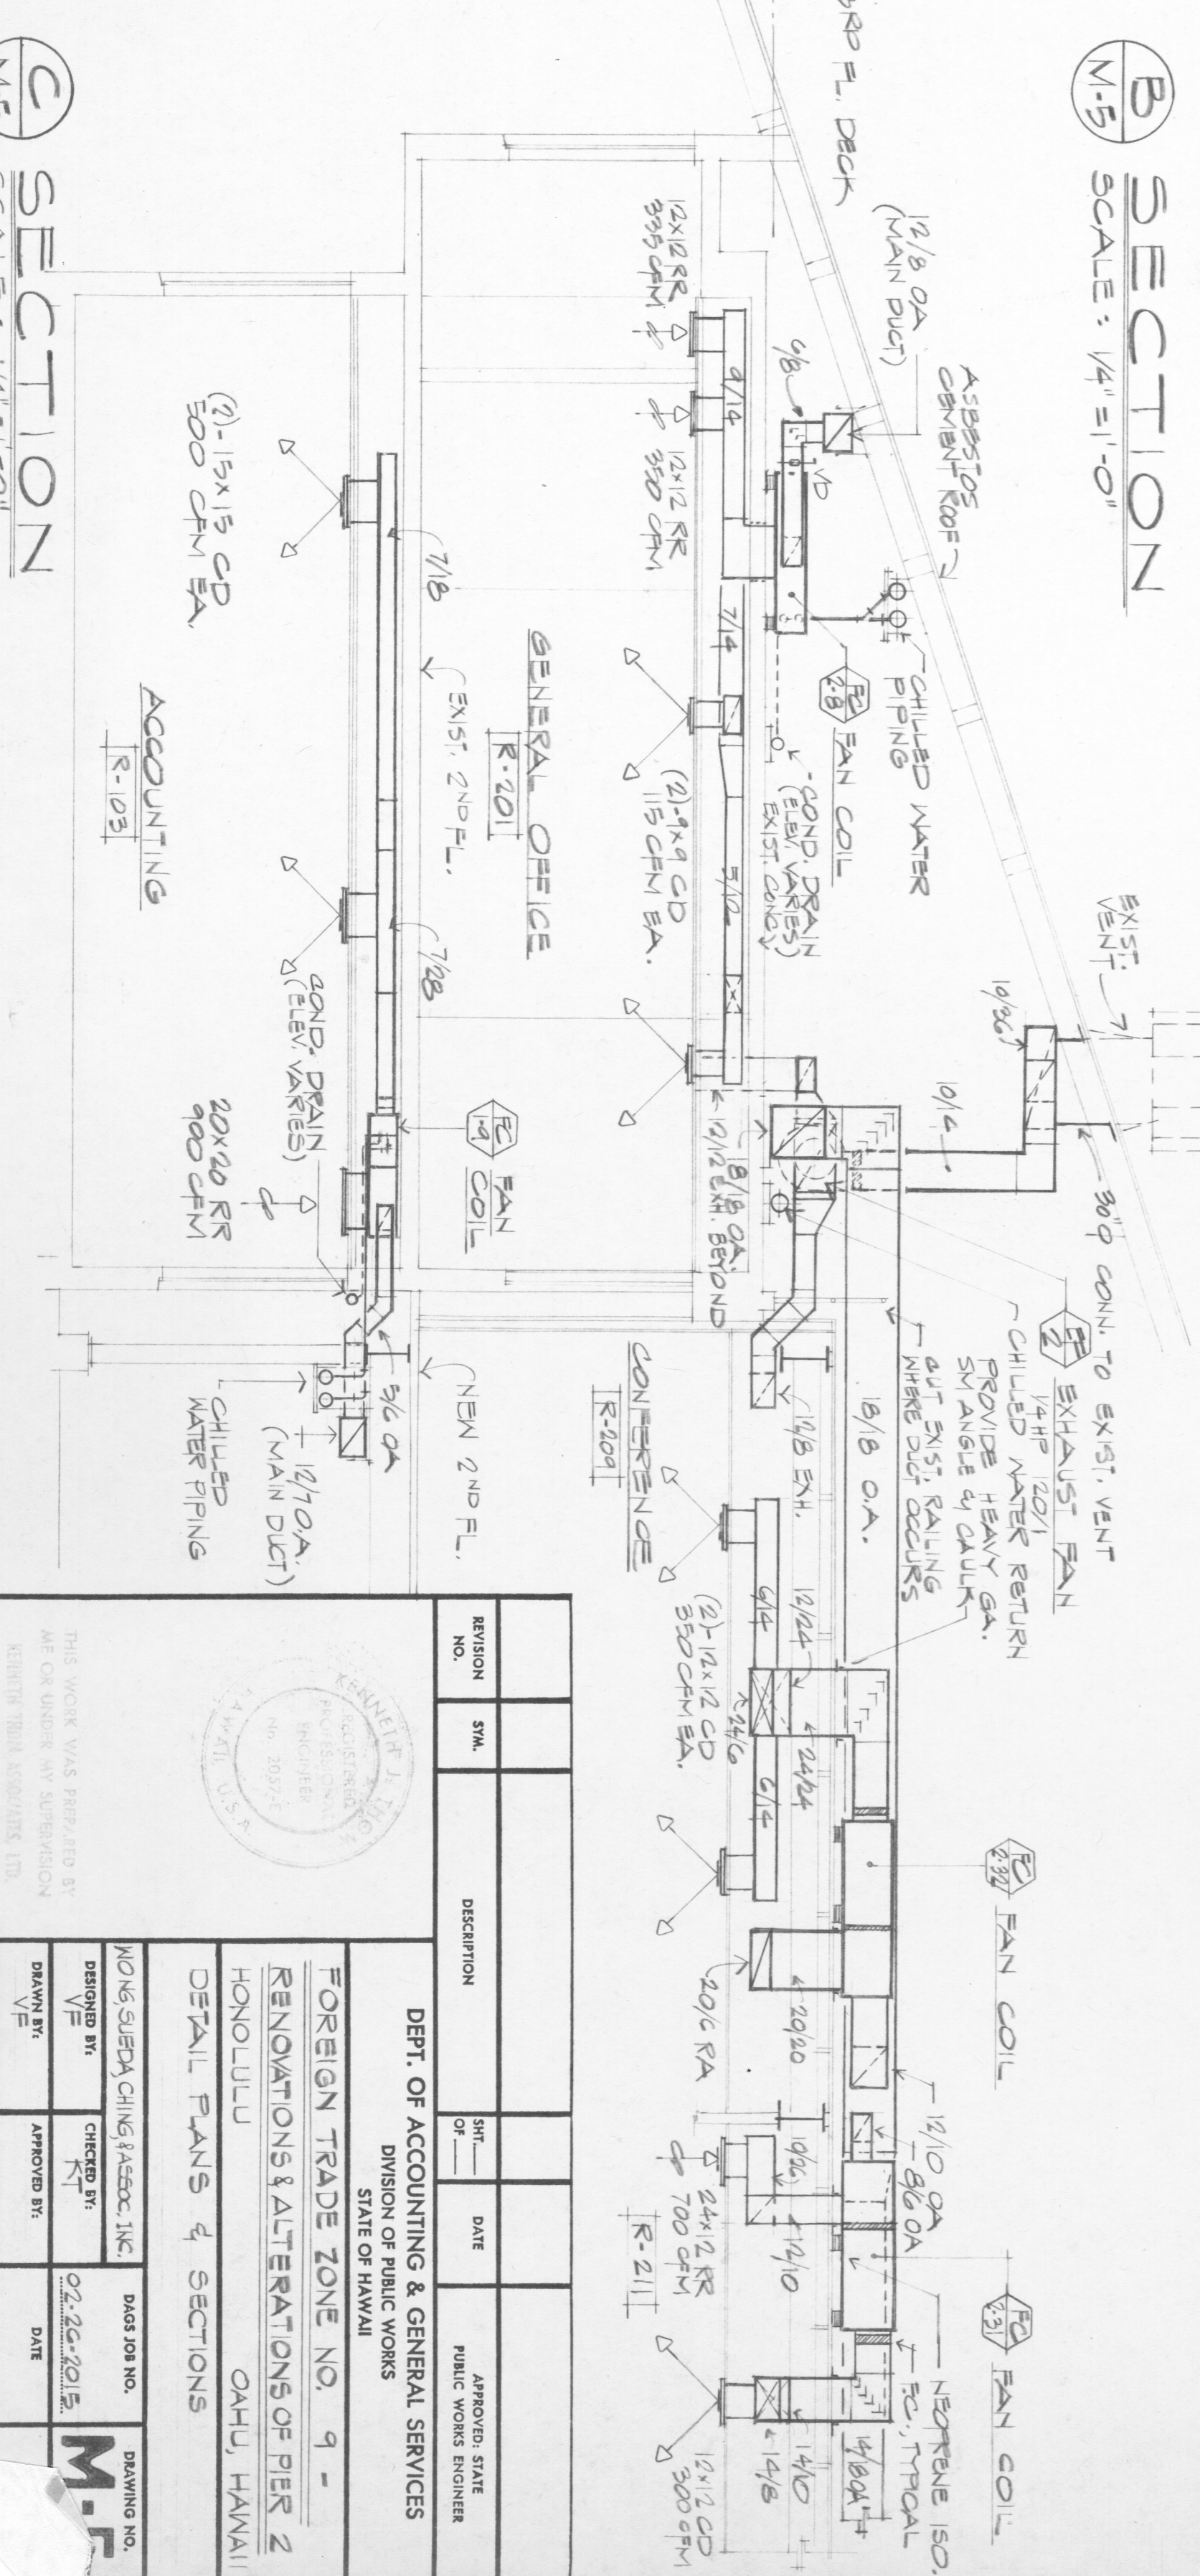

B SECTION
SCALE: 1/4" = 1'-0"

C SECTION
SCALE: 1/4" = 1'-0"

REGION NO.	SYN.	REVISION	DATE	APPROVED STATE
				MARKED WITH SIGNATURE
DEPT. OF ACCOUNTING & GENERAL SERVICES				
DIVISION OF PUBLIC WORKS				
STATE OF HAWAII				
FOREIGN TRADE ZONE NO. 9 -				
RENOVATIONS ALTERATIONS OF PER 2				
HONOLULU				
DETAIL PLANS & SECTIONS				
WORKSHEET NO.	DATE	SCALE	PROJECT NO.	PROJECT NAME
100	02.26.2015	AS NOTED		
DESIGNED BY	CHECKED BY	DATE	APPROVED BY	DATE
M.F.				