




REVISIONS	BY

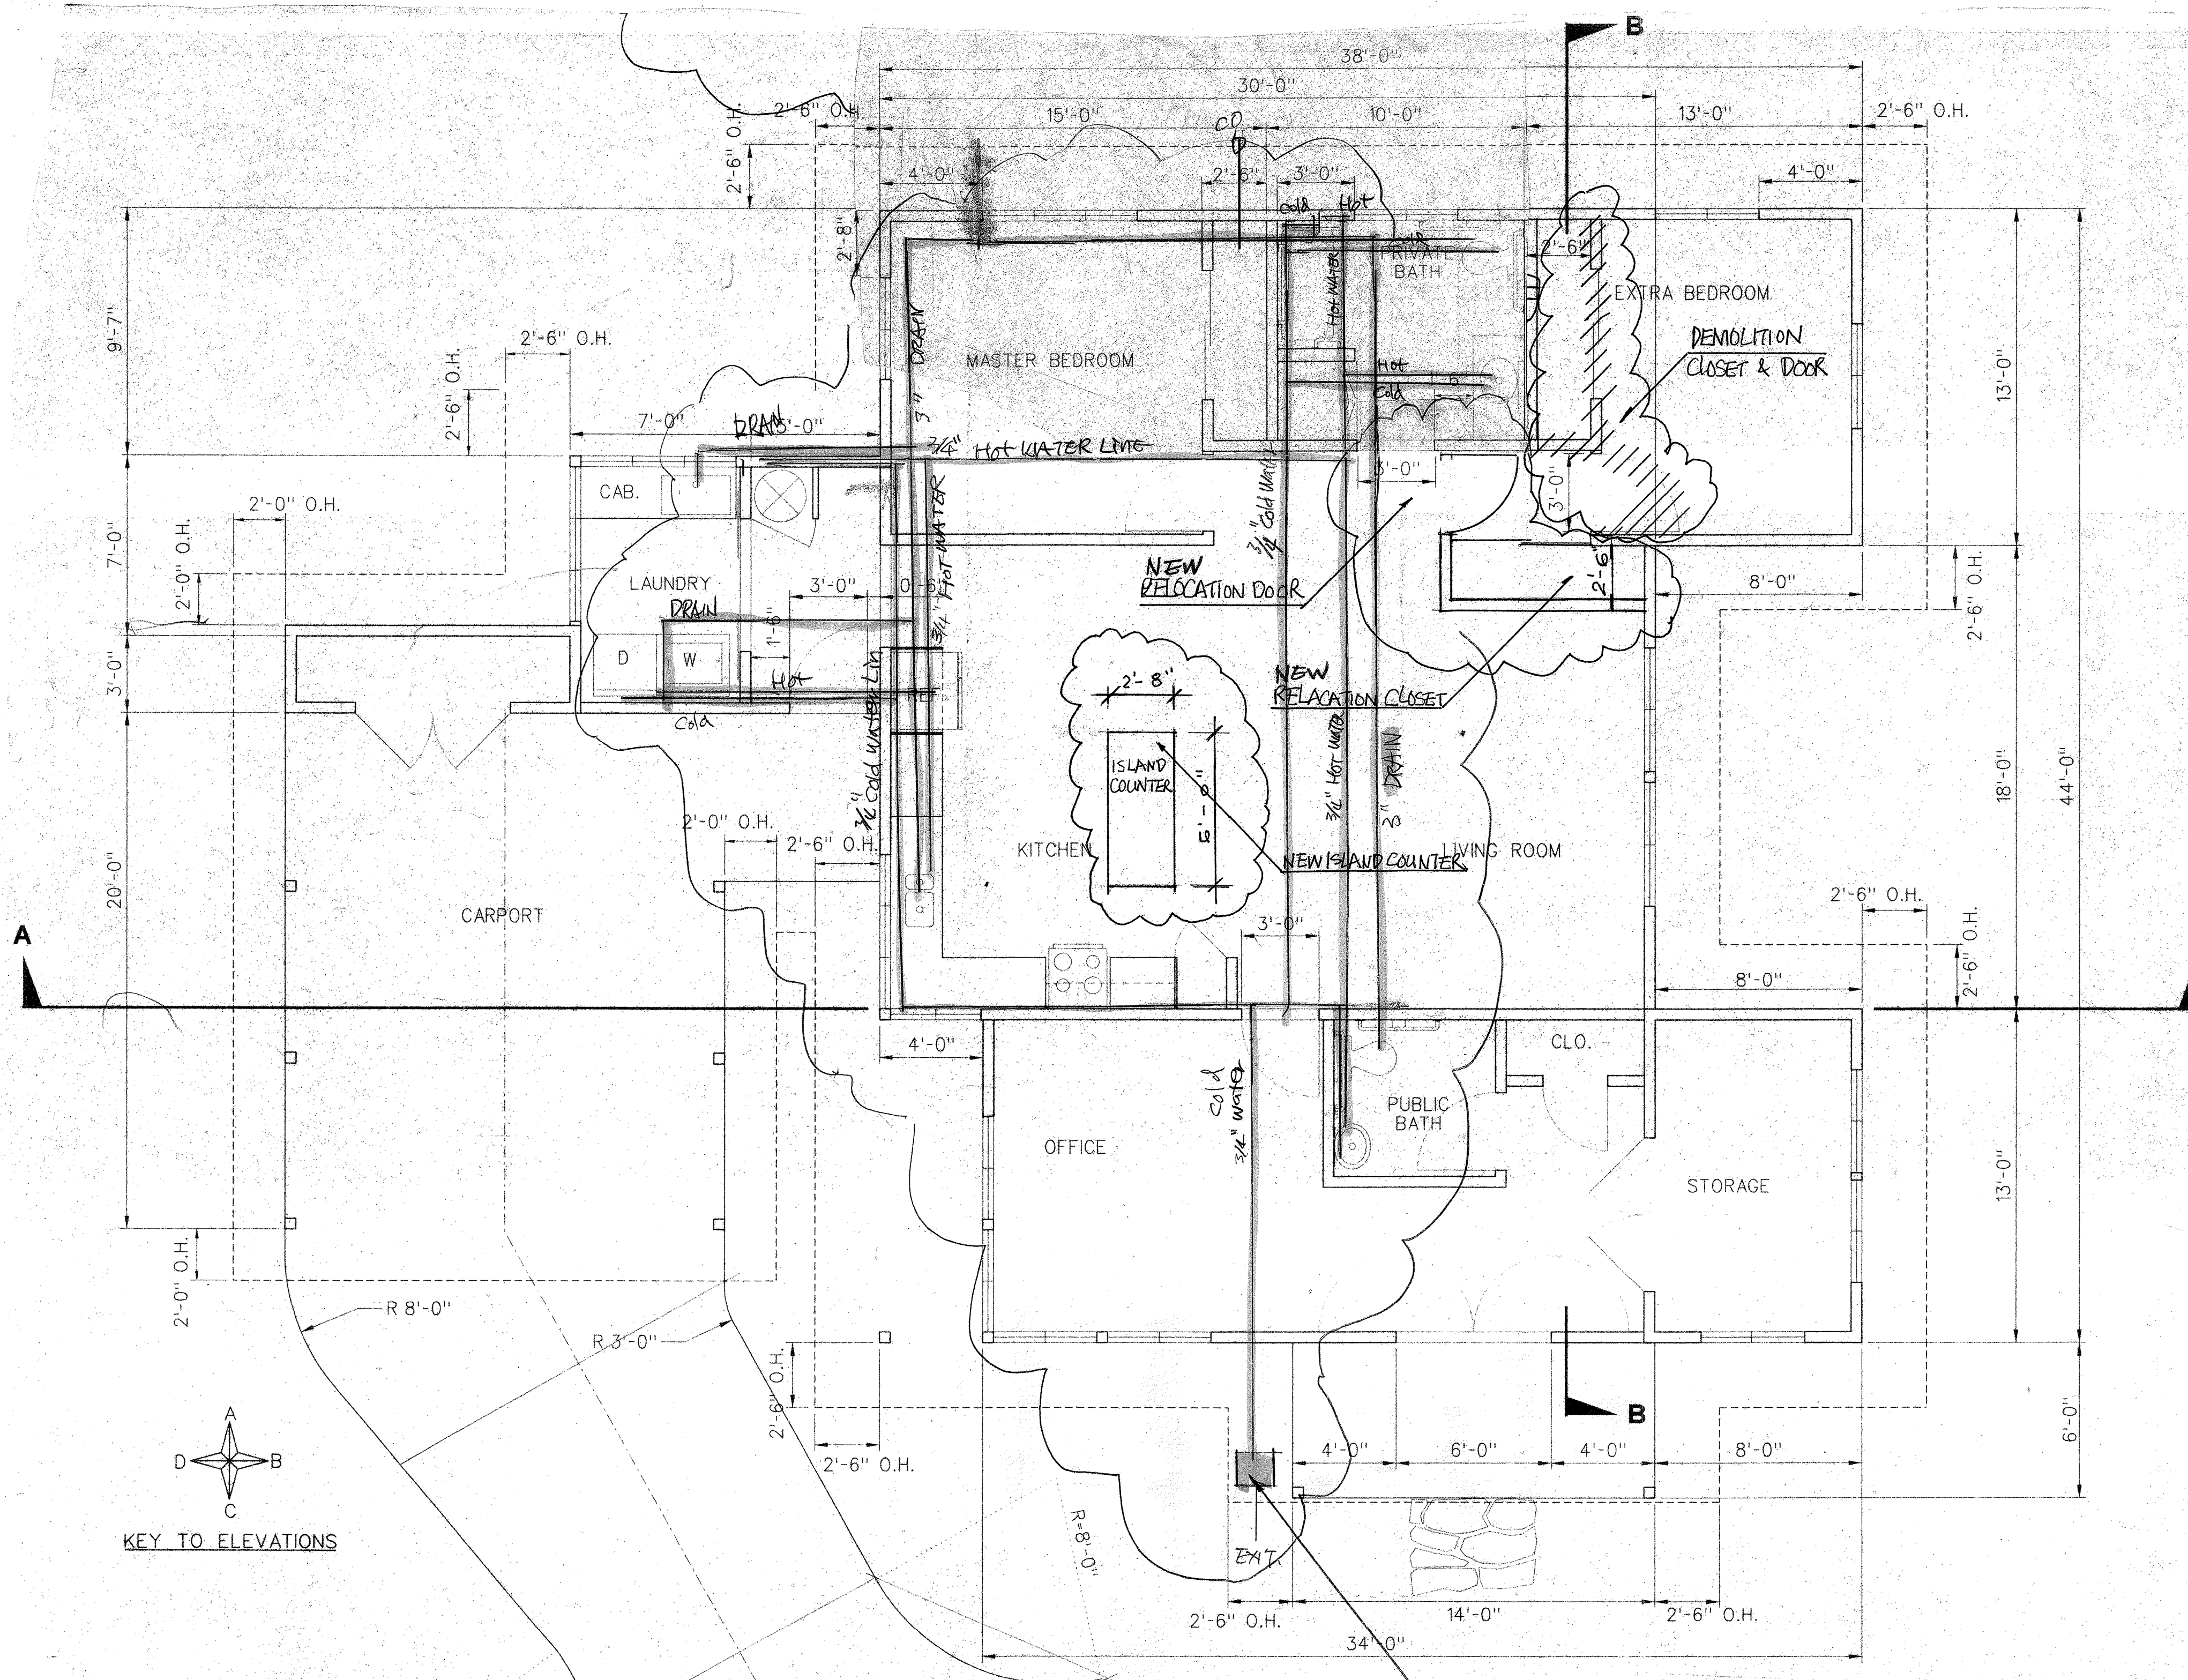


PLUMBING & FLOOR PLAN
SCALE: 1/4" = 1'-0"

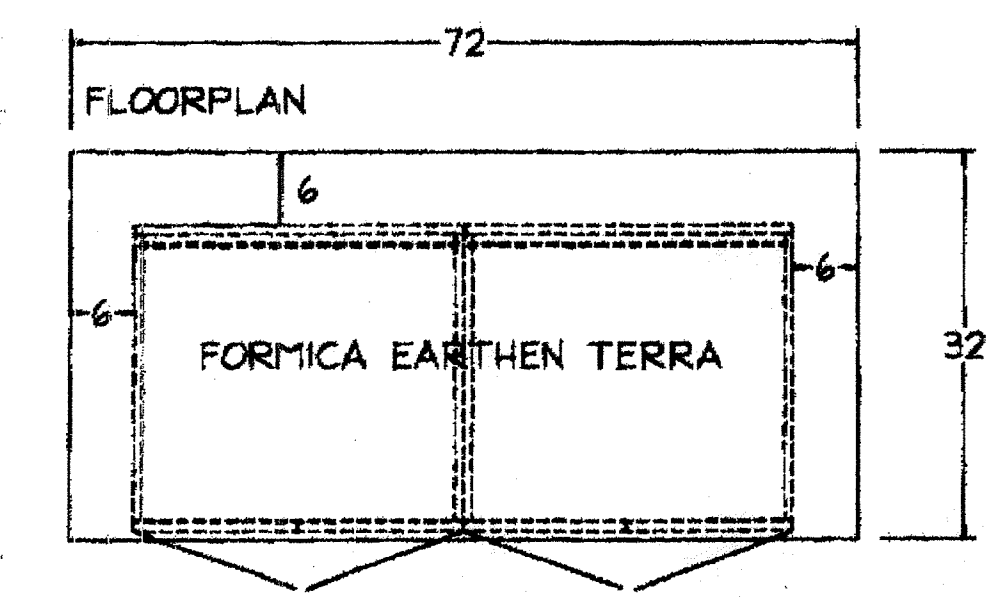


CURATORS RESIDENCE ISLAND CABINET

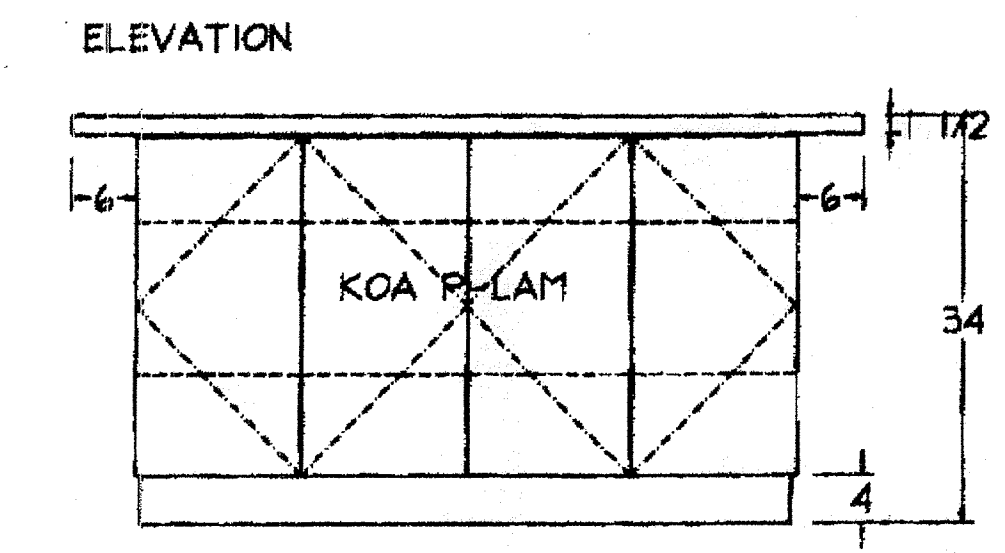

NEW ISLAND COUNTER

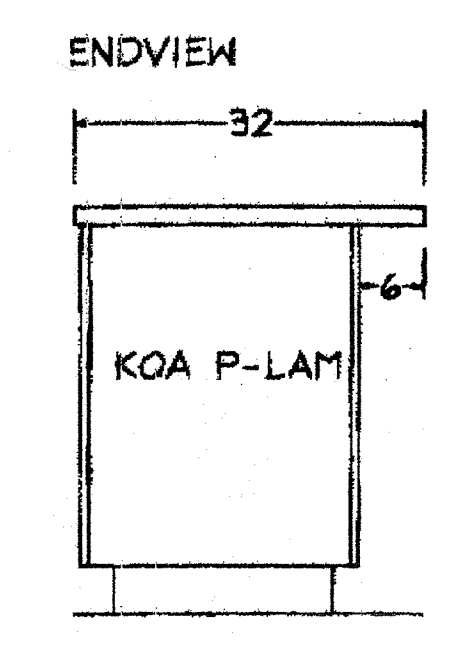

ENDVIEW

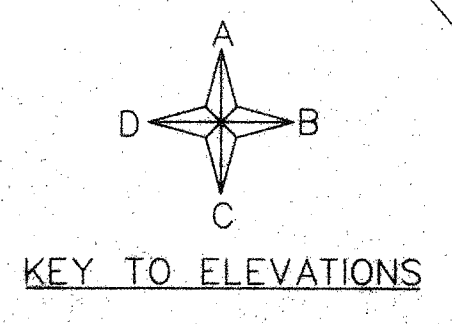


AS BUILT DRAWING
BY 57 BUILDERS LTD


STATE OF HAWAII
DEPARTMENT OF LAND AND NATURAL RESOURCES
ENGINEERING BRANCH, LAND DIVISION
CONSTRUCTION OF CURATOR'S RESIDENCE
ROYAL MAUSOLEUM STATE MONUMENT

Date 6/4/2004
Scale
Drawn J.
Job
Sheet
AS BUILT
Of 3 Sheets

REVISIONS	BY

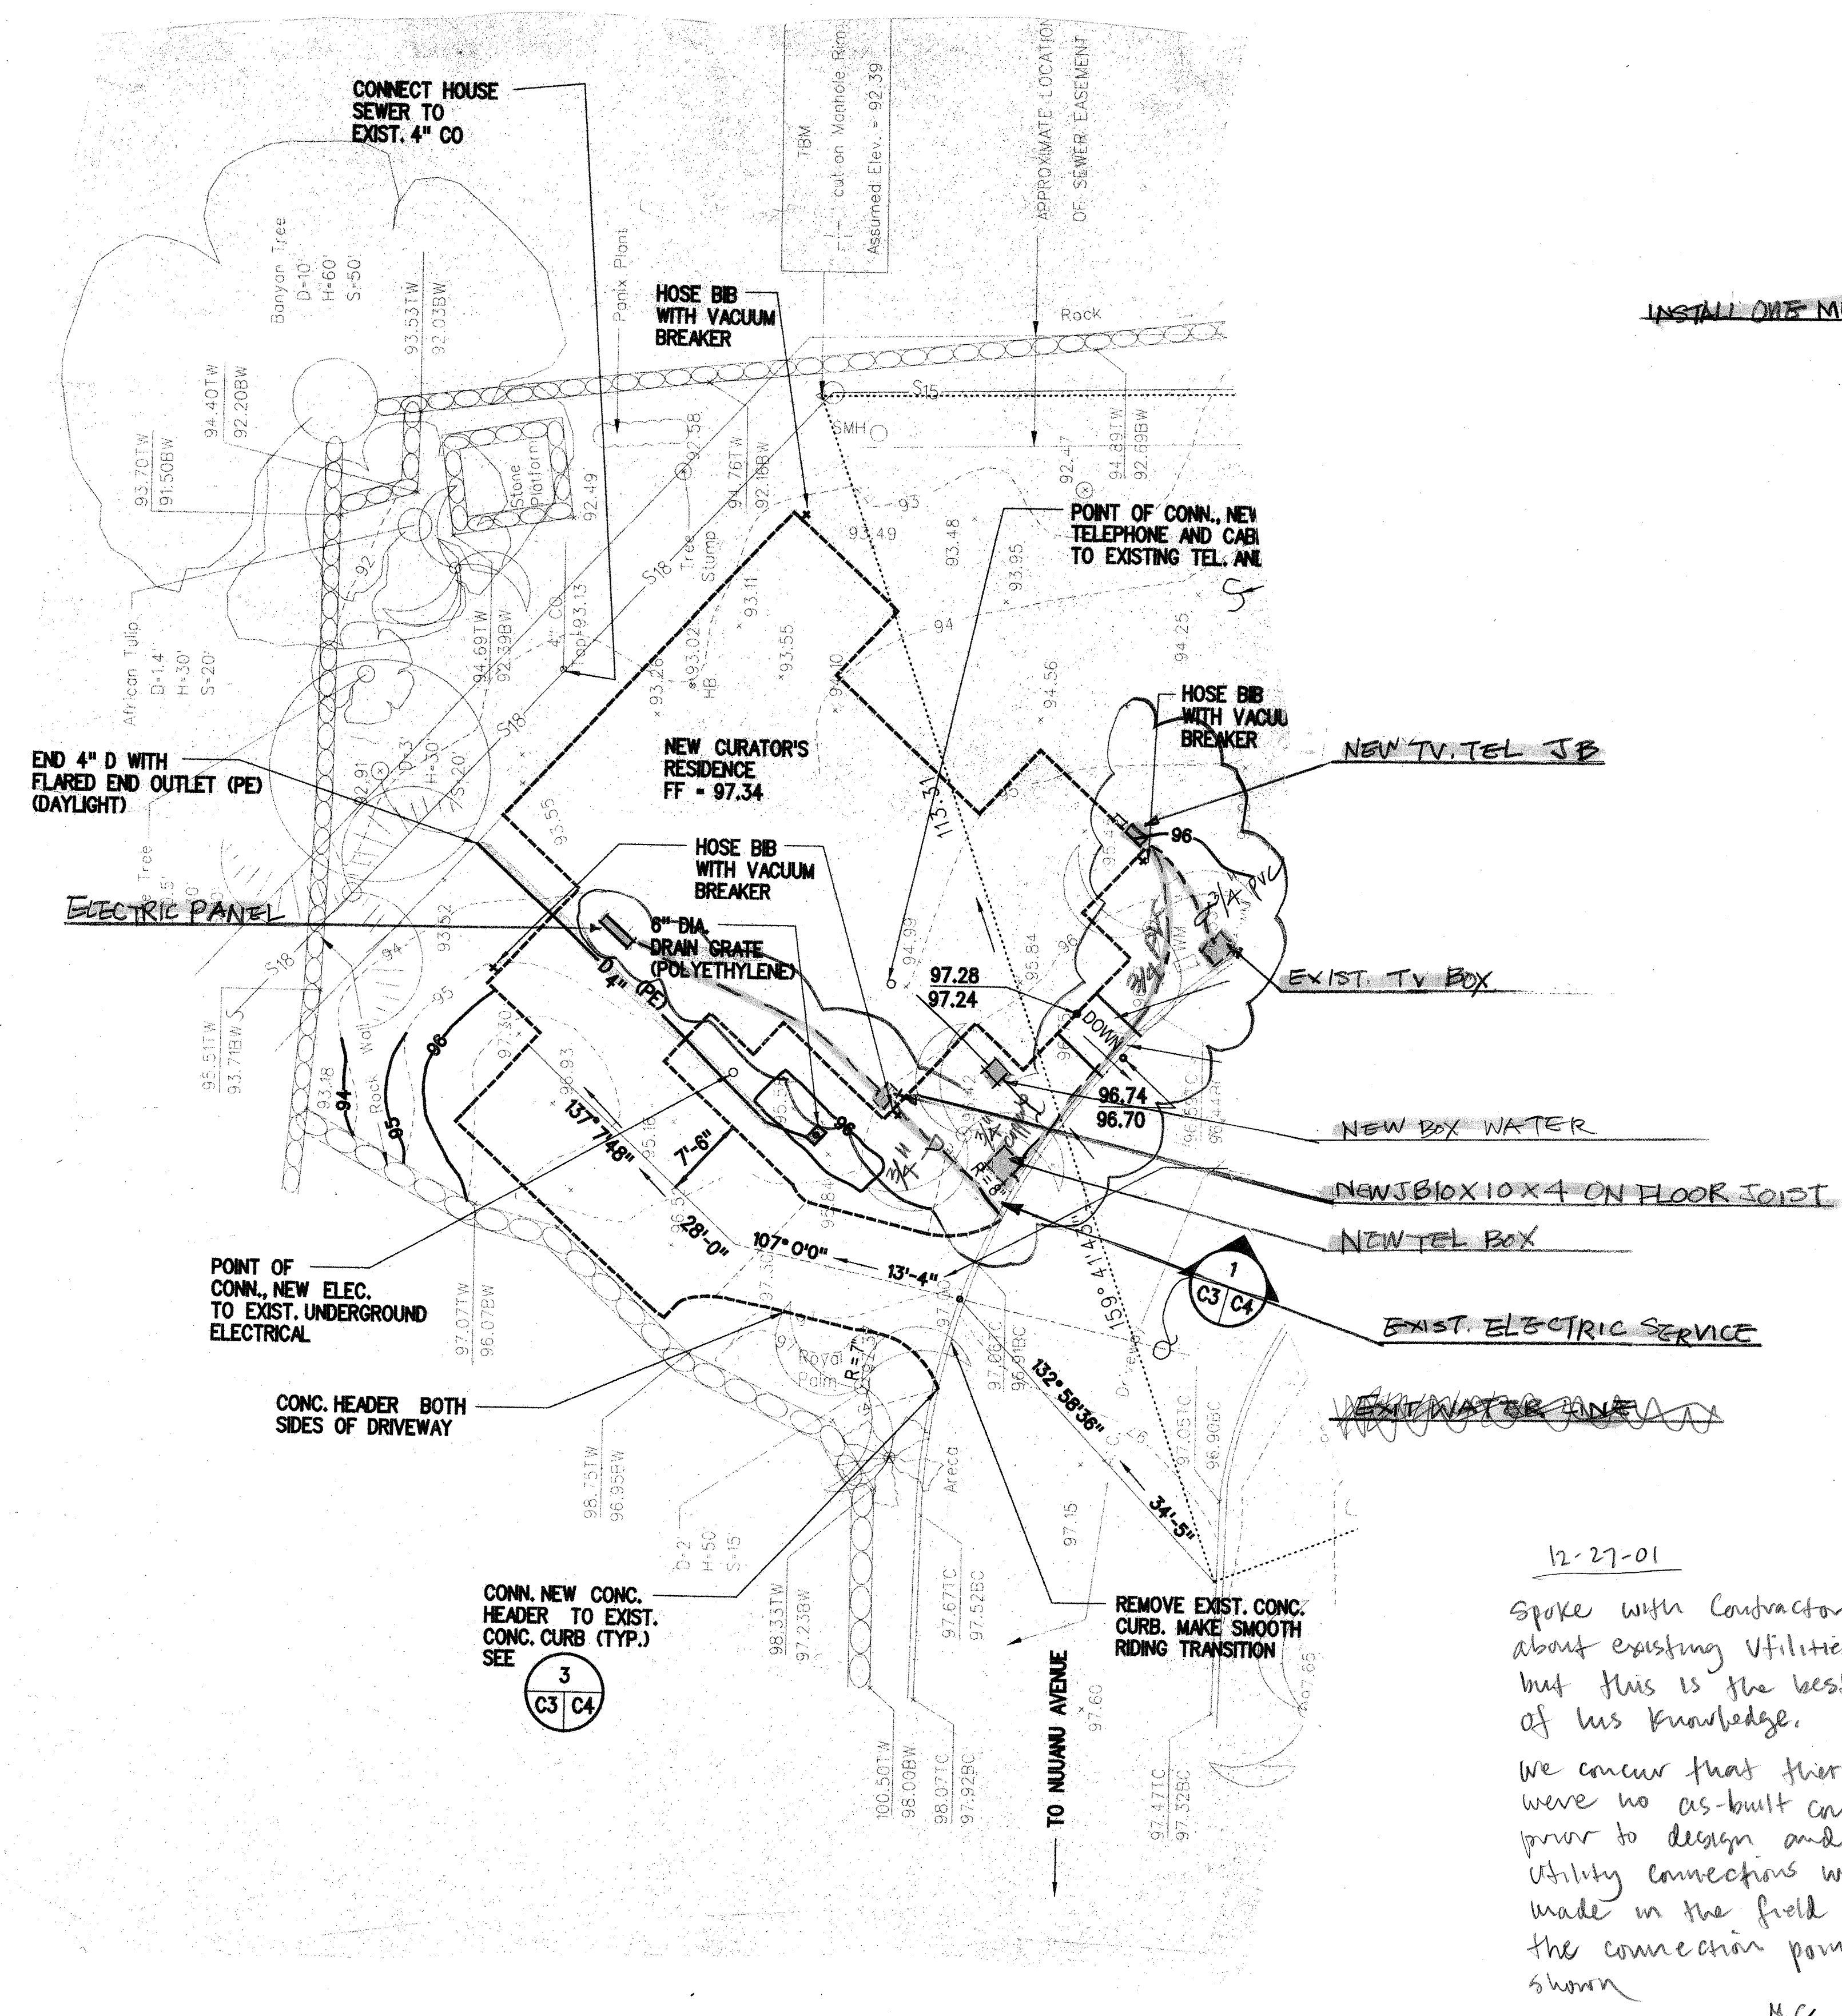

12-27-01
 Spoke with Contractor about existing utilities but this is the best of his knowledge. We ensure that there were no as-built conditions prior to design and utility connections were made in the field at the connection points shown
 MC

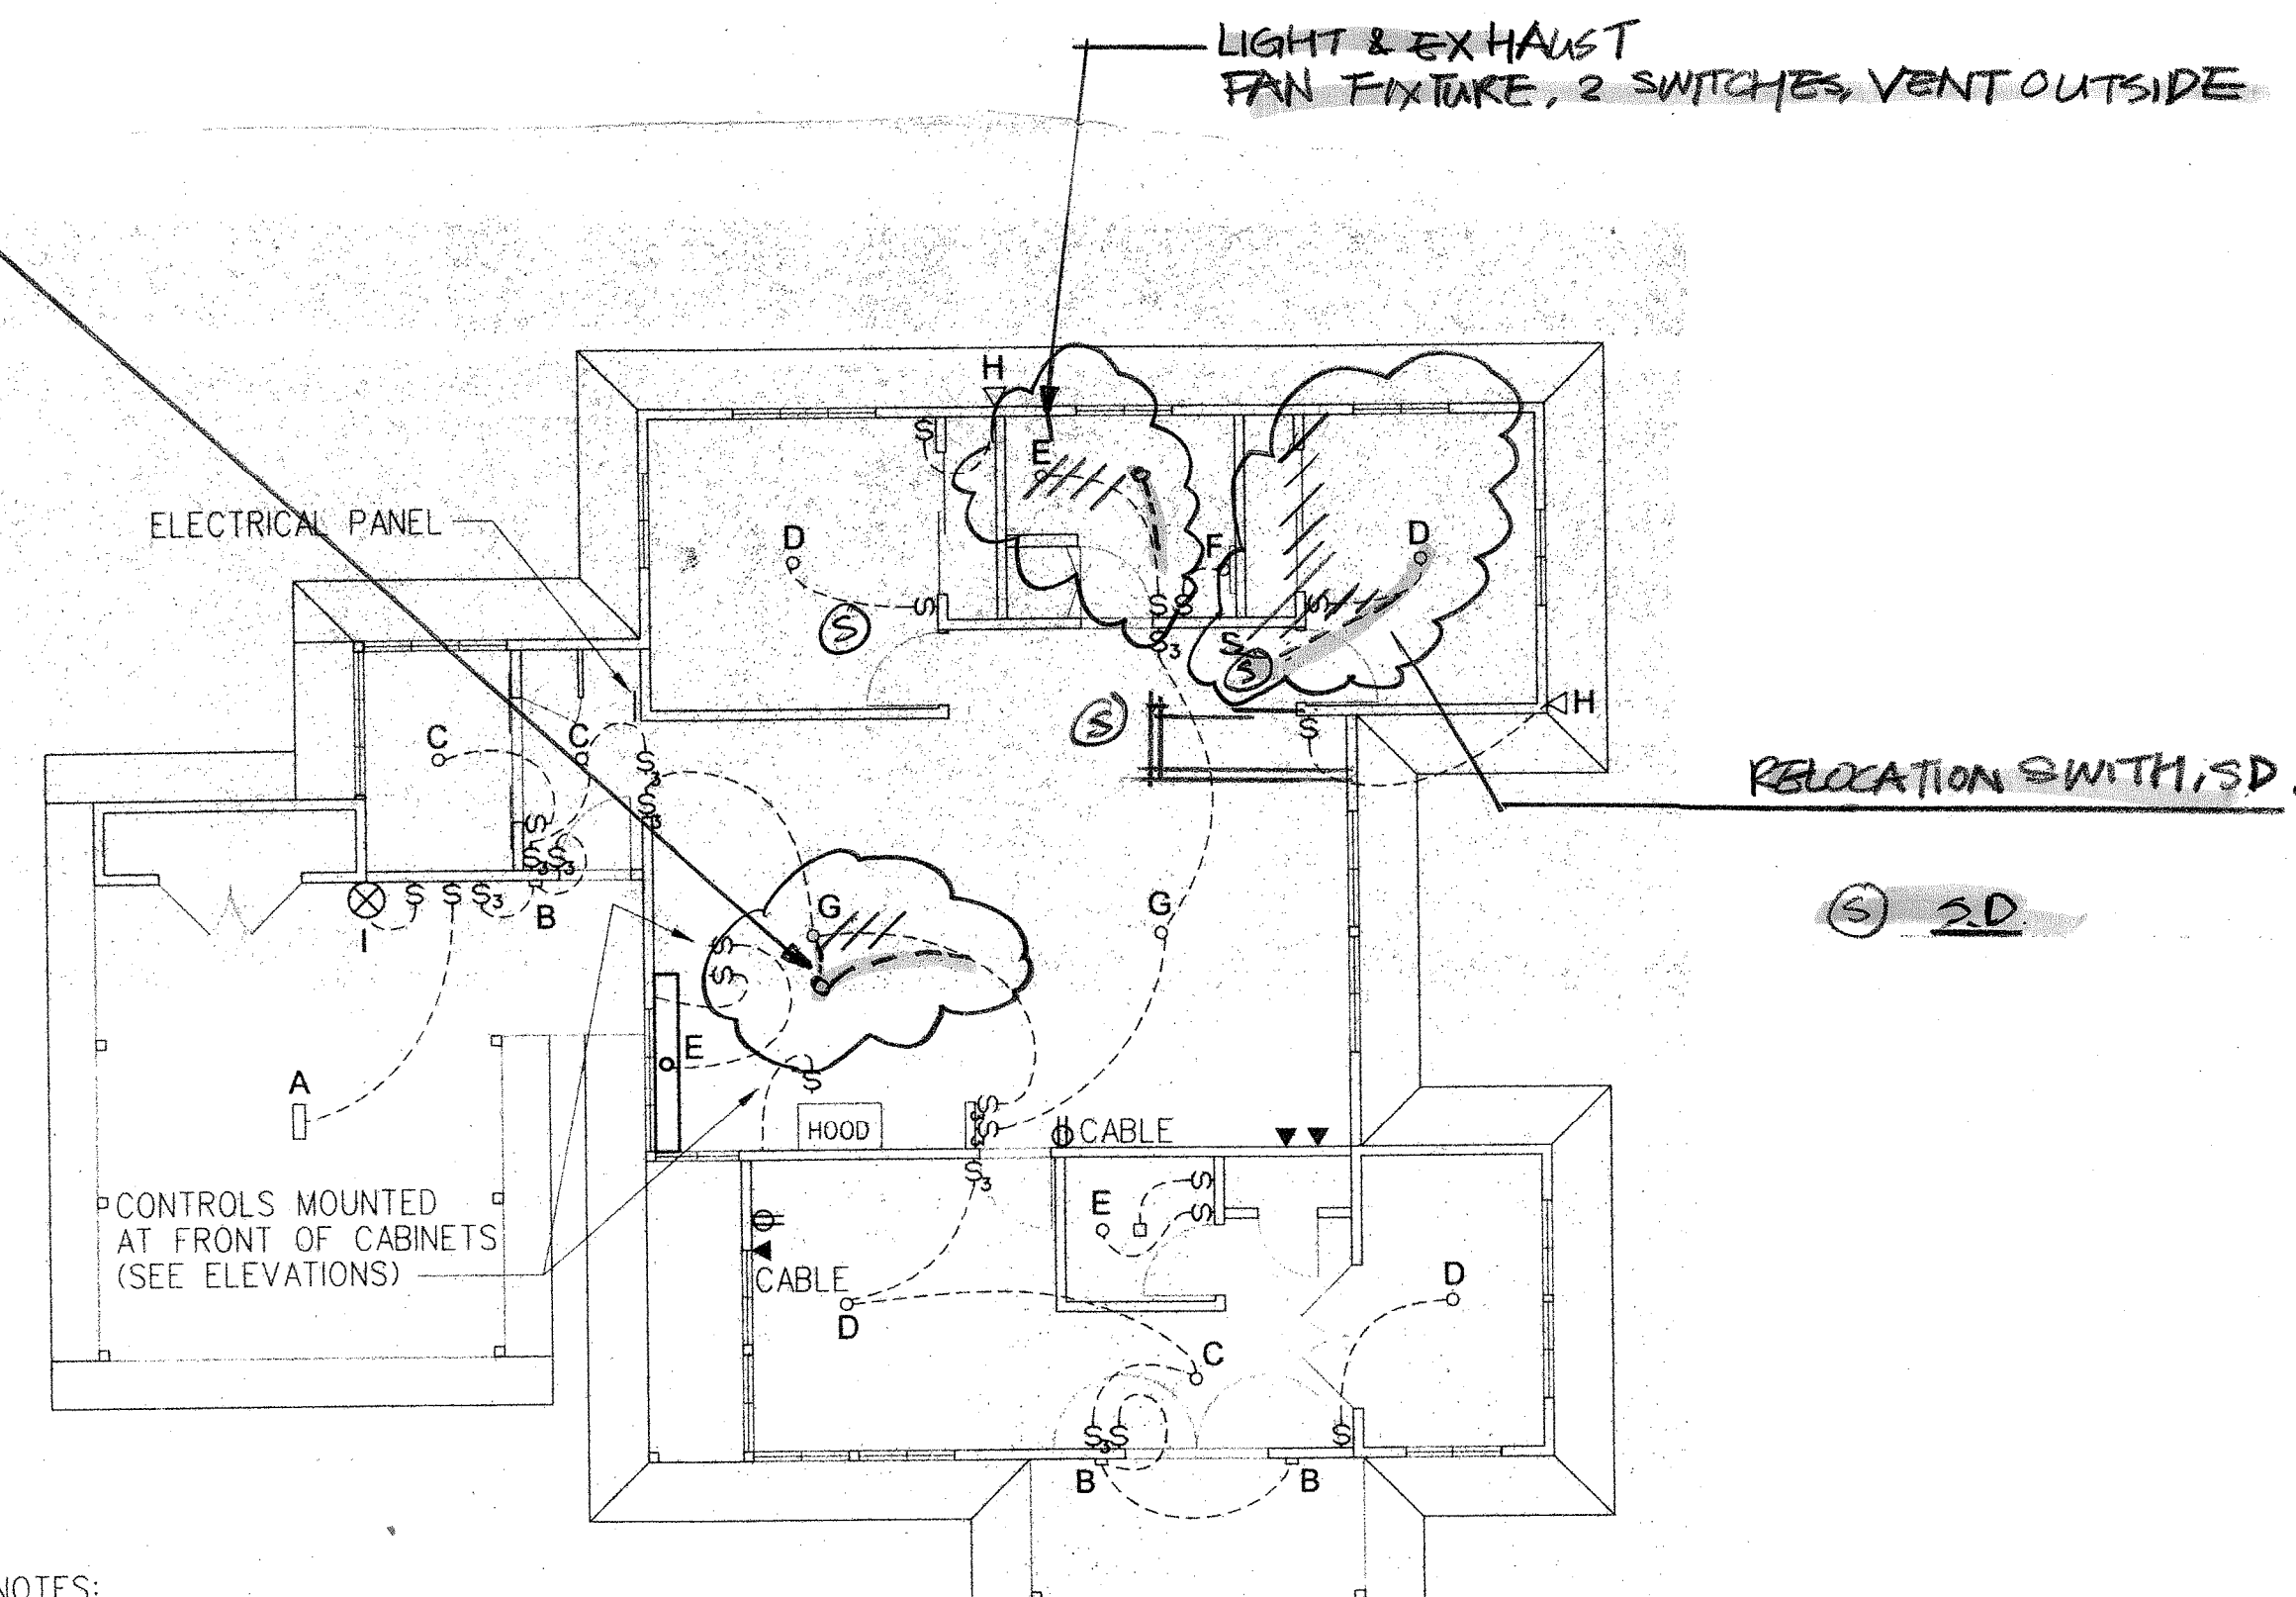

- NOTES:
1. ALL ELECTRIC OUTLETS MOUNTED MIN. 15" ABOVE GROUND.
 2. ALL LIGHT SWITCHES SHALL BE ROCKER TYPE MOUNTED AT MAX. 48" ABOVE GROUND.
 3. KITCHEN SWITCHES (DISPOSAL, OVERSINK LIGHT, HOOD CONTROLS MOUNTED AT FRONT OF CABINETS)
 4. ELECTRICAL WORK SHALL COMPLY WITH ALL FEDERAL, STATE AND LOCAL CODES, REGULATIONS, ORDINANCES AND THE NATIONAL ELECTRICAL CODE.
 5. PROVIDE ELECTRICAL PANEL BOX SIZED TO FIT NO LESS THAN 20 POLE.
 6. G.F.I. IN RESTROOM & KITCHEN AREAS, TYP.
 7. ENGINEER SHALL APPROVE ALL ELECTRICAL SWITCHES, RECEPTACLES & COVER PLATES.

ELECTRICAL PLAN
 SCALE: 1/8" = 1'-0"

AS BUILT DRAWING
 BY 57 BUILDERS LTD

STATE OF HAWAII
 DEPARTMENT OF LAND AND NATURAL RESOURCES
 ENGINEERING BRANCH, LAND DIVISION
 CONSTRUCTION OF CURATOR'S RESIDENCE
 ROYAL MAUSOLEUM STATE MONUMENT

Date	12/1/2001
Scale	
Drawn	Ji
Job	
Sheet	AS BUILT
Of	3 Sheets