


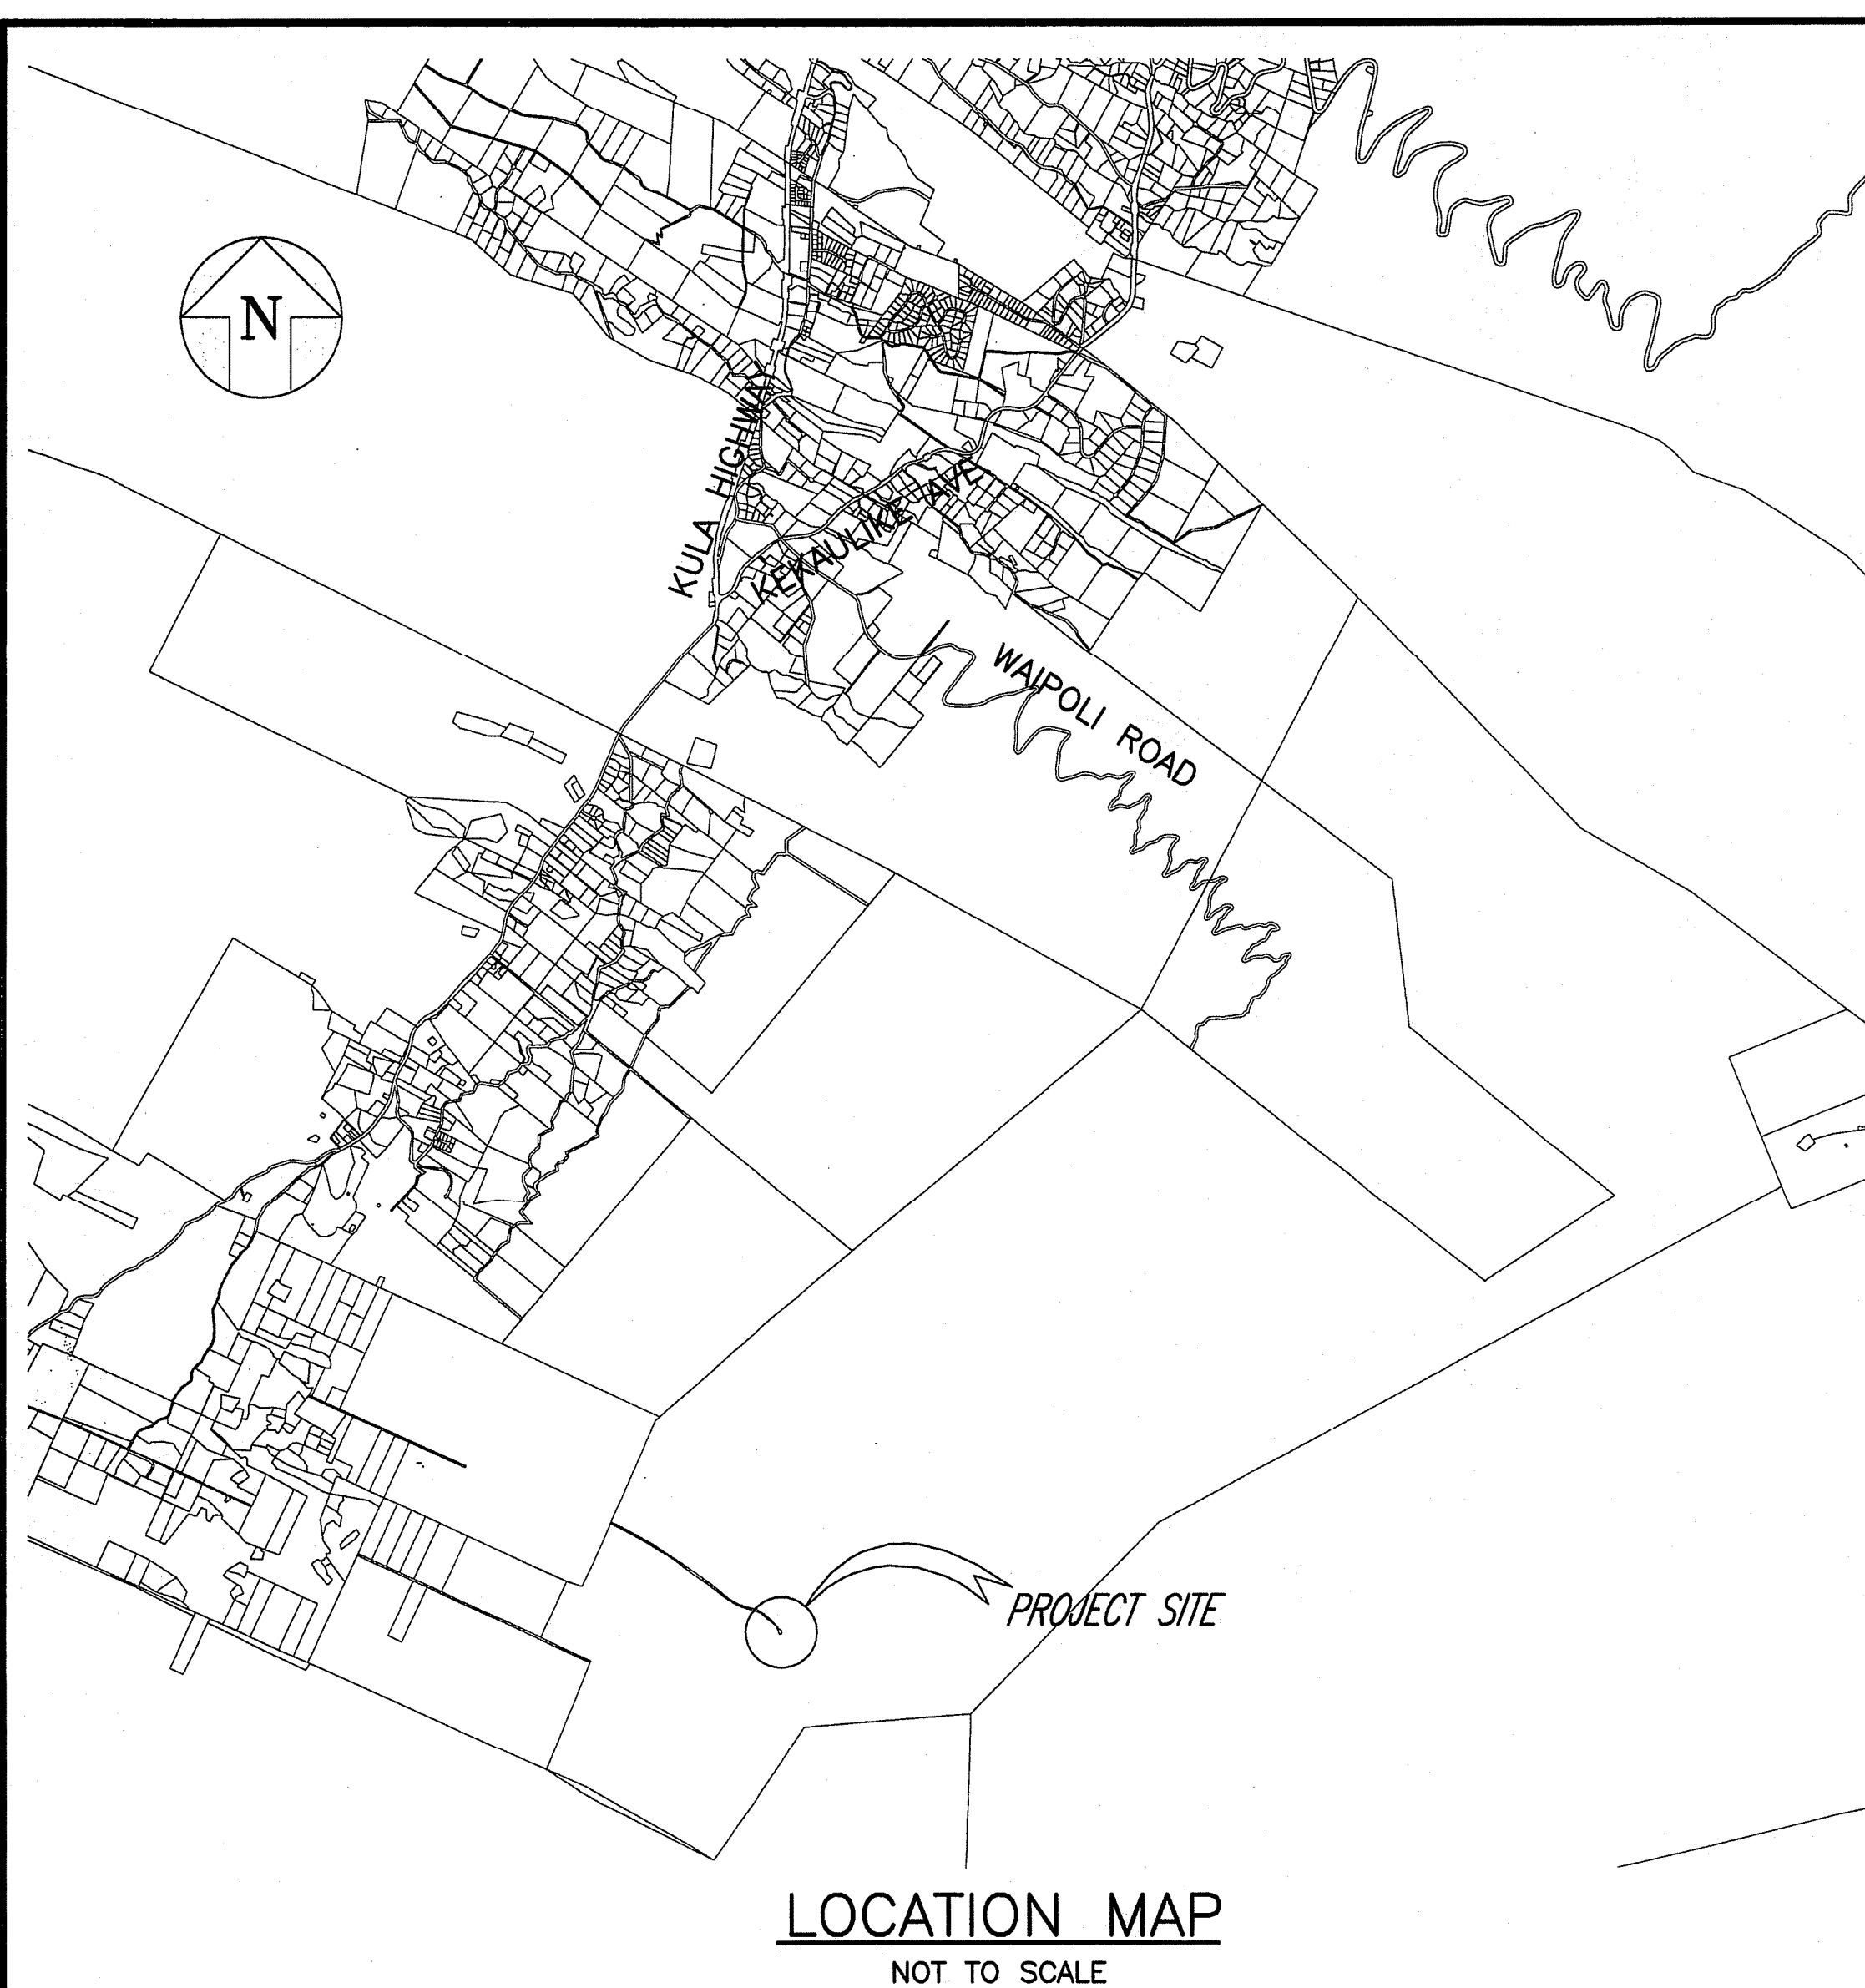

STATE OF HAWAII
DEPARTMENT OF LAND AND NATURAL RESOURCES
ENGINEERING DIVISION
FOR
DIVISION OF STATE PARKS

JOB NO. J00CF67A

POLI POLI SPRING STATE MONUMENT ADA BARRIER REMOVAL

KULA, MAUI, HAWAII

T.M.K.: (2) 2-2-07:001

I N D E X

DESCRIPTION

SHEET NO.

T-1:	TITLE SHEET	1
C-1:	LOCATION 1: CAMPGROUND SITE AND PICNIC TABLE	2
C-2:	LOCATION 2: CABIN SITE AND CONSTRUCTION NOTES	3
C-3:	CONSTRUCTION NOTES AND DETAILS	4
A-1:	LOCATION 2: CABIN FLOOR PLANS AND DETAILS	5
A-1.2:	LOCATION 2: CABIN FLOOR PLANS AND DETAILS	6
A-2:	LOCATION 2: CABIN ELEVATIONS AND DETAILS	7
A-3:	LOCATION 2: CABIN DETAILS	8
A-4:	LOCATION 1: OUTHOUSE FLOOR PLANS AND DETAILS	9

AS-BUILT DRAWINGS

This certifies the dimensions and detail shown on this sheet reflect the dimensions & details, and specifications as constructed in the field.
BCP CONSTRUCTION OF HAWAII, INC.
Signature & Date: *Geon Bait* 10-3-07

APPROVED:

DATE: 8/3/05

Daniel S. Quinn


DANIEL S. QUINN
ADMINISTRATOR
DIVISION OF STATE PARKS
DEPARTMENT OF LAND AND NATURAL RESOURCES


APPROVED:

DATE: 8/4/05


Eric T. Hirano

ERIC T. HIRANO, P.E.
CHIEF ENGINEER
ENGINEERING DIVISION
DEPARTMENT OF LAND AND NATURAL RESOURCES

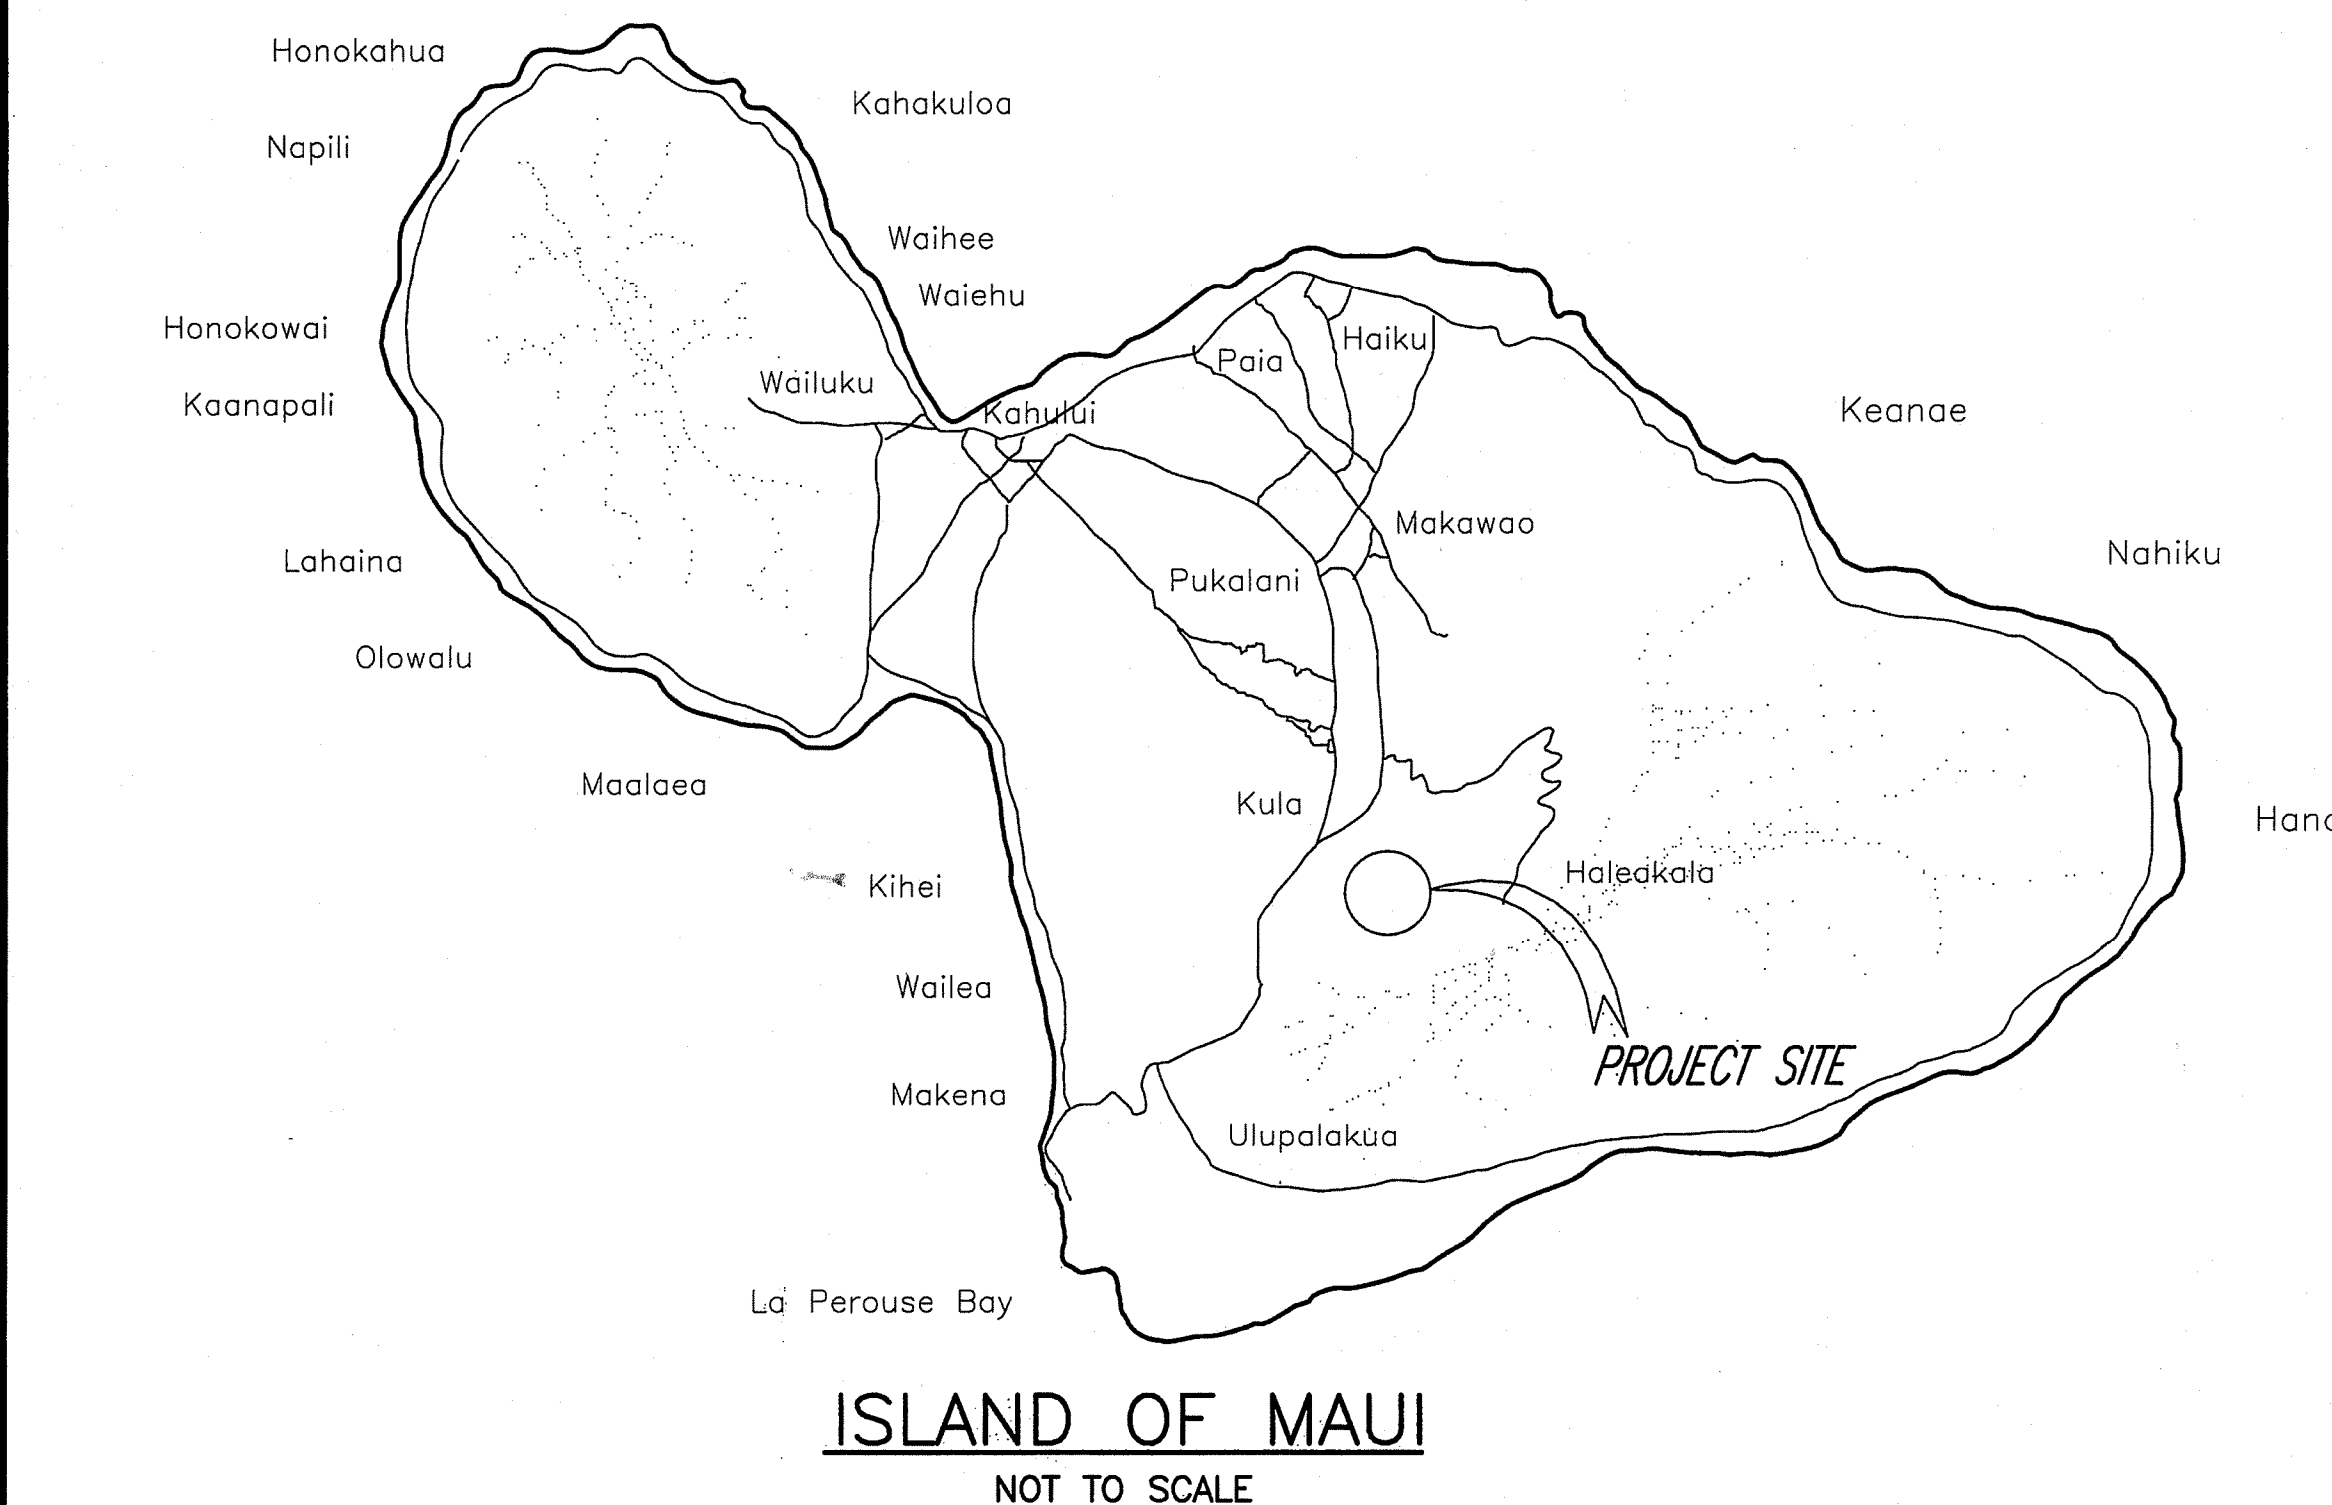

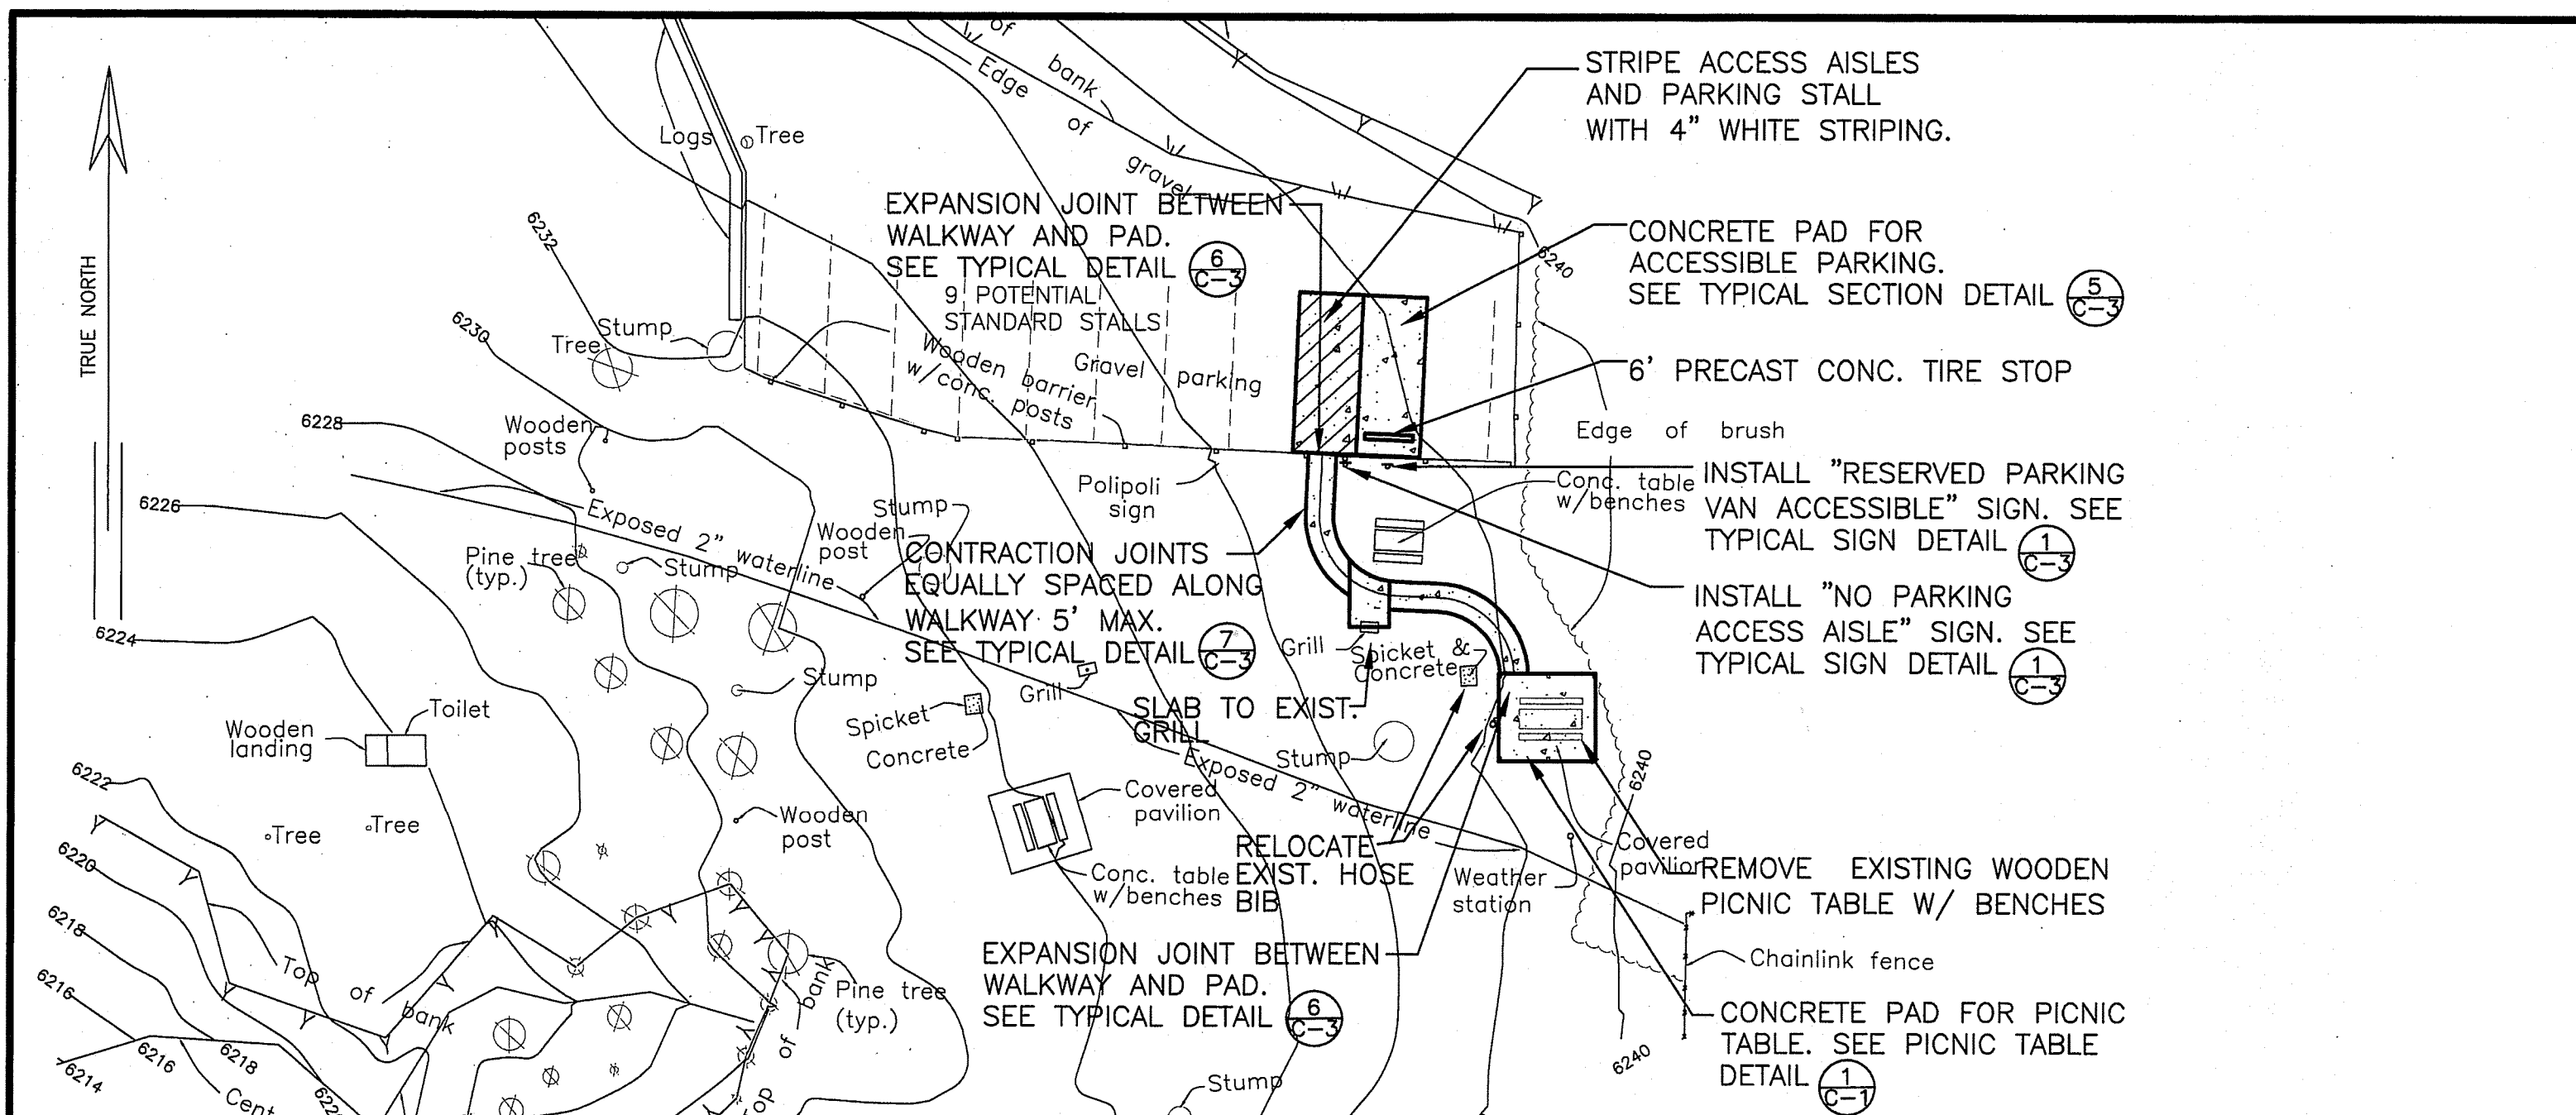


LOCATION 1: CAMPGROUND SITE PLAN
SCALE: 1" = 20'-0"

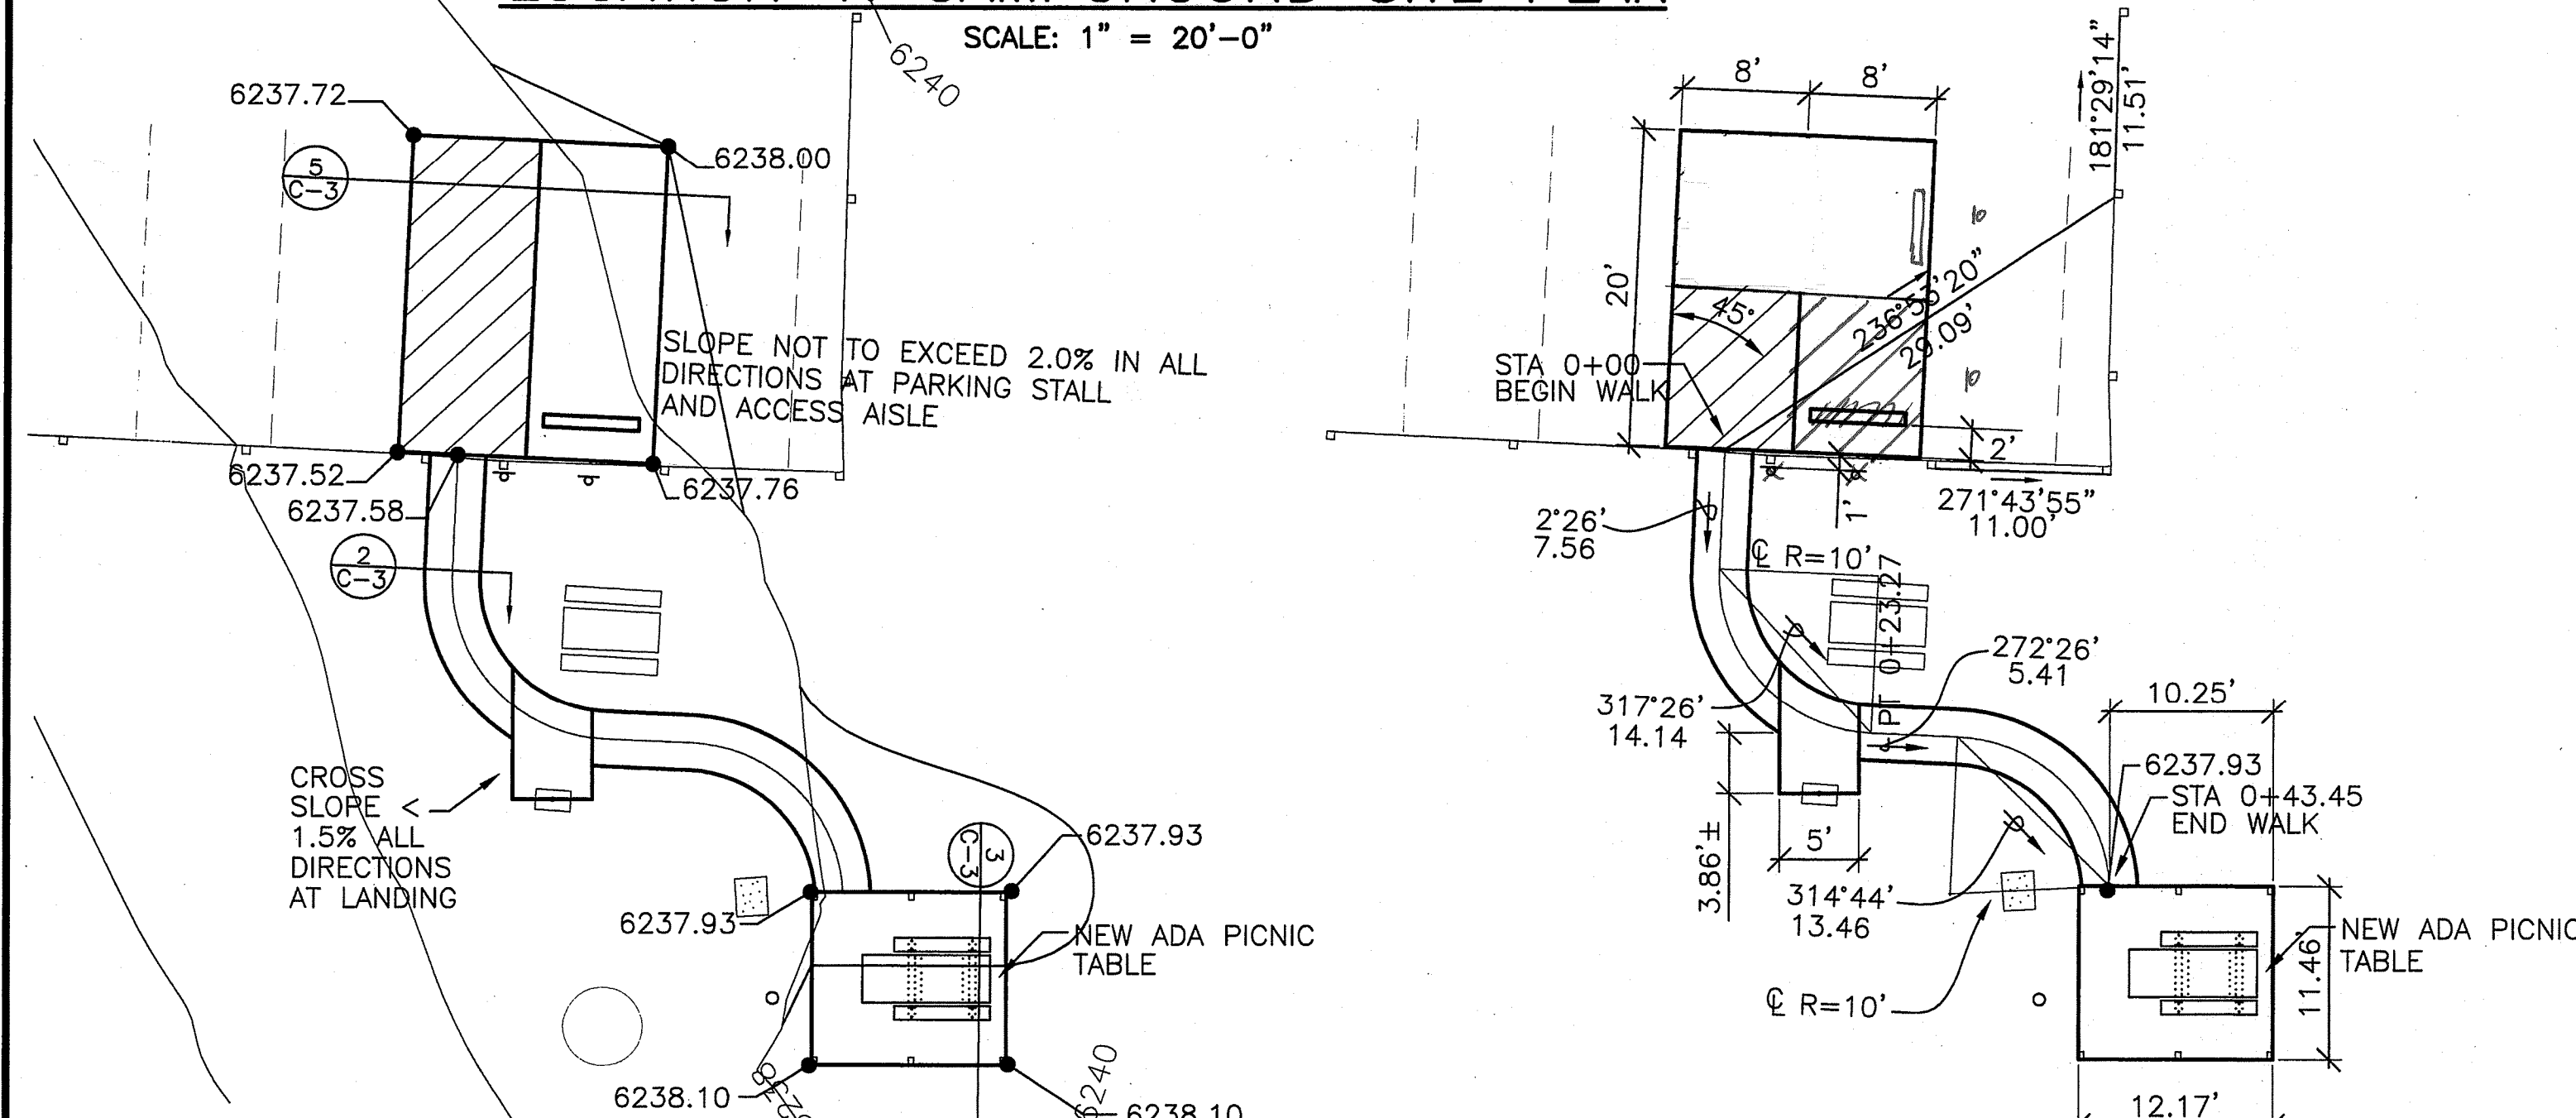


LOCATION 1: CAMPGROUND GRADING PLAN
SCALE: 1" = 10'-0"


LOCATION 1: CAMPGROUND LAYOUT
SCALE: 1" = 10'-0"

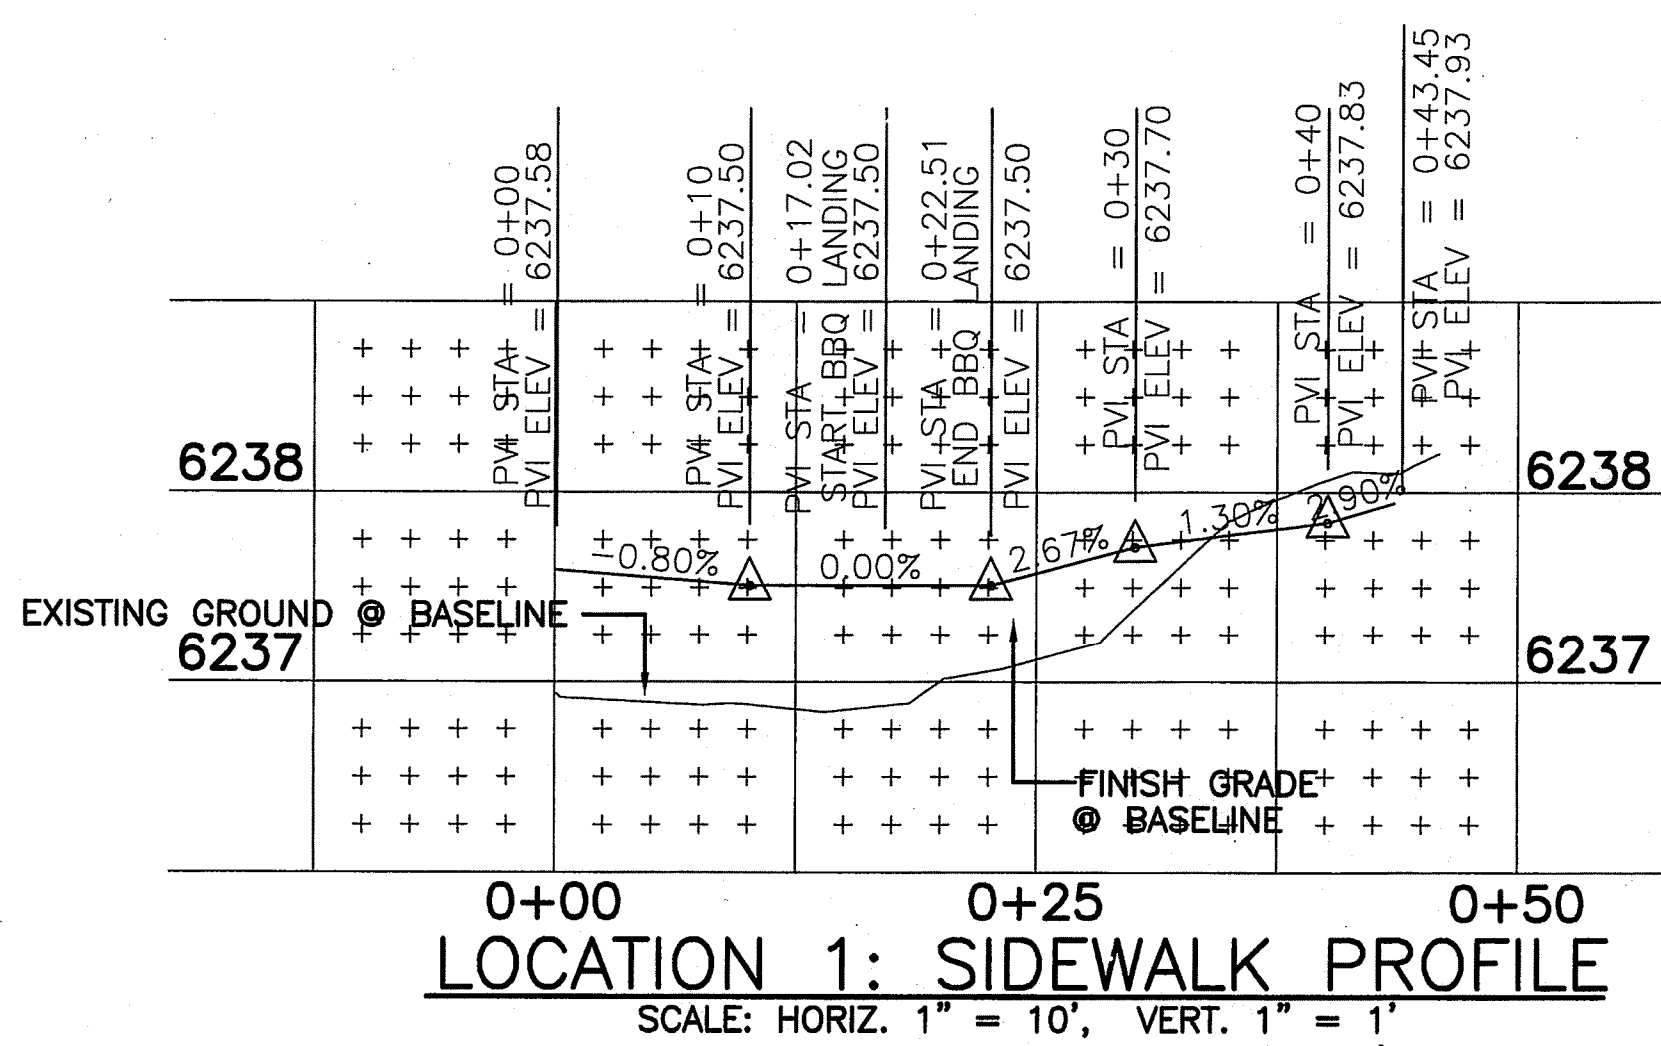


LOCATION 1: SIDEWALK PROFILE
SCALE: HORIZ. 1" = 10', VERT. 1" = 1'

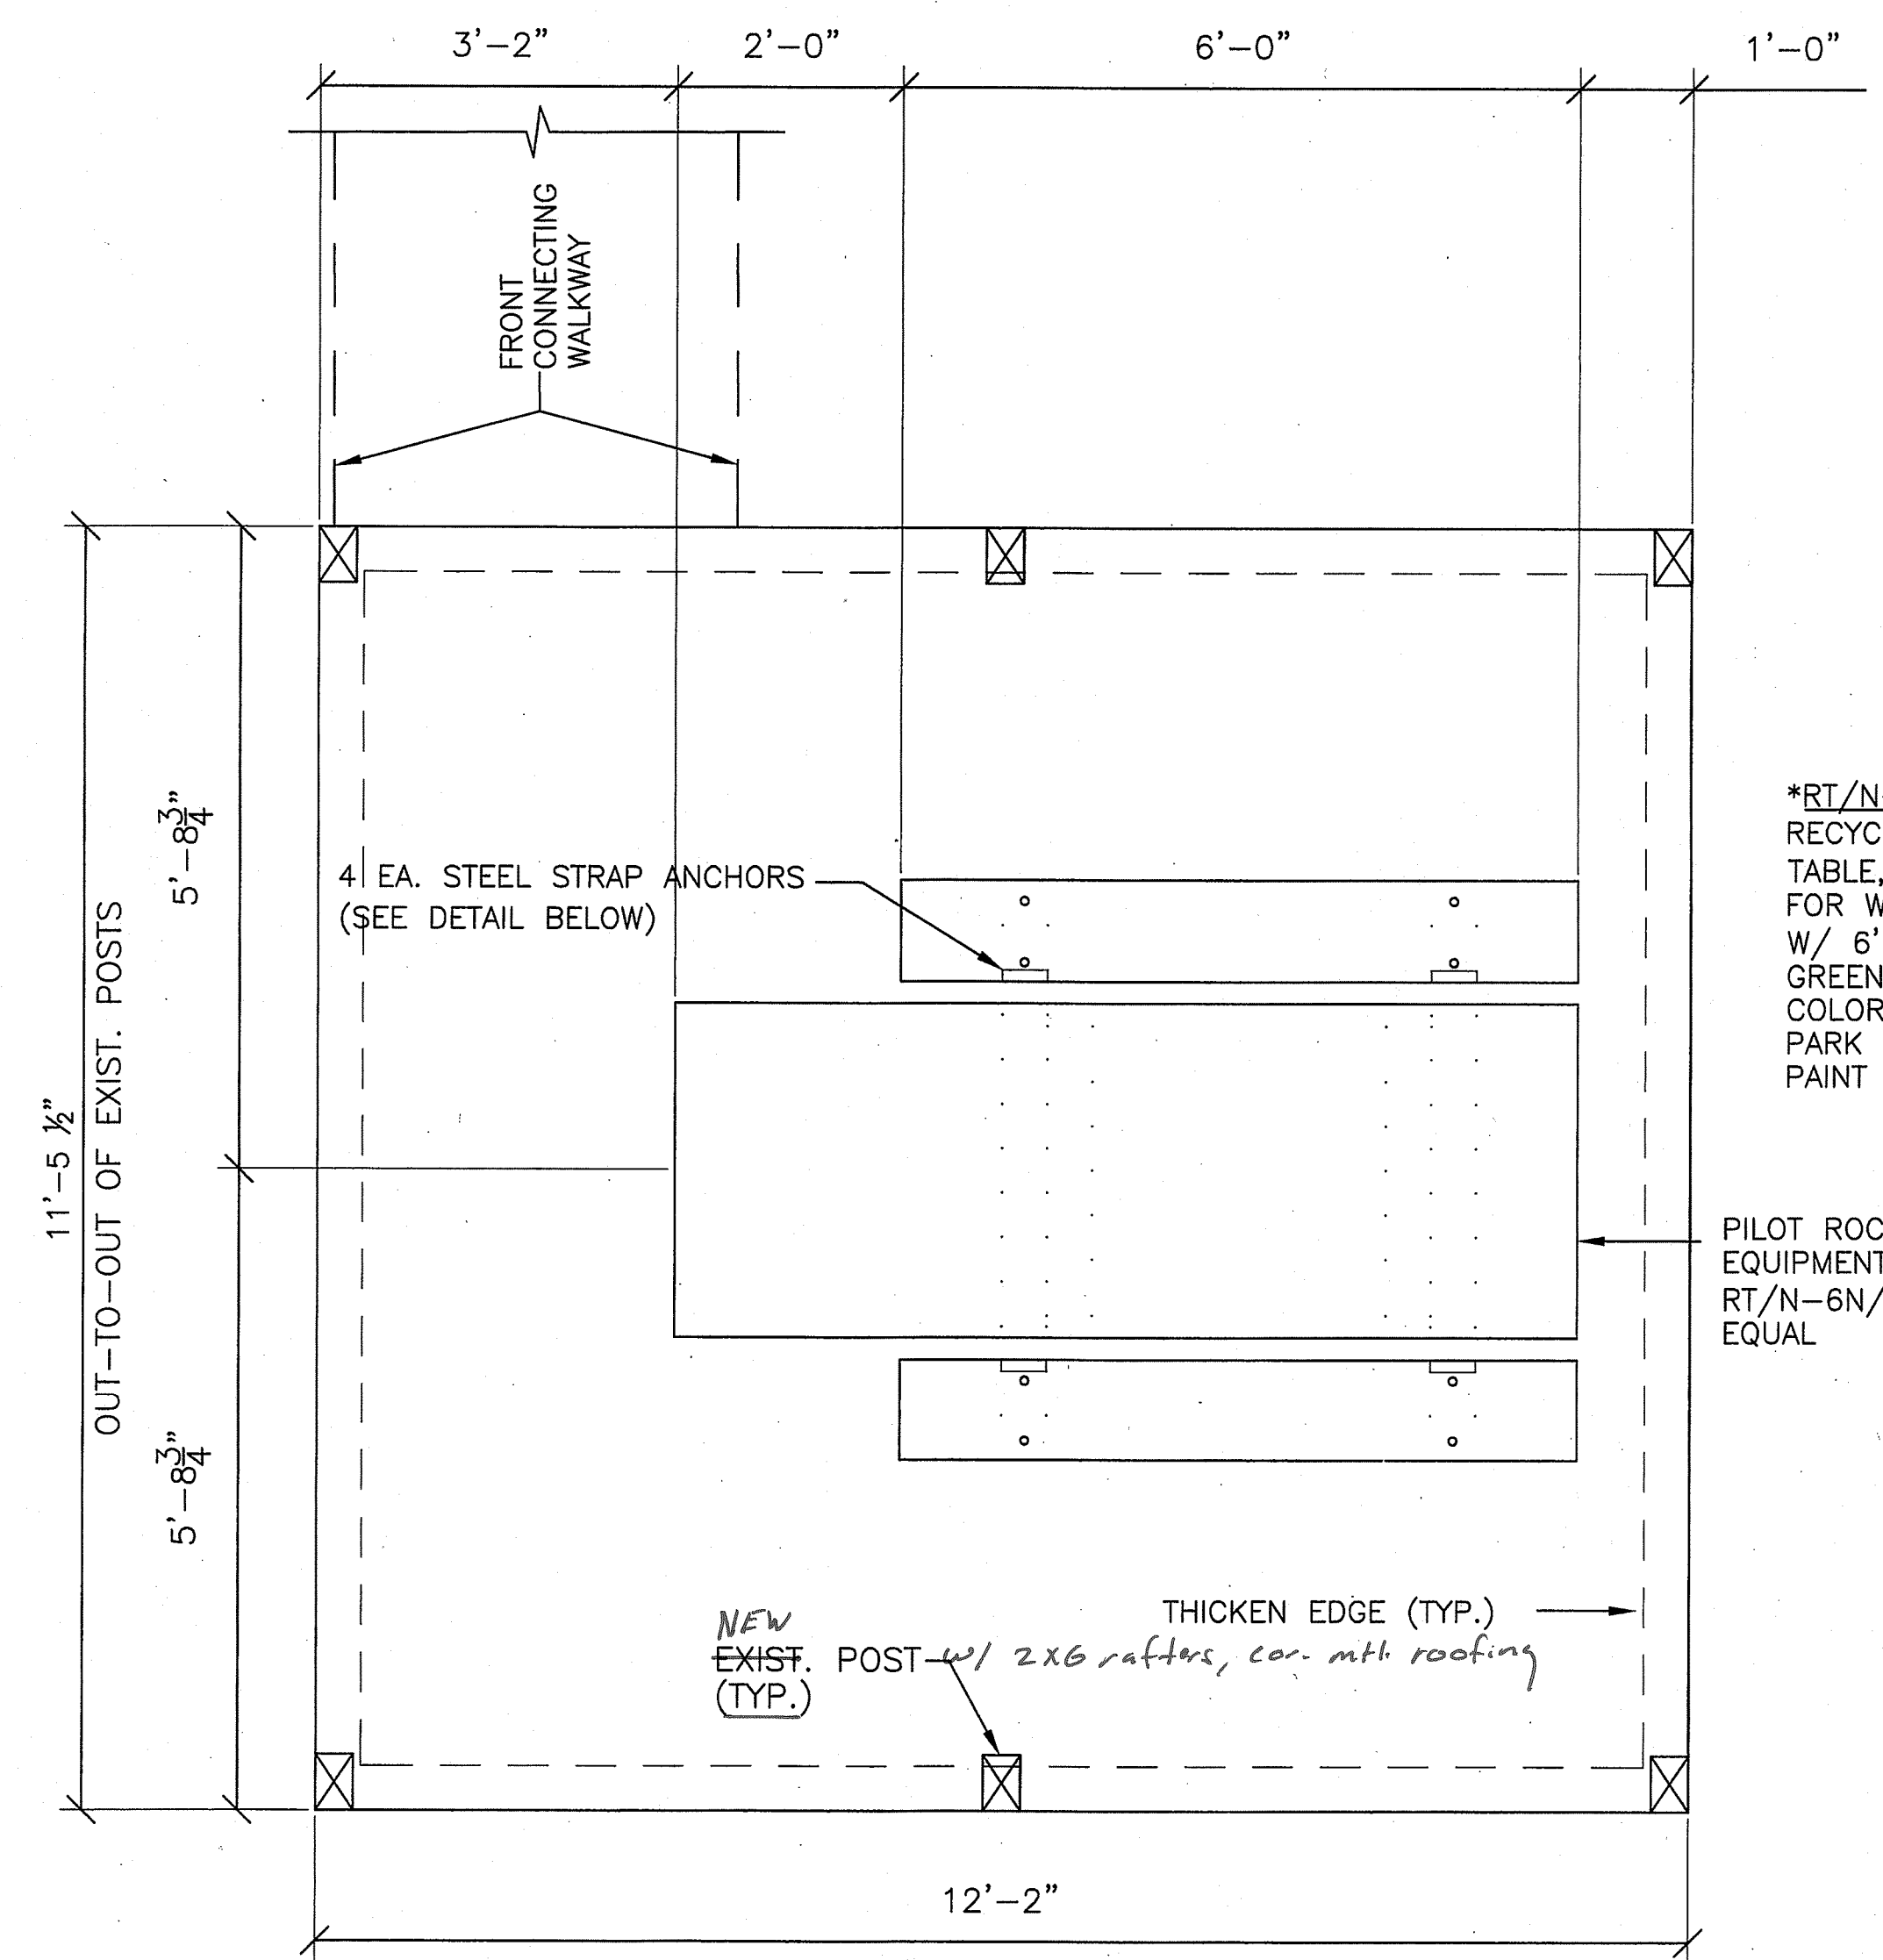

PICNIC TABLE PLAN

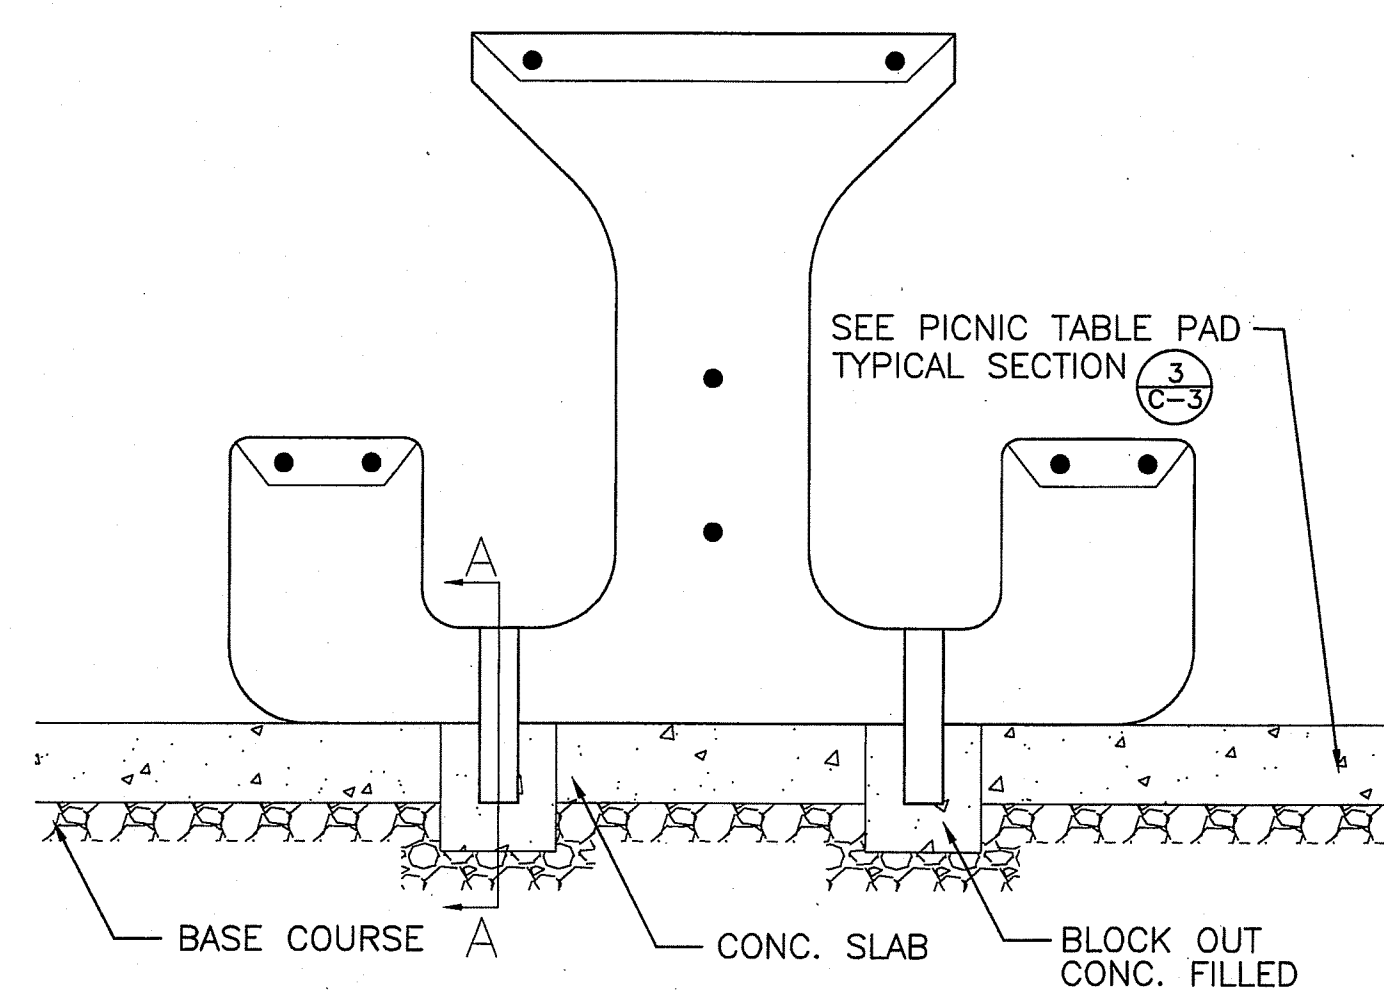

SECTION A-A
TYPICAL STEEL STRAP SECTION

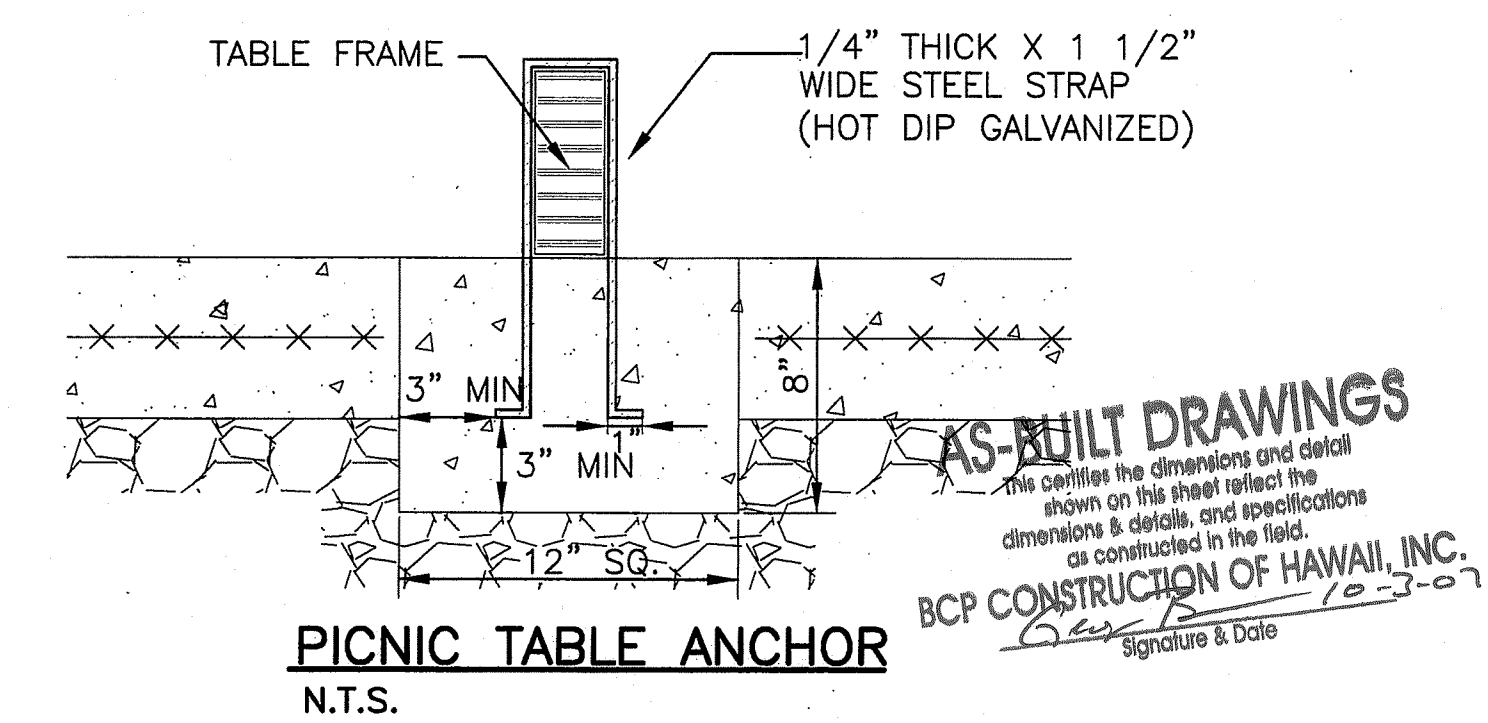


PICNIC TABLE ANCHOR
N.T.S.

1
C-1


PICNIC TABLE DETAIL

REVISION NO.	SYM.	DESCRIPTION	SHT./OF	DATE	APPROVED
CARL K. TAKIM LICENSED PROFESSIONAL ENGINEER No. 3485 C HAWAII, U.S.A. STATE OF HAWAII DEPARTMENT OF LAND AND NATURAL RESOURCES ENGINEERING DIVISION POLI POLI SPRINGS STATE MONUMENT ADA BARRIER REMOVAL LOCATION 1: CAMPGROUND AND PICNIC TABLE DETAIL					
DESIGNED: M.A.		SUBMITTED:			
DRAWN: M.A.		DATE: NOVEMBER 2004			
CHECKED: C.T.		SCALE: AS NOTED			
APPROVED: <i>Carl K. Takim</i>		ALJ - 4 2005		DRAWING NO.	
LICENSE EXPIRATION DATE		DATE		C-1	

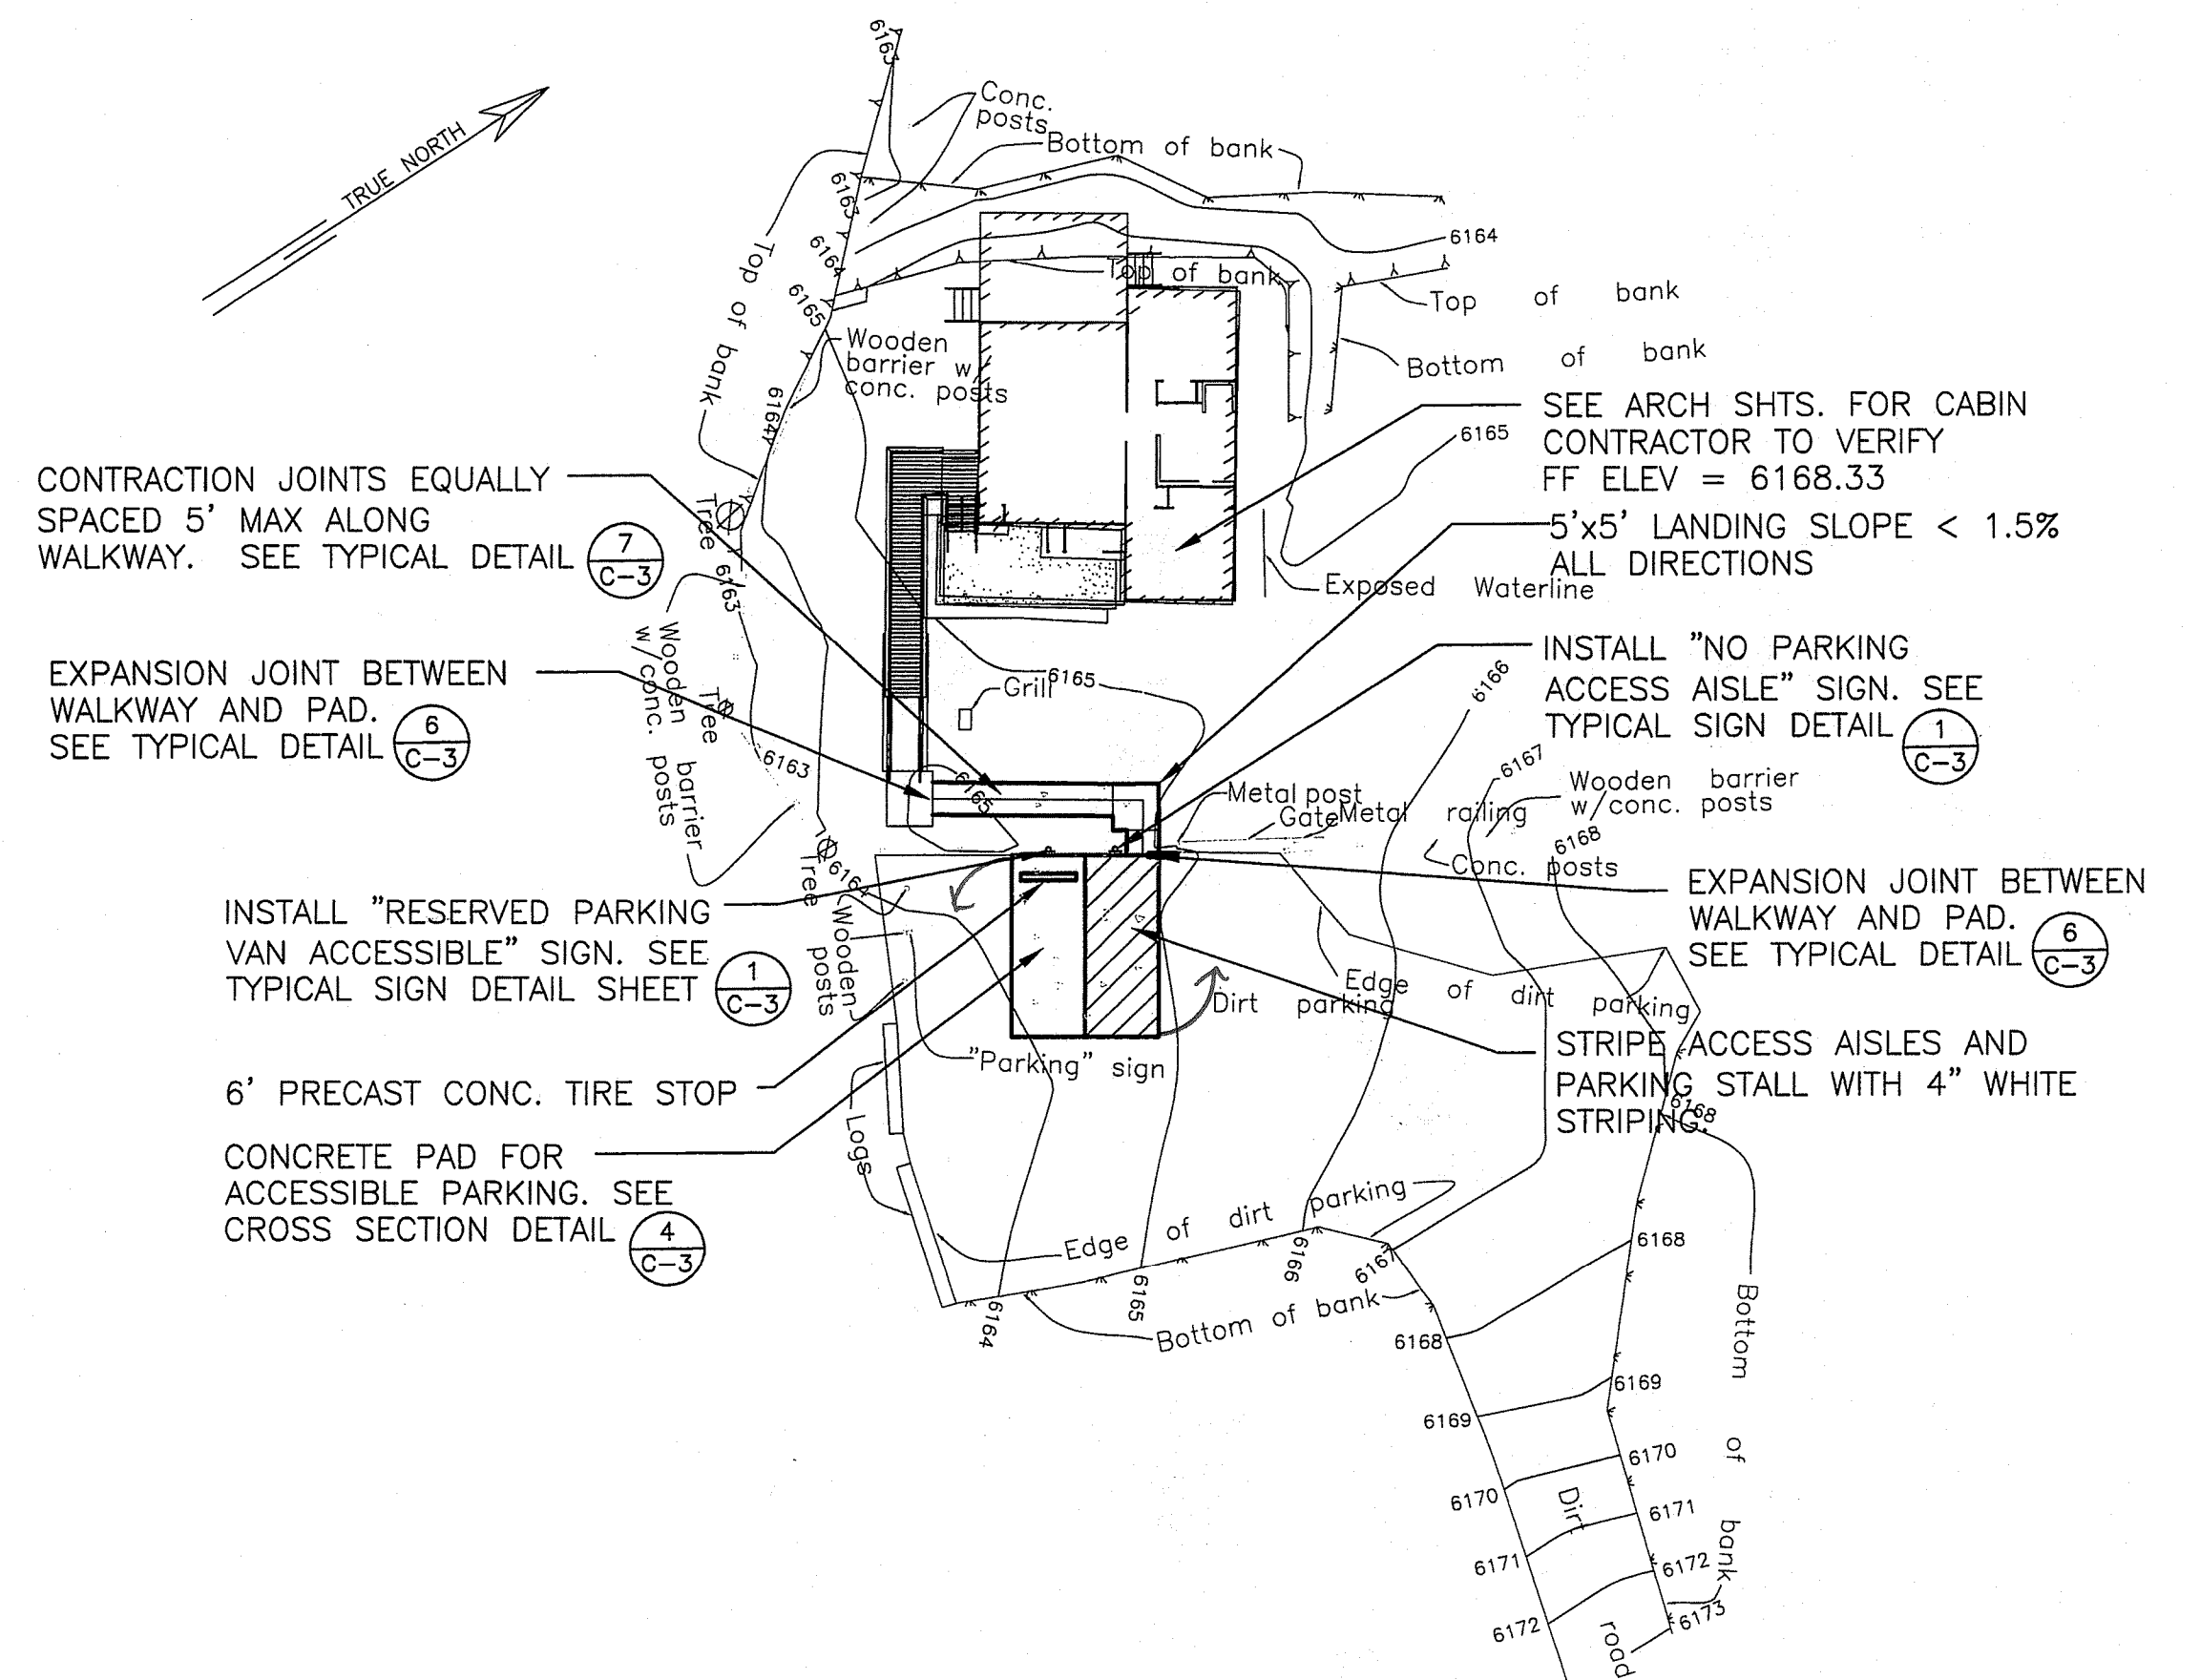


LOCATION 2: SITE PLAN

SCALE: 1" = 20'-0"

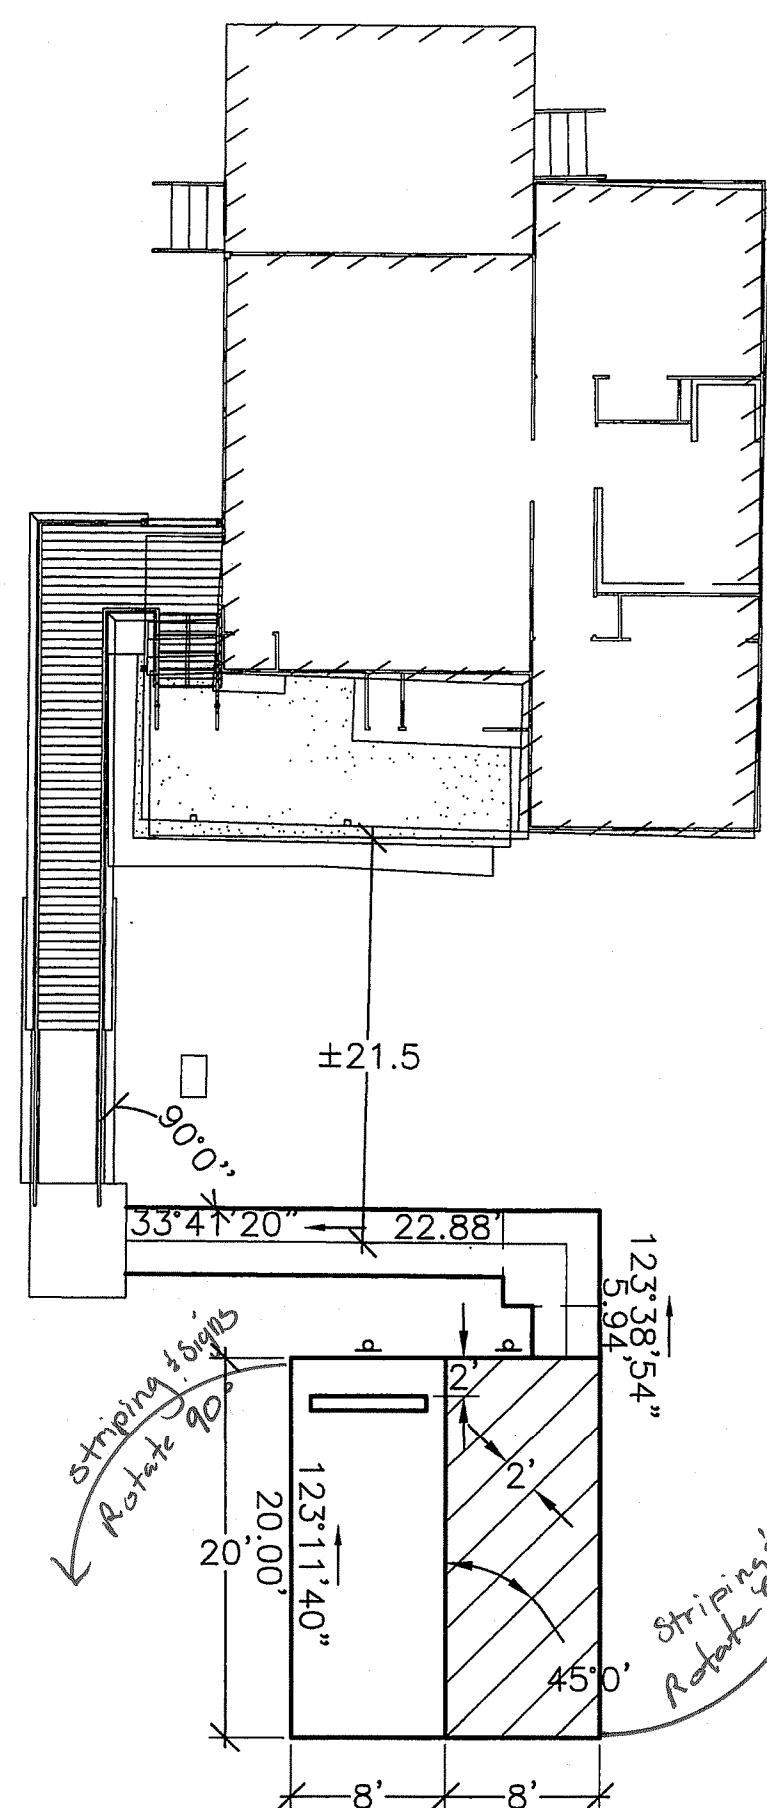

LOCATION 2: CABIN LAYOUT

SCALE: 1" = 10'-0"

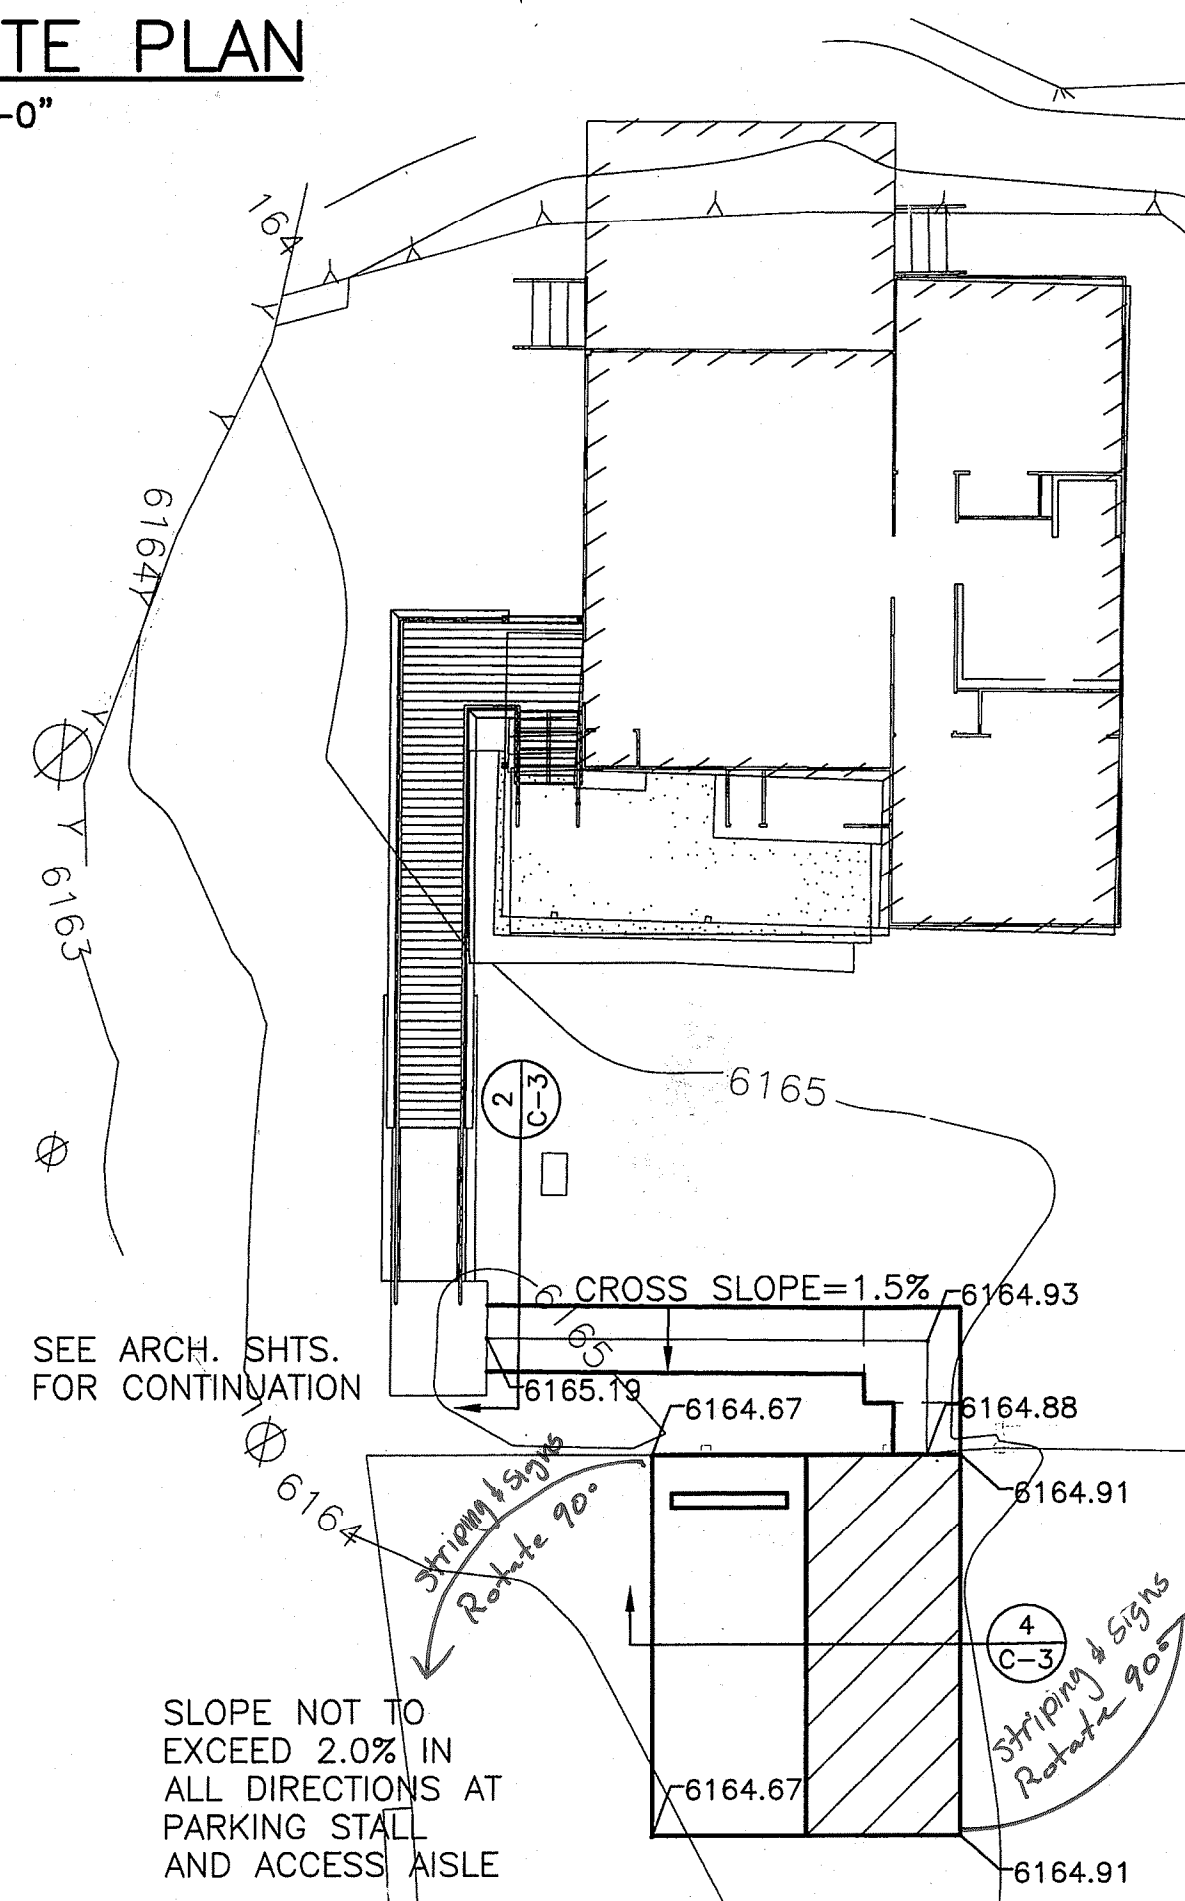

LOCATION 2: CABIN GRADING PLAN

SCALE: 1" = 10'-0"

CONSTRUCTION NOTES

- UNLESS NOTED OTHERWISE, THE CONTRACTOR SHALL BE RESPONSIBLE TO OBTAIN ALL NECESSARY PERMITS REQUIRED FOR CONSTRUCTION.
- ALL CONSTRUCTION WORK SHALL STRICTLY CONFORM TO THE APPLICABLE SECTIONS OF THE 1994 HAWAII STANDARD SPECIFICATIONS FOR ROAD, BRIDGE AND PUBLIC WORKS CONSTRUCTION, AND THE SEPTEMBER 1984 "STANDARD DETAILS" AND 1986 "STANDARD SPECIFICATIONS" FOR PUBLIC WORKS CONSTRUCTION OF THE DEPARTMENT OF PUBLIC WORKS FOR THE COUNTY OF MAUI.
- THE CONTRACTOR SHALL BE RESPONSIBLE TO FIELD VERIFY ALL GRADES, INVERTS, DIMENSIONS, AND POSSIBLE OBSTRUCTIONS, PRIOR TO ORDERING MATERIALS AND BEGINNING RELATED PHASE OF WORK.
- IF EXISTING UTILITIES, WHETHER OR NOT SHOWN ON PLANS, ARE DAMAGED DURING CONSTRUCTION, THE CONTRACTOR SHALL AT HIS OWN EXPENSE BE REQUIRED TO REPAIR SUCH UTILITIES.
- CONTRACTOR SHALL PROVIDE, INSTALL AND MAINTAIN ALL NECESSARY SIGNS, LIGHTS, FLARES, BARRICADES, AND OTHER PROTECTIVE DEVICES FOR THE PROTECTION, SAFETY AND CONVENIENCE OF THE PUBLIC, ACCORDING TO THE "MANUAL ON UNIFORM TRAFFIC CONTROL DEVICE FOR STREETS AND HIGHWAYS", 2001, AND TO THE RULES AND REGULATIONS GOVERNING THE USE OF TRAFFIC CONTROL DEVICES AT WORKSITES AND/OR ADJACENT TO PUBLIC STREETS AND HIGHWAYS ADOPTED BY THE HIGHWAY SAFETY COORDINATOR AND THE U.S. FEDERAL HIGHWAY ADMINISTRATION "MANUAL ON UNIFORM TRAFFIC CONTROL DEVICES FOR HIGHWAY CONSTRUCTION AND MAINTENANCE OPERATIONS", DATED 2000.
- THE CONTRACTOR SHALL, AT HIS OWN EXPENSE, KEEP THE PROJECT AREA AND SURROUNDING AREA FREE FROM DUST NUISANCE. THE WORK SHALL BE IN CONFORMANCE WITH AIR POLLUTION CONTROL STANDARDS AND REGULATIONS OF THE STATE DEPARTMENT OF HEALTH AND COUNTY GRADING ORDINANCE.
- THE CONTRACTOR SHALL REMOVE ALL SILT AND DEBRIS RESULTING FROM HIS WORK AND DEPOSITED IN DRAINAGE FACILITIES, ROADWAYS AND OTHER AREAS. THE COST INCURRED FOR ANY NECESSARY REMEDIAL ACTION SHALL BE PAID BY THE CONTRACTOR.
- CONSTRUCTION DEBRIS AND WASTES SHALL BE DEPOSITED AT AN APPROPRIATE WORK SITE. THE CONTRACTOR SHALL INFORM THE CONSTRUCTION MANAGER, OR ENGINEER, AND ANY APPLICABLE AGENCIES OF THE LOCATION OF THE DISPOSAL SITES. THE DISPOSAL SITE MUST FULFILL THE REQUIREMENTS OF THE GRADING ORDINANCE.
- SHOULD HISTORIC SITES SUCH AS WALLS, PLATFORMS, PAVEMENTS, OR MOUNDS, OR REMAINS SUCH AS ARTIFACTS, BURIALS, CONCENTRATION OF SHELL OR CHARCOAL BE ENCOUNTERED DURING CONSTRUCTION ACTIVITIES, WORK SHALL CEASE IMMEDIATELY IN THE IMMEDIATE VICINITY OF THE FIND AND THE FIND SHALL BE PROTECTED FROM FURTHER DAMAGE. THE CONTRACTOR AND/OR LANDOWNER SHALL IMMEDIATELY CONTACT THE STATE HISTORIC PRESERVATION DIVISION (243-5169), WHICH WILL ASSESS THE SIGNIFICANCE OF THE FIND AND RECOMMEND AN APPROPRIATE MITIGATION MEASURE, IF NECESSARY.
- THE CONTRACTOR SHALL SECURE THE SERVICES OF A LICENSED SURVEYOR TO PROVIDE ALL CONSTRUCTION STAKEOUTS. REFER TO SPECIAL PROVISION SECTION 105.07 FOR OTHER SPECIFIC REQUIREMENTS.
- THE PARK SHALL REMAIN OPEN DURING THE CONSTRUCTION PERIOD. THE CONTRACTOR SHALL INSTALL ADEQUATE TEMPORARY BARRICADES AND WARNINGS SIGNS TO PROTECT THE PUBLIC DURING THE CONSTRUCTION PERIOD. PROVIDE AND MAINTAIN A SAFE PEDESTRIAN ACCESS FROM THE PARKING AREA AND TO THE LOOKOUT THROUGHOUT THE CONSTRUCTION PERIOD.
- ALL APPLICABLE CONSTRUCTION WORK SHALL BE DONE IN ACCORDANCE WITH THE STANDARD SPECIFICATIONS FOR PUBLIC WORKS CONSTRUCTION, SEPTEMBER 1988 AND STANDARD DETAILS FOR PUBLIC WORKS CONSTRUCTION, SEPTEMBER 1964, AS AMENDED, DEPARTMENT OF PUBLIC WORKS, CITY AND COUNTY OF HONOLULU, AND COUNTIES OF KAUAI, MAUI, AND HAWAII.

PAVEMENT STRIPING AND SIGNAGE NOTES

- PAVEMENT STRIPING OTHER THAN FOR CROSSWALKS, STOP LINES AND PAVEMENT ARROWS, PAVEMENT ALPHABETS, AND PAVEMENT SYMBOLS SHALL BE WITH PRE-MIXED REFLECTORIZED LEAD FREE TRAFFIC PAINTS WHICH HAVE PASSED THE STATE OF HAWAII, DEPARTMENT OF TRANSPORTATION, HIGHWAYS DIVISION PRE-QUALIFICATIONS TESTS. THERMOPLASTIC STRIPING MAY BE USED IN LIEU OF PAINTING FOR CENTERLINE STRIPING, LANE-LINE STRIPING AND EDGE OF PAVEMENT STRIPING. THE CONTRACTOR SHALL SUBMIT CERTIFICATE OF COMPLIANCE CERTIFYING THAT THE TRAFFIC PAINT AND/OR THERMOPLASTIC MATERIAL TO BE USED MEETS THE DOT SPECIFICATIONS.
- ALL PAINTED PAVEMENT STRIPING SHALL BE APPLIED IN COATS OF 0.015 INCH NOMINAL THICKNESS EACH. FOR STRIPING ON FRESH ASPHALT CONCRETE PAVEMENT (RESURFACED OR NEW), TWO COATS OF PAINT MUST BE APPLIED. SECOND COAT SHALL BE APPLIED ONLY AFTER COMPLETE DRYING OF THE FIRST COAT. WAIT AT LEAST 2 HOURS BETWEEN COATS. FOR STRIPING ON OLD EXISTING PAVEMENTS, ONLY ONE COAT IS REQUIRED.
- SIGNPOSTS SHALL BE 2 INCHES SQUARE TELESAR TUBING NO. 20 F 12 OR EQUIVALENT WITH 2-1/4 INCH SQUARE TELESAR POST.
- UPON COMPLETION OF THE CONSTRUCTION WORK, THE CONTRACTOR SHALL RE-STRIP ALL PAVEMENT MARKINGS WITHIN THE CONSTRUCTION WORK AREA AND ADJACENT ROADWAY PAVEMENTS UP TO 300 FEET BEYOND THE CONSTRUCTION AREA. ALL SIGNS AND MARKINGS WITHIN THE CONSTRUCTION AREA AND ADJACENT AREAS THAT HAVE BEEN DAMAGED, REMOVED, OR ADVERSELY AFFECTED BY THE CONSTRUCTION WORK SHALL BE RESTORED TO ITS ORIGINAL CONDITIONS OR BETTER BY THE CONTRACTOR.

COMPACTION REQUIREMENTS

- TESTING OF MATERIALS SHALL BE CONDUCTED BY AN APPROVED INDEPENDENT TESTING AGENCY IN ACCORDANCE WITH ASTM STANDARD METHODS OR AS SPECIFIED BY THE ENGINEER, AS FOLLOWS:
 - EMBANKMENT/SELECT BORROW AND SUBGRADE MATERIALS: ONE (1) COMPACTION TEST PER 600 SQUARE YARDS, PER LIFT OF MATERIAL;
 - AGGREGATE SUBBASE COURSE: ONE (1) COMPACTION TEST PER 400 SQUARE YARDS, PER LIFT OF MATERIAL; ONE (1) GRADATION AND SAND EQUIVALENT TEST PER PROJECT;
 - AGGREGATE BASE COURSE: ONE (1) COMPACTION TEST PER 300 SQUARE YARDS, PER LIFT OF MATERIAL; ONE (1) GRADATION AND SAND EQUIVALENT TEST PER PROJECT;
 - ASPHALT CONCRETE PAVEMENT OR ASPHALT TREATED BASE COURSE: THREE (3) A.C. CORES FOR THICKNESS AND DENSITY TESTS PER PROJECT;
 - TRENCH BACKFILL MATERIAL: ONE (1) TEST FOR EACH 300 LINEAL FEET OF TRENCH PER LIFT OF MATERIAL.
- CONTRACTOR SHALL SUBMIT ALL TESTING REPORTS INCLUDING RESULTS TO THE COUNTY'S INSPECTION AGENCY FOR REVIEW AND APPROVAL PRIOR TO STATE'S ACCEPTANCE OF WORK.
- THE CONTRACTOR SHALL BE REQUIRED TO NOTIFY THE STATE OF ANY TESTING FAILURES AND CORRECT EACH FAILURE PRIOR TO PROCEEDING TO THE NEXT PHASE OF CONSTRUCTION. NONCOMPLIANCE WILL REQUIRE REMOVAL OF ALL SUBSEQUENT WORK TO CORRECT THE AREA OF FAILURE. ALL COSTS OF TESTING, REMOVAL, AND RECONSTRUCTION, SHALL BE BORNE BY THE CONTRACTOR.


EROSION CONTROL

THE FOLLOWING MEASURES SHALL BE TAKEN TO CONTROL EROSION DURING THE SITE DEVELOPMENT PERIOD:

- MINIMIZE TIME OF CONSTRUCTION.
- RETAIN EXISTING GROUND COVER UNTIL LATEST DATE TO COMPLETE CONSTRUCTION.
- EARLY CONSTRUCTION OF DRAINAGE CONTROL FEATURES.
- USE TEMPORARY AREA SPRINKLERS IN NON-ACTIVE CONSTRUCTION AREAS WHEN GROUND COVER IS REMOVED.
- STATION WATER TRUCKS ON SITE DURING CONSTRUCTION PERIOD TO PROVIDE FOR IMMEDIATE SPRINKLING, AS NEEDED, IN ACTIVE CONSTRUCTION ZONES, INCLUDING WEEKENDS AND HOLIDAYS.
- USE TEMPORARY BERMS AND CUT-OFF DITCHES, WHERE NEEDED, FOR CONTROL OF EROSION.
- GRADING AREAS SHALL BE THOROUGHLY WATERED AFTER CONSTRUCTION ACTIVITY HAS CEASED FOR THE DAY AND ON WEEKENDS.
- ALL CUT AND FILL SLOPES SHALL BE SODDED OR PLANTED IMMEDIATELY AFTER GRADING WORK HAS BEEN COMPLETED.
- ROUGHEN THE SURFACE OF ALL SLOPES DURING THE CONSTRUCTION OPERATION TO RETAIN WATER, INCREASE INFILTRATION, AND FACILITATE VEGETATION ESTABLISHMENT.
- USE MULCH TO STABILIZE AREAS TEMPORARILY WHERE FINAL GRADING MUST BE DELAYED.
- STOCKPILES, BORROW AREAS, AND SPOIL AREAS SHALL BE STABILIZED TO PREVENT EROSION AND SEDIMENTATION.
- ANY SITE SEDIMENT TRACKED ONTO THE ROADWAY SHALL BE CLEARED OFF AT THE END OF EACH WORK DAY OR AS CONDITIONS WARRANT.
- IF THE CONTRACTOR IS NOT ABLE TO SATISFACTORILY CONTROL DUST EMISSIONS FROM THE PROJECT SITE, ALL CONSTRUCTION WORK SHALL CEASE EXCEPT FOR WATERING AND OTHER STABILIZATION EFFORTS.


AS-BUILT DRAWINGS
This certifies the dimensions and detail shown on this sheet reflect the dimensions & detail, and specifications as constructed in the field.
Signature & Date
BCP CONSTRUCTION OF HAWAII, INC.

REVISION NO.	SYM.	DESCRIPTION	SHT./OF	DATE	APPROVED
STATE OF HAWAII DEPARTMENT OF LAND AND NATURAL RESOURCES ENGINEERING DIVISION POLI POLI SPRINGS STATE MONUMENT ADA BARRIER REMOVAL LOCATION 2: CABIN AND CONSTRUCTION NOTES					
DESIGNED:	M.A.	SUBMITTED:			
DRAWN:	M.A.	DATE:	NOVEMBER 2004		
CHECKED:	C.T.	SCALE:	AS NOTED		
APPROVED:	<i>Carl K. Takami</i>	DATE:	AUG -4 2005		
THIS WORK WAS PREPARED BY ME OR UNDER MY SUPERVISION. CONSTRUCTION OF THIS PROJECT WILL BE UNDER MY OBSERVATION. 4-30-2006 LICENSE EXPIRATION DATE		CHIEF ENGINEER	DRAWING NO. C-2		

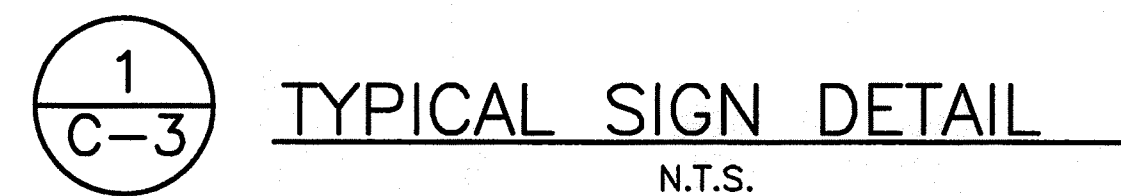


ENVIRONMENTAL HEALTH CONSTRUCTION NOTES

1. THE CONTRACTOR SHALL REMOVE ALL SILT AND DEBRIS RESULTING FROM HIS WORK AND DEPOSITED IN DRAINAGE FACILITIES, ROADWAYS, AND OTHER AREAS. THE COSTS INCURRED FOR ANY NECESSARY REMEDIAL ACTION BY THE STATE DEPARTMENT OF HEALTH SHALL BE PAYABLE BY THE CONTRACTOR.
2. THE CONTRACTOR, AT HIS EXPENSE, SHALL KEEP THE PROJECT AREA AND SURROUNDING AREA FREE OF DUST NUISANCE. THE WORK SHALL BE IN CONFORMANCE WITH THE AIR POLLUTION CONTROL STANDARDS AND REGULATIONS OF THE STATE DEPARTMENT OF HEALTH.
3. ALL GRADING OPERATIONS SHALL BE PERFORMED IN CONFORMANCE WITH THE APPLICABLE PROVISIONS OF THE WATER POLLUTION CONTROL AND WATER QUALITY STANDARDS CONTAINED IN THE PUBLIC HEALTH REGULATIONS, STATE DEPARTMENT OF HEALTH, ON WATER POLLUTION CONTROL AND WATER QUALITY STANDARDS.
4. ALL SLOPES AND EXPOSED AREAS SHALL BE PLANTED OR PAVED IMMEDIATELY AFTER THE GRADING WORK HAS BEEN COMPLETED.
5. CONSTRUCTION DEBRIS AND WASTES SHALL BE DEPOSITED AT AN APPROPRIATE SITE. THE CONTRACTOR SHALL INFORM THE ENGINEER OF THE LOCATION OF DISPOSAL SITES. THE DISPOSAL SITE MUST ALSO FULFILL REQUIREMENTS OF THE GRADING ORDINANCES.
6. THE CONTRACTOR SHALL NOT DEMOLISH OR CLEAR ANY STRUCTURE, SITE OR VACANT LOT WITHOUT FIRST ASCERTAINING THE PRESENCE OR ABSENCE OF RODENTS WHICH MAY ENDANGER THE PUBLIC HEALTH BY DISPERSAL FROM SUCH PREMISES. SHOULD SUCH INSPECTION REVEAL THE PRESENCE OF SUCH RODENTS, THE CONTRACTOR SHALL ERADICATE SUCH RODENTS BEFORE DEMOLISHING OR CLEARING SAID STRUCTURE, SITE OR VACANT LOT.

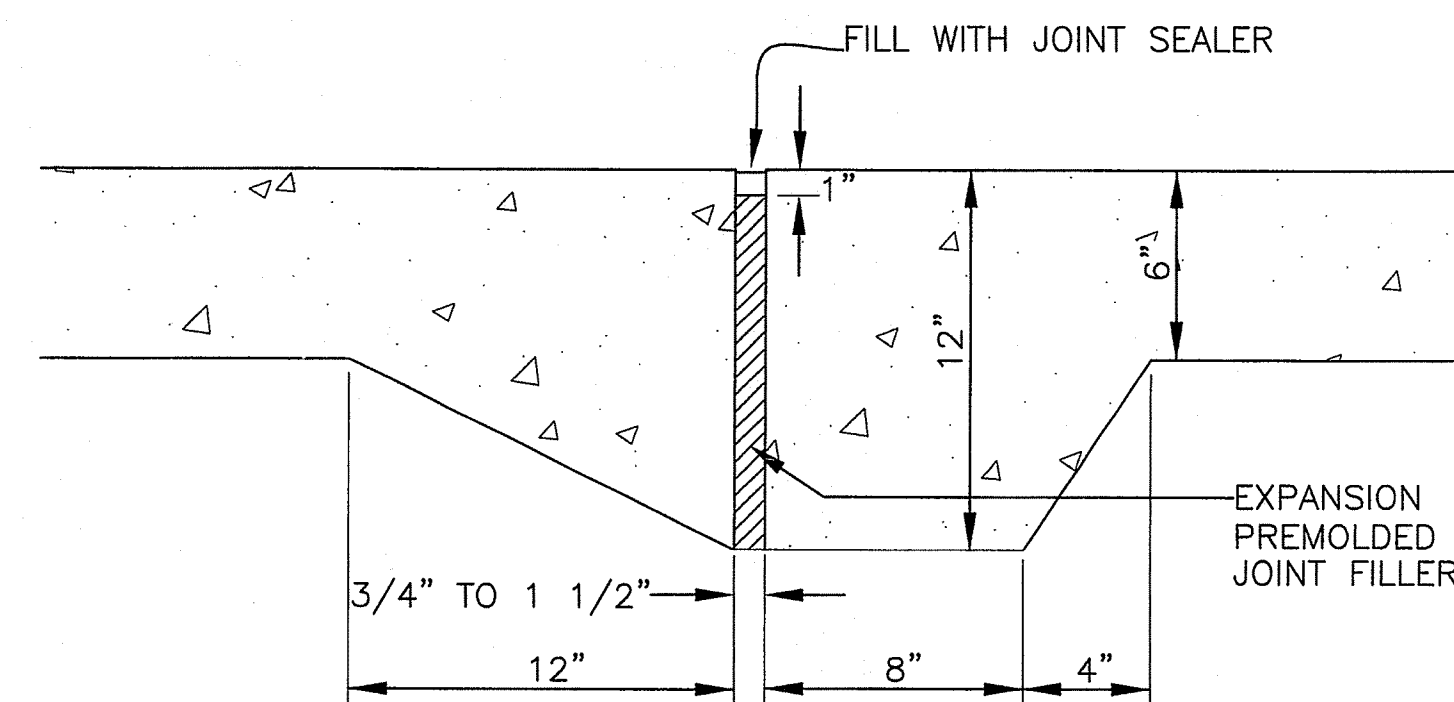



TYPICAL EXPANSION JOINT DETAIL
 N.T.S.

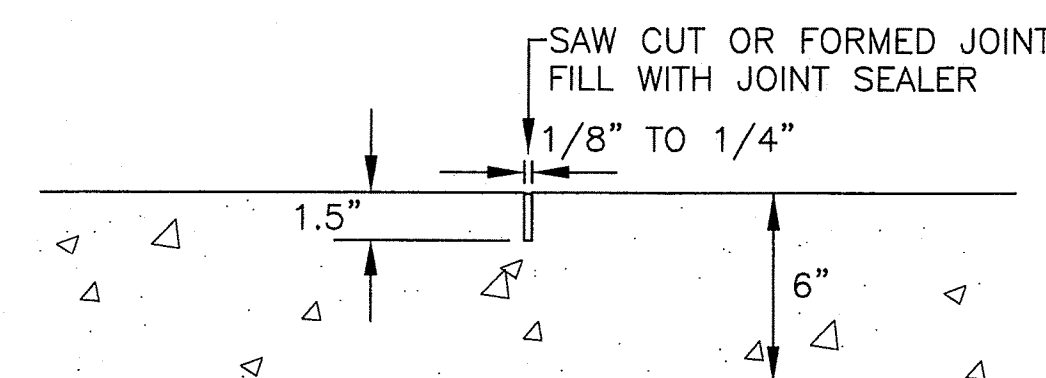


7
C-3

TYPICAL CONTRACTION JOINT DETAIL

N.T.S.

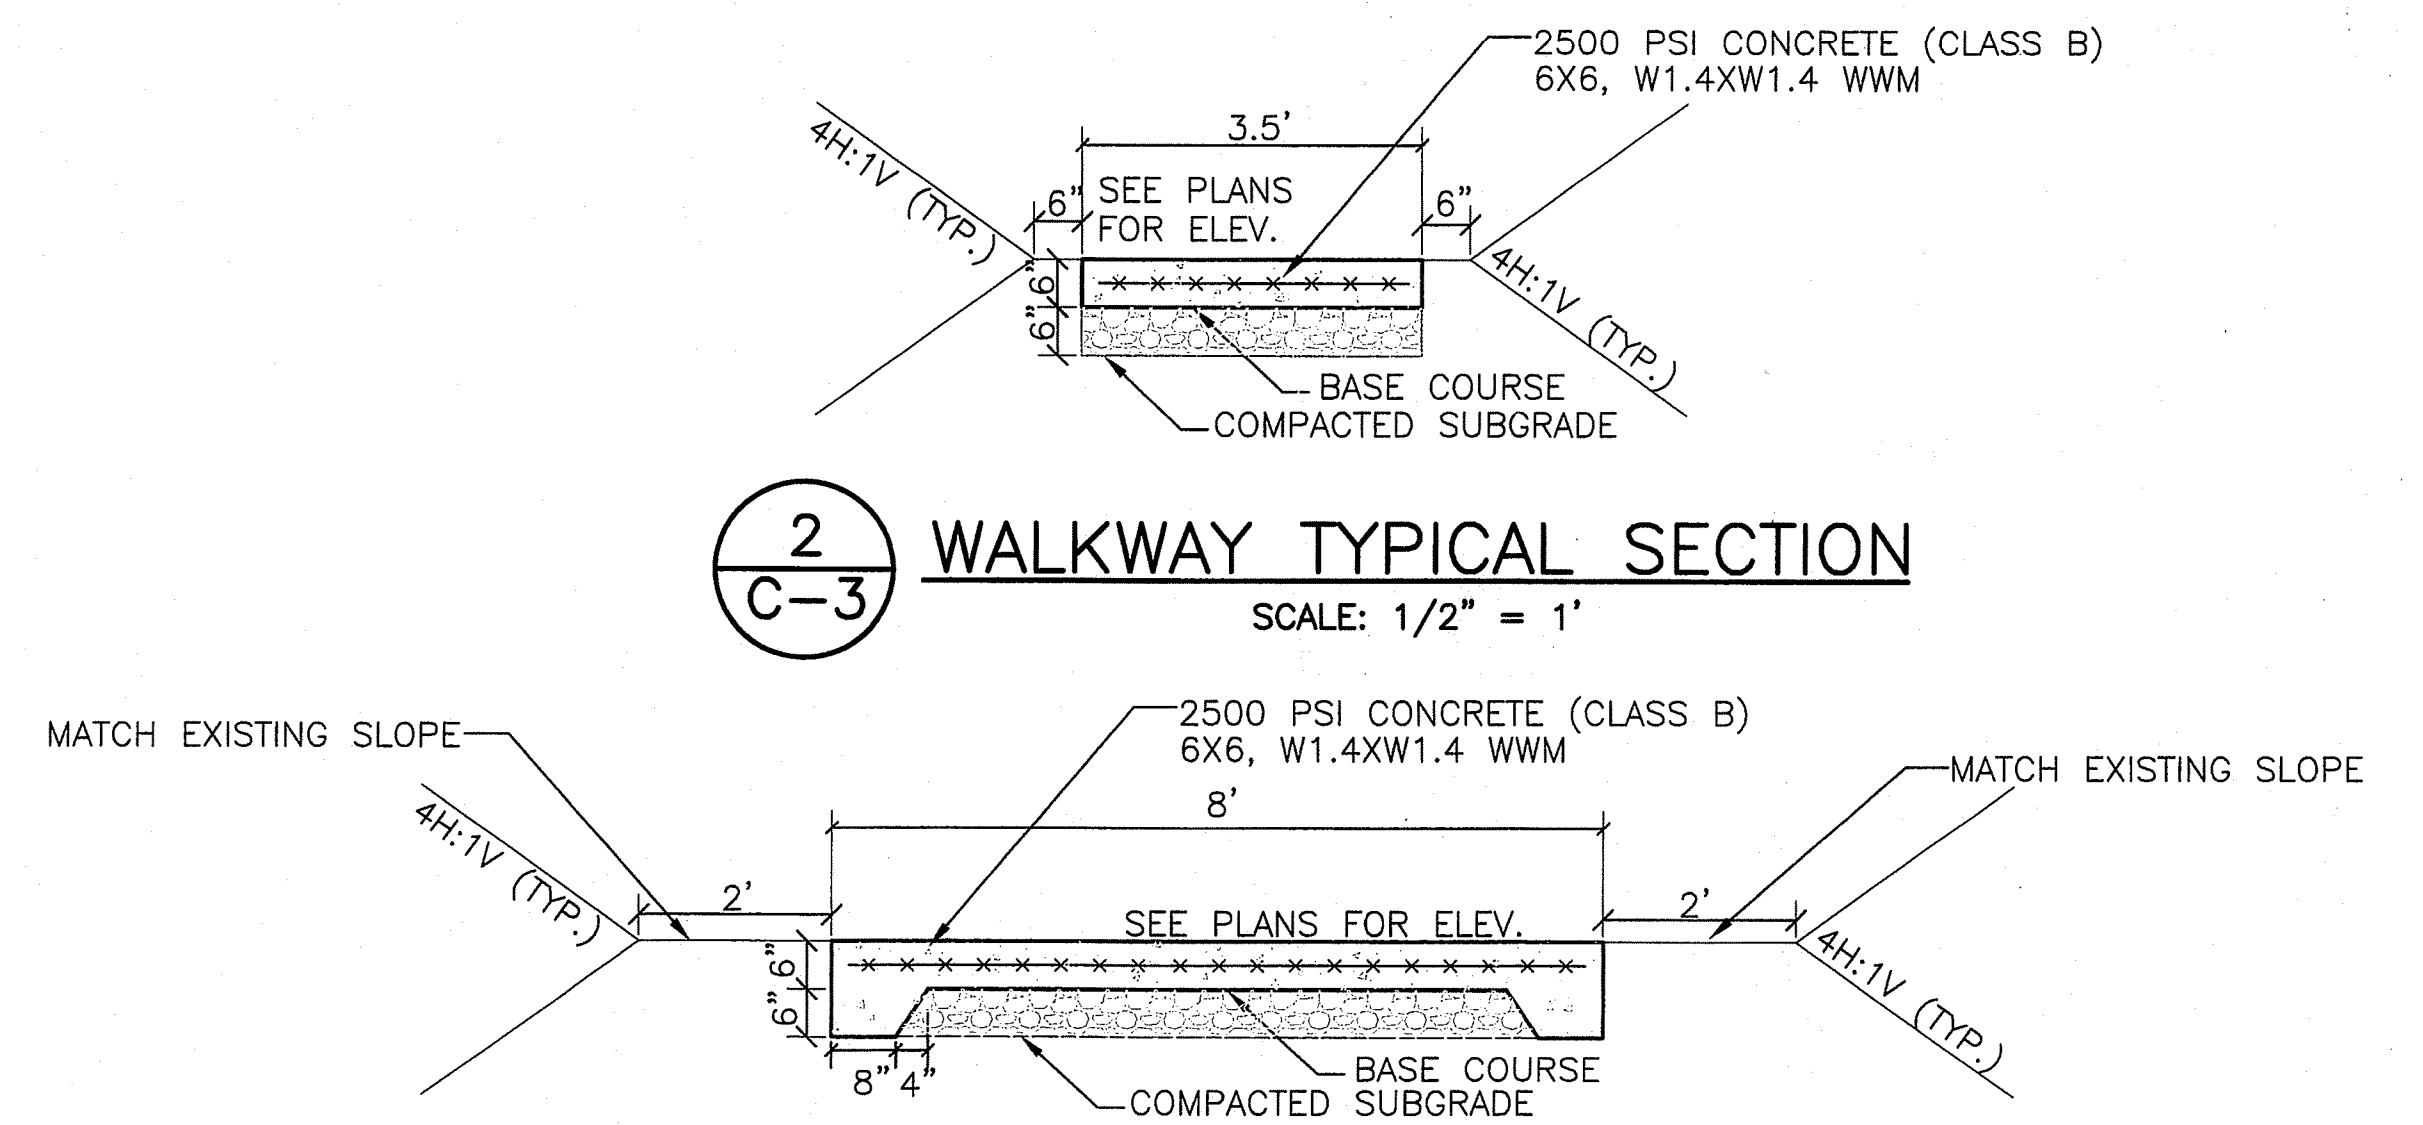


 PICNIC TABLE PAD TYPICAL SECTION
SCALE: 1/2" = 1'

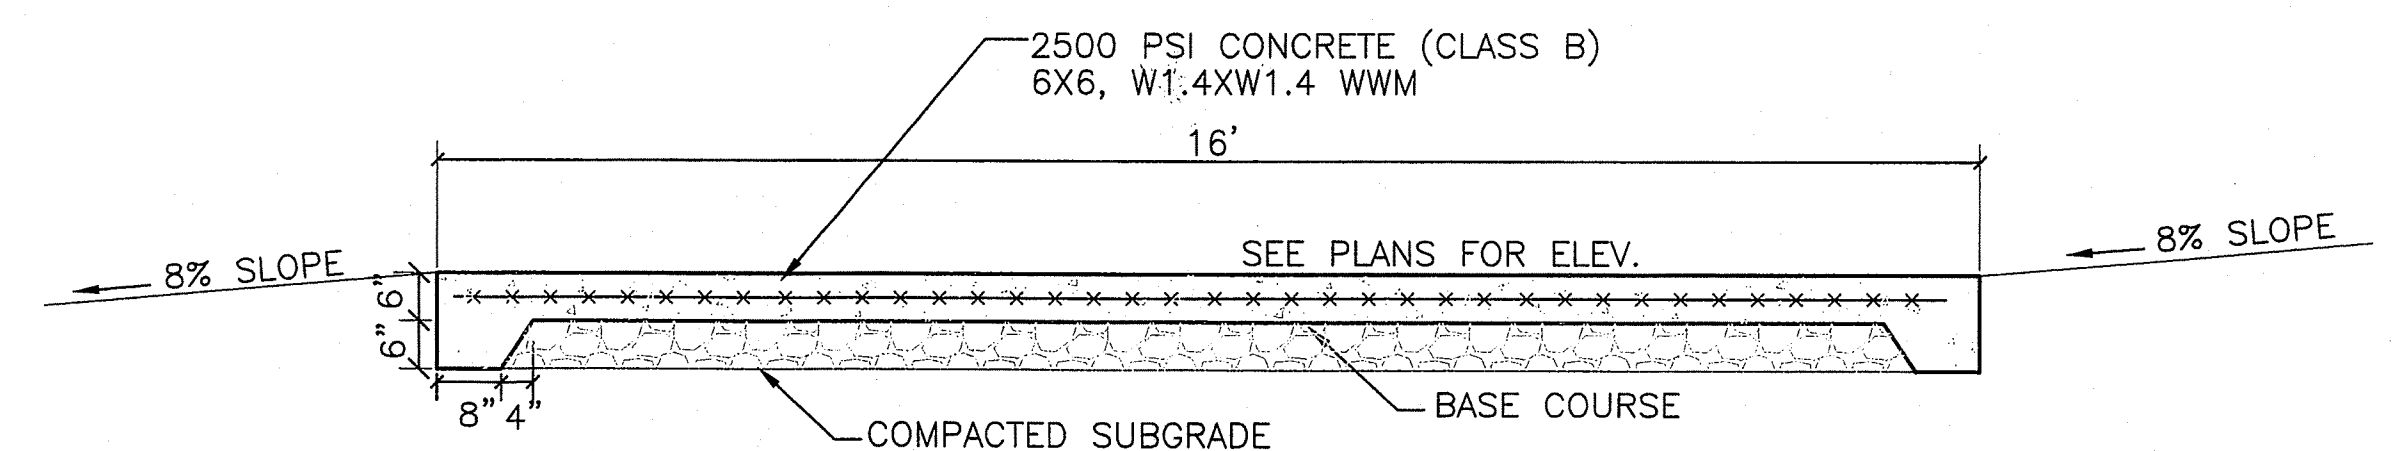

4
C-3

PARKING PAD TYPICAL SECTION FOR LOCATION 2

SCALE: 1/2" = 1'

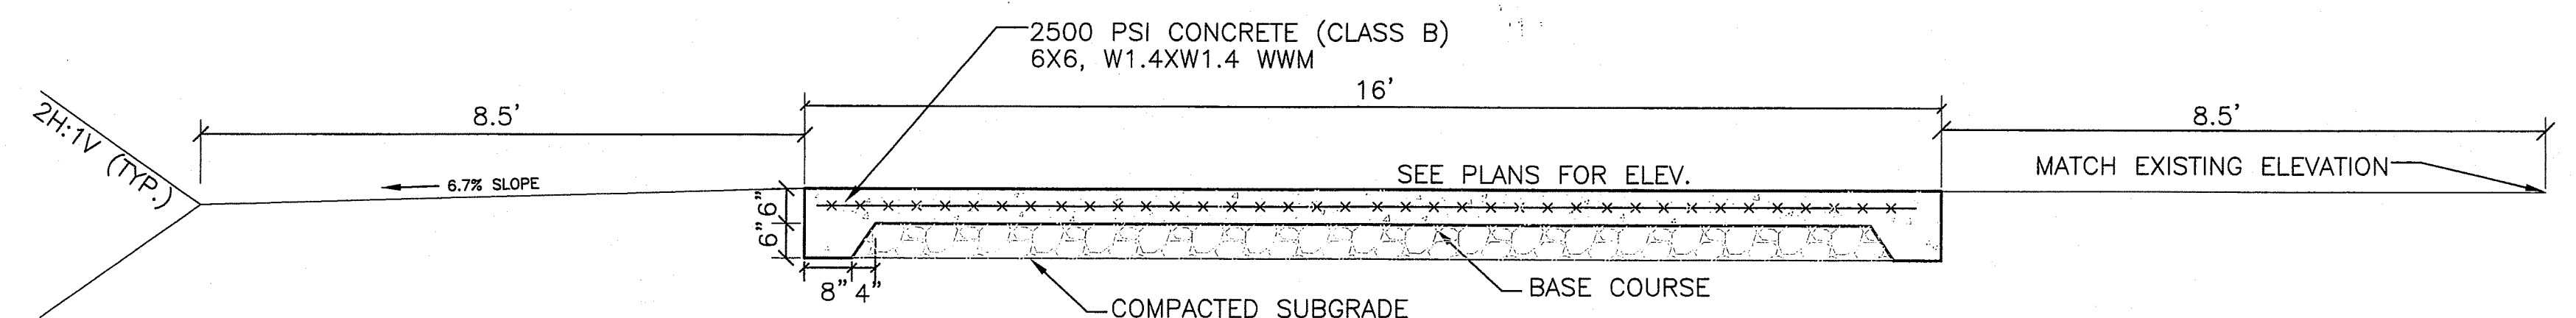




PARKING PAD TYPICAL SECTION FOR LOCATION 1

SCALE: 1/2" = 1'

AS-BUILT DRAWINGS


This certifies the dimensions and detail shown on this sheet reflect the dimensions & details, and specifications as constructed in the field.

BCP CONSTRUCTION OF HAWAII, INC.


Signature & Date

SIGNATURE & DATE			
REVISION NO.	SYM.	DESCRIPTION	SHT./OF DATE APPROVED


STATE OF HAWAII DEPARTMENT OF LAND AND NATURAL RESOURCES ENGINEERING DIVISION	
POLI POLI SPRINGS STATE PARK ADA BARRIER REMOVAL	
LOCATION 1: CAMPGROUND NOTES, SIGN AND SECTION DETAILS	
DESIGNED: M.A. DRAWN: M.A. CHECKED: G.T. APPROVED: <i>[Signature]</i> CHIEF ENGINEER	SUBMITTED: DATE: NOVEMBER 2004 SCALE: AS NOTED AUG - 4 2008 DATE
DRAWING NO. C-3	

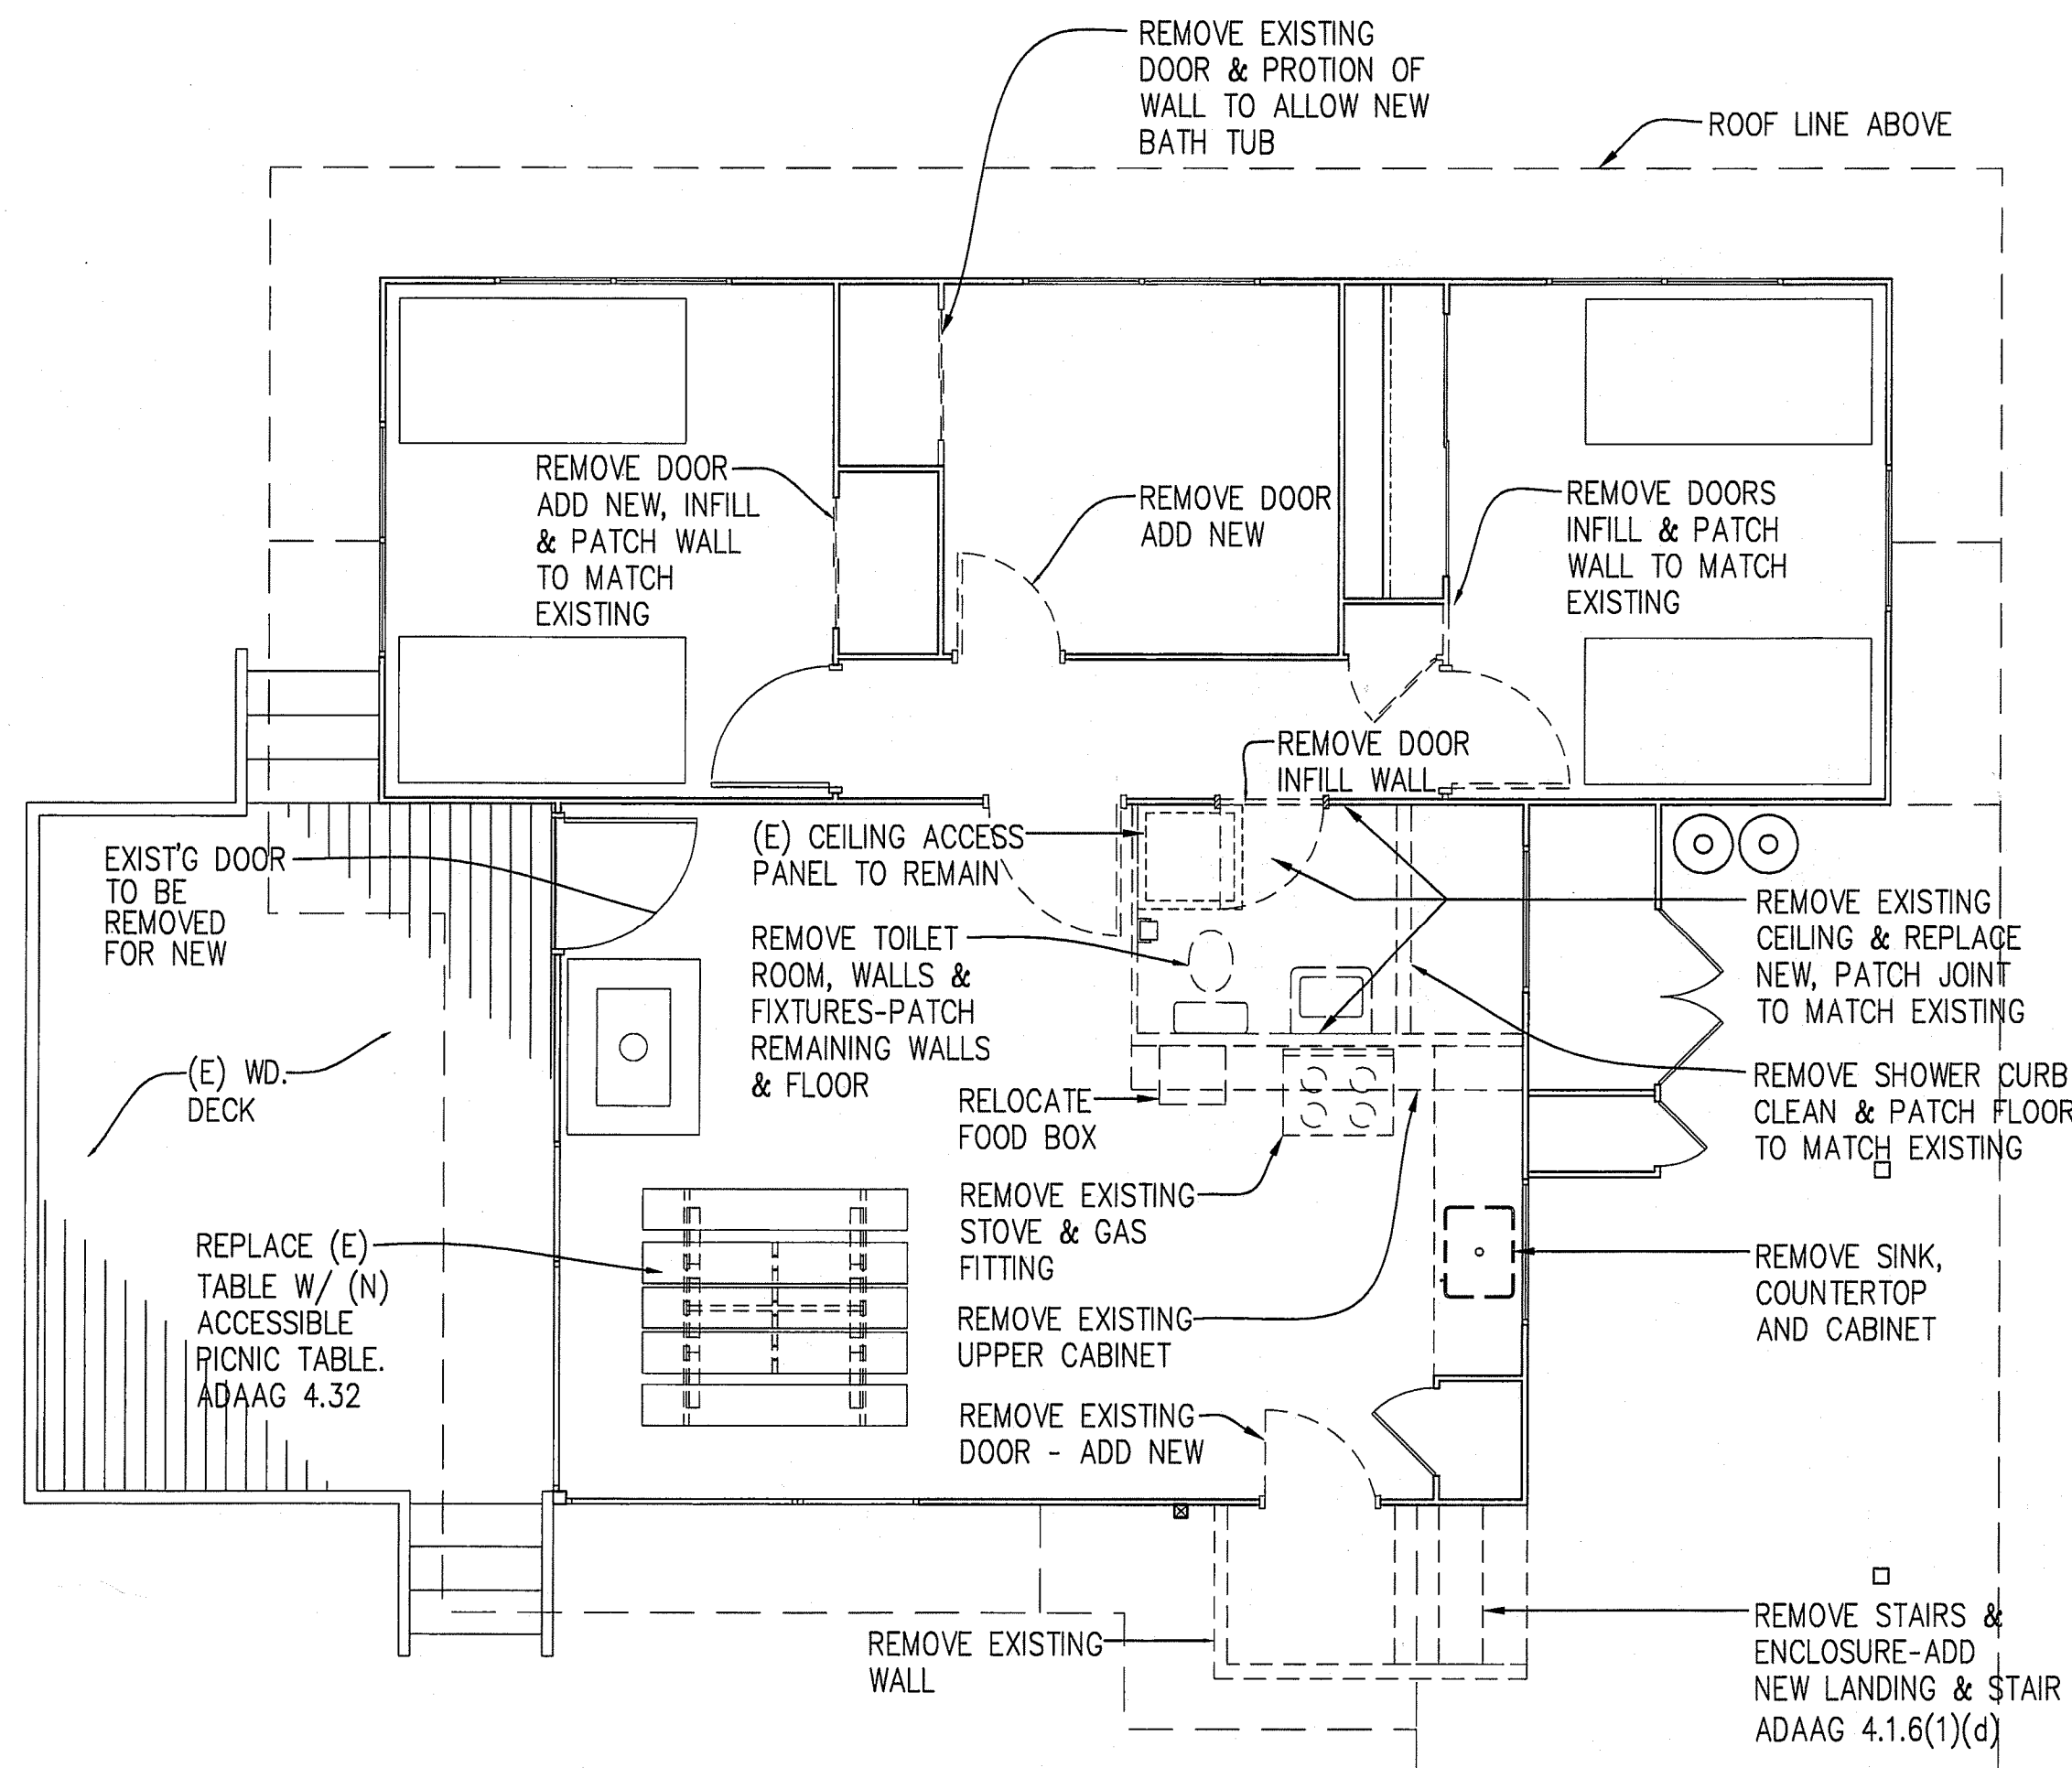


3 EXISTING FLOOR PLAN / DEMOLITION PLAN
SCALE: 1/4"=1'-0"

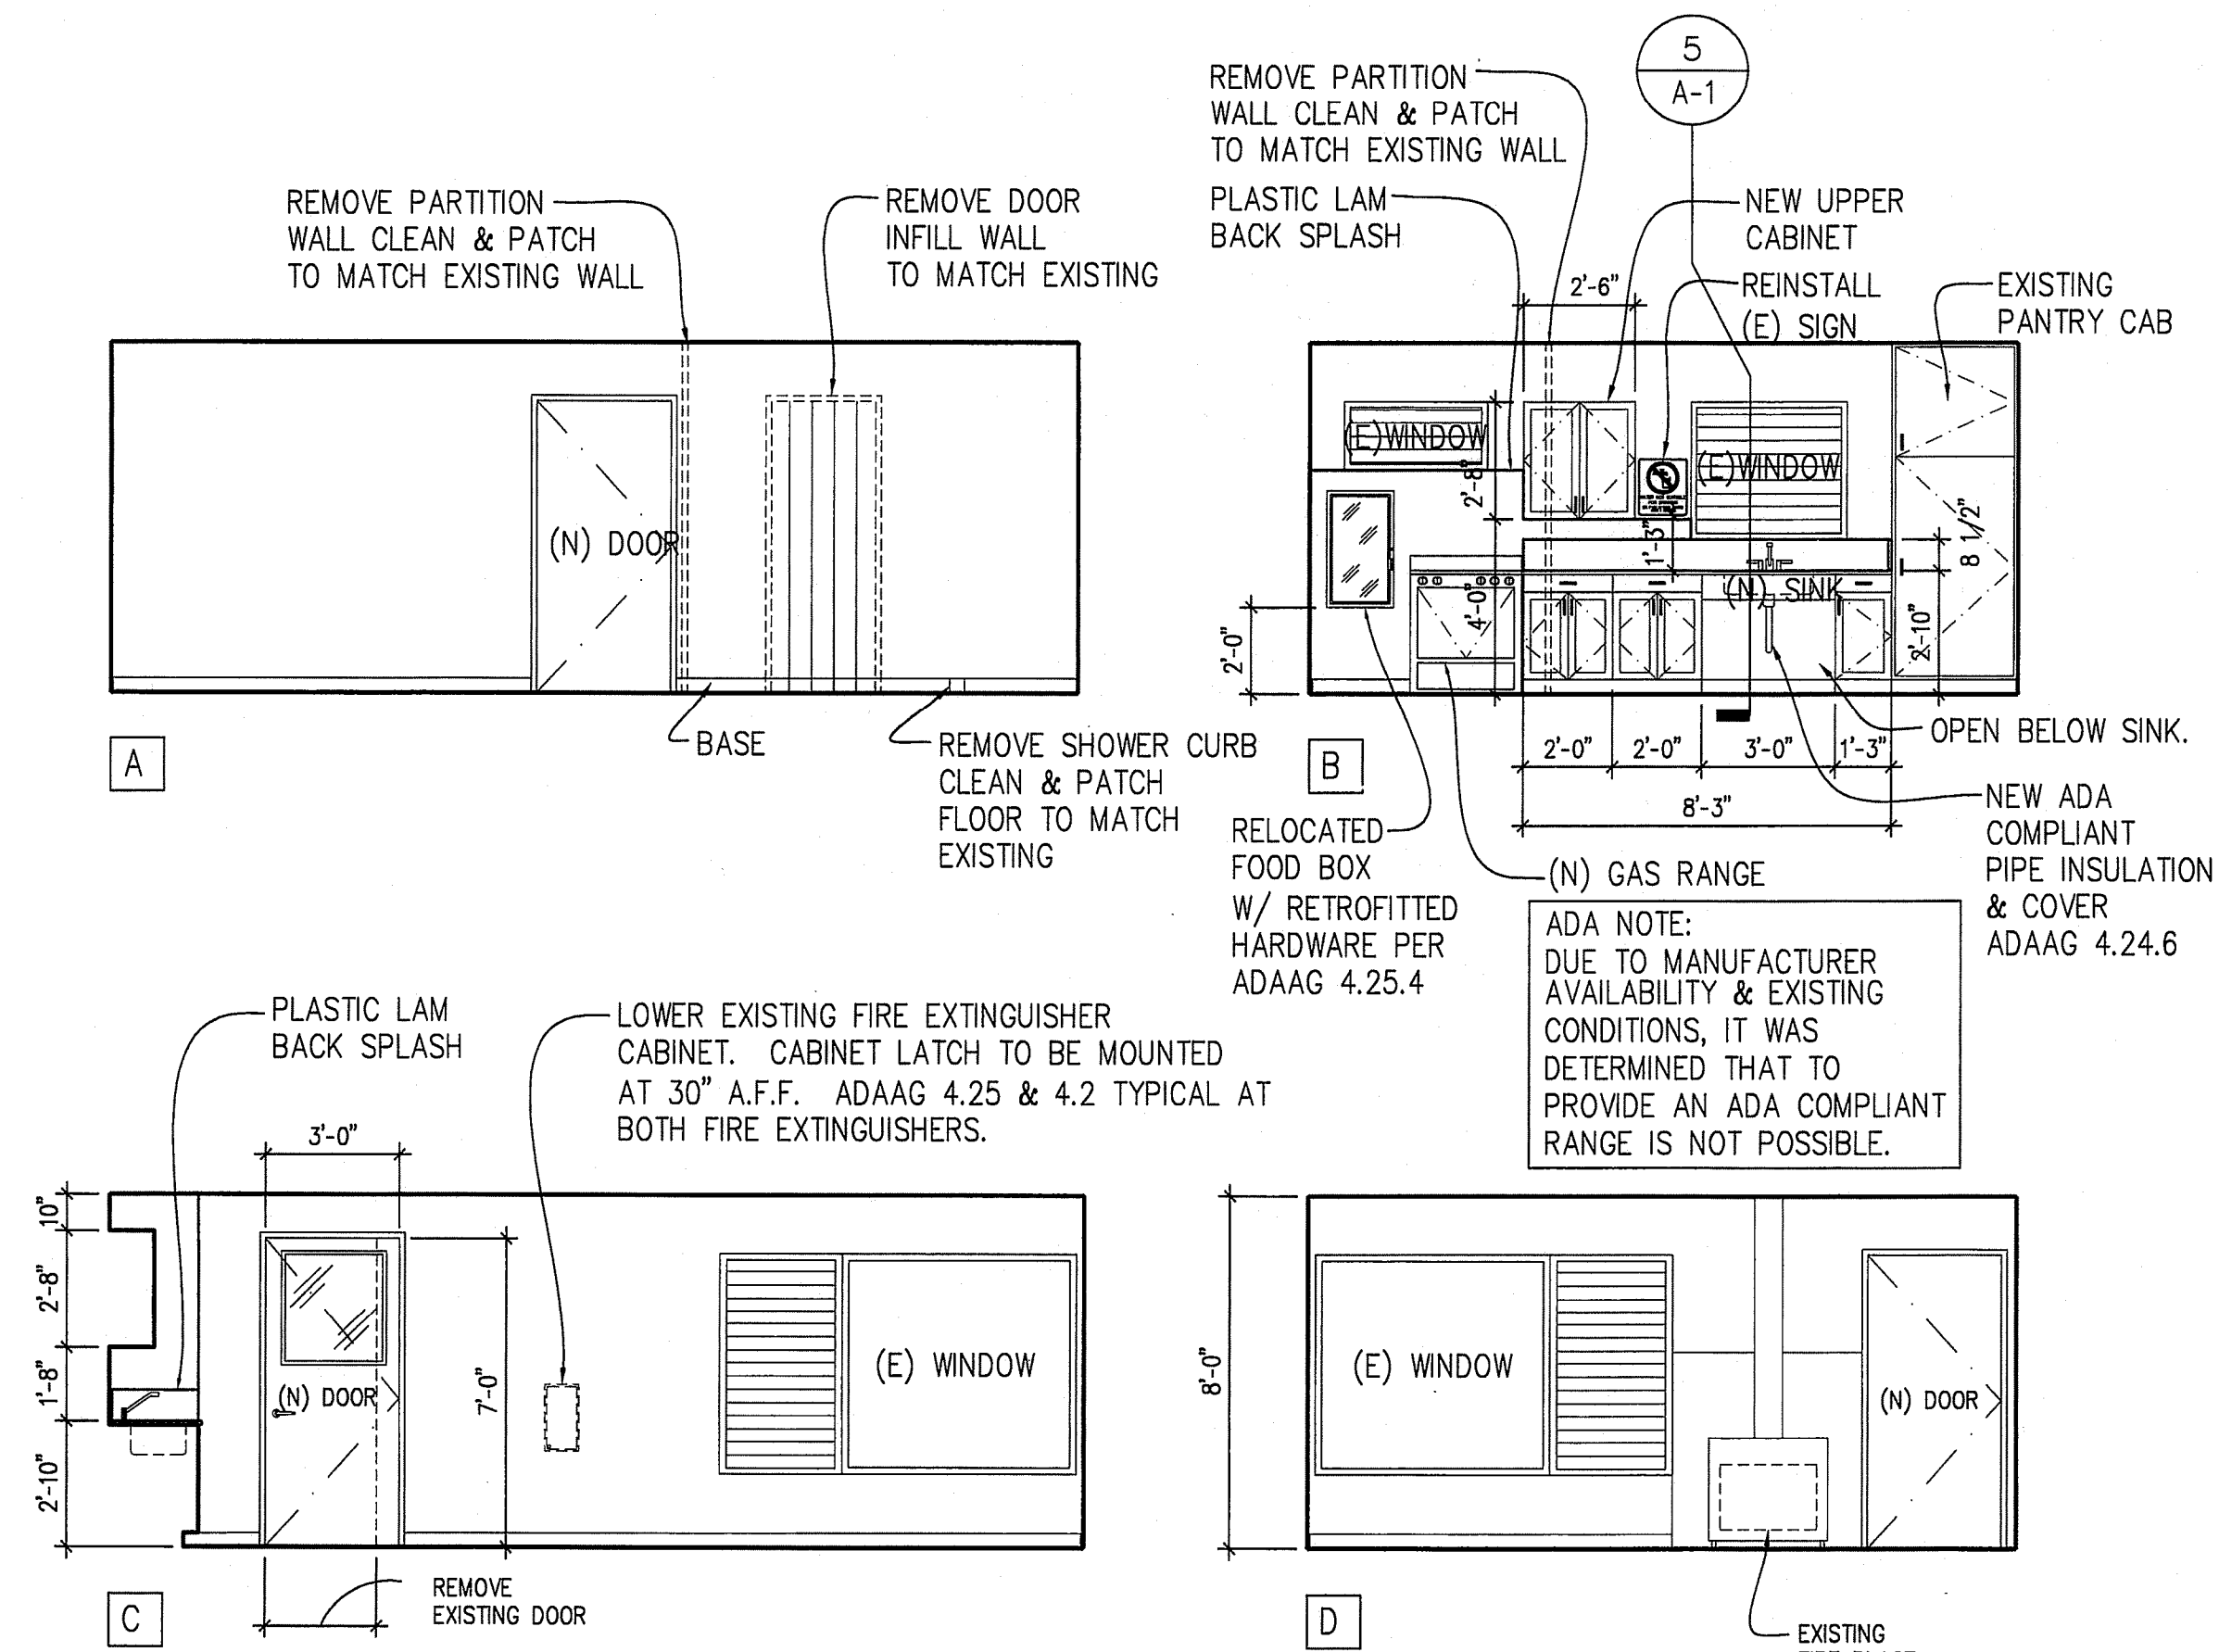


4 GREAT ROOM INTERIOR ELEVATIONS
SCALE: 1/4"=1'-0"

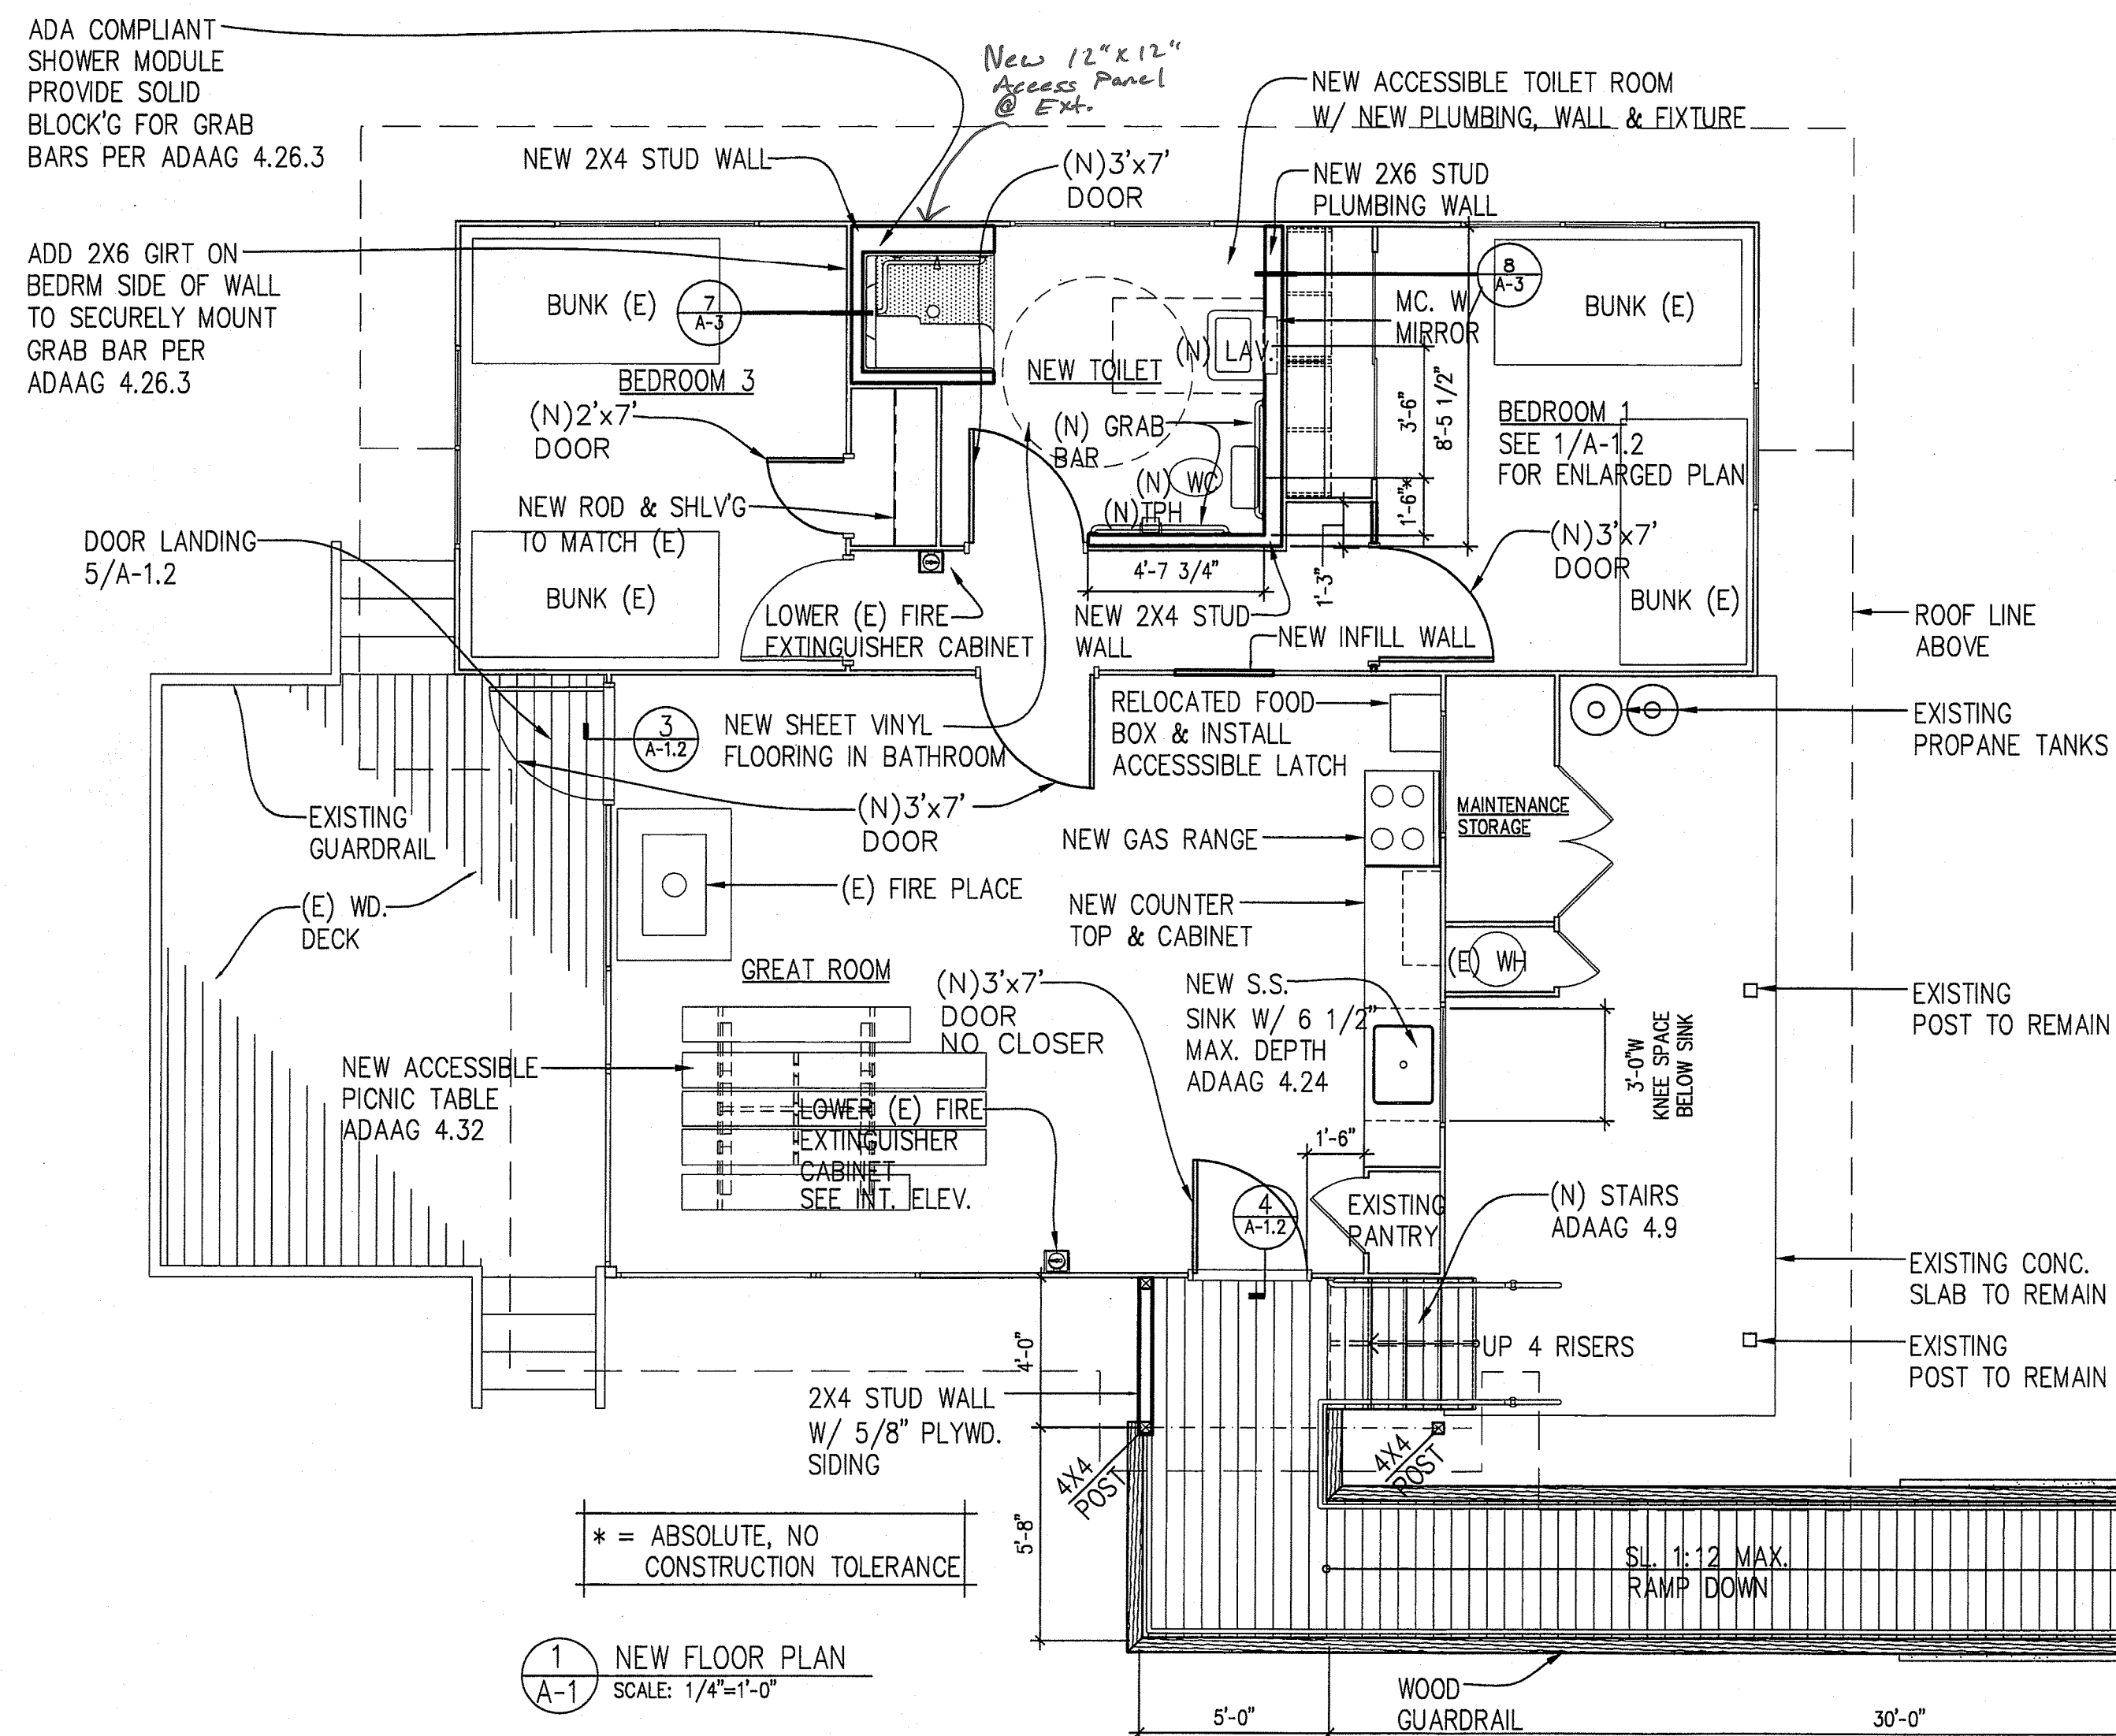

1 NEW FLOOR PLAN
SCALE: 1/4"=1'-0"

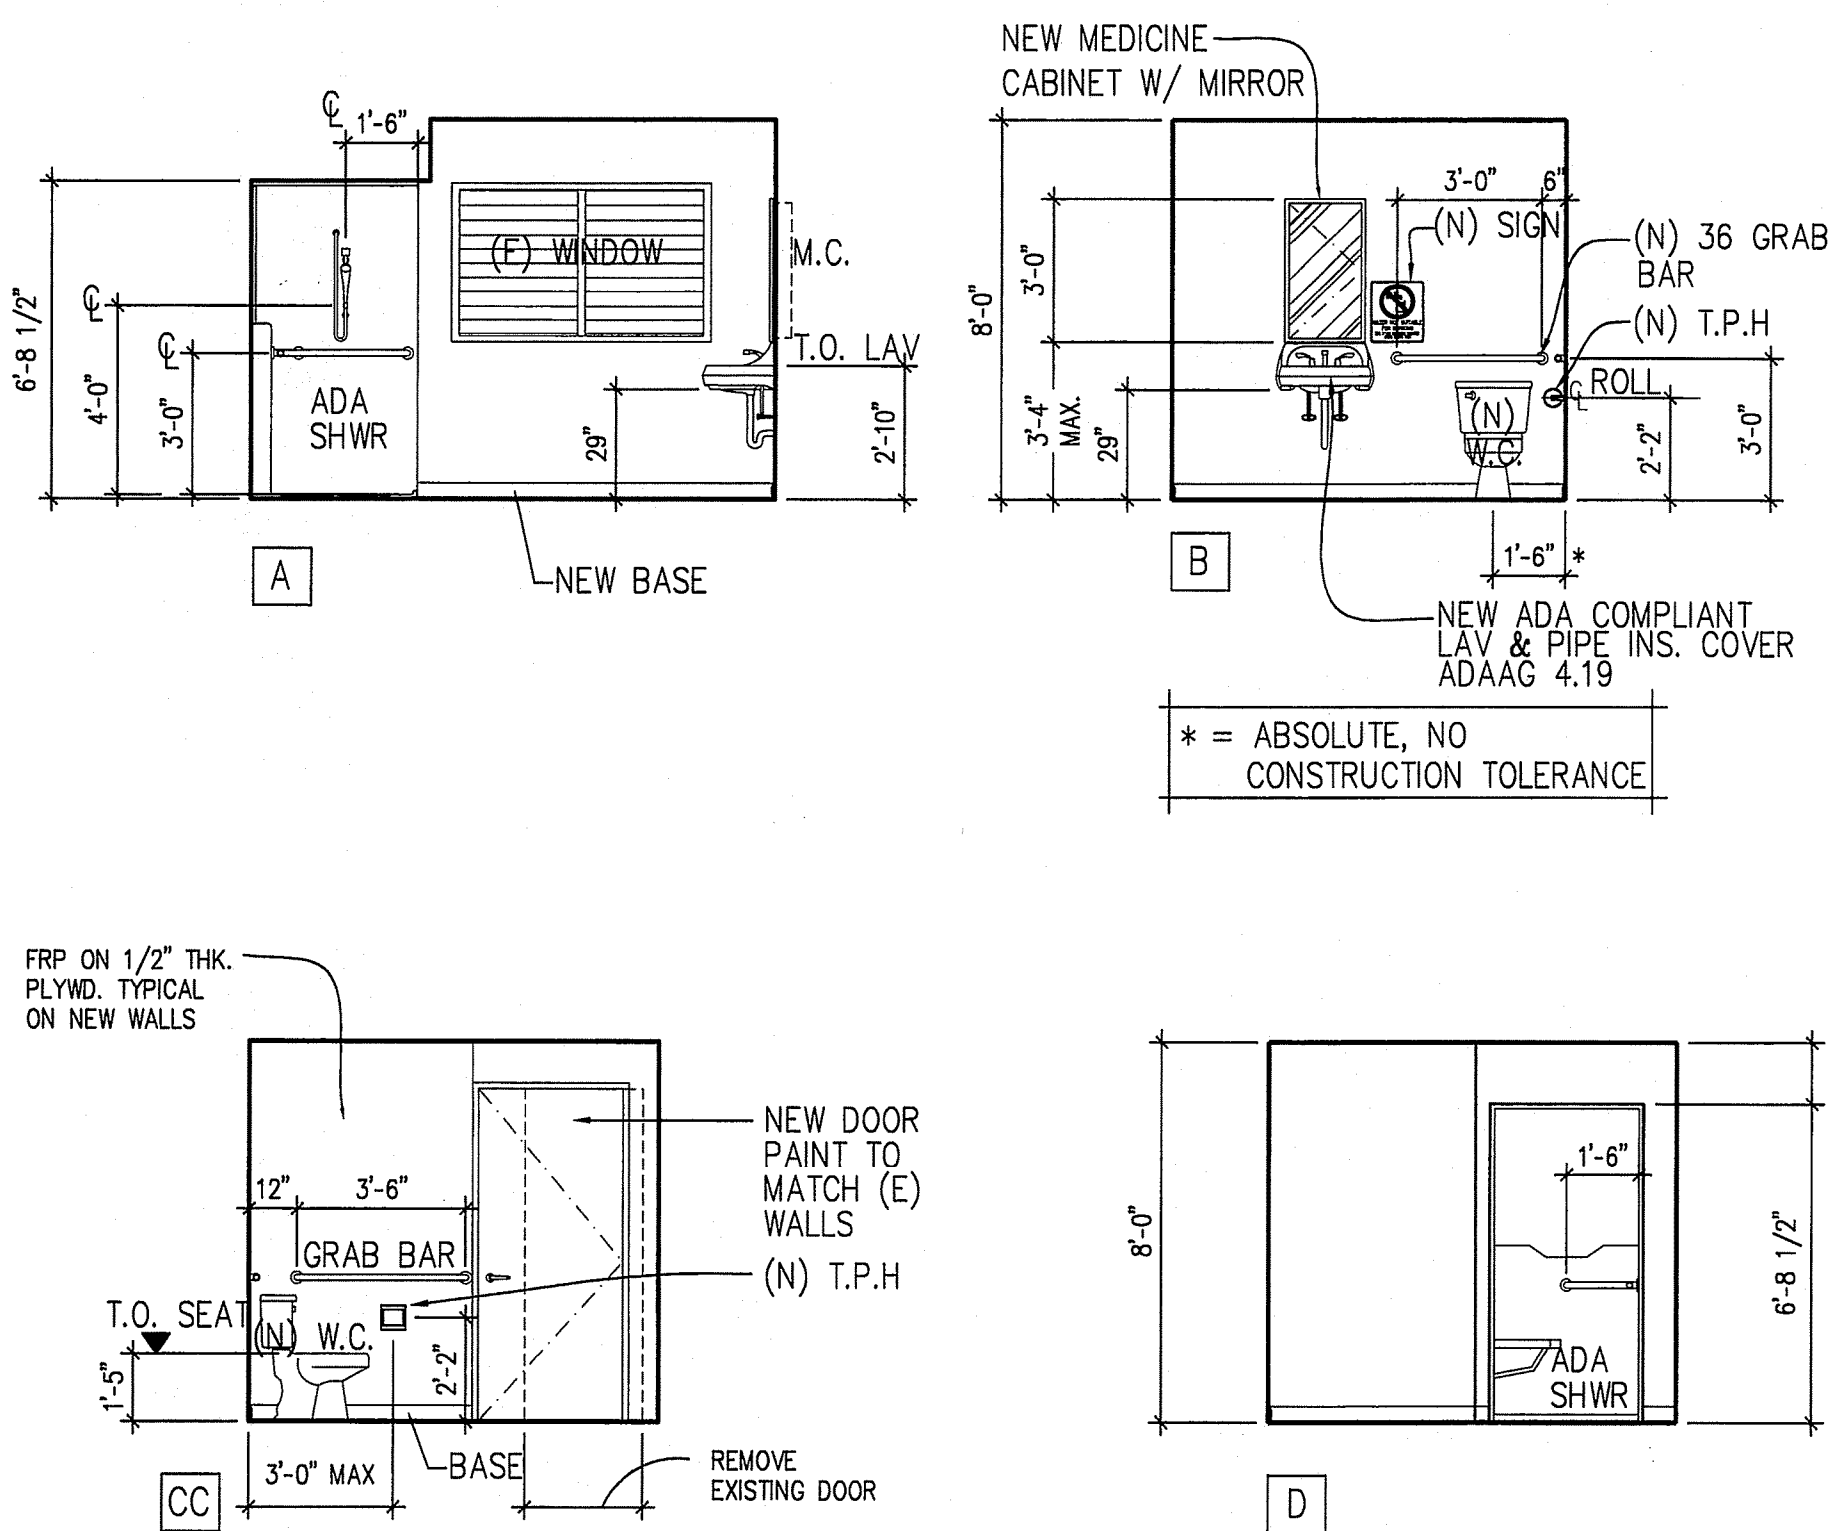

2 BATH ROOM INTERIOR ELEVATIONS
SCALE: 1/4"=1'-0"

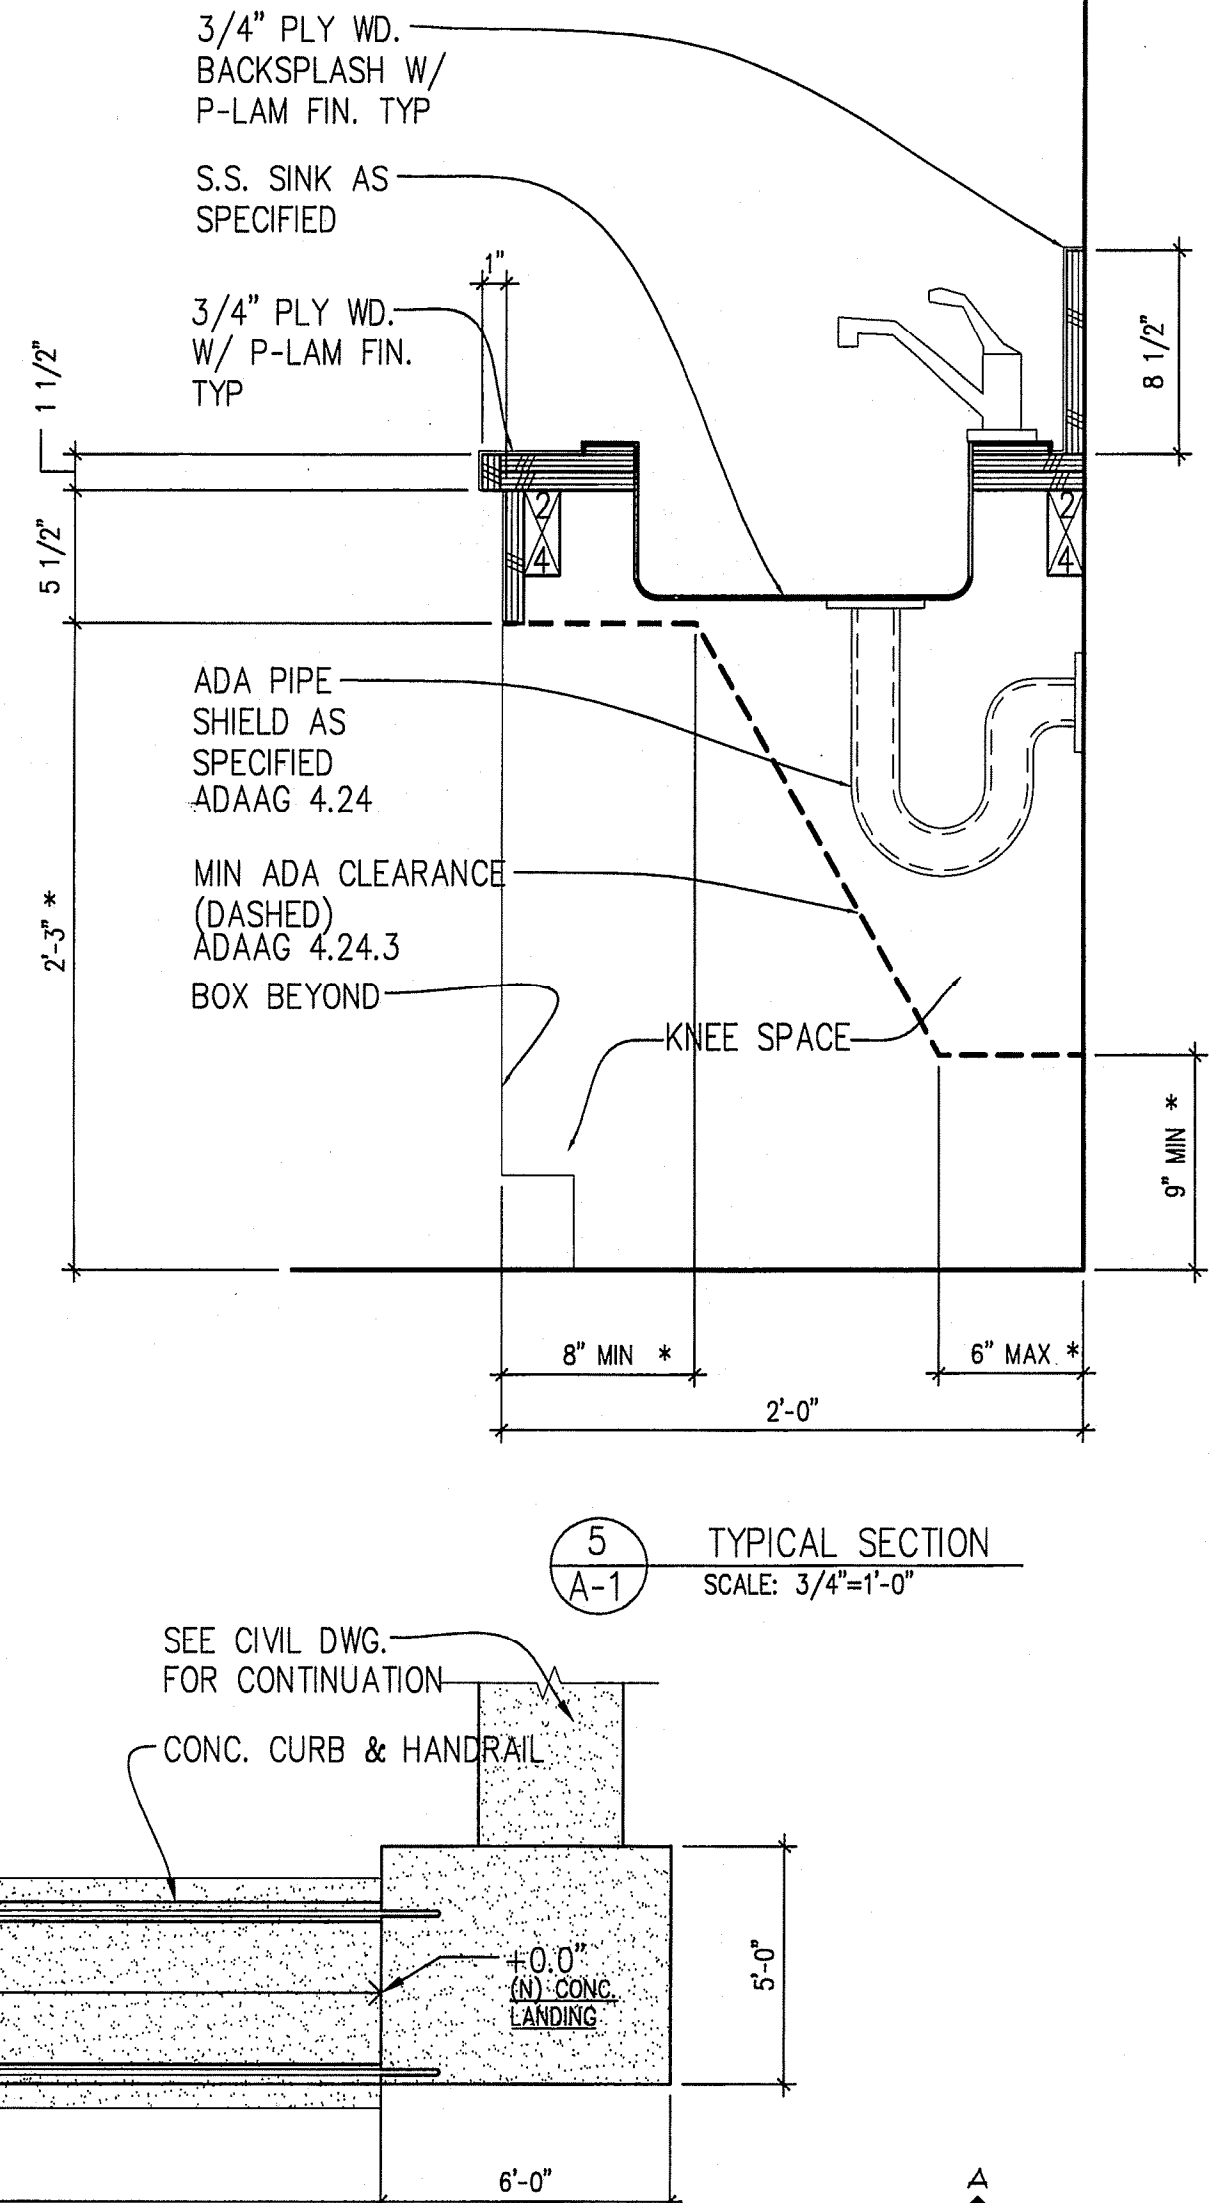

5 TYPICAL SECTION
SCALE: 3/4"=1'-0"

DEMOLITION NOTES:

- (E) = EXISTING
- (N) = NEW
- DR = DOOR
- REMOVE (E) WALLS & CURBS AS SHOWN ON PLAN. PATCH, REPAIR, REFINISH WALLS & FLOORS AS REQUIRED TO MATCH EXISTING.
- REMOVE (E) PLUMBING FIXTURES AS SHOWN ON PLAN. ABANDON (E) WASTE LINES/VENTS WITHIN (E) CONC. SLAB OR WALL. PATCH HOLES WITH NON SHRINK GROUT. REFINISH TO MATCH (E) WALLS OR FLOORS.
- REMOVE (E) BATHROOM ACCESSORIES AS SHOWN ON PLAN. PATCH & REFINISH ALL HOLES AS REQUIRED TO MATCH (E).
- ENSURE POSITIVE DRAINAGE IN ALL AREAS TO THE (E) FLOOR DRAINS.
- RELOCATE ALL (E) PIPING, DRAINS, VENT LINES AS REQ.


AS-BUILT DRAWINGS

This certifies the dimensions and detail shown on this sheet reflect the dimensions & details, and specifications as constructed in the field.

BCP CONSTRUCTION OF HAWAII, INC.


Signature & Date

REVISION NO.	SYM.	DESCRIPTION	SHT / OF	DATE	APPROVED
1		DESIGNED: E.K.	1		
2		DRAWN: J.H.	2		
3		CHECKED: E.K.	3		
4		APPROVED: <i>E.K.</i>	4		
5		APPROVED: <i>Earl H. Kono</i>	5		
6		APPROVED: <i>Earl H. Kono</i>	6		
7		APPROVED: <i>Earl H. Kono</i>	7		
8		APPROVED: <i>Earl H. Kono</i>	8		
9		APPROVED: <i>Earl H. Kono</i>	9		
10		APPROVED: <i>Earl H. Kono</i>	10		
11		APPROVED: <i>Earl H. Kono</i>	11		
12		APPROVED: <i>Earl H. Kono</i>	12		
13		APPROVED: <i>Earl H. Kono</i>	13		
14		APPROVED: <i>Earl H. Kono</i>	14		
15		APPROVED: <i>Earl H. Kono</i>	15		
16		APPROVED: <i>Earl H. Kono</i>	16		
17		APPROVED: <i>Earl H. Kono</i>	17		
18		APPROVED: <i>Earl H. Kono</i>	18		
19		APPROVED: <i>Earl H. Kono</i>	19		
20		APPROVED: <i>Earl H. Kono</i>	20		

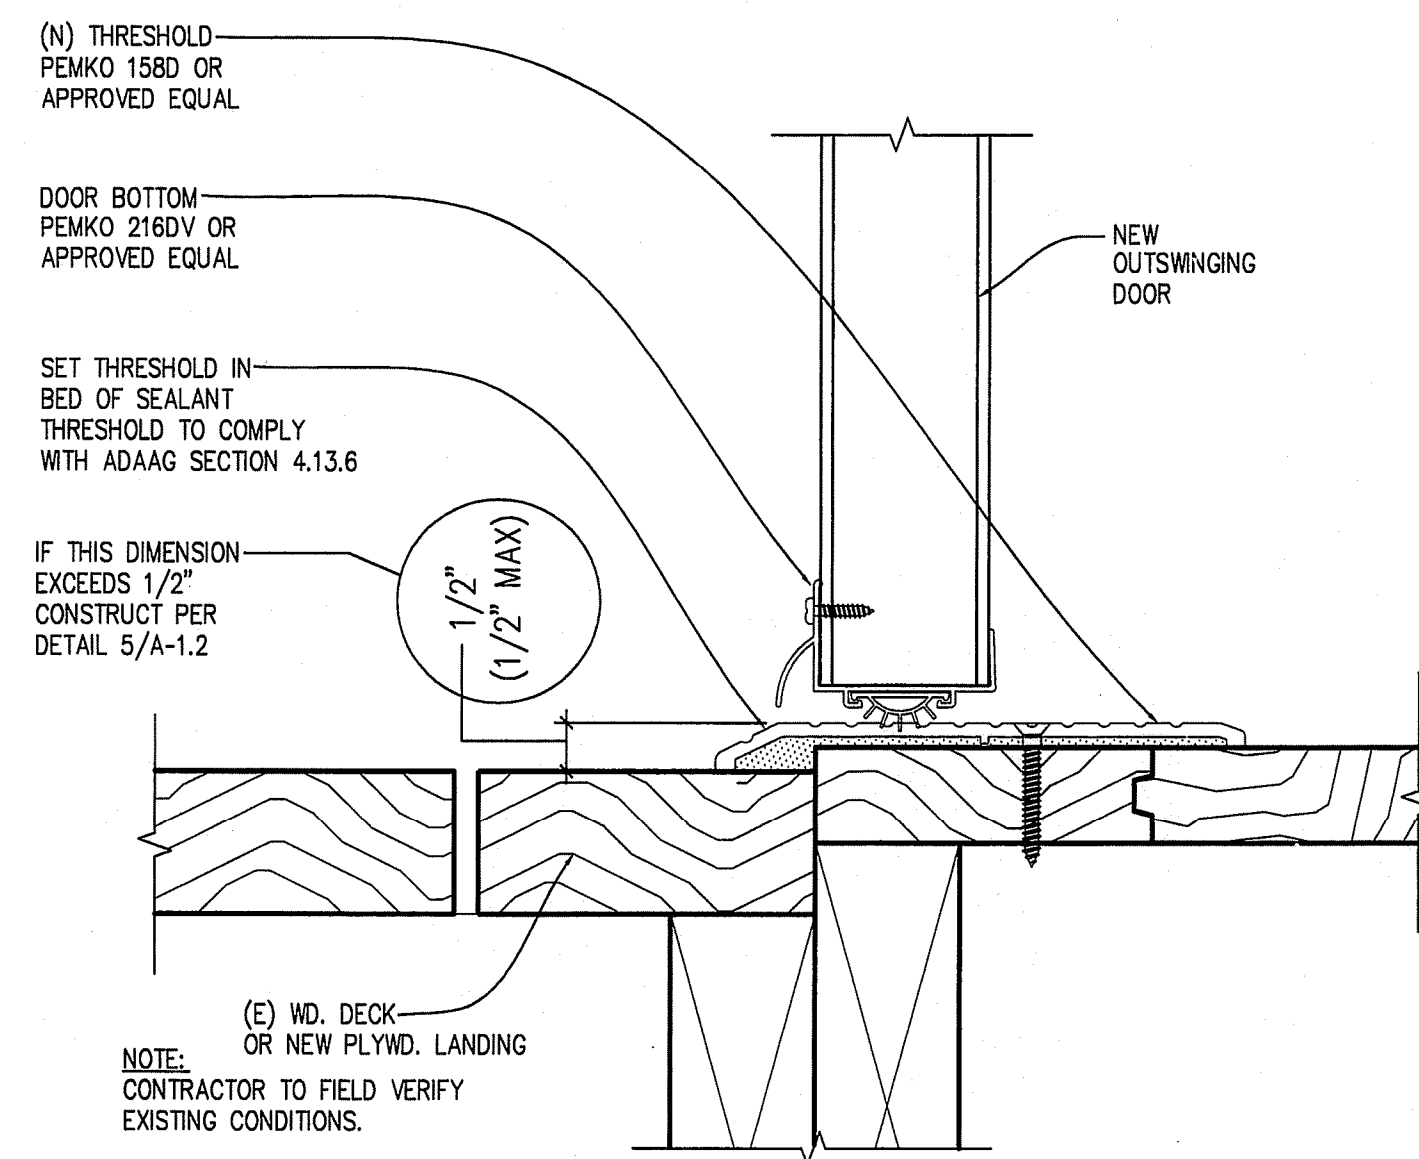


OUT SWINGING DOOR

3 FLOOR TRANSITION DETAIL
A-1.2 SCALE: 6"=1'-0"

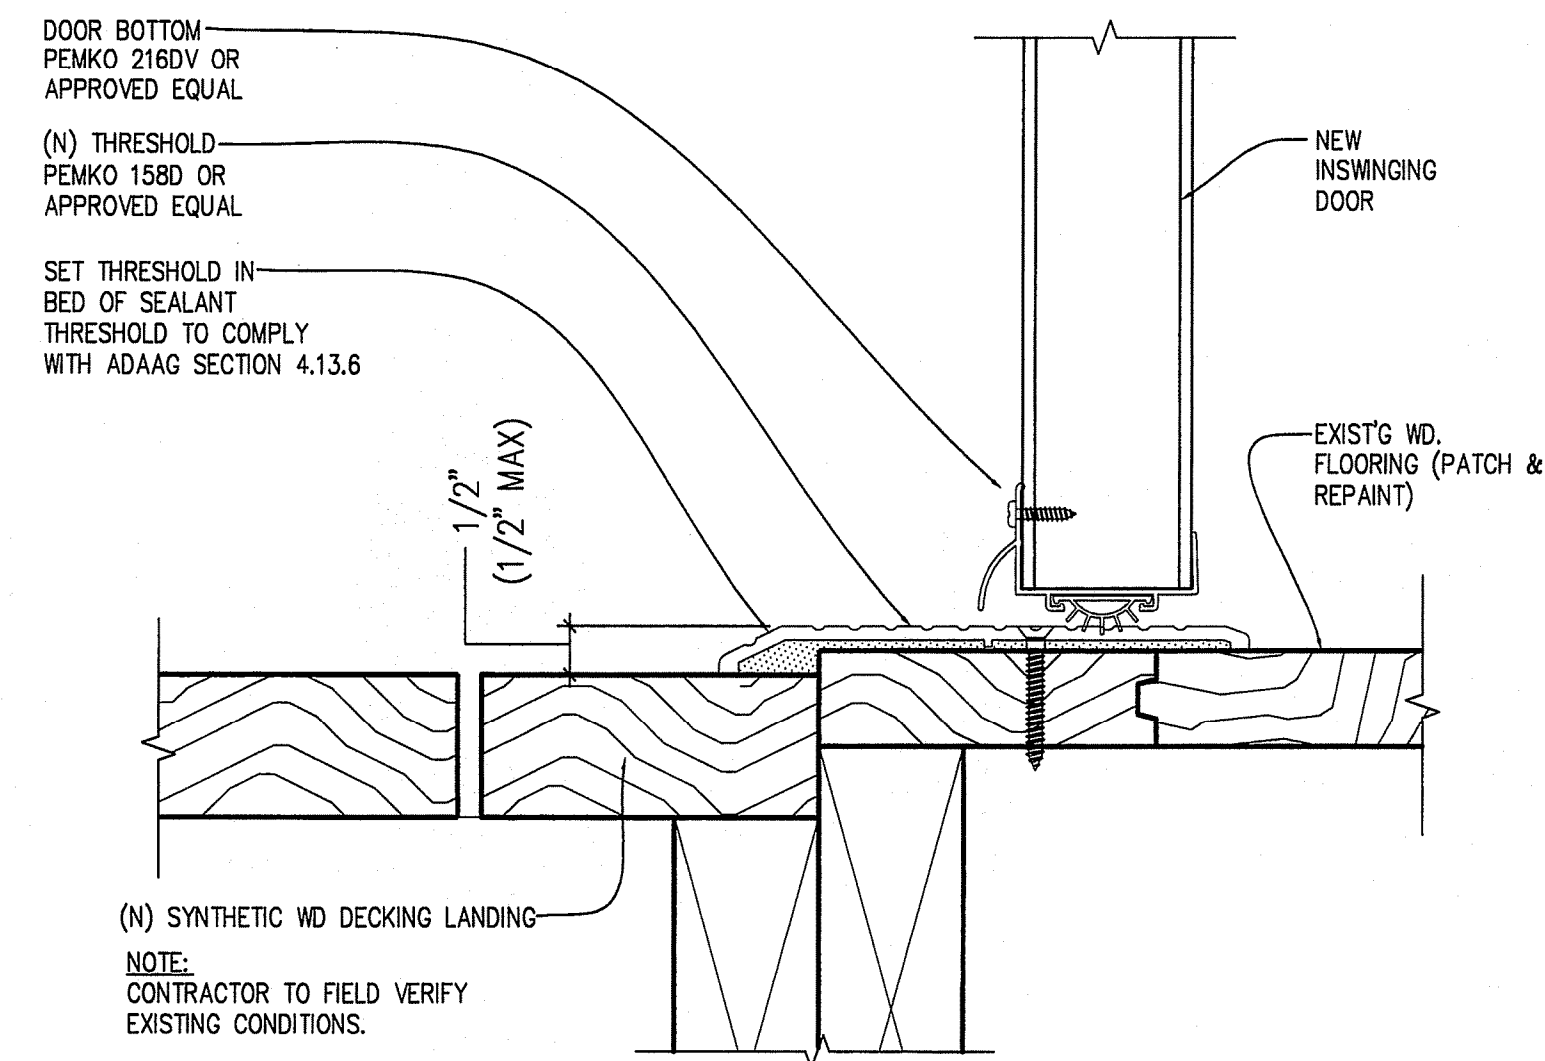


IN SWINGING DOOR


4 FLOOR TRANSITION DETAIL
A-1.2 SCALE: 6"=1'-0"

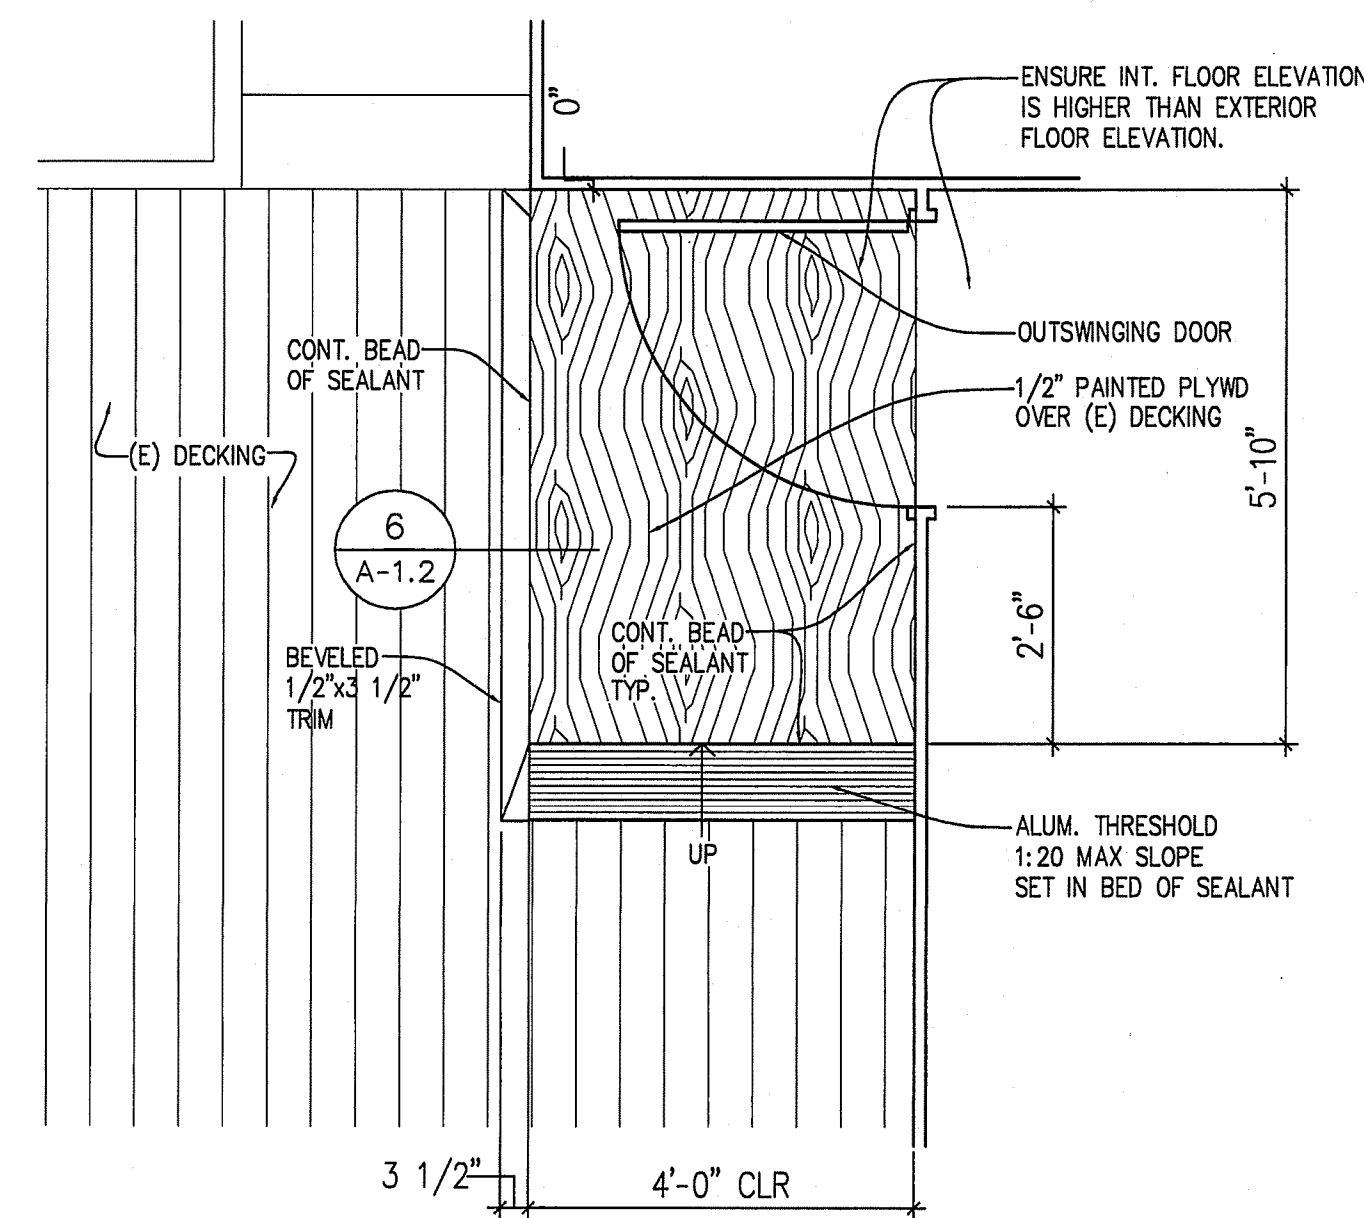


5 LANDING DETAIL
A-1.2 SCALE: 1/2"=1'-0"

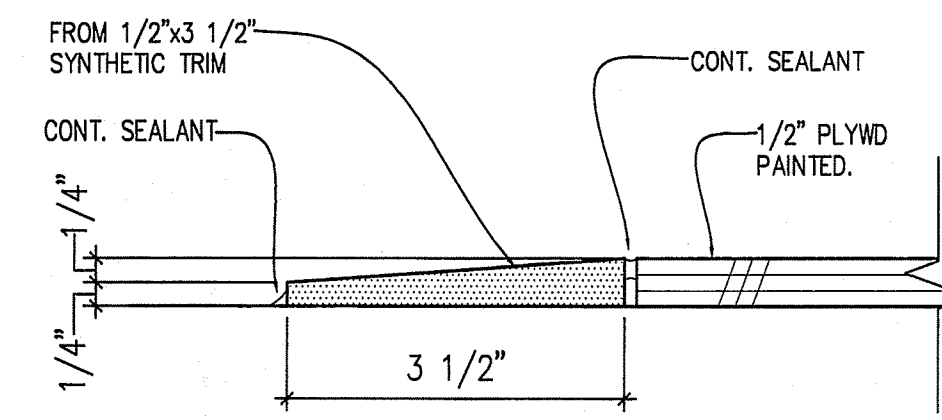

6 LANDING DETAIL
A-1.2 SCALE: 6"=1'-0"

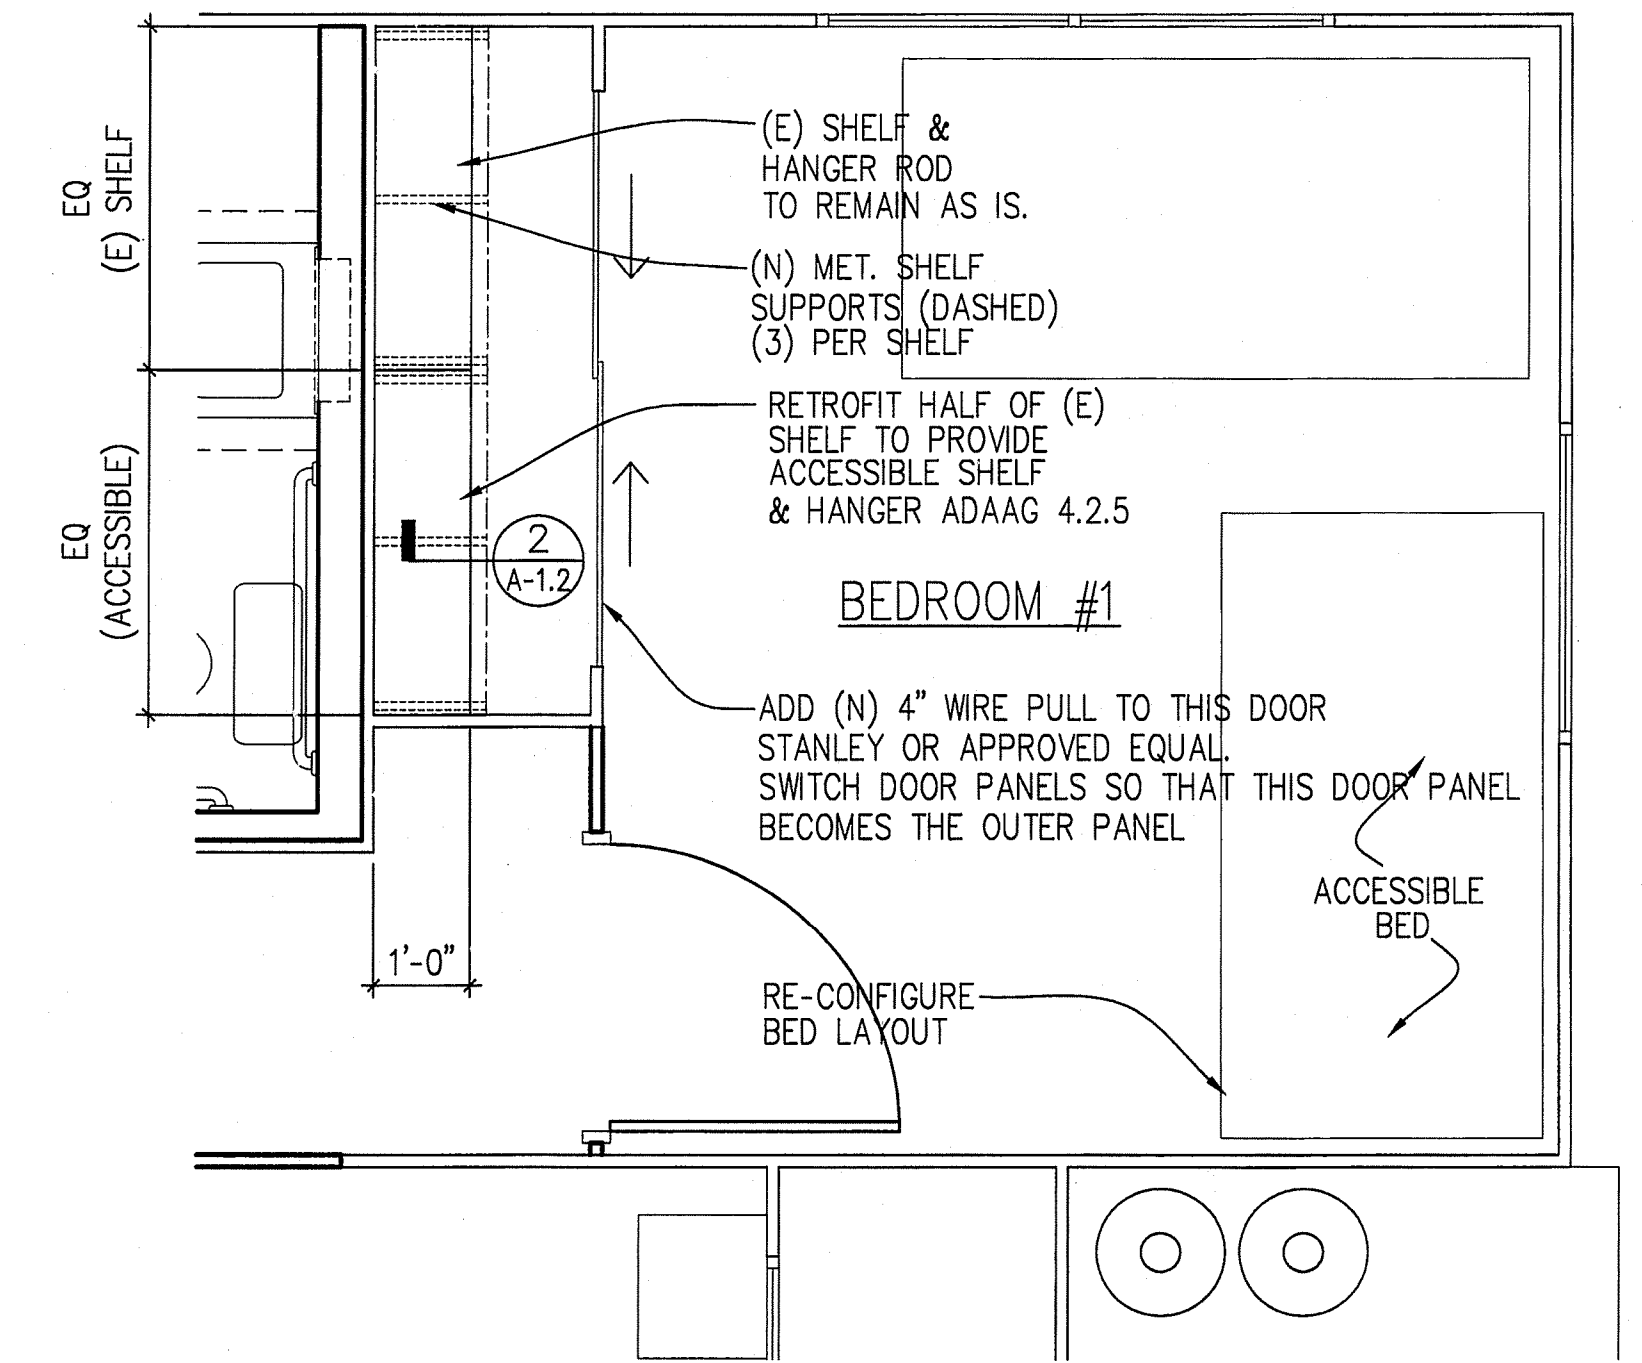

1 ENLARGED PLAN
A-1.2 SCALE: 1/2"=1'-0"












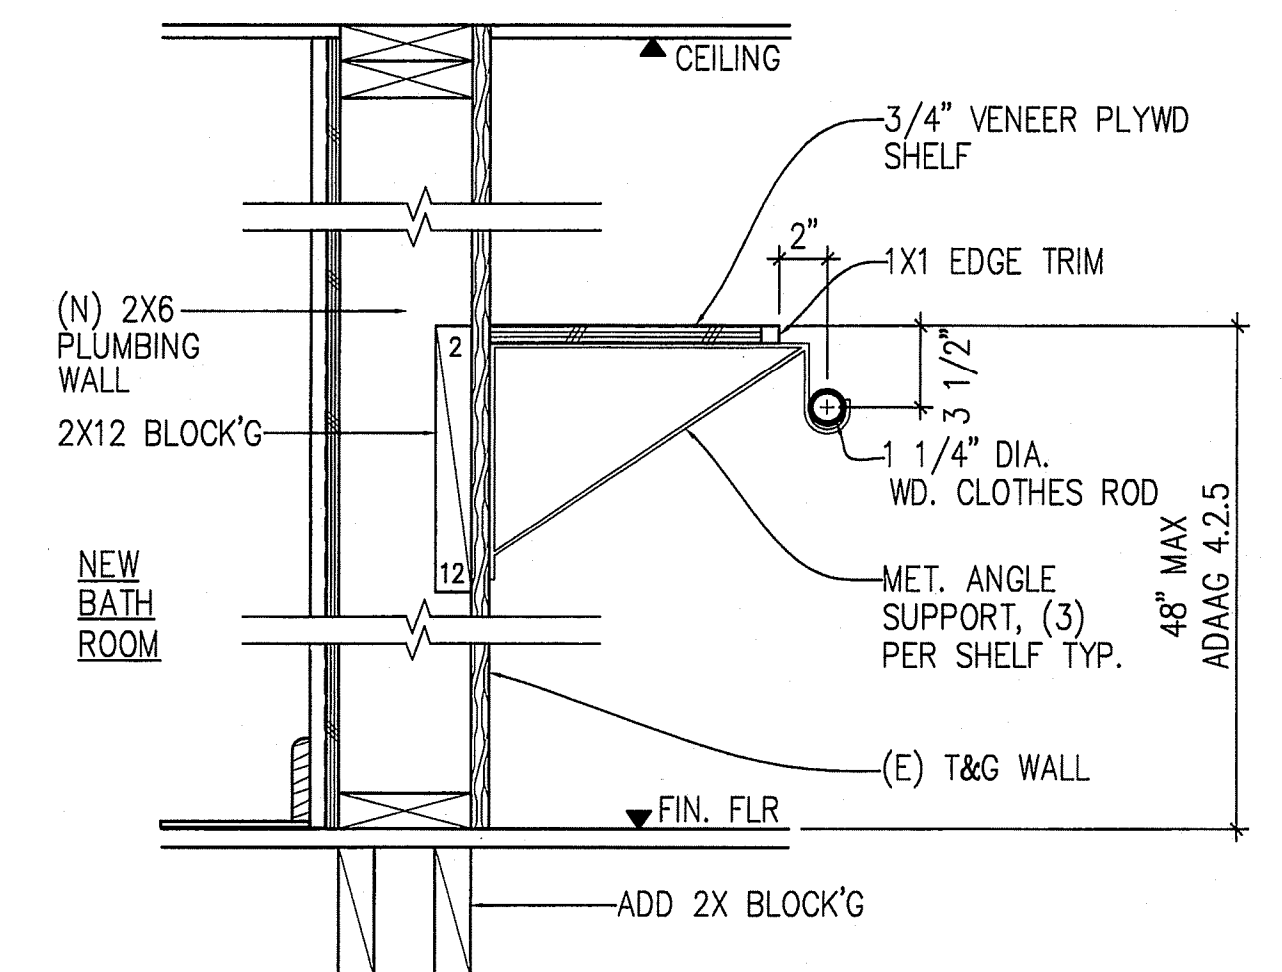


2 ACCESSIBLE CLOSET SHELF DETAIL
A-1.2

AS-BUILT DRAWINGS
This certifies the dimensions and detail shown on this sheet reflect the dimensions & details and specifications as constructed in the field.

BCP CONSTRUCTION OF HAWAII, INC.
Signature & Date: *[Signature]* 10-3-07

REVISION NO.	SYM.	DESCRIPTION	SHT / OF	DATE	APPROVED
EARL H. KONO LICENSED PROFESSIONAL ARCHITECT No. 4455 HAWAII, U.S.A. <i>Earl H. Kono</i> THIS WORK WAS PREPARED BY ME OR UNDER MY SUPERVISION. CONSTRUCTION OF THIS PROJECT WILL BE UNDER MY OBSERVATION. APRIL 30, 2006 LICENSE EXPIRATION DATE STATE OF HAWAII DEPARTMENT OF LAND AND NATURAL RESOURCES ENGINEERING DIVISION POLIPOLI SPRING STATE MONUMENT ADA BARRIER REMOVAL LOCATION 2: CABIN FLOOR PLANS & DETAILS DESIGNED: E.K. SUBMITTED: RIECKE SUNNLAND KONO ARCHITECTS LTD. DRAWN: J.H. DATE: JANUARY, 2005 CHECKED: E.K. SCALE: AS NOTED APPROVED: <i>[Signature]</i> AUG -4 2005 CHIEF ENGINEER DATE: DRAWING NO. A-1.2					

     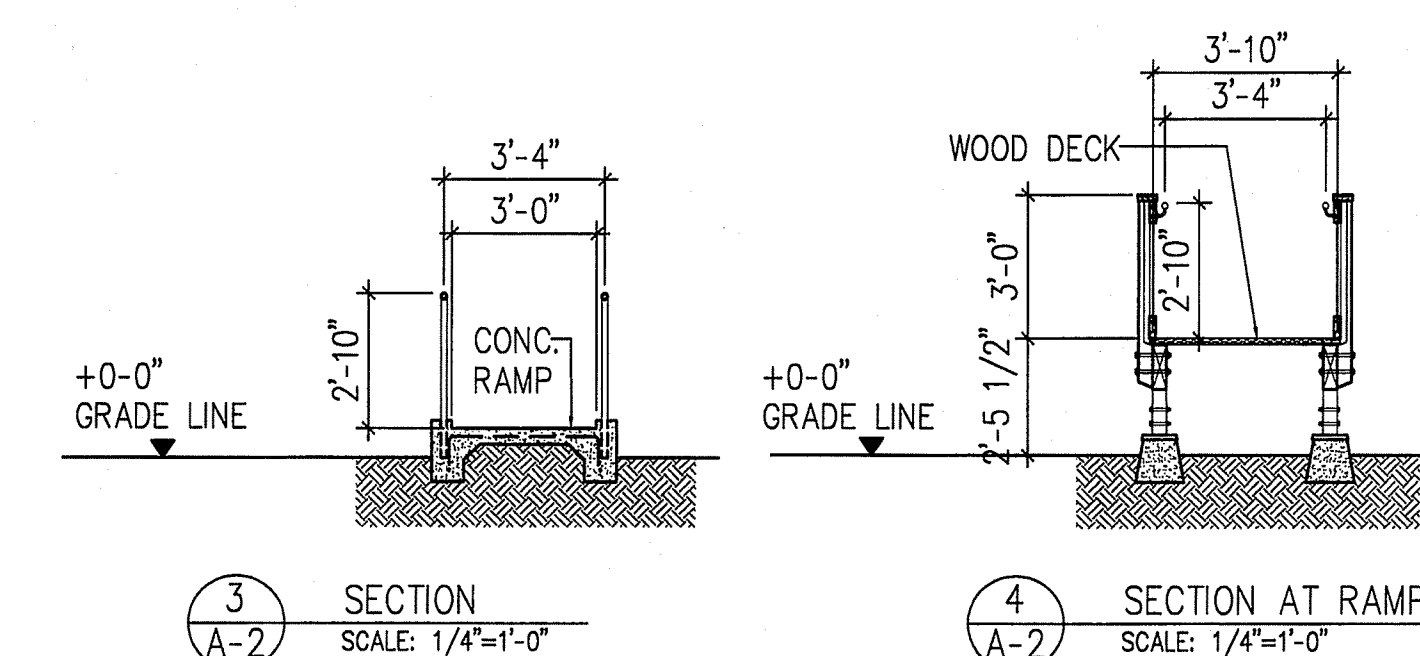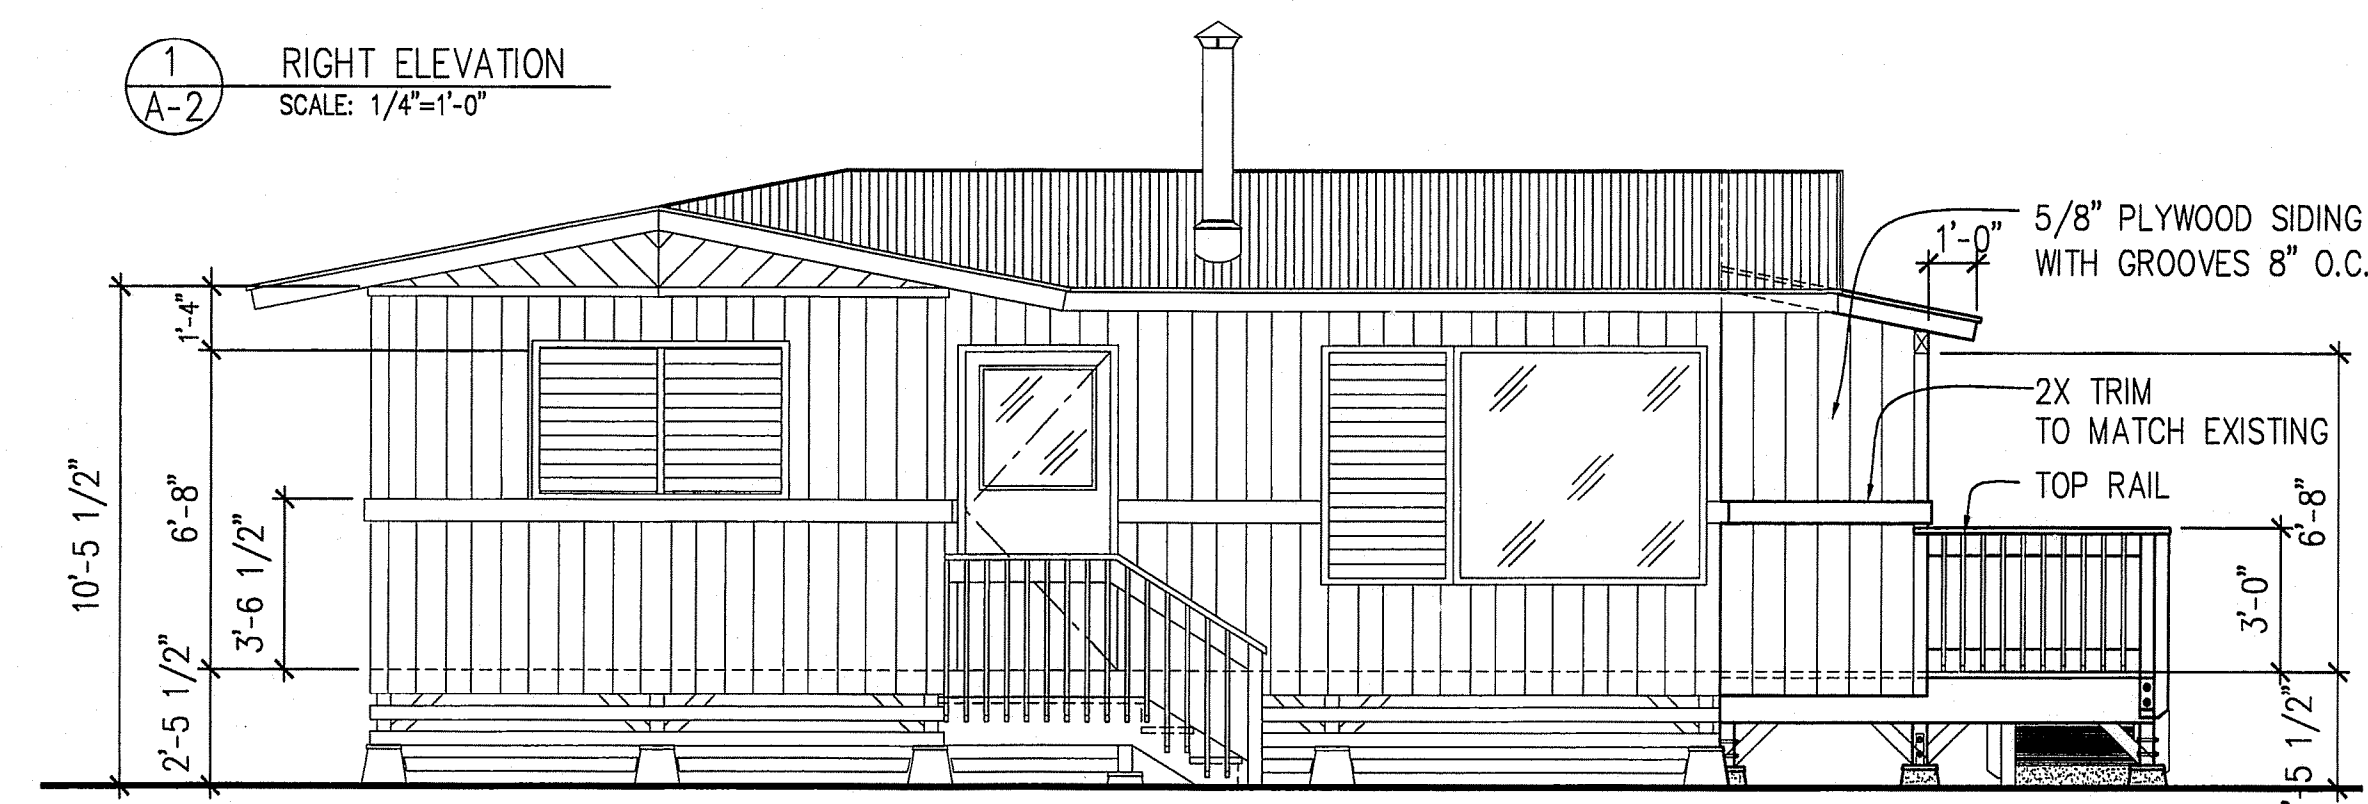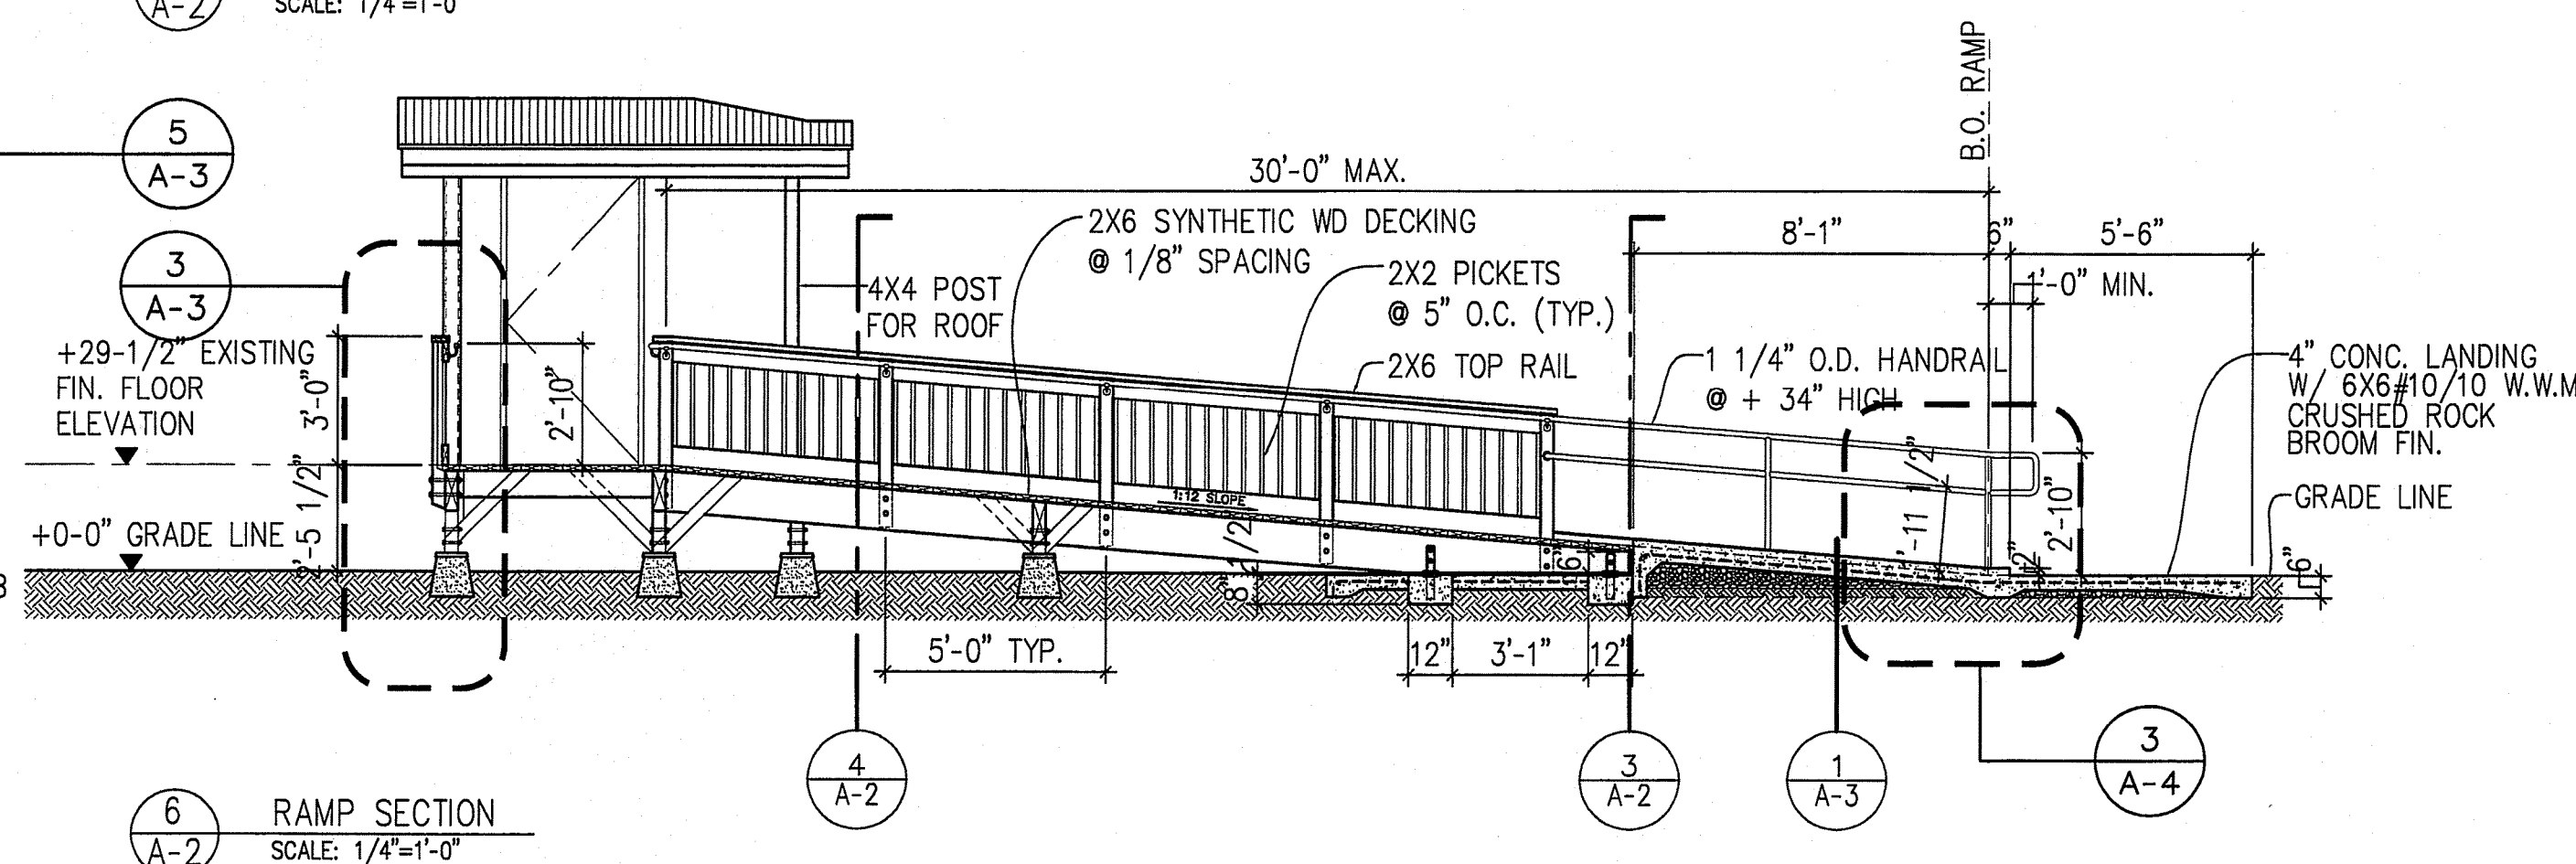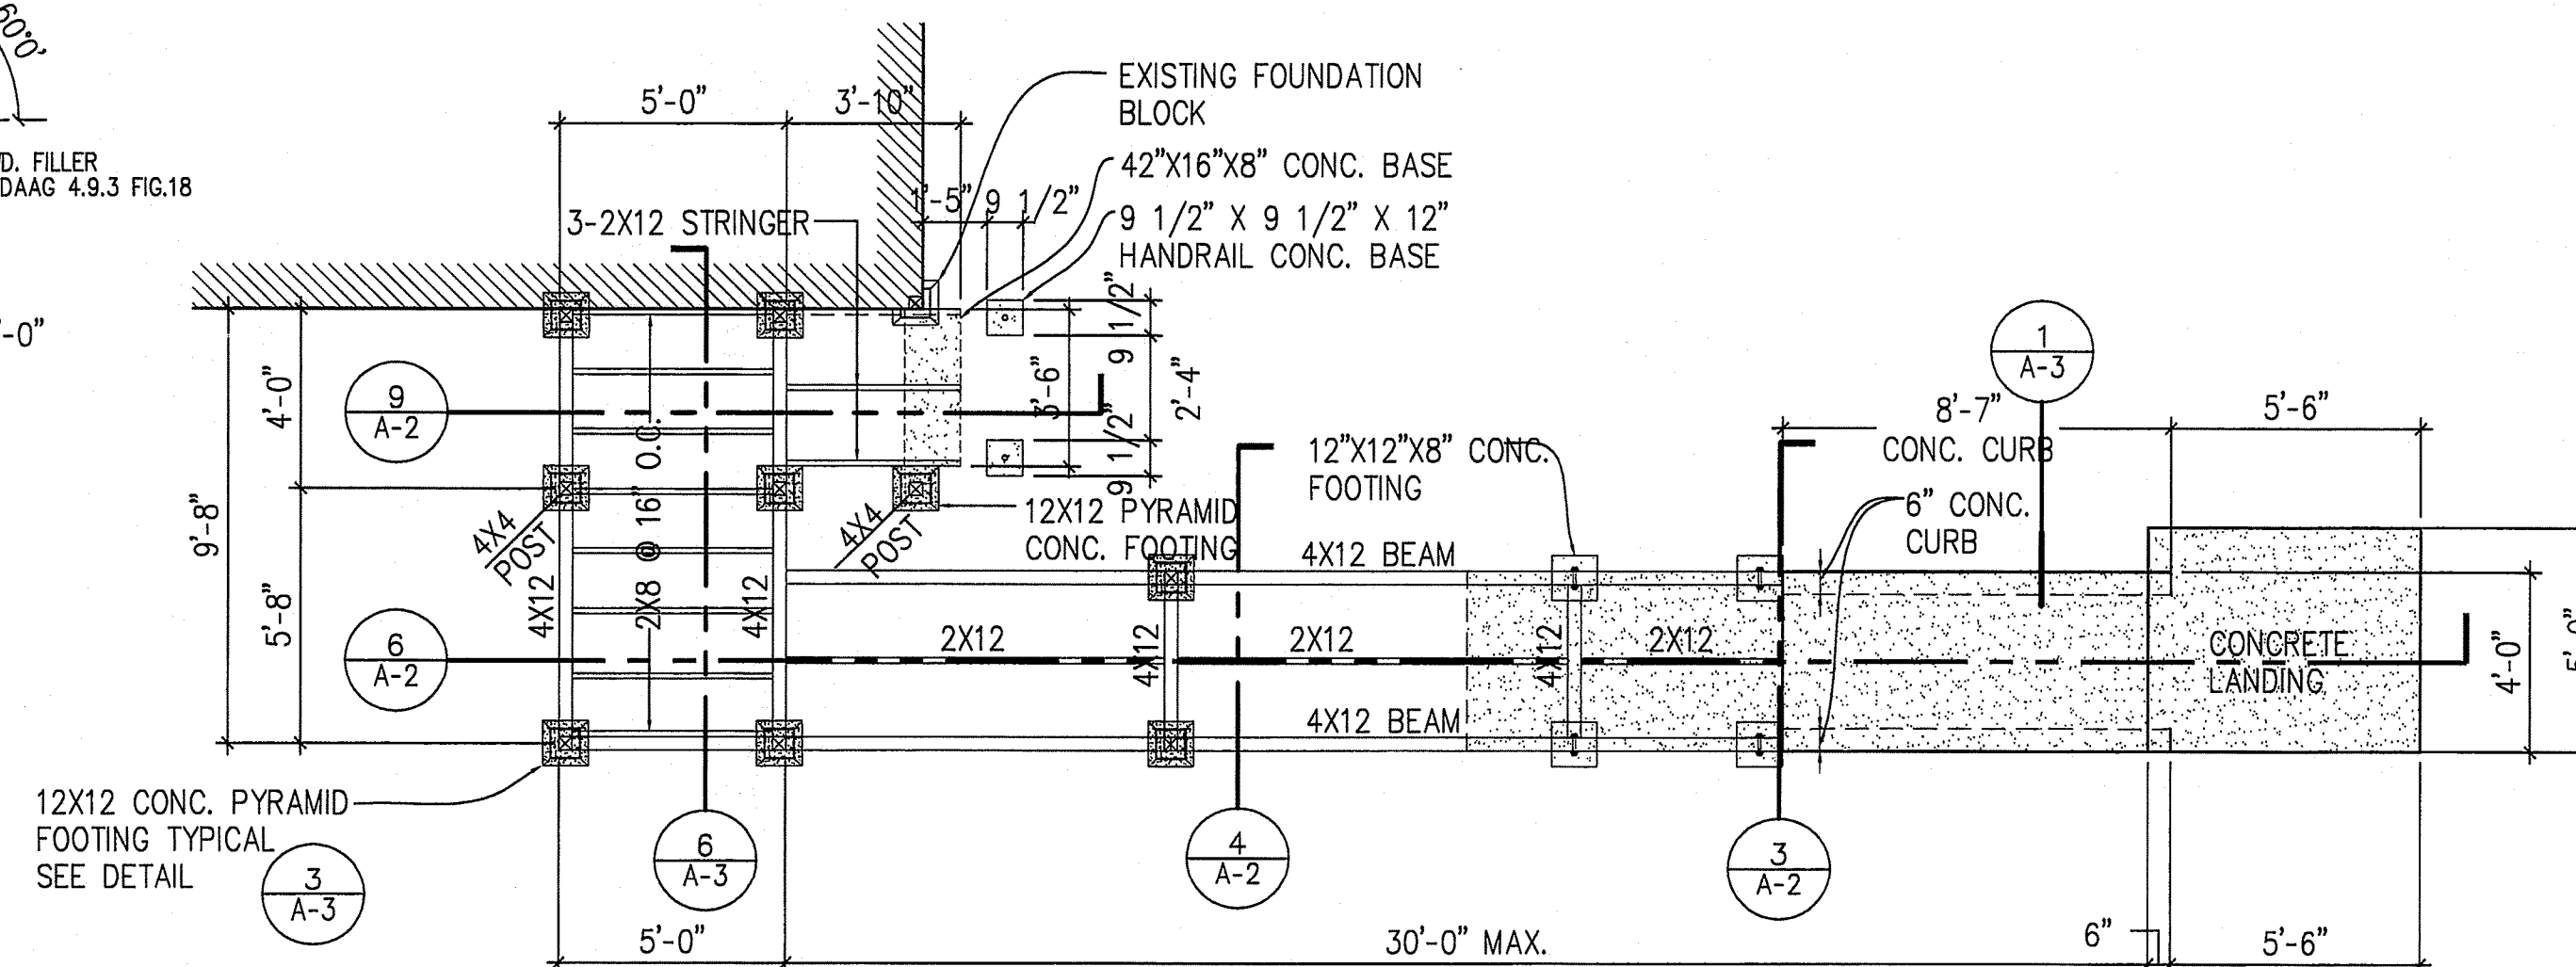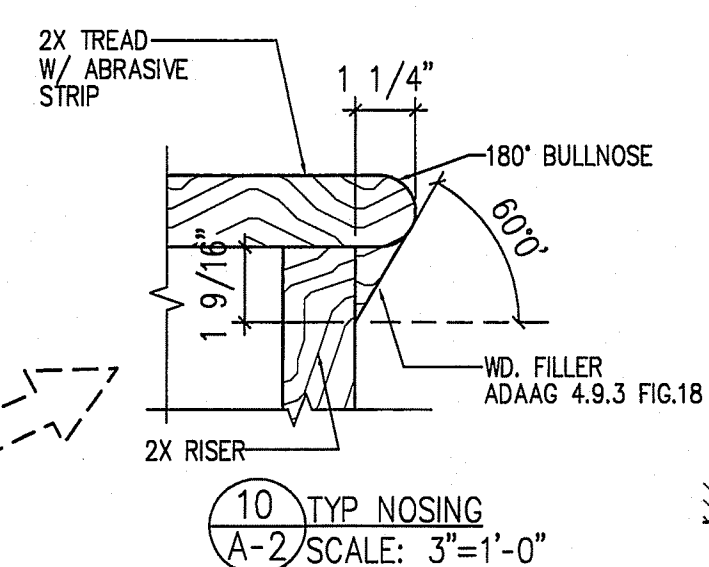  


AS-BUILT DRAWINGS

This certifies the dimensions and detail shown on this sheet reflect the dimensions & details, and specifications as constructed in the field.


BCP CONSTRUCTION OF HAWAII, INC.
Signature & Date 10-3-07

REVISION NO.		SYM.		DESCRIPTION		SHT / OF		DATE		APPROVED							
 EARL H. KONO LICENSED PROFESSIONAL ARCHITECT No. 4455 HAWAII, U.S.A. <i>Earl H. Kono</i> THIS WORK WAS PREPARED BY ME OR UNDER MY SUPERVISION. CONSTRUCTION OF THIS PROJECT WILL BE UNDER MY OBSERVATION. APRIL 30, 2006 _____ LICENSE EXPIRATION DATE						STATE OF HAWAII DEPARTMENT OF LAND AND NATURAL RESOURCES ENGINEERING DIVISION POLIPOLI SPRING STATE MONUMENT ADA BARRIER REMOVAL LOCATION 2: CABIN ELEVATIONS AND DETAILS											
						DESIGNED: E.K.						SUBMITTED: REECKE SUNNLAND KONO ARCHITECTS LTD.					
						DRAWN: J.H.						DATE: JANUARY, 2005					
						CHECKED: E.K.						SCALE: AS NOTED					
APPROVED: 						AUG - 4 2005 DATE: _____											
<i>Earl H. Kono</i> CHIEF ENGINEER																	
						DRAWING NO. A-2											

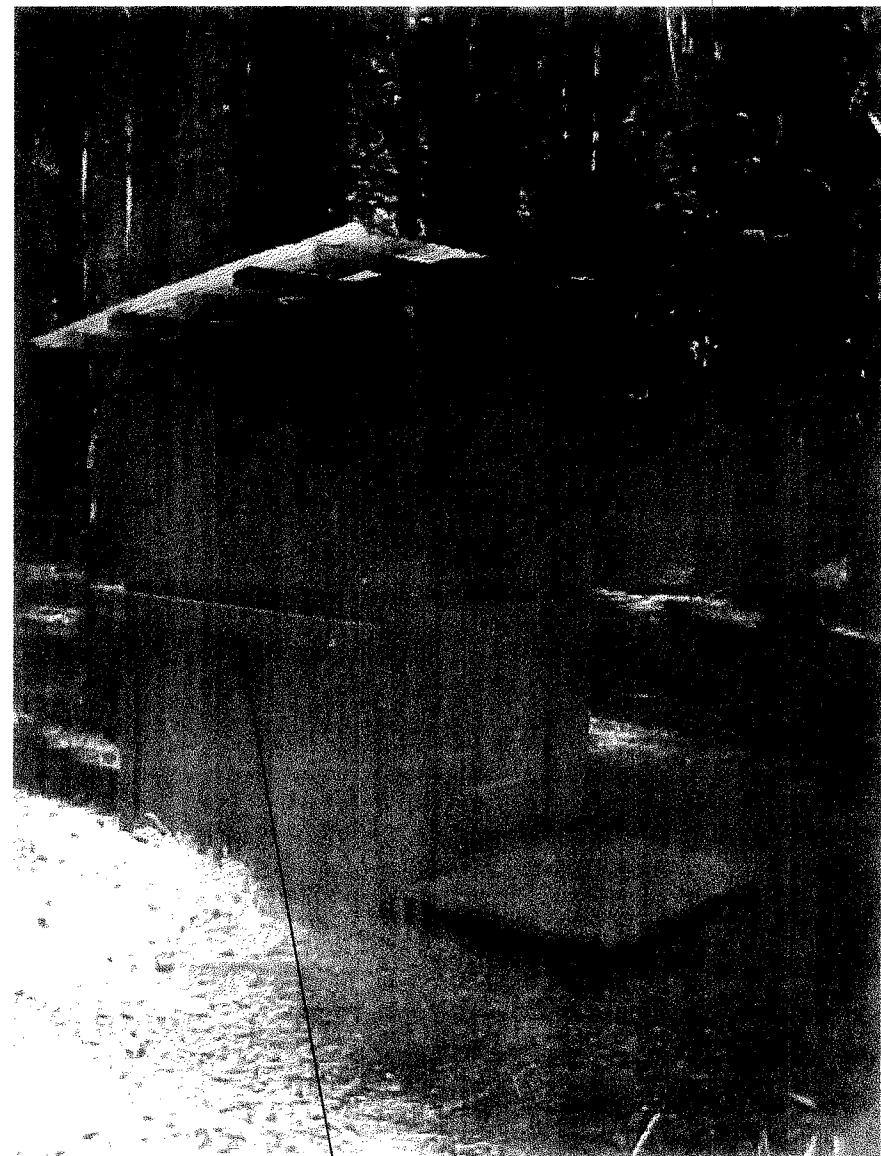


(E) 2X6 GIRT
FASTEN GRAB BARS INTO THIS
GIRT IF POSSIBLE.

OUTHOUSE

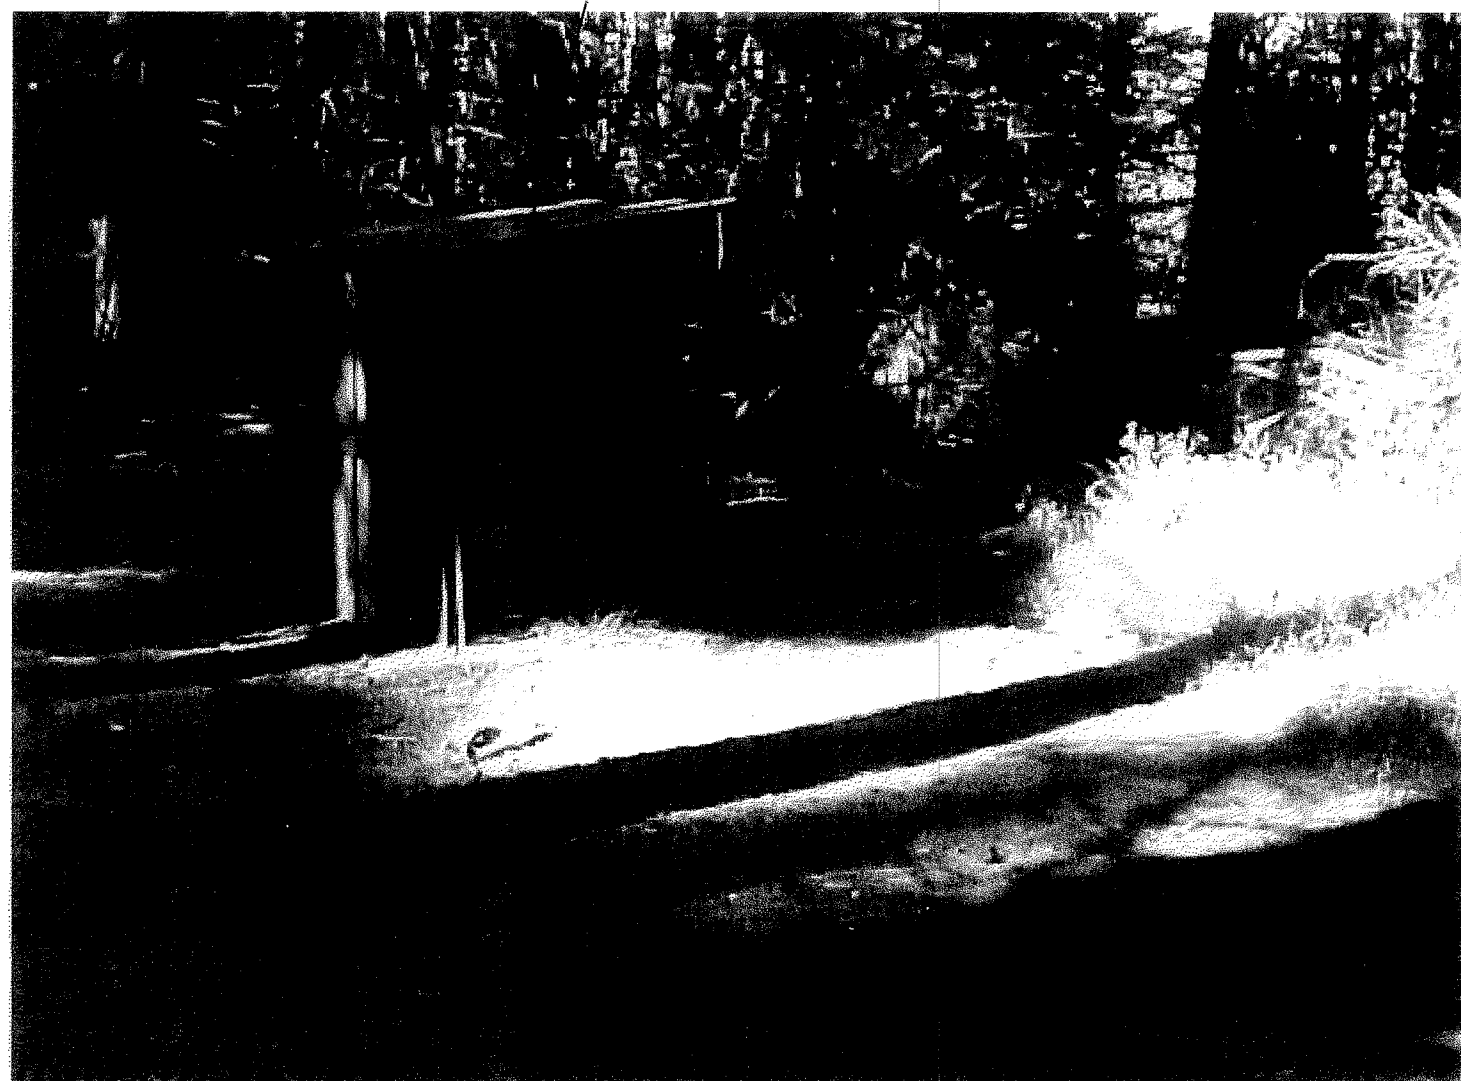

(E) DOOR FRAME

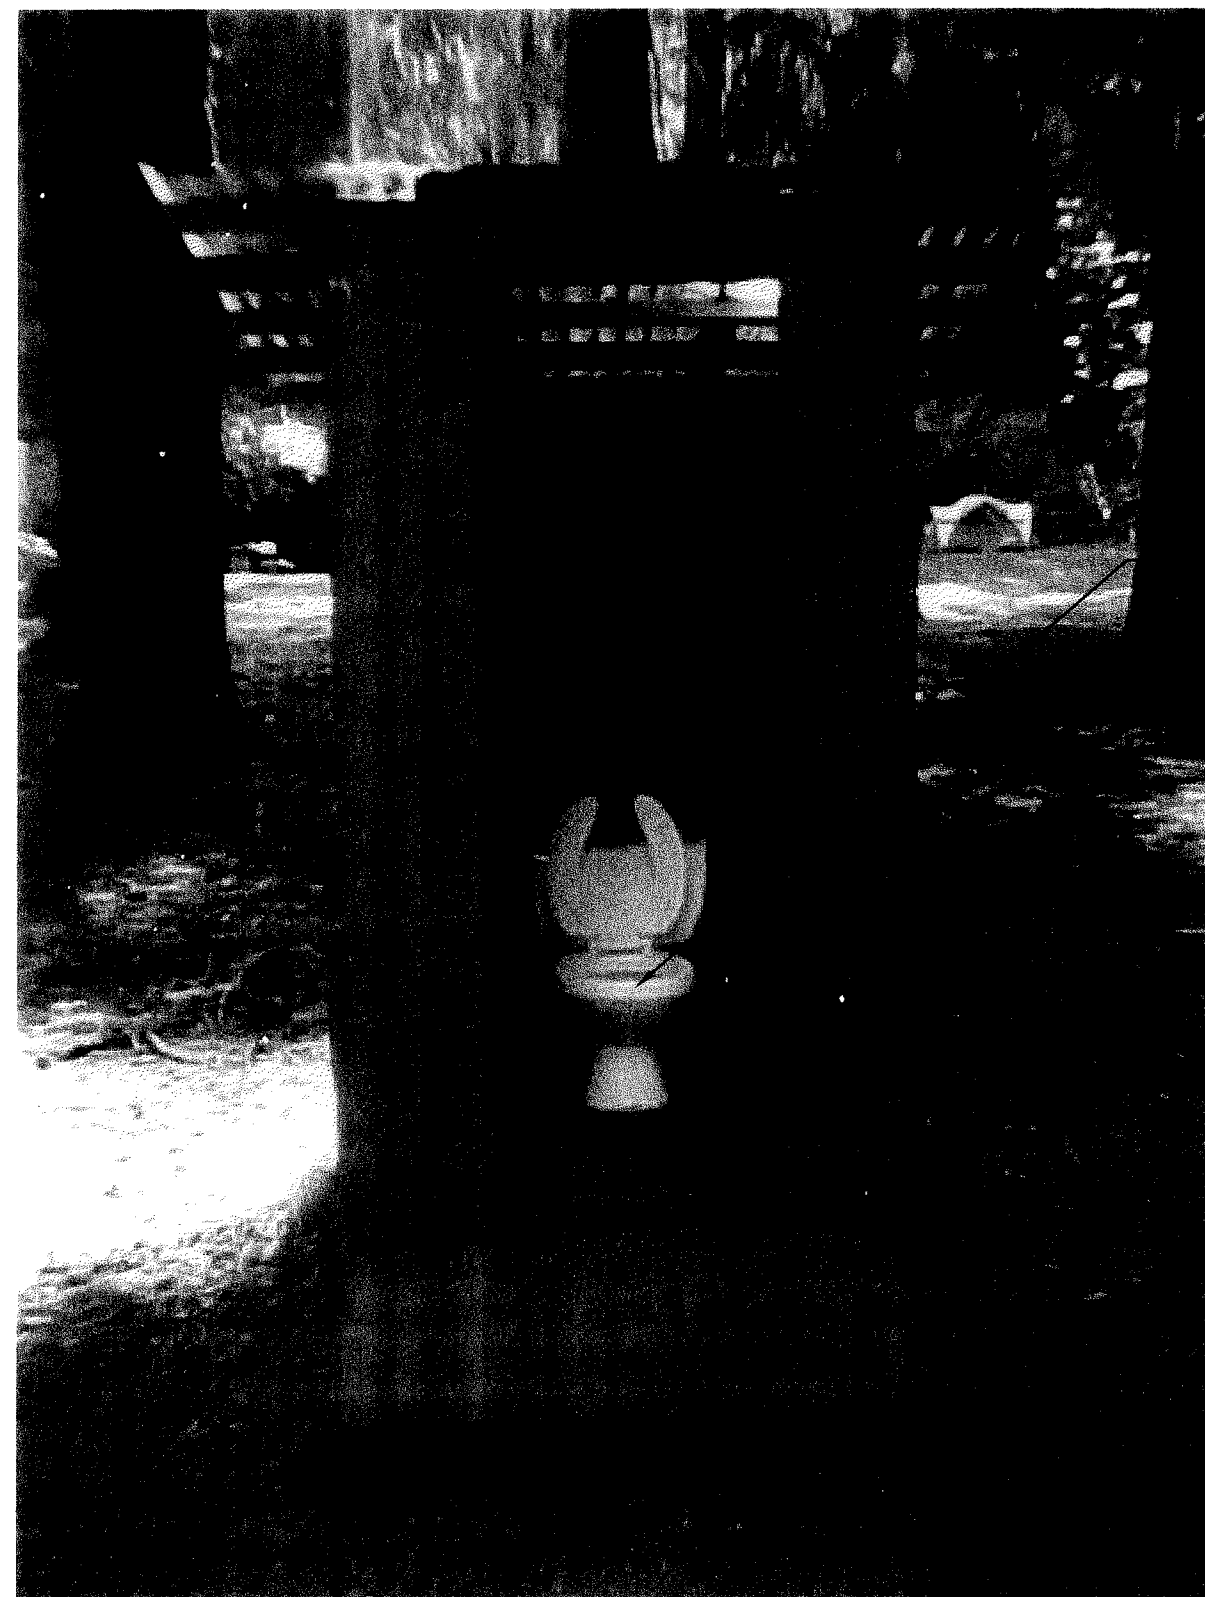

ENLARGE (E) DOOR WAY.
PROVIDE NEW DOOR & FRAME.
RE-USE EXTERIOR DOOR TRIM

REPLACE (E) W.C. WITH
NEW ADA COMPLIANT W.C.

LEVEL (E) PLYWD. FLOOR W/
(N) 5/8" PLYWD. SHIM AS REQ.

INSTALL (N) WD. STRIP
FILLER

REMOVE (E) WD. PALETTE LANDING.
POUR (N) CONC. LANDING & RAMP.

NOTES:
(E) = EXISTING
(R) = EXISTING RELOCATED
(N) = NEW

RE-CONNECT WATER SUPPLY
VERIFY ALL EXIST'G
CONDITIONS AND
DIMENSIONS

REMOVE ALL EXIST'G TOILET
ACCESSORIES.

PROVIDE SOLID BLOCK'G AS
REQUIRED.

ENSURE NO FASTENERS
PROTRUDE THROUGH
1X WALLS

REPLACE (E) W.C. W/
(N) ADA COMPLIANT W.C.

(E) 2X6 GIRT

(E) SINGLE WALL
CONSTRUCTED
OUTHOUSE.

INFILL GAP W/ A
WD. FILLER. ENSURE
LEVEL CHANGE BET.
PLYWD. FLR & CONC.
LANDING IS NO MORE
THAN 1/2"

BUILD UP CORNER
W/ 2-2X3'S

6" CURB
OPENING

6" CURB
OPENING

CONC. CURB TYP.

1.0% SL MAX

ADJUST SLOPE IN FIELD
RAMP 4.5% SL MAX

ADJUST SLOPE IN FIELD
RAMP 4.5% SL MAX


ADJUST SLOPE IN FIELD
RAMP 4.5% SL MAX

ADJUST SLOPE IN FIELD
RAMP 4.5% SL MAX


ADJUST SLOPE IN FIELD
RAMP 4.5% SL MAX

1 OUTHOUSE FLOOR PLAN
SCALE: 1/2"=1'-0"

Note: New Outhouse constructed
Similar to Existing

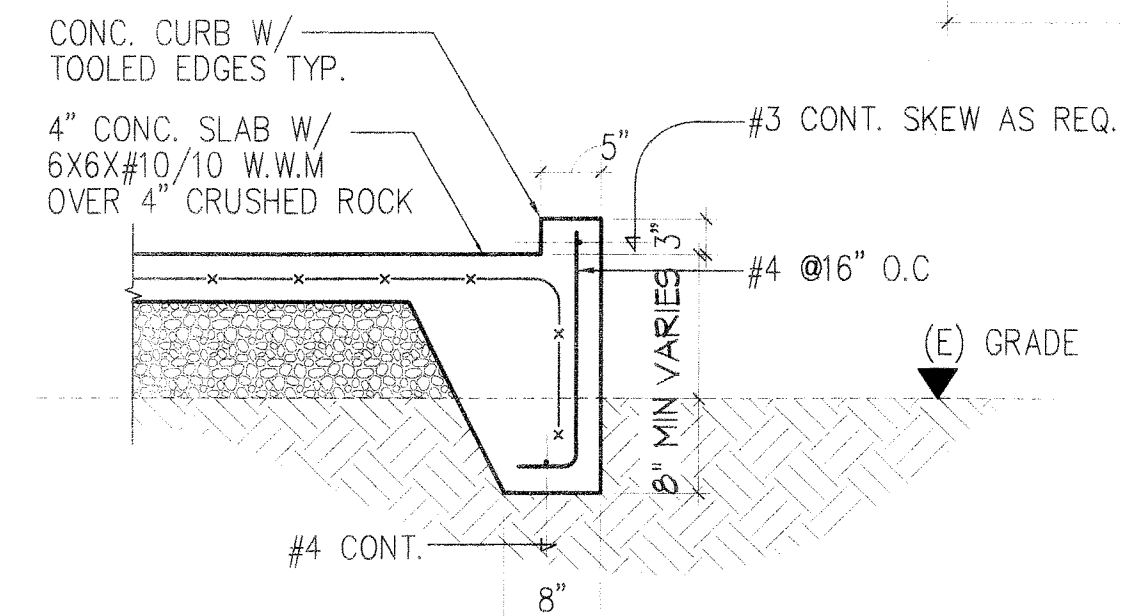


A DETAIL
SCALE: 3/4"=1'-0"

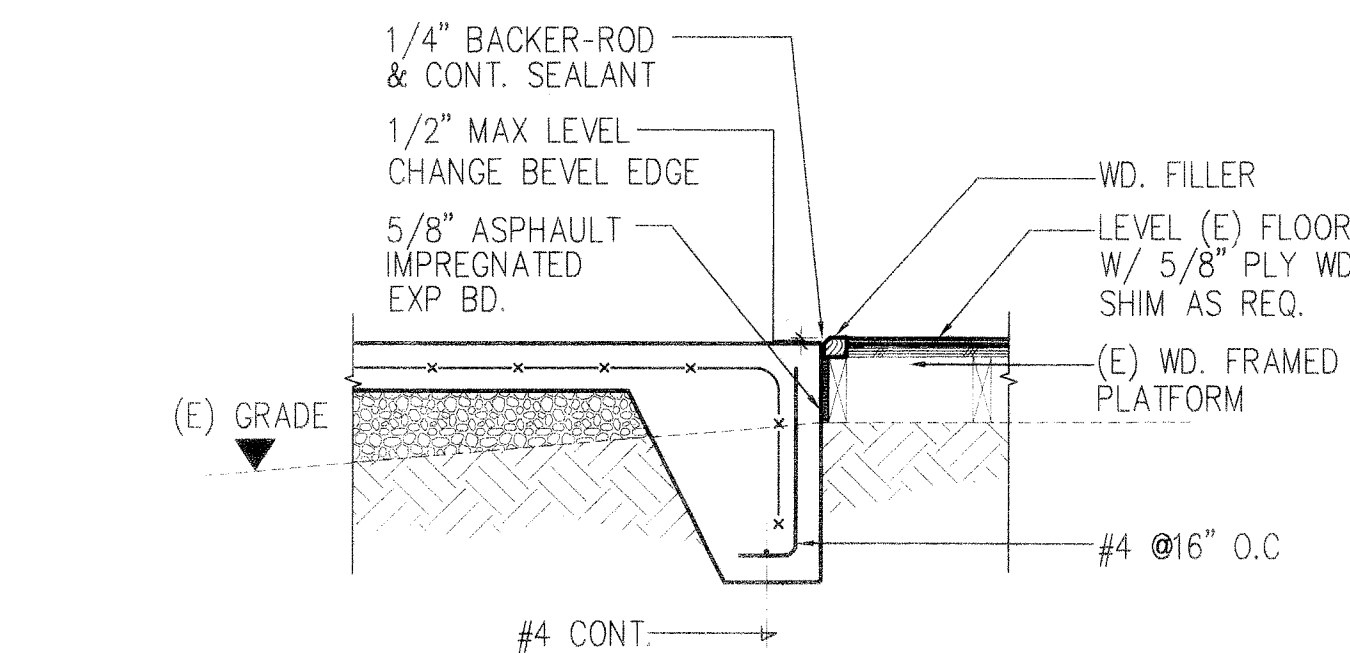


B DETAIL
SCALE: 3/4"=1'-0"


C FRONT ELEVATION OF OUTHOUSE
PHOTO

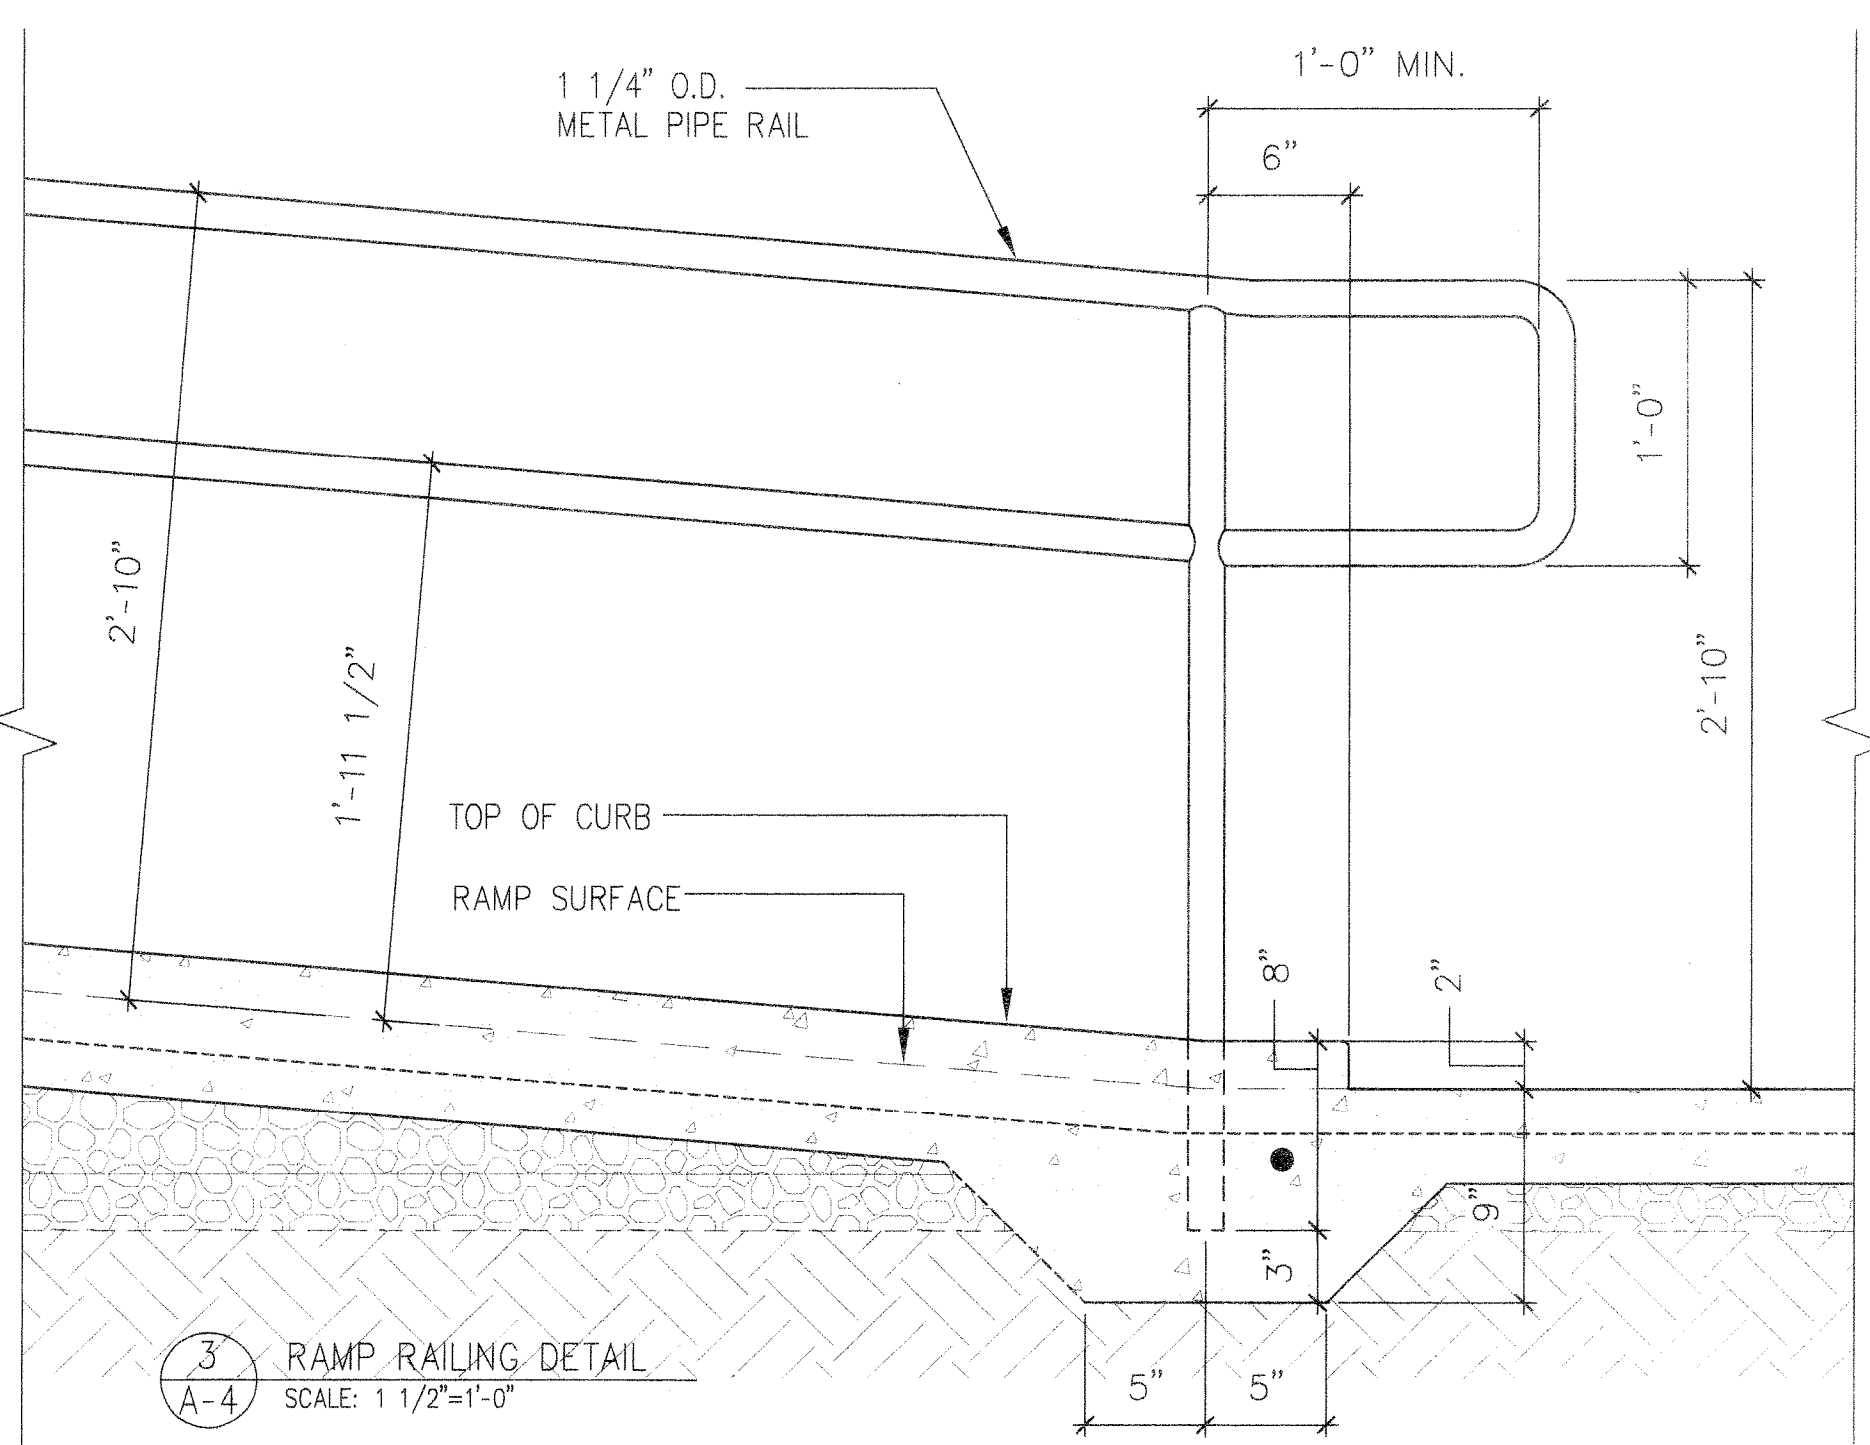

3 RAMP RAILING DETAIL
SCALE: 1 1/2"=1'-0"

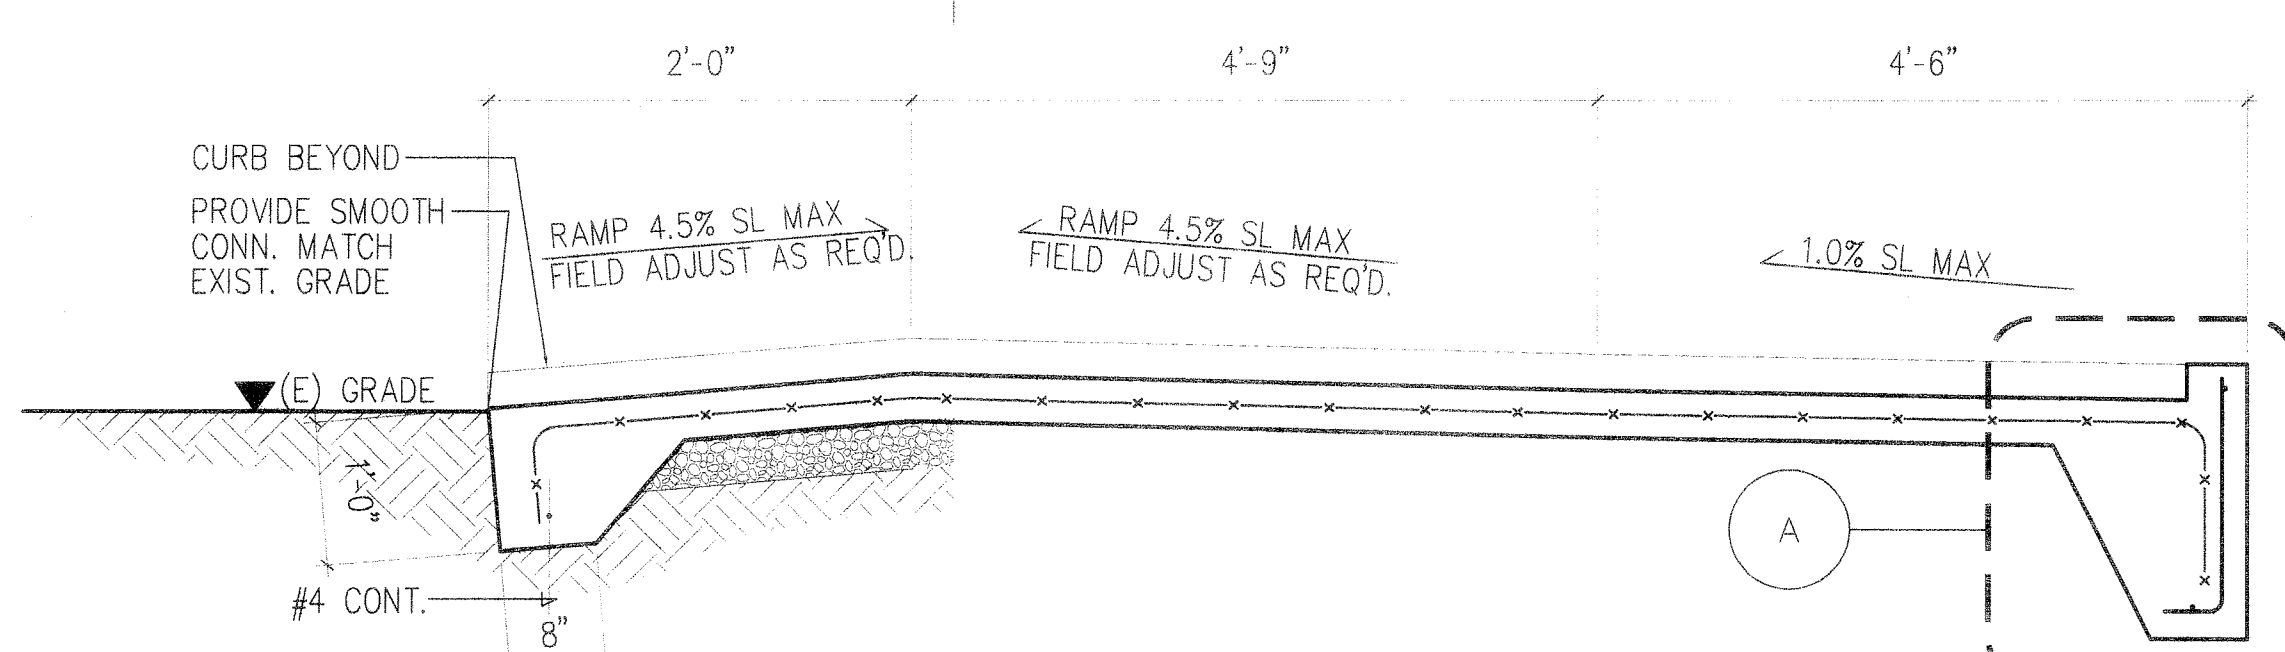

C DETAIL
SCALE: N.T.S.

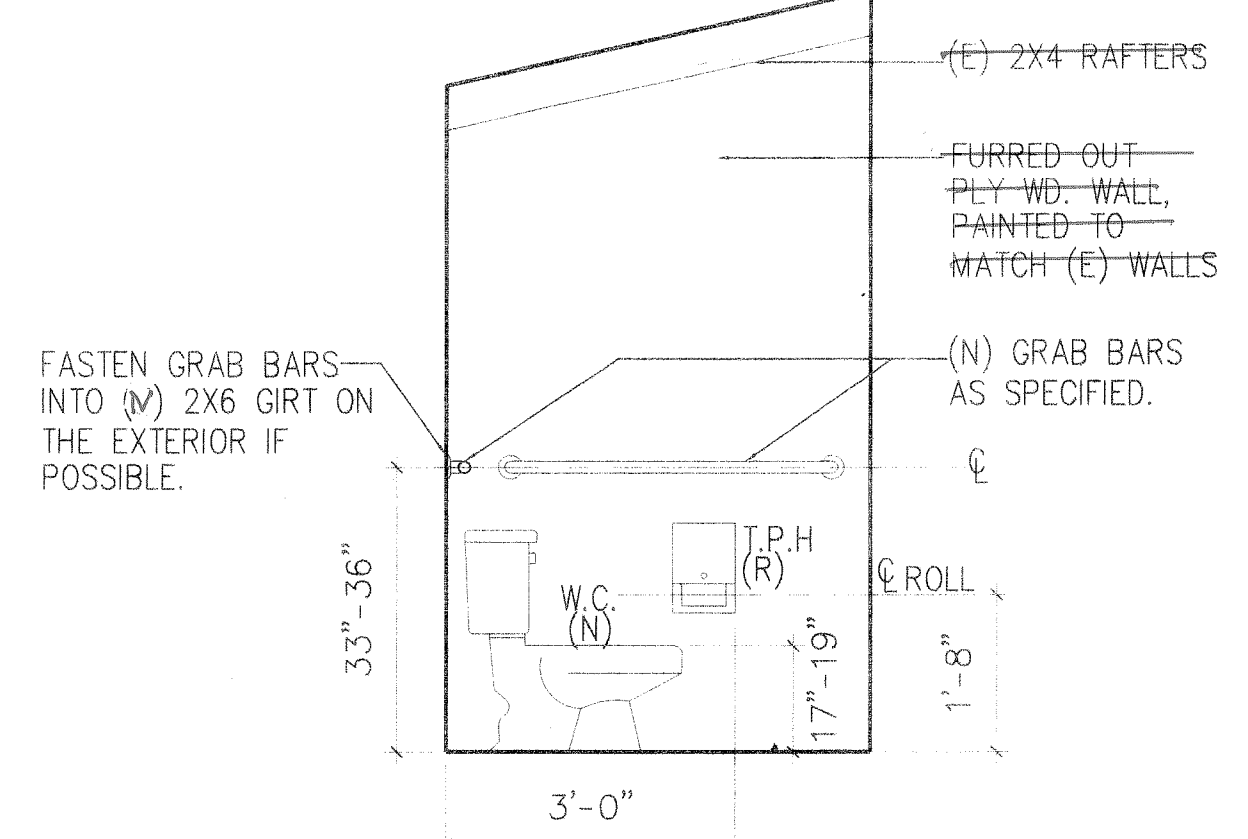

2 INT. ELEV B
SCALE: 1/2"=1'-0"

AS-BUILT DRAWINGS

This certifies the dimensions and detail
shown on this sheet reflect the
dimensions & details, and specifications
as constructed in the field.

BCP CONSTRUCTION OF HAWAII, INC.
Signature & Date

REVISION		NO.	DATE	DESCRIPTION	SHT	OF	DATE	APPROVED																				
EARL H. KONO ★ LICENSED PROFESSIONAL ARCHITECT ★ No. 4455 HAWAII, U.S.A.  THIS WORK WAS PREPARED BY ME, OR UNDER MY SUPERVISION IN CONNECTION WITH THE PROJECT IDENTIFIED BY THE NUMBER APRIL 30, 2006 LICENSE EXPIRATION DATE: STATE OF HAWAII DEPARTMENT OF LAND AND NATURAL RESOURCES ENGINEERING DIVISION POLIPOLI SPRING STATE MONUMENT ADA BARRIER REMOVAL LOCATION 1: OUTHOUSE FLOOR PLANS & DETAILS <table><tr><td>DESIGNED:</td><td>E.K.</td><td>SUBMITTED:</td><td>RECKE JANNARD KONO ARCHITECTS, LTD.</td></tr><tr><td>DRAWN:</td><td>J.H.</td><td>DATE:</td><td>JANUARY, 2005</td></tr><tr><td>CHECKED:</td><td>E.K.</td><td>SCALE:</td><td>AS NOTED</td></tr><tr><td>APPROVED:</td><td colspan="3"></td></tr><tr><td>CHIEF ENGINEER</td><td colspan="2">DATE:</td><td>A-4</td></tr></table>									DESIGNED:	E.K.	SUBMITTED:	RECKE JANNARD KONO ARCHITECTS, LTD.	DRAWN:	J.H.	DATE:	JANUARY, 2005	CHECKED:	E.K.	SCALE:	AS NOTED	APPROVED:				CHIEF ENGINEER	DATE:		A-4
DESIGNED:	E.K.	SUBMITTED:	RECKE JANNARD KONO ARCHITECTS, LTD.																									
DRAWN:	J.H.	DATE:	JANUARY, 2005																									
CHECKED:	E.K.	SCALE:	AS NOTED																									
APPROVED:																												
CHIEF ENGINEER	DATE:		A-4																									