

IFB J27150 ADDENDUM NO. 1

TO CONSTRUCT

**HOAPILI HALE
POWER QUALITY SYSTEM IMPROVEMENTS
JUD-2C-HOAPILI HALE POWER QUALITY IMP.
TAX MAP KEY: (2)-4-013:020 & 021
WAILUKU, MAUI, HAWAII**

FOR **THE JUDICIARY**
STATE OF HAWAII

BRANDON M. KIMURA
ADMINISTRATIVE DIRECTOR OF THE COURTS
THE JUDICIARY - STATE OF HAWAII

August, 2026

Prime Consultant & Electrical Engineer: Ronald N.S. Ho & Associates, Inc.

This addendum modifies the original Solicitation Documents for the Project dated, August, 2026 and any previously issued addenda. The items in this addendum shall govern the work, taking precedence over previously issued specifications and drawings governing the items mentioned. Acknowledge receipt of this Addendum in the space provided on the Solicitation, Offer and Contract Form.

August 13, 2026
Addendum No. 1

1. The attached drawings supersede and replace the drawings originally contained in the solicitation in their entirety.

END OF ADDENDUM NO. 1

HOAPILI HALE

POWER QUALITY SYSTEM IMPROVEMENTS

2145 MAIN STREET
WAILUKU, MAUI, HAWAII
TAX MAP KEY: 3-4-013:013


FOR THE JUDICIARY
BY THE

STATE OF HAWAII


JUDICIARY JOB NO. 2526-02-076

PREPARED BY:
RONALD N.S. HO & ASSOCIATES, INC. - PRIME / ELECTRICAL ENGINEER

LOCATION MAP

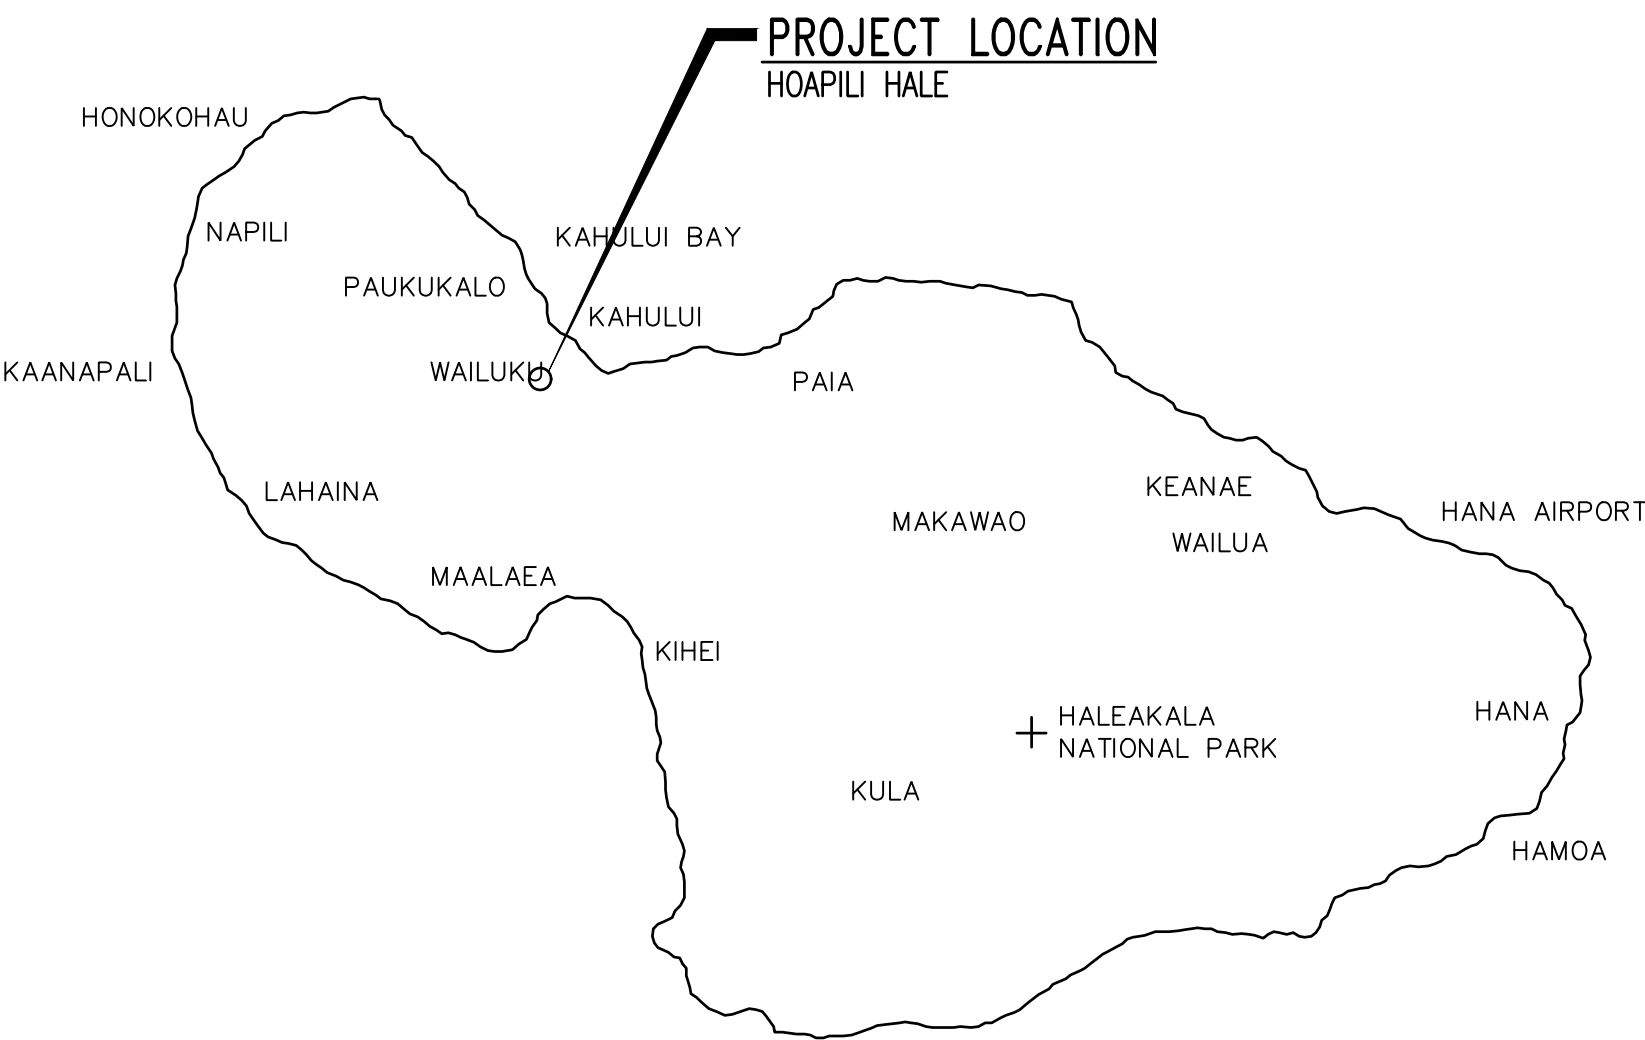


NORTH

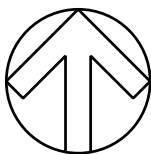


ISLAND OF MAUI

VICINITY MAP

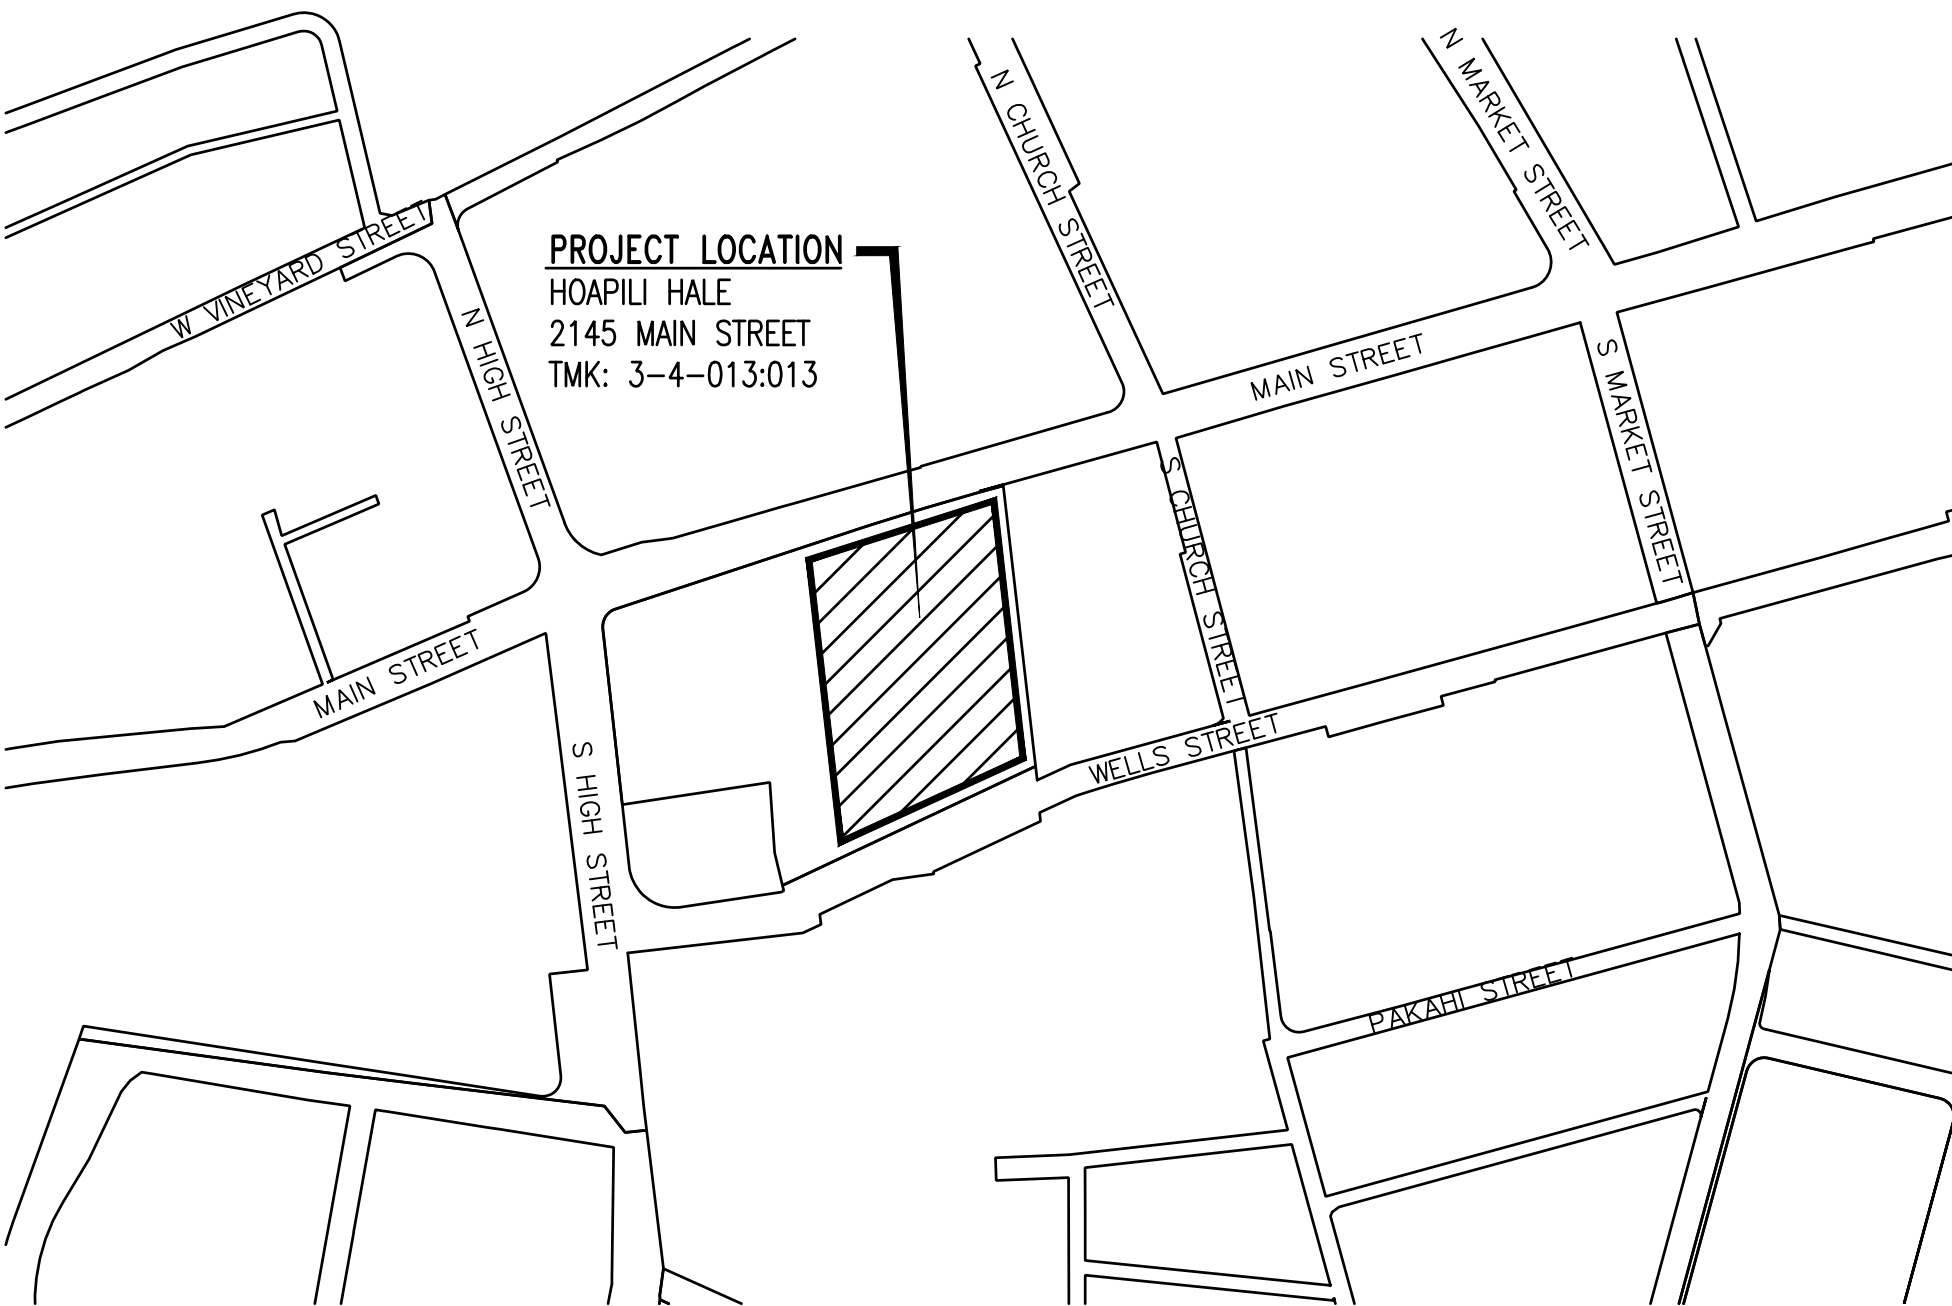

NORTH

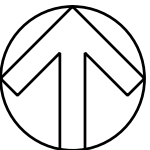

APPROVALS


APPROVED BY:

Brandon M Kimura

5/8/26

ADMINISTRATIVE DIRECTOR
OFFICE OF THE ADMINISTRATIVE DIRECTOR OF
THE COURTS
STATE OF HAWAII

DATE

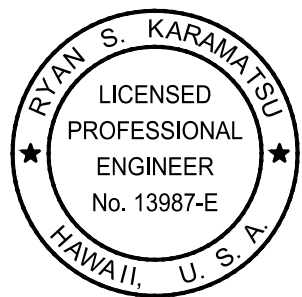REVISION NO.	SYM.	DESCRIPTION	SHT. OF	DATE	APPROVED: ADMINISTRATIVE DIRECTOR OF COURTS
		THE JUDICIARY STATE OF HAWAII			
THIS WORK WAS PREPARED BY ME OR UNDER MY SUPERVISION AND CONSTRUCTION OF THIS PROJECT WILL BE UNDER MY OBSERVATION. <i>Ryan S. Karamatsu</i> Digitally signed by Ryan Karamatsu 2026.05.08 11:17:06-1000		HOAPILI HALE POWER QUALITY SYSTEM IMPROVEMENTS 2145 MAIN STREET, WAILUKU, HAWAII, 96793 TAX MAP KEY: 3-4-013:013 WAILUKU MAUI HAWAII			
RONALD N.S. HO & ASSOC., INC.		JUDICIARY PROJECT NO.	DRAWING NO.		
DESIGNED BY: RK	CHECKED BY: RK	2526-02-076	0001		
DRAWN BY: CAD	APPROVED BY: RK	DATE FEB 2026	SHEET 1 OF 13 SHTS		
SCALE: AS SHOWN					

EXP. DATE: 4-30-28

GENERAL CONSTRUCTION NOTES:

1. VISIT SITE AND BECOME FAMILIAR WITH EXISTING CONDITIONS, AND EXTENT OF DEMOLITION AND NEW WORK PRIOR TO START OF WORK. RESOLVE ALL DISCREPANCIES AND QUESTIONS PRIOR TO THE START OF WORK.
2. REPORT ANY DISCREPANCIES AND/OR DIFFERENCES IN DRAWINGS, IN RESPECT TO EXISTING CONDITIONS, TO THE CITY.
3. RESOLVE ALL DISCREPANCIES AND QUESTIONS PRIOR TO THE START OF WORK. NO EXTRA PAYMENT SHALL BE ALLOWED ON ACCOUNT OF WORK MADE NECESSARY BY FAILURE TO VISIT THE SITE AND/OR FAILURE TO RESOLVE DISCREPANCIES AND QUESTIONS.
4. MINIMIZE ALL OUTAGES. SCHEDULE AND OBTAIN APPROVALS, FOR ALL OUTAGES WITH THE OWNER. WORK WILL BE REQUIRED DURING OFF HOURS TO MINIMIZE OUTAGES.
5. PATCH, GROUT, AND PAINT ALL OPENINGS EXPOSED BY REMOVAL WORK.
6. CORE, PATCH, AND PAINT EXISTING FLOORS AND WALLS AS NECESSARY. PROVIDE FIRE PROOFING SEALS (FIRE STOPS) AT ALL CONDUIT PENETRATIONS IN FLOORS AND WALLS, TO MAINTAIN EXISTING FIRE RATING INTEGRITY OF FLOORS AND WALLS.
7. MAINTAIN PORTIONS OF EXISTING FIRE ALARM SYSTEM IN COMPLETE OPERATING CONDITION DURING DEMOLITION AND CONSTRUCTION WORK PER UFC ARTICLE 87 "FIRE SAFETY DURING CONSTRUCTION, ALTERATION OR DEMOLITION OF A BUILDING".
8. ALL WORK SHALL CONFORM TO THE LATEST ADOPTED BUILDING CODE.
9. CONCEAL ALL RACEWAYS WHEREVER POSSIBLE. ROUTE EXPOSED CONDUITS, AND CONDUITS IN CEILING, AS HIGH AS POSSIBLE.
10. MAINTAIN ELECTRICAL CONNECTIONS (POWER, SIGNAL, AND LIGHTING) TO UNAFFECTED AREAS.
11. REMOVE ALL TEMPORARY LIGHTS, EQUIPMENT, DEVICES, CIRCUITING, ETC. AFTER TEMPORARY WORK IS NO LONGER REQUIRED.
12. TEST ALL EQUIPMENT AND SYSTEMS, AND DEMONSTRATE SYSTEM OPERATION TO THE SATISFACTION OF THE CITY.
13. PROVIDE EXPANSION COUPLINGS FOR RACEWAYS LARGER THAN 2" PASSING THROUGH EXPANSION JOINTS.
14. PROVIDE SHOP DRAWINGS FOR APPROVAL BY THE ENGINEER.
15. CONTRACTOR TO PAY FOR ALL PERMITS REQUIRED.
16. CONTRACTOR SHALL PROVIDE PADLOCKS FOR ALL EQUIPMENT AND GATES KEYED PER CITY'S REQUIREMENTS.
17. PROVIDE AS-BUILT DRAWINGS.

INTERIOR ELECTRICAL SYMBOLS					
MEASURED FROM FINISHED FLOOR TO:			MOUNTING HEIGHT	SYMBOL	DESCRIPTION
TOP	CTR	BTM			
					ELECTRICAL EQUIPMENT, TYPE AS INDICATED
●			72"		ELECTRICAL PANELBOARD OR COMMUNICATION CABINET
					SURGE PROTECTION DEVICE
					ELECTRICAL EQUIPMENT CONNECTION
		●			JUNCTION BOX, 4"SQ MIN., WALL/CEILING MTD RESPECTIVELY.
		●			LARGE JUNCTION BOX, SIZE AS NOTED, WALL/CEILING MTD RESPECTIVELY.
					CONDUIT CONCEALED IN CEILING OR WALL, ALL OTHERS SIMILAR
					EXPOSED CONDUIT, ALL OTHERS SIMILAR
					CONDUIT CONCEALED BELOW FINISH FLOOR, IN NEW FLOOR TOPPING, ALL OTHERS SIMILAR
					LIQUID-TIGHT FLEXIBLE METAL CONDUIT AND WIRING
					POWER/LIGHTING CIRCUIT HOMERUN TO PANEL "2A", CIRCUITS 1, 3, 5 INDICATED, OTHERS INDICATED SIMILARLY
					COMM CONDUIT HOMERUN, 3/4"C W/PULLSTRING (TEL INDICATED, DATA SIMILAR)
					CONDUIT STUBOUT.
					PWR/LTG CONDUIT CONCEALED IN WALL OR CEILING, 3 WIRES AND 1 GROUND WIRE INDICATED. NO HASHMARKS DENOTES 2 WIRES AND 1 GROUND WIRE.
					CONDUIT RISER TURNED UP/DOWN RESPECTIVELY.
					NOTE INDICATOR, "NOTE NUMBER 1 REFERENCED", ALL OTHERS SIMILAR

ABBREVIATIONS

AFF	ABOVE FINISHED FLOOR	MTD	MOUNTED
	AMPERES	NO.	NUMBER
BTM	BOTTOM	OFCl	OWNER FURNISHED, CONTRACTOR INSTALLED
BKR	BREAKER	PSI	POUNDS PER SQUARE INCH
BKBD	BACKBOARD	PFB	PROVISIONS FOR FUTURE CIRCUIT BREAKER
CAB	CABINET		
CTR	CENTER	PNL	PANELBOARD
CKT	CIRCUIT	PWR	POWER
C	CONDUIT	SCH	SCHEDULE
D	DEEP	SQ	SQUARE
DIA	DIAMETER	STD	STANDARD
DWG	DRAWING	T	THICK
EQ	EQUAL	TYP	TYPICAL
GND	GROUND	V	VOLTS
HECO	HAWAIIAN ELECTRIC COMPANY	W	WIRE
KAIC	KILOAMPERES INTERRUPTING CAPACITY	WP	WEATHERPROOF
KVA	KILOVOLT AMPERES		
L	LENGTH/LONG		
LTG	LIGHTING		
MAX	MAXIMUM		
	MINIMUM		

ONE-LINE DIAGRAM SYMBOLS

SYMBOL	DESCRIPTION
	GROUND
	GROUND BUS
	NEUTRAL BUS
	MOLDED CASE CIRCUIT BREAKER
	TRANSFORMER, TYPE AS INDICATED
	SURGE PROTECTION DEVICE
	GROUND FAULT INTERRUPTER
	ARCFLASH REDUCTION MAINTENANCE SWITCH
	SWITCH
	UTILITY METER SOCKET AND METER (METER BY UTILITY)
	POWER METER
	CURRENT TRANSFORMERS, ONE PER PHASE
	KIRKKEY
X	ITEMS WITH "X" THROUGH SYMBOL INDICATES REMOVAL/DEMOLITION OF THAT ITEM

SYMBOL NOTES:

1. HASH MARKS ON CONDUIT SYMBOL DENOTE NUMBER OF WIRES IN CONDUIT, NO HASH MARKS INDICATE 2 WIRES PLUS SEPARATE GROUND WIRE. GROUND WIRES NOT INDICATED IN WIRE COUNTS.
2. CIRCUITING WITH AN "e" AND DASHED SYMBOLS INDICATE EXISTING ITEMS.
3. ITEMS INDICATED WITH AN "X" ARE TO BE DEMOLISHED
4. SPECIAL MOUNTING HEIGHTS AS INDICATED ON PLANS.

COUNTY OF MAUI
MAUI COUNTY CODE, CHAPTER 16.16C:ENERGY CODE
COMMERCIAL PROVISIONS

COMPLIANCE METHOD
Check applicable method

☐ C401.2(1) ANSI / ASHRAE / IESNA 90.1

☒ C401.2(2) Sections C402 through C406 and C408

☐ C401.2(3) Sections C402.5, C403.2, C403.3 through C403.3.2, C403.4, through C403.4.2.3, C403.5.5, C403.7, C403.8.1 through C403.8.4, C403.10.1 through C403.10.3, C403.11, C403.12, C404, C405, C407 and C408

☐ C102.1 Alternative

To the best of my knowledge, this project's design substantially conforms to the Energy Code.

Signature: Date: 2026.05.08 11:16:05-10'00'

Name: RYAN S. KARAMATSU

Title: ELECTRICAL ENGINEER

License No.: 13987-E

Digitally signed by Ryan Karamatsu 2026.05.08 11:16:05-10'00'

REVISION NO.

SYM.

DESCRIPTION

DATE

DATE

APPROVED: ADMINISTRATIVE DIRECTOR OF COURTS

THE JUDICIARY
STATE OF HAWAII
HOAPILI HALE
POWER QUALITY SYSTEM IMPROVEMENTS
2145 MAIN STREET, WAILUKU, HAWAII, 96793
TAX MAP KEY: 3-4-013:013
WAILUKU MAUI HAWAII
ELECTRICAL SYMBOLS AND NOTES

RONALD N.S. HO & ASSOC., INC.

JUDICIARY PROJECT NO.

DRAWING NO.

DESIGNED BY: RK

CHECKED BY: RK

2526-02-076

DRAWN BY: CAD

APPROVED BY: RK

DATE: FEB 2026



SHEET: 3 OF 13

THIS WORK WAS PREPARED BY ME OR UNDER MY SUPERVISION AND CONSTRUCTION OF THIS PROJECT WILL BE UNDER MY OBSERVATION.


Digitally signed by Ryan Karamatsu 2026.05.08 11:15:14-10'00'

EXP. DATE: 4-30-28



FILE _____ DRAWER _____ FOLDER _____

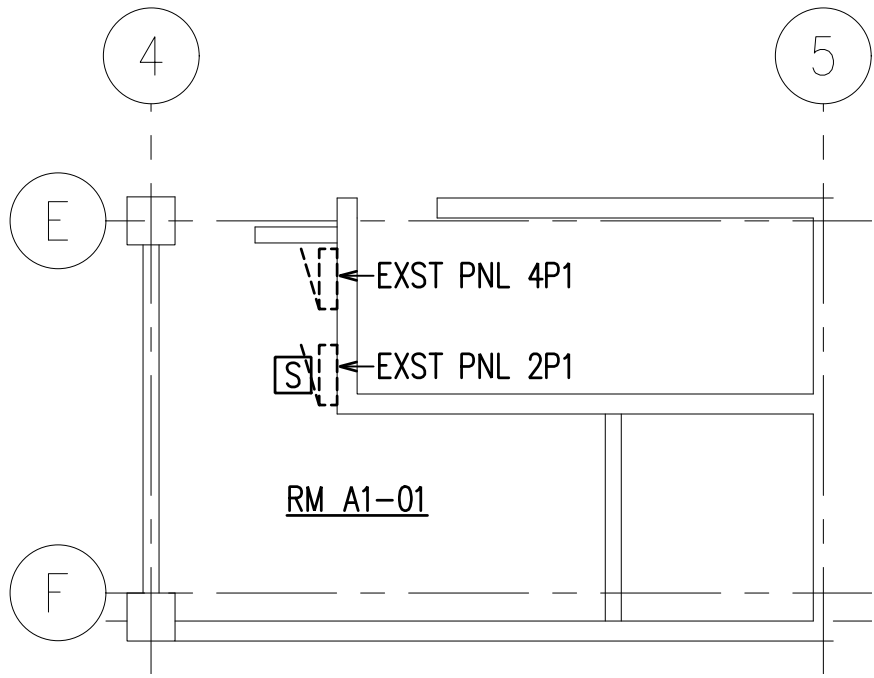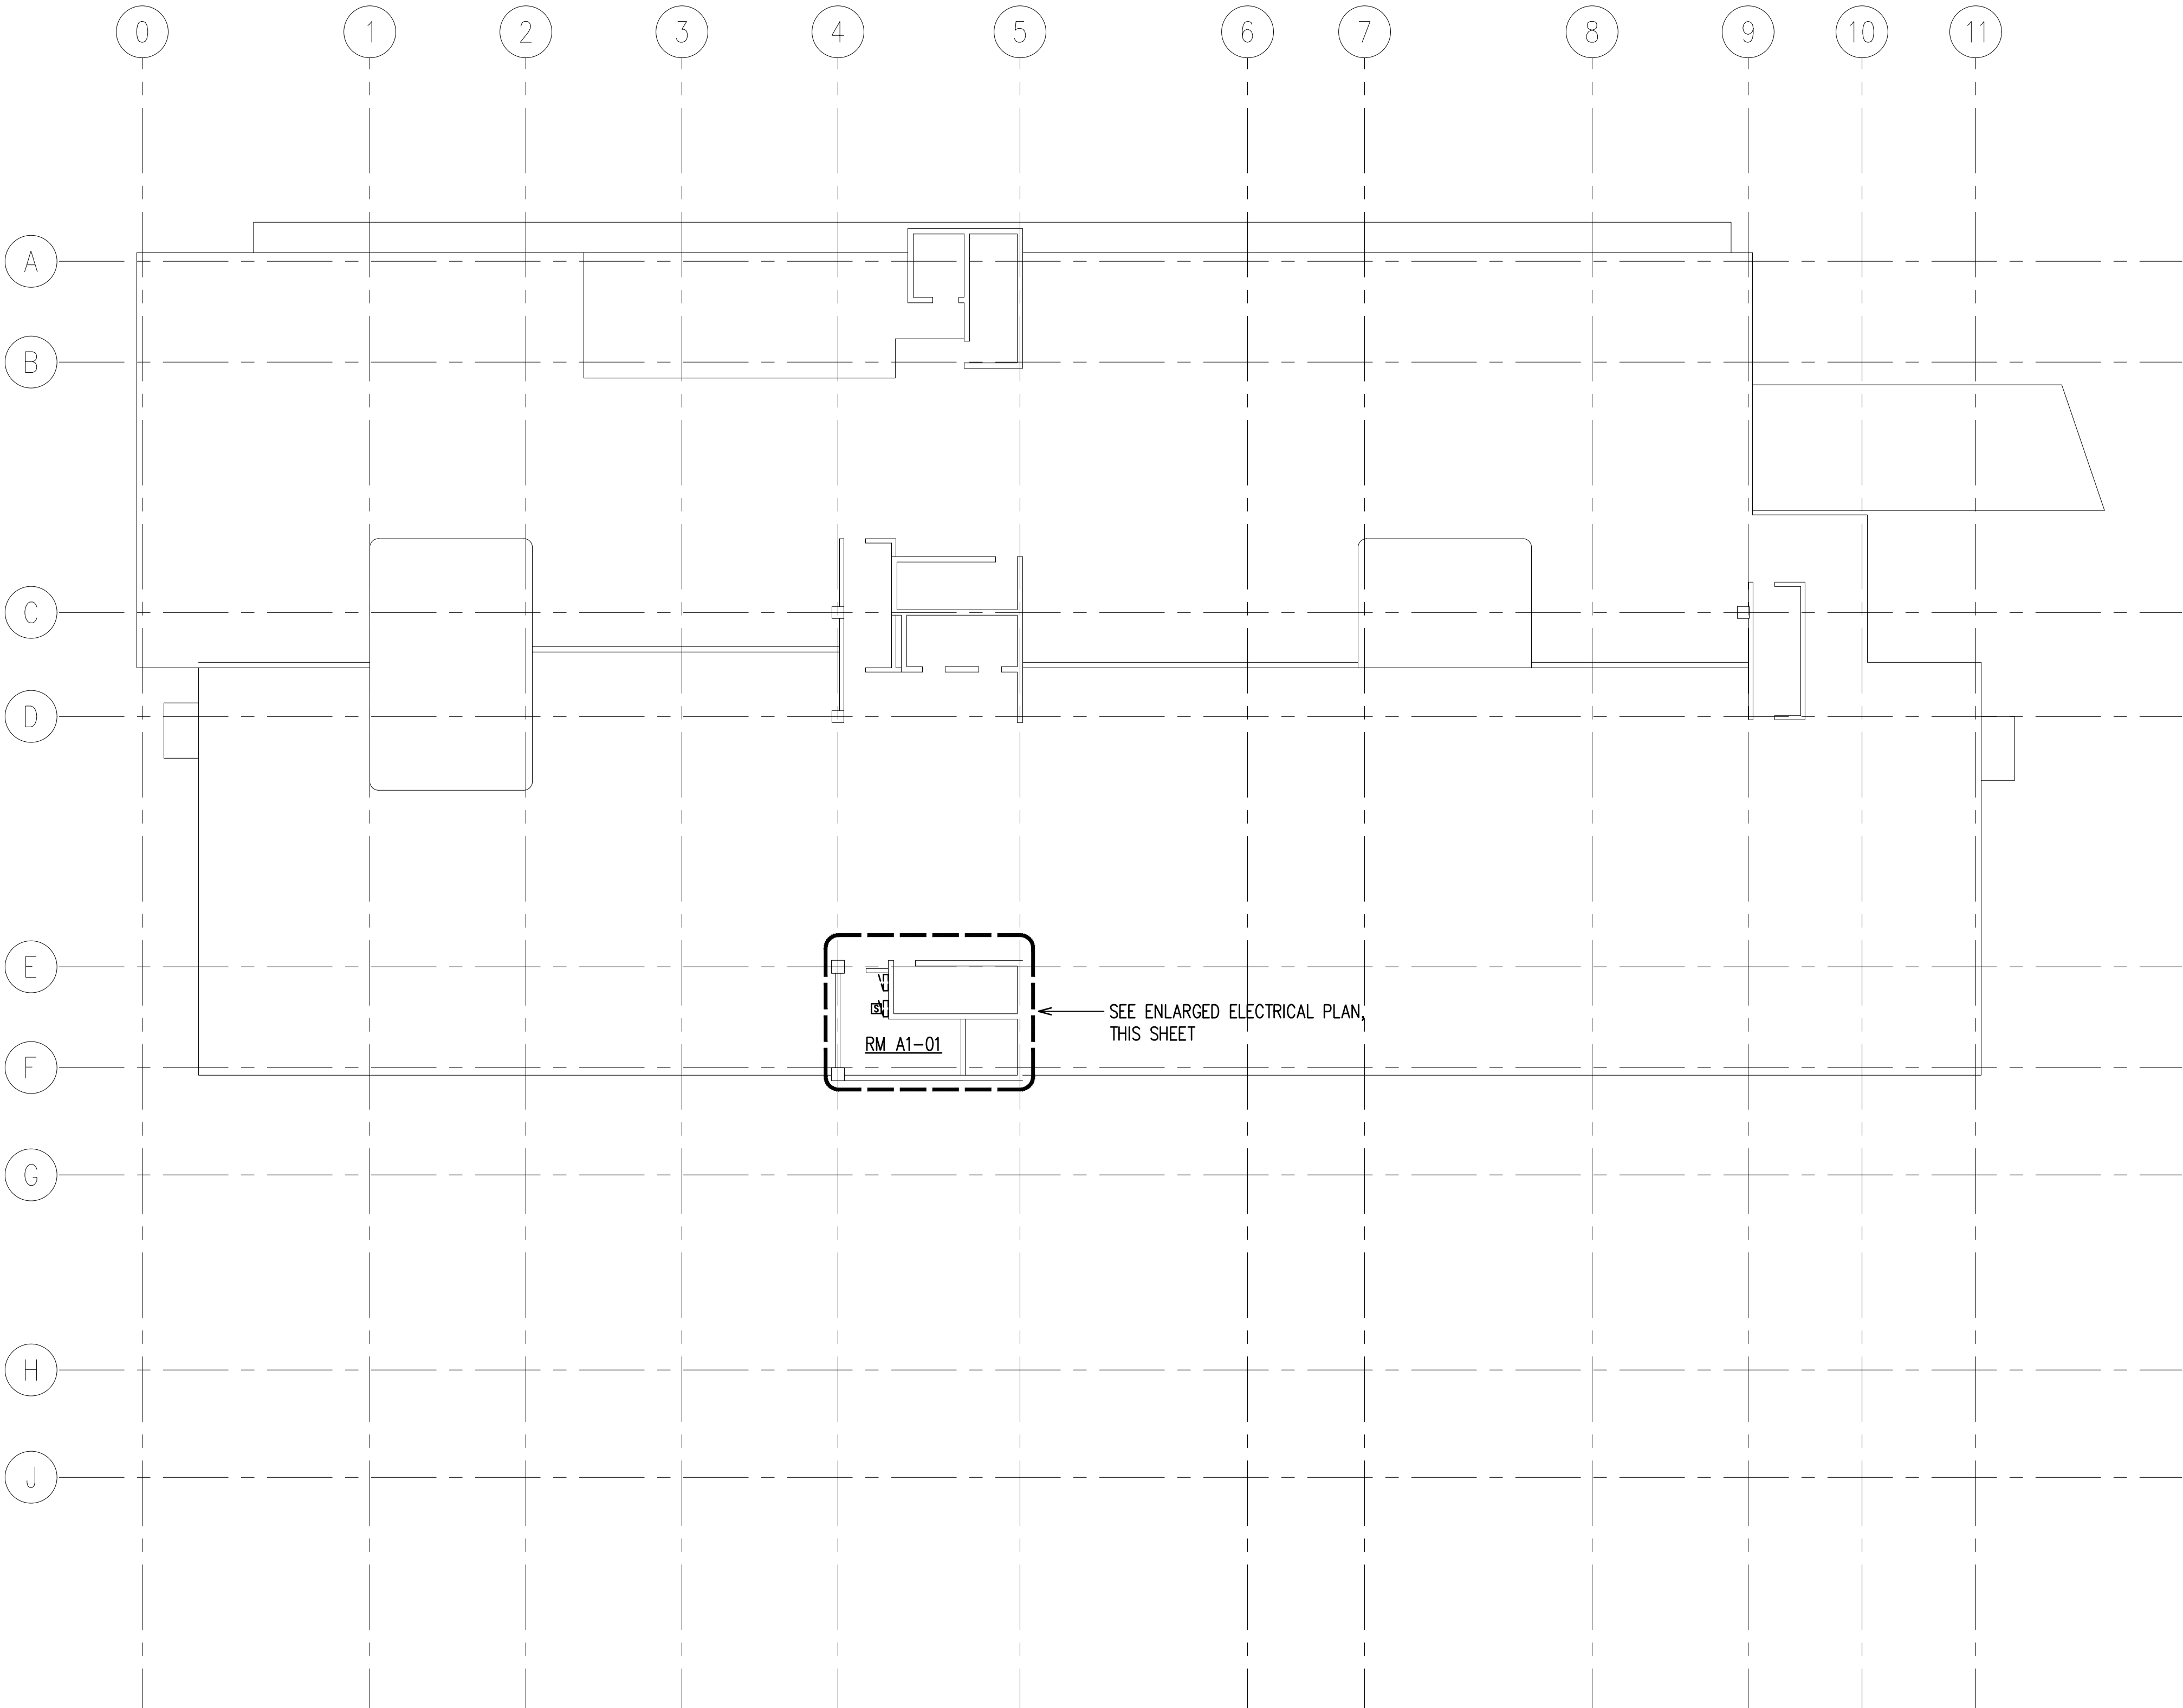



ENLARGED ELECTRICAL PLAN – RM 1A-01
SCALE: 1/8"=1'-0"

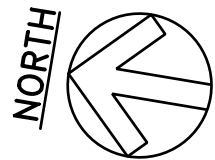


ELECTRICAL PLAN – PARKING LEVEL 1
SCALE: 1/16"=1'-0"

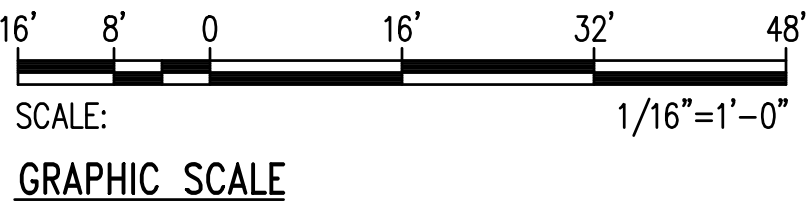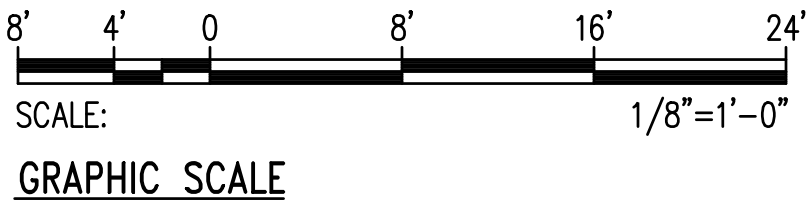


REVISION NO.	SYM.	DESCRIPTION	SHT. OF	DATE	APPROVED: ADMINISTRATIVE DIRECTOR OF COURTS
		THE JUDICIARY STATE OF HAWAII			
		HOAPILI HALE POWER QUALITY SYSTEM IMPROVEMENTS 2145 MAIN STREET, WAILUKU, HAWAII, 96793 TAX MAP KEY: 3-4-013:013 WAILUKU MAUI HAWAII			
		ELECTRICAL PLAN - PARKING LEVEL 1			
		RONALD N.S. HO & ASSOC., INC.			
DESIGNED BY: RK	CHECKED BY: RK	JUDICIARY PROJECT NO. 2526-02-076	DRAWING NO. E201		
DRAWN BY: CAD	APPROVED BY: RK	DATE FEB 2026	SHEET 4 OF 13 SHTS		
EXP. DATE: 4-30-28		SCALE: AS SHOWN			

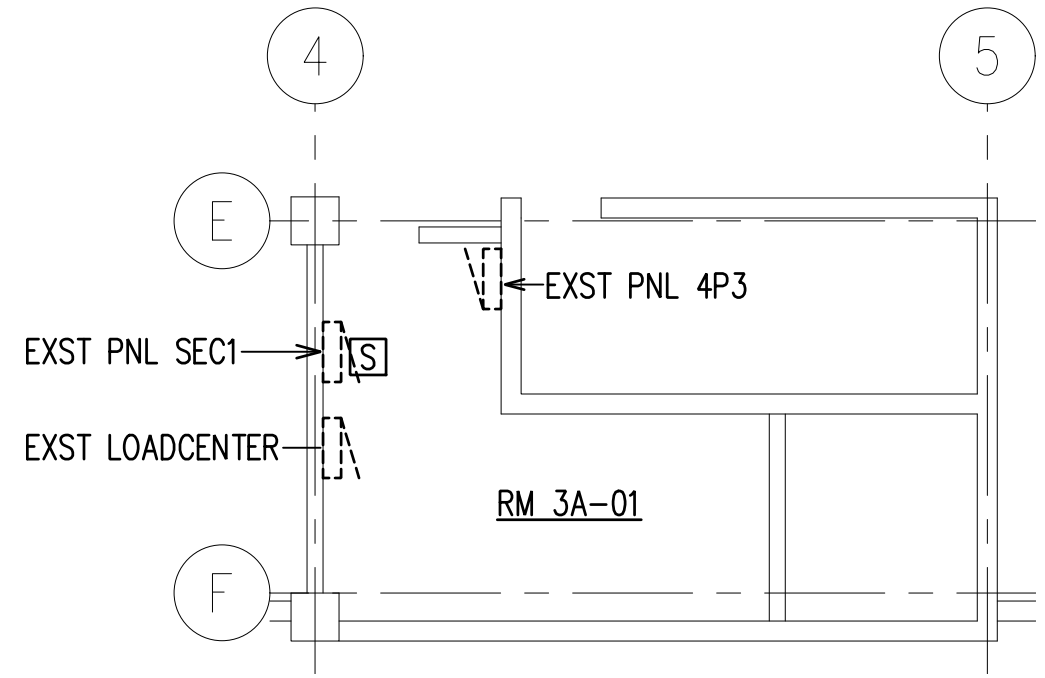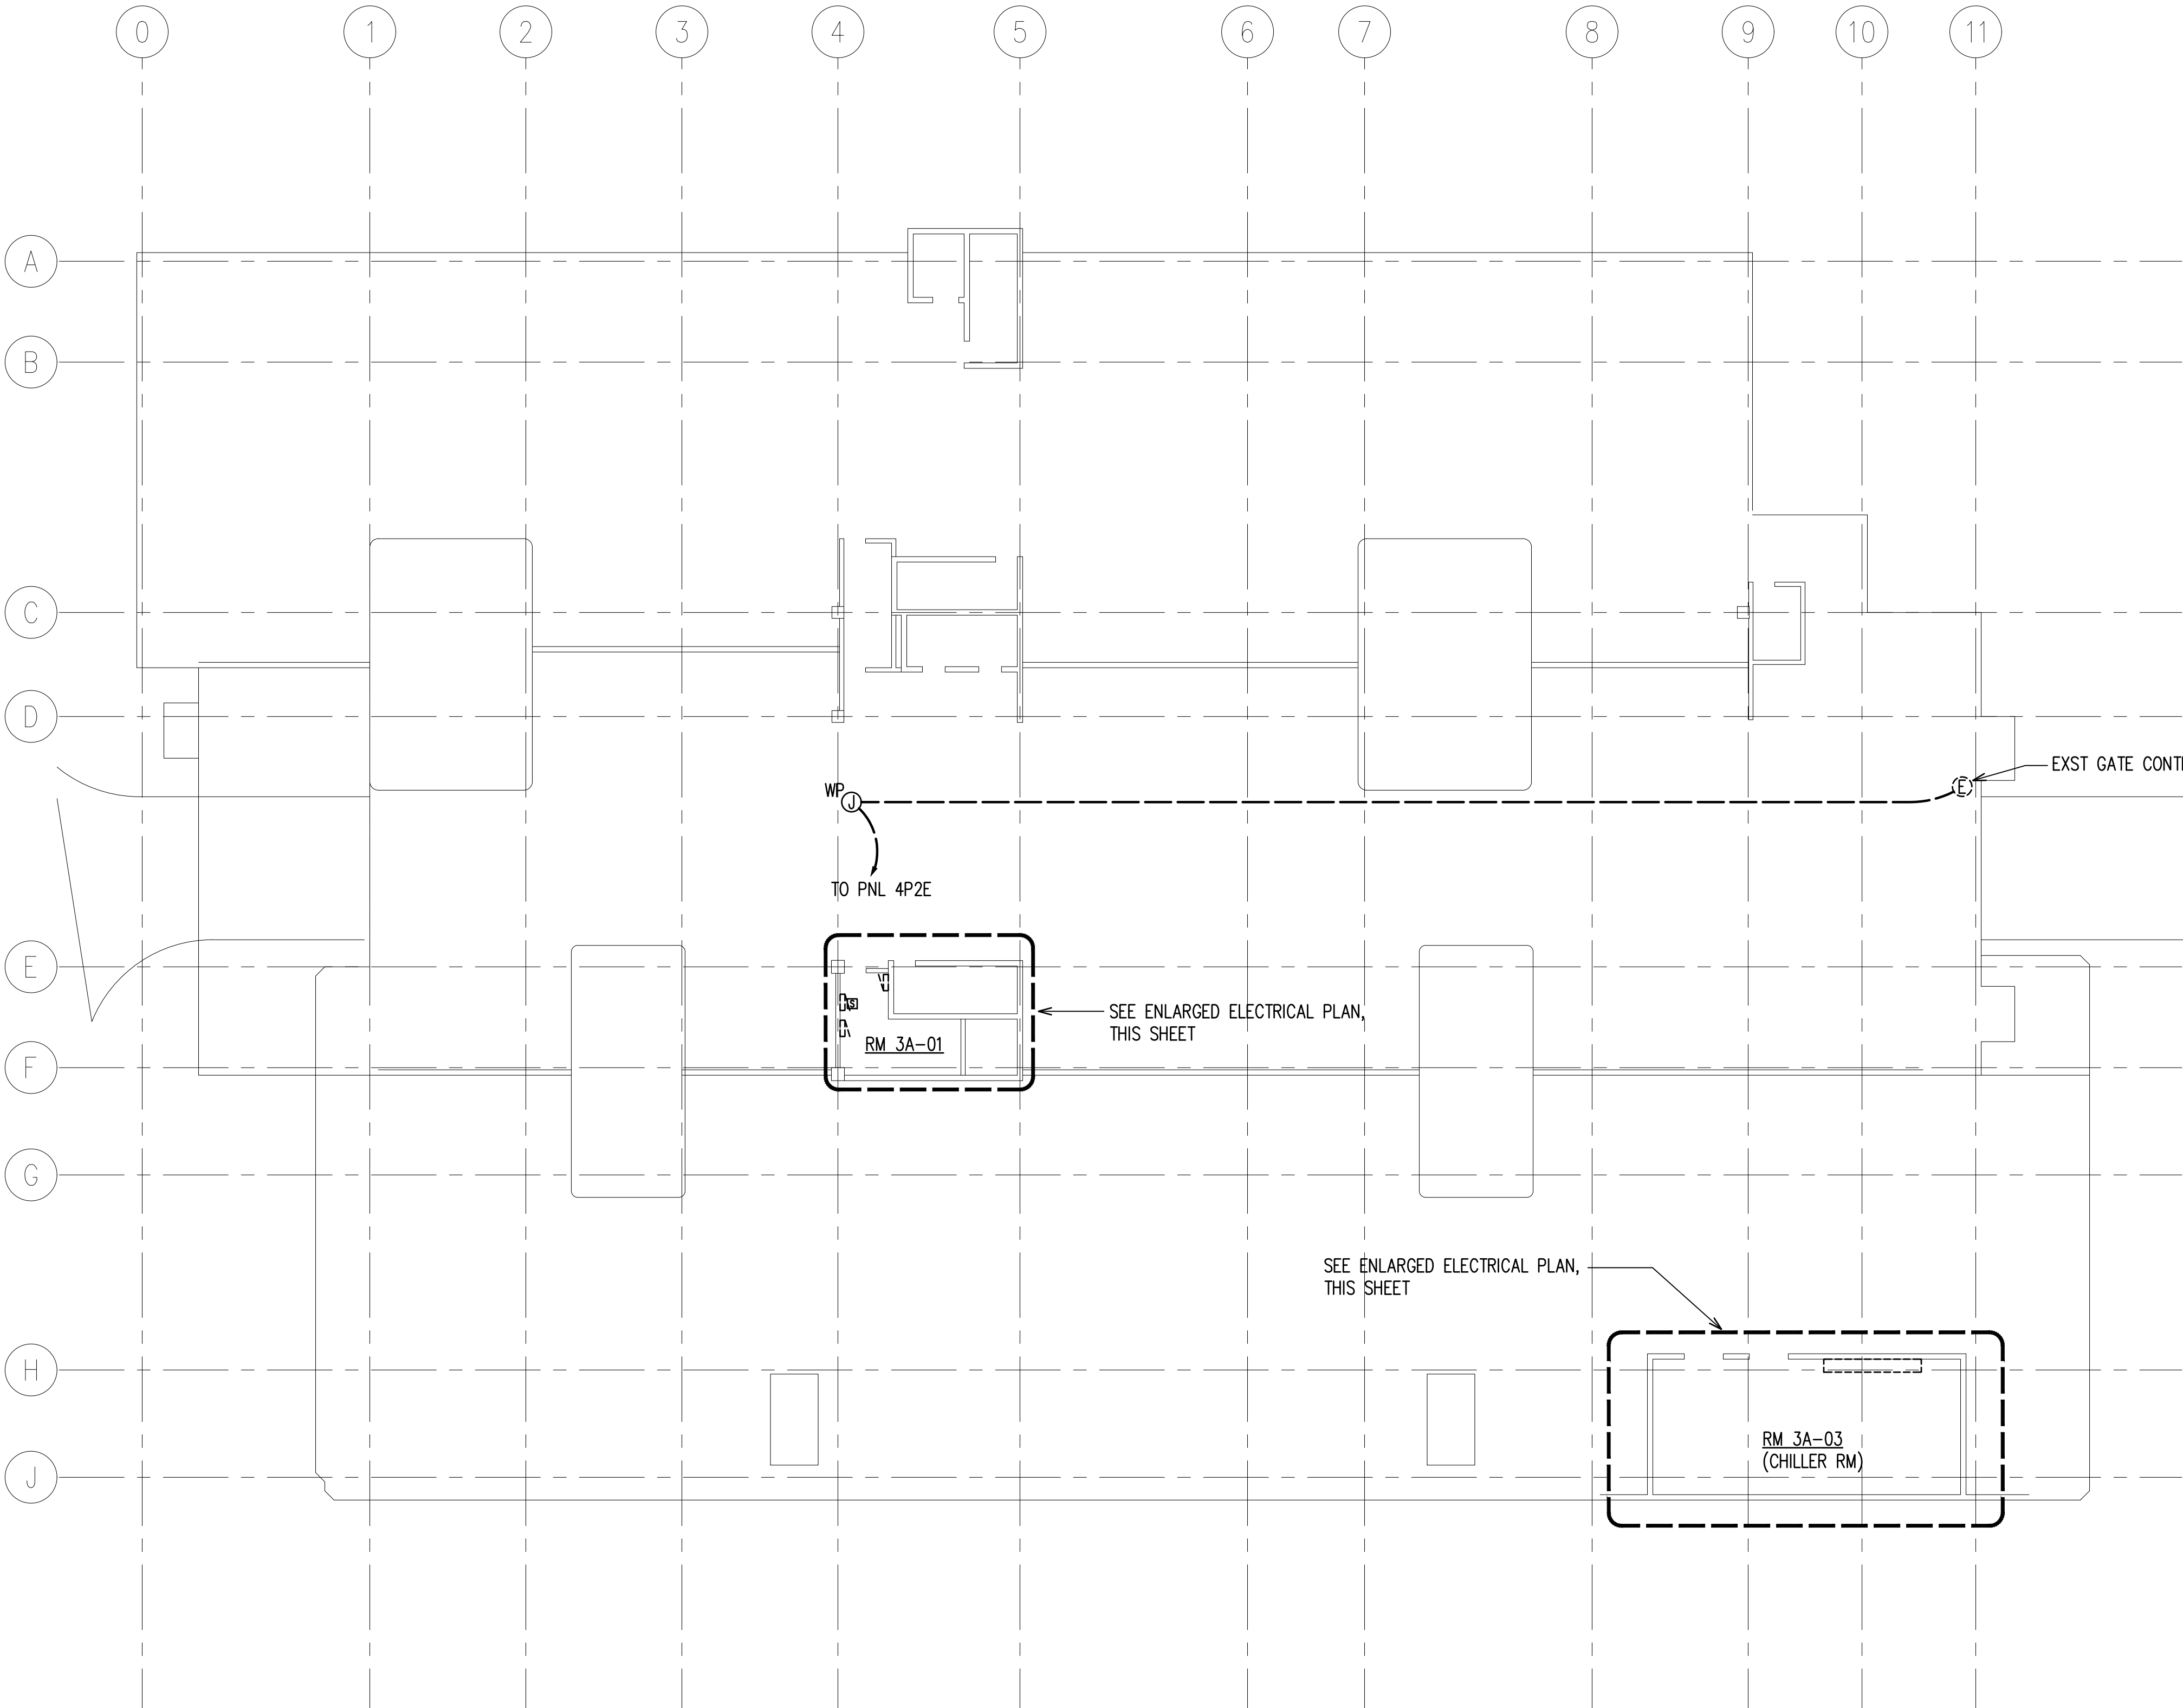



ENLARGED ELECTRICAL PLAN – RM 3A-01
SCALE: 1/8"=1'-0"

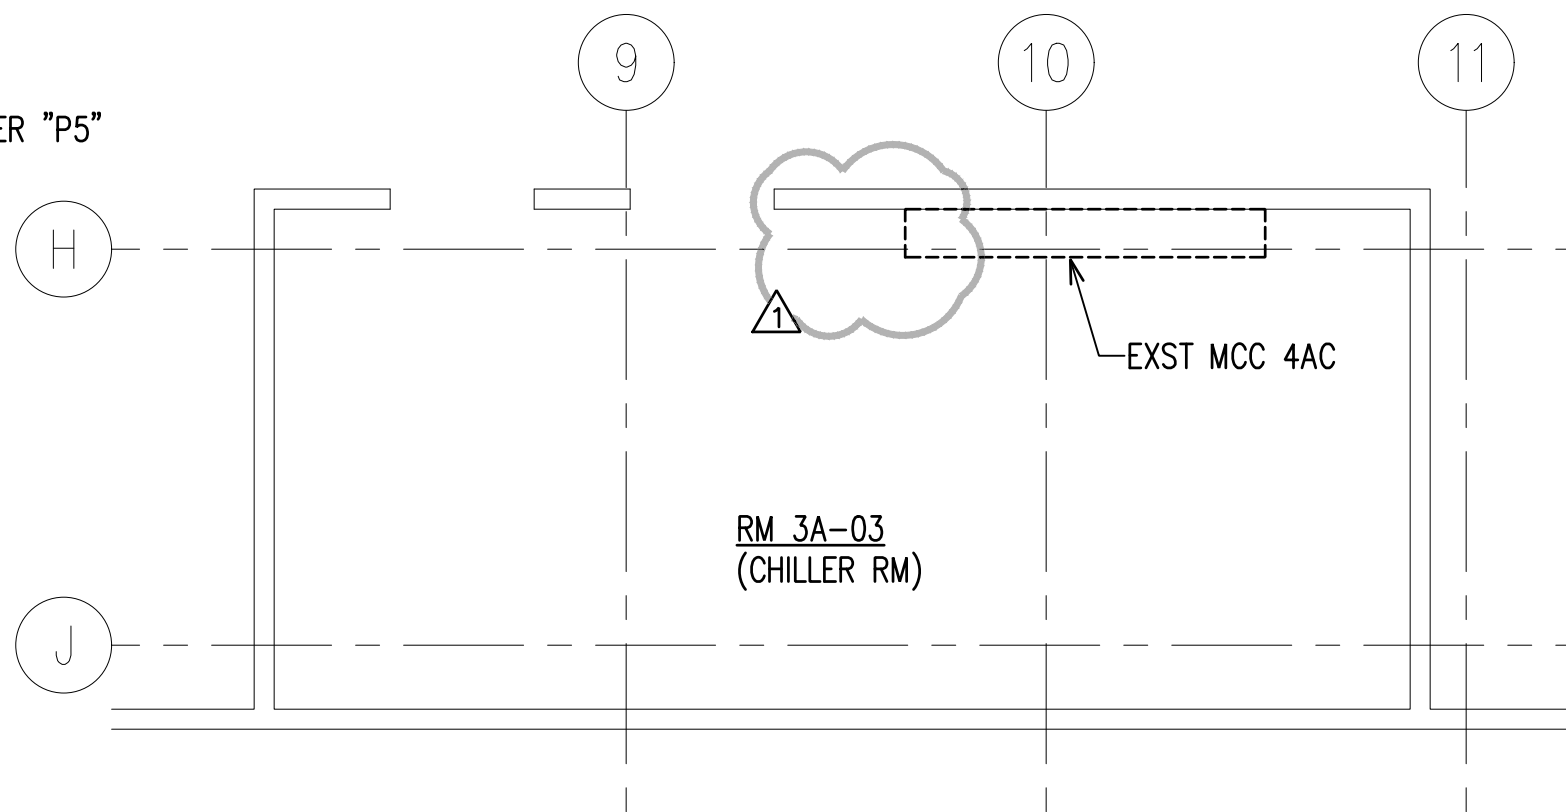



ENLARGED ELECTRICAL PLAN – RM 3A-03
SCALE: 1/8"=1'-0"

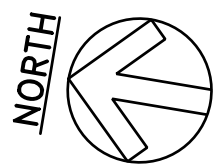


ELECTRICAL PLAN – PARKING LEVEL 3
SCALE: 1/16"=1'-0"

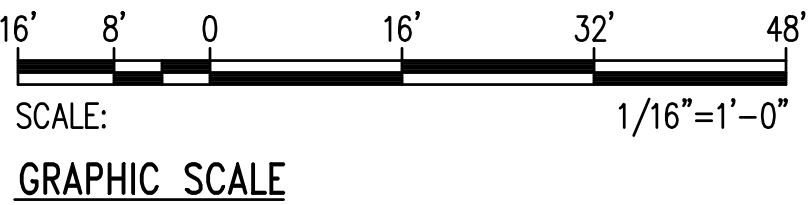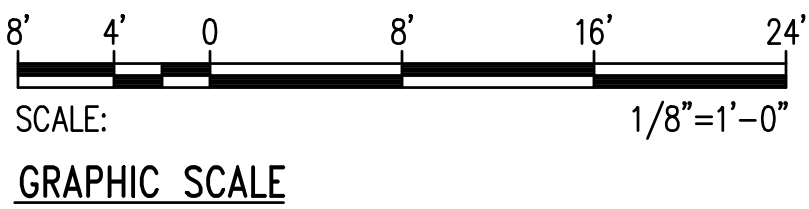


REV 1	⚠	REVISION 1		5/5/26						
REVISION NO.	SYM.	DESCRIPTION	SHT. OF	DATE	APPROVED: ADMINISTRATIVE DIRECTOR OF COURTS					
			THE JUDICIARY STATE OF HAWAII'							
			HOAPI'I HALE POWER QUALITY SYSTEM IMPROVEMENTS 2145 MAIN STREET, WAILUKU, HAWAII, 96793 TAX MAP KEY: 3-4-013:013							
			WAILUKU	MAUI	HAWAII					
			ELECTRICAL PLAN - PARKING LEVEL 3							
THIS WORK WAS PREPARED BY ME OR UNDER MY SUPERVISION AND CONSTRUCTION OF THIS PROJECT WILL BE UNDER MY OBSERVATION. Digitally signed by Ryan Karamatsu 2026.05.08 11:16:54-10707										
						RONALD N.S. HO & ASSOC., INC.		JUDICIARY PROJECT NO.	DRAWING NO.	
						DESIGNED BY: RK	CHECKED BY: RK	2526-02-076	E203	
						DRAWN BY: CAD	APPROVED BY: RK	DATE FEB 2026	SHEET 6 13	
SCALE: AS SHOWN			SHTS							
EXP. DATE: 4-30-28										

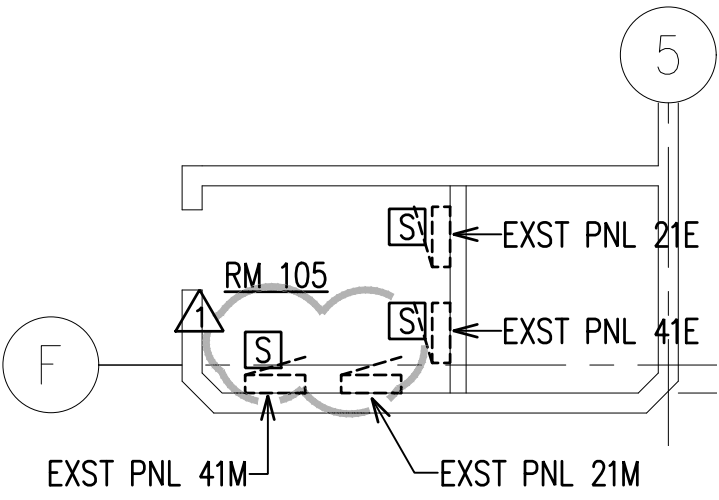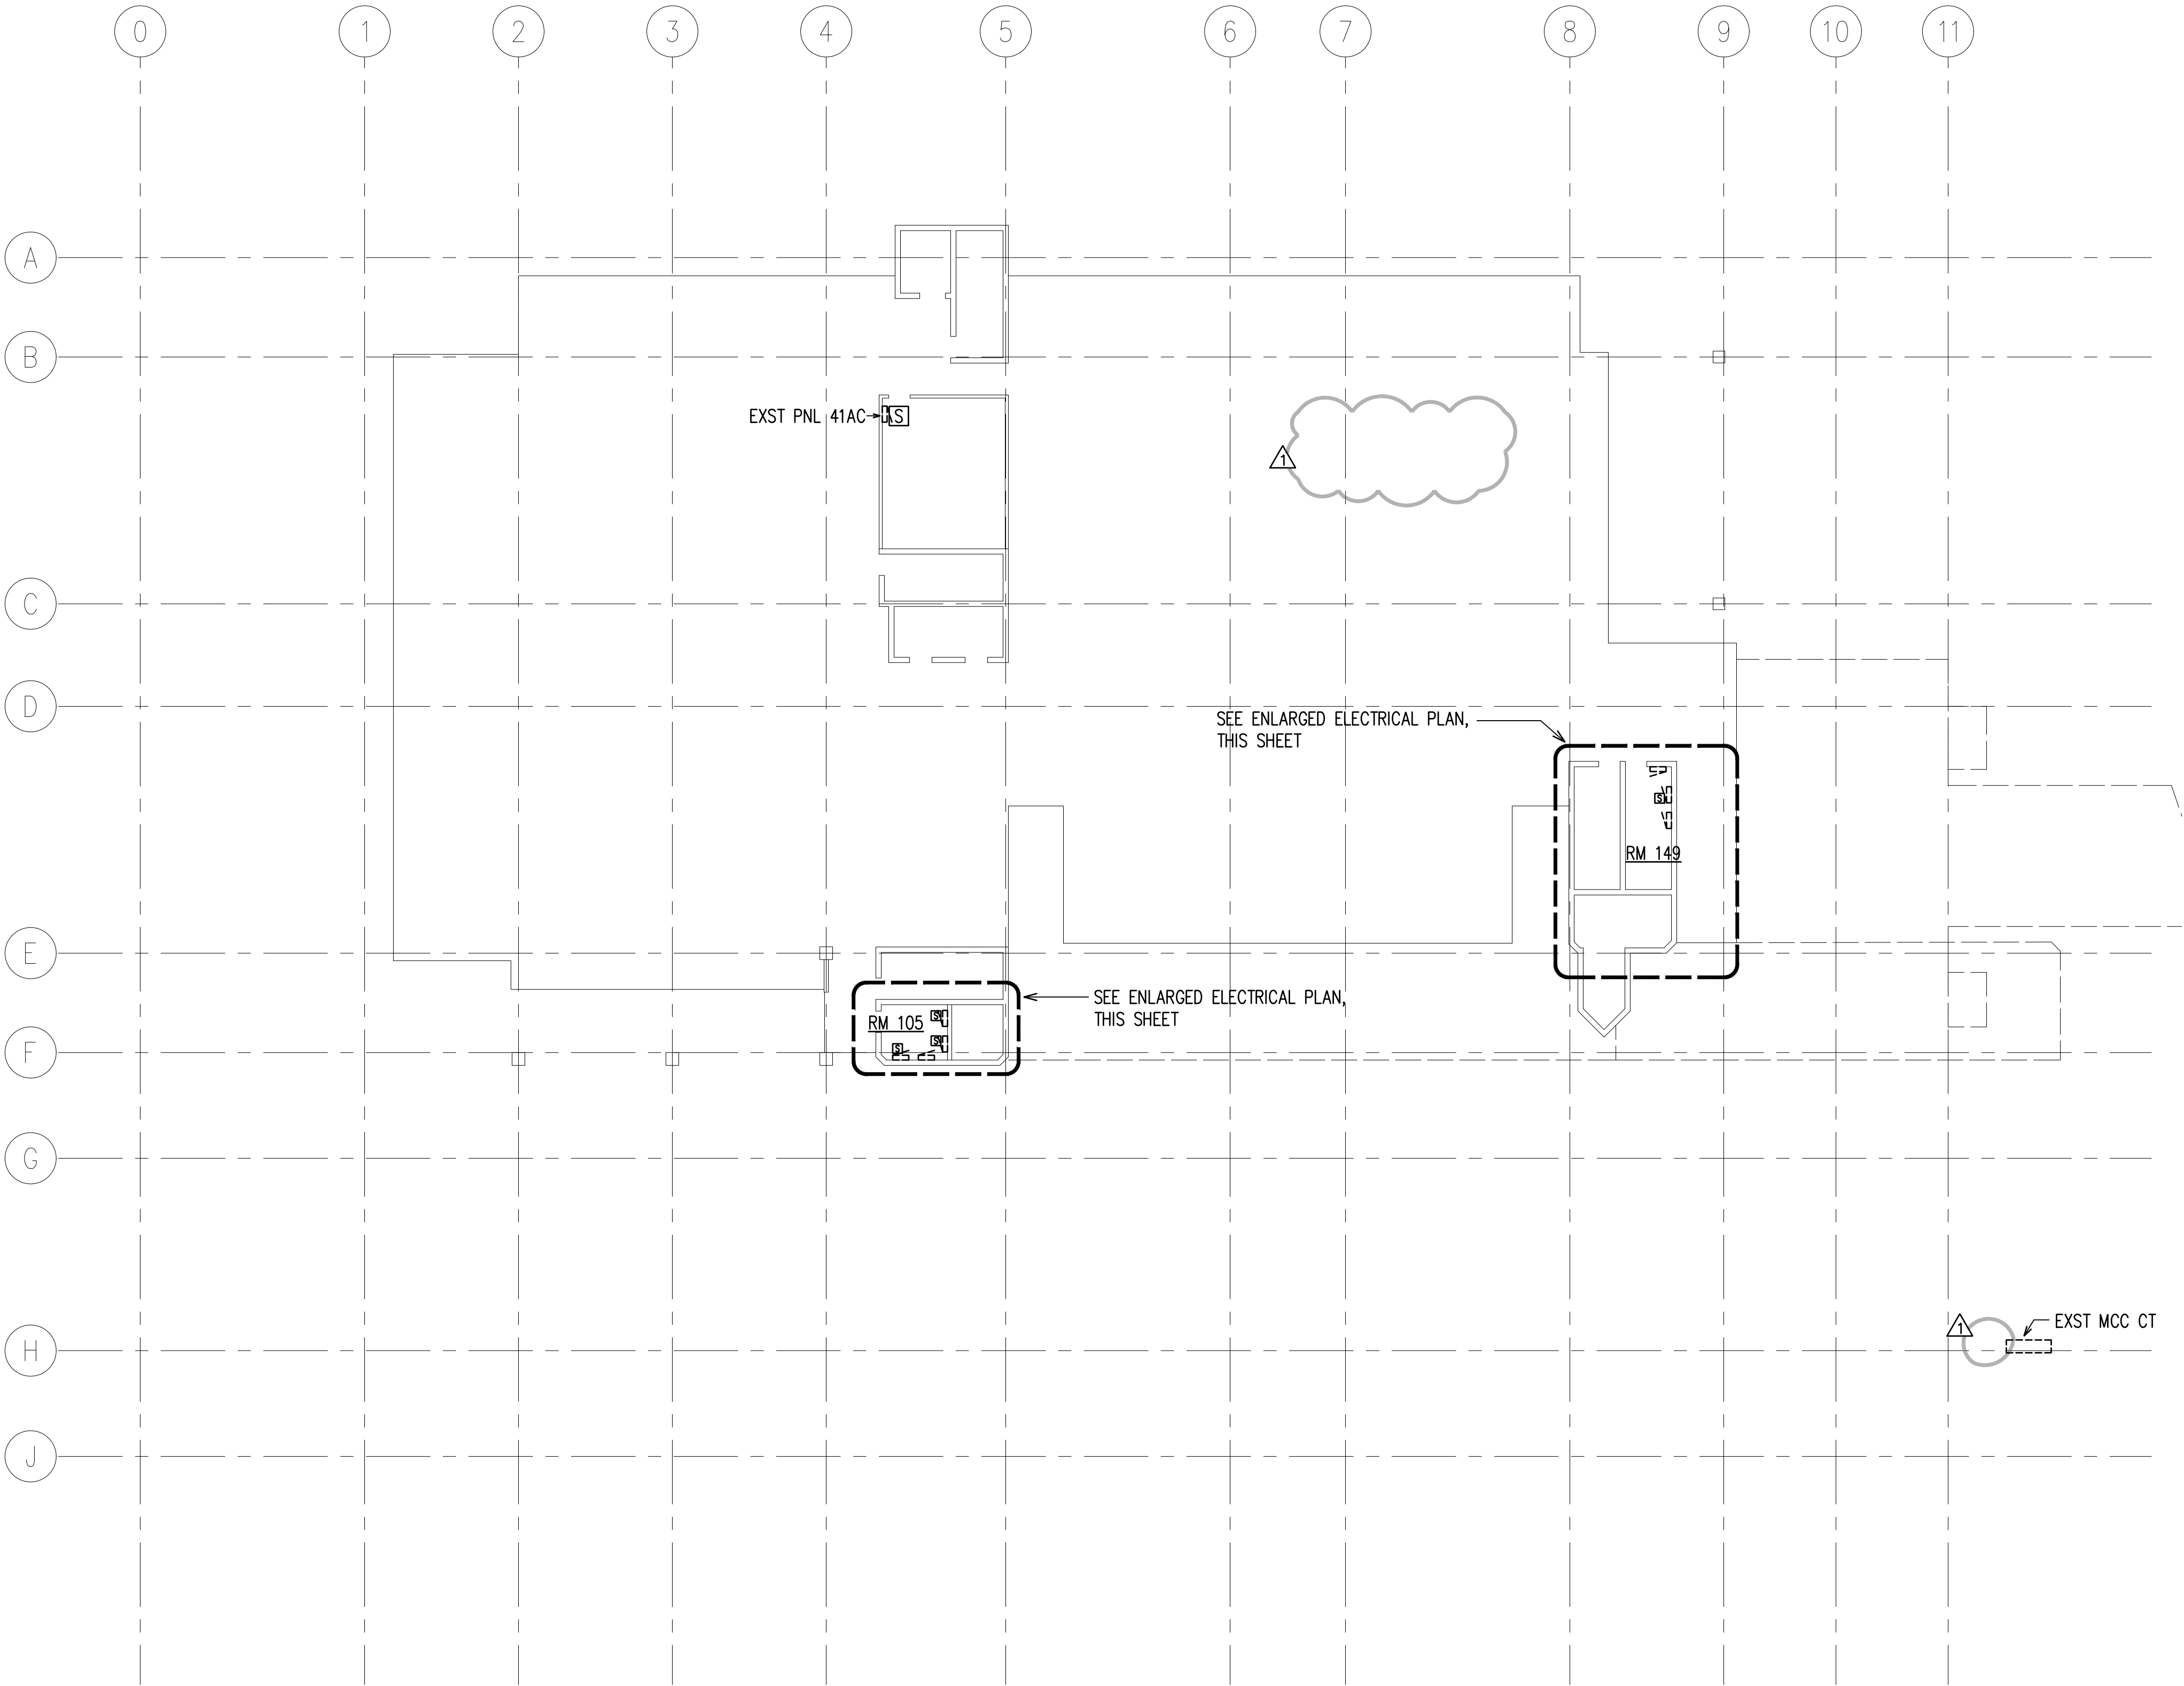



ENLARGED ELECTRICAL PLAN – RM 105
SCALE: 1/8"=1'-0"

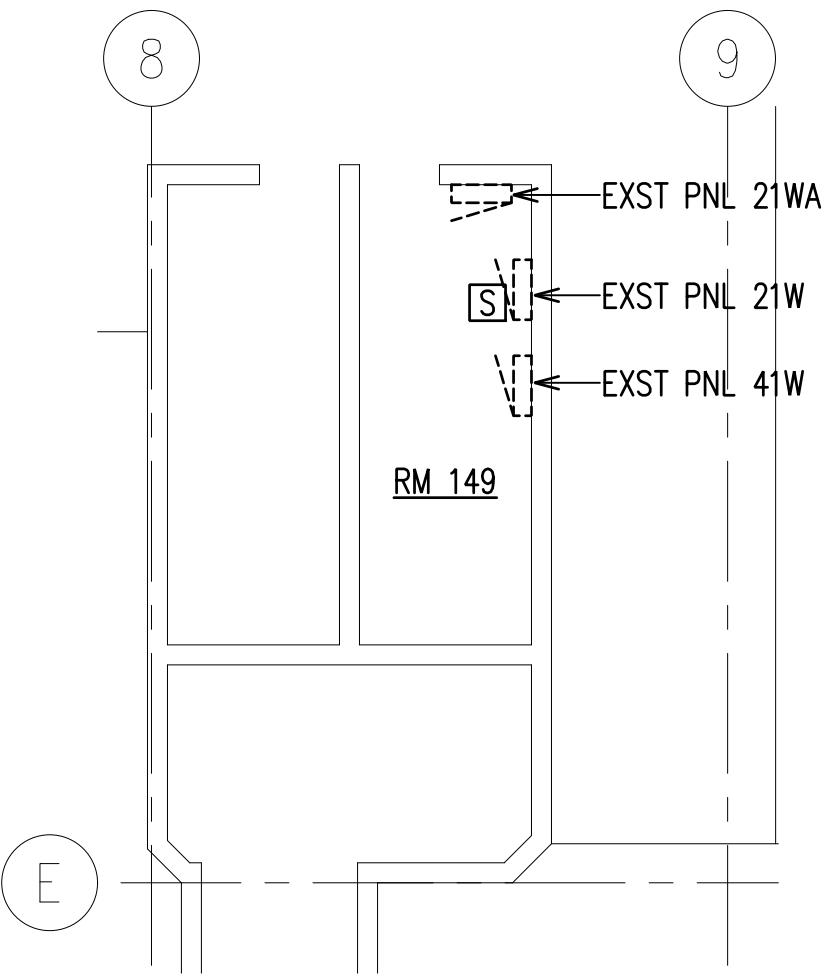



ENLARGED ELECTRICAL PLAN – RM 149
SCALE: 1/8"=1'-0"

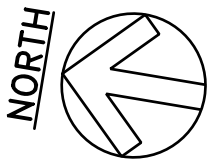


ELECTRICAL PLAN – 1ST FLOOR
SCALE: 1/16"=1'-0"

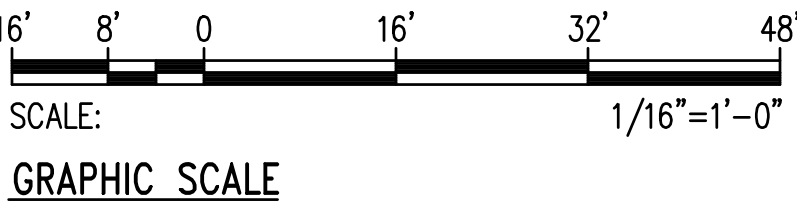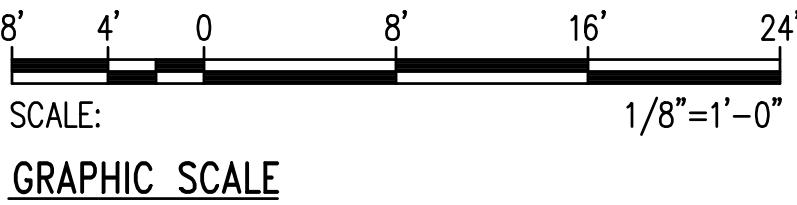


REV 1		△	REVISION 1		5/5/26	
REVISION NO.	SYM.	DESCRIPTION		SHT. OF	DATE	APPROVED: ADMINISTRATIVE DIRECTOR OF COURTS
		THE JUDICIARY STATE OF HAWAII'				
		HOAPILI HALE POWER QUALITY SYSTEM IMPROVEMENTS 2145 MAIN STREET, WAILUKU, HAWAII, 96793 TAX MAP KEY: 3-4-013:013 WAILUKU MAUI HAWAII				
		ELECTRICAL PLAN - 1ST FLOOR				
		RONALD N.S. HO & ASSOC., INC.				
DESIGNED BY: RK	CHECKED BY: RK	JUDICIARY PROJECT NO. 2526-02-076		DRAWING NO. E204		
DRAWN BY: CAD	APPROVED BY: RK	DATE FEB 2026		SHEET 7 OF 13		
EXP. DATE: 4-30-28		SCALE: AS SHOWN				

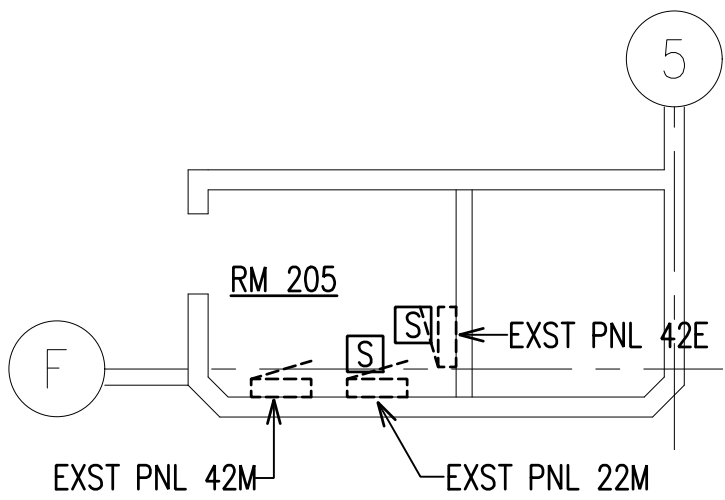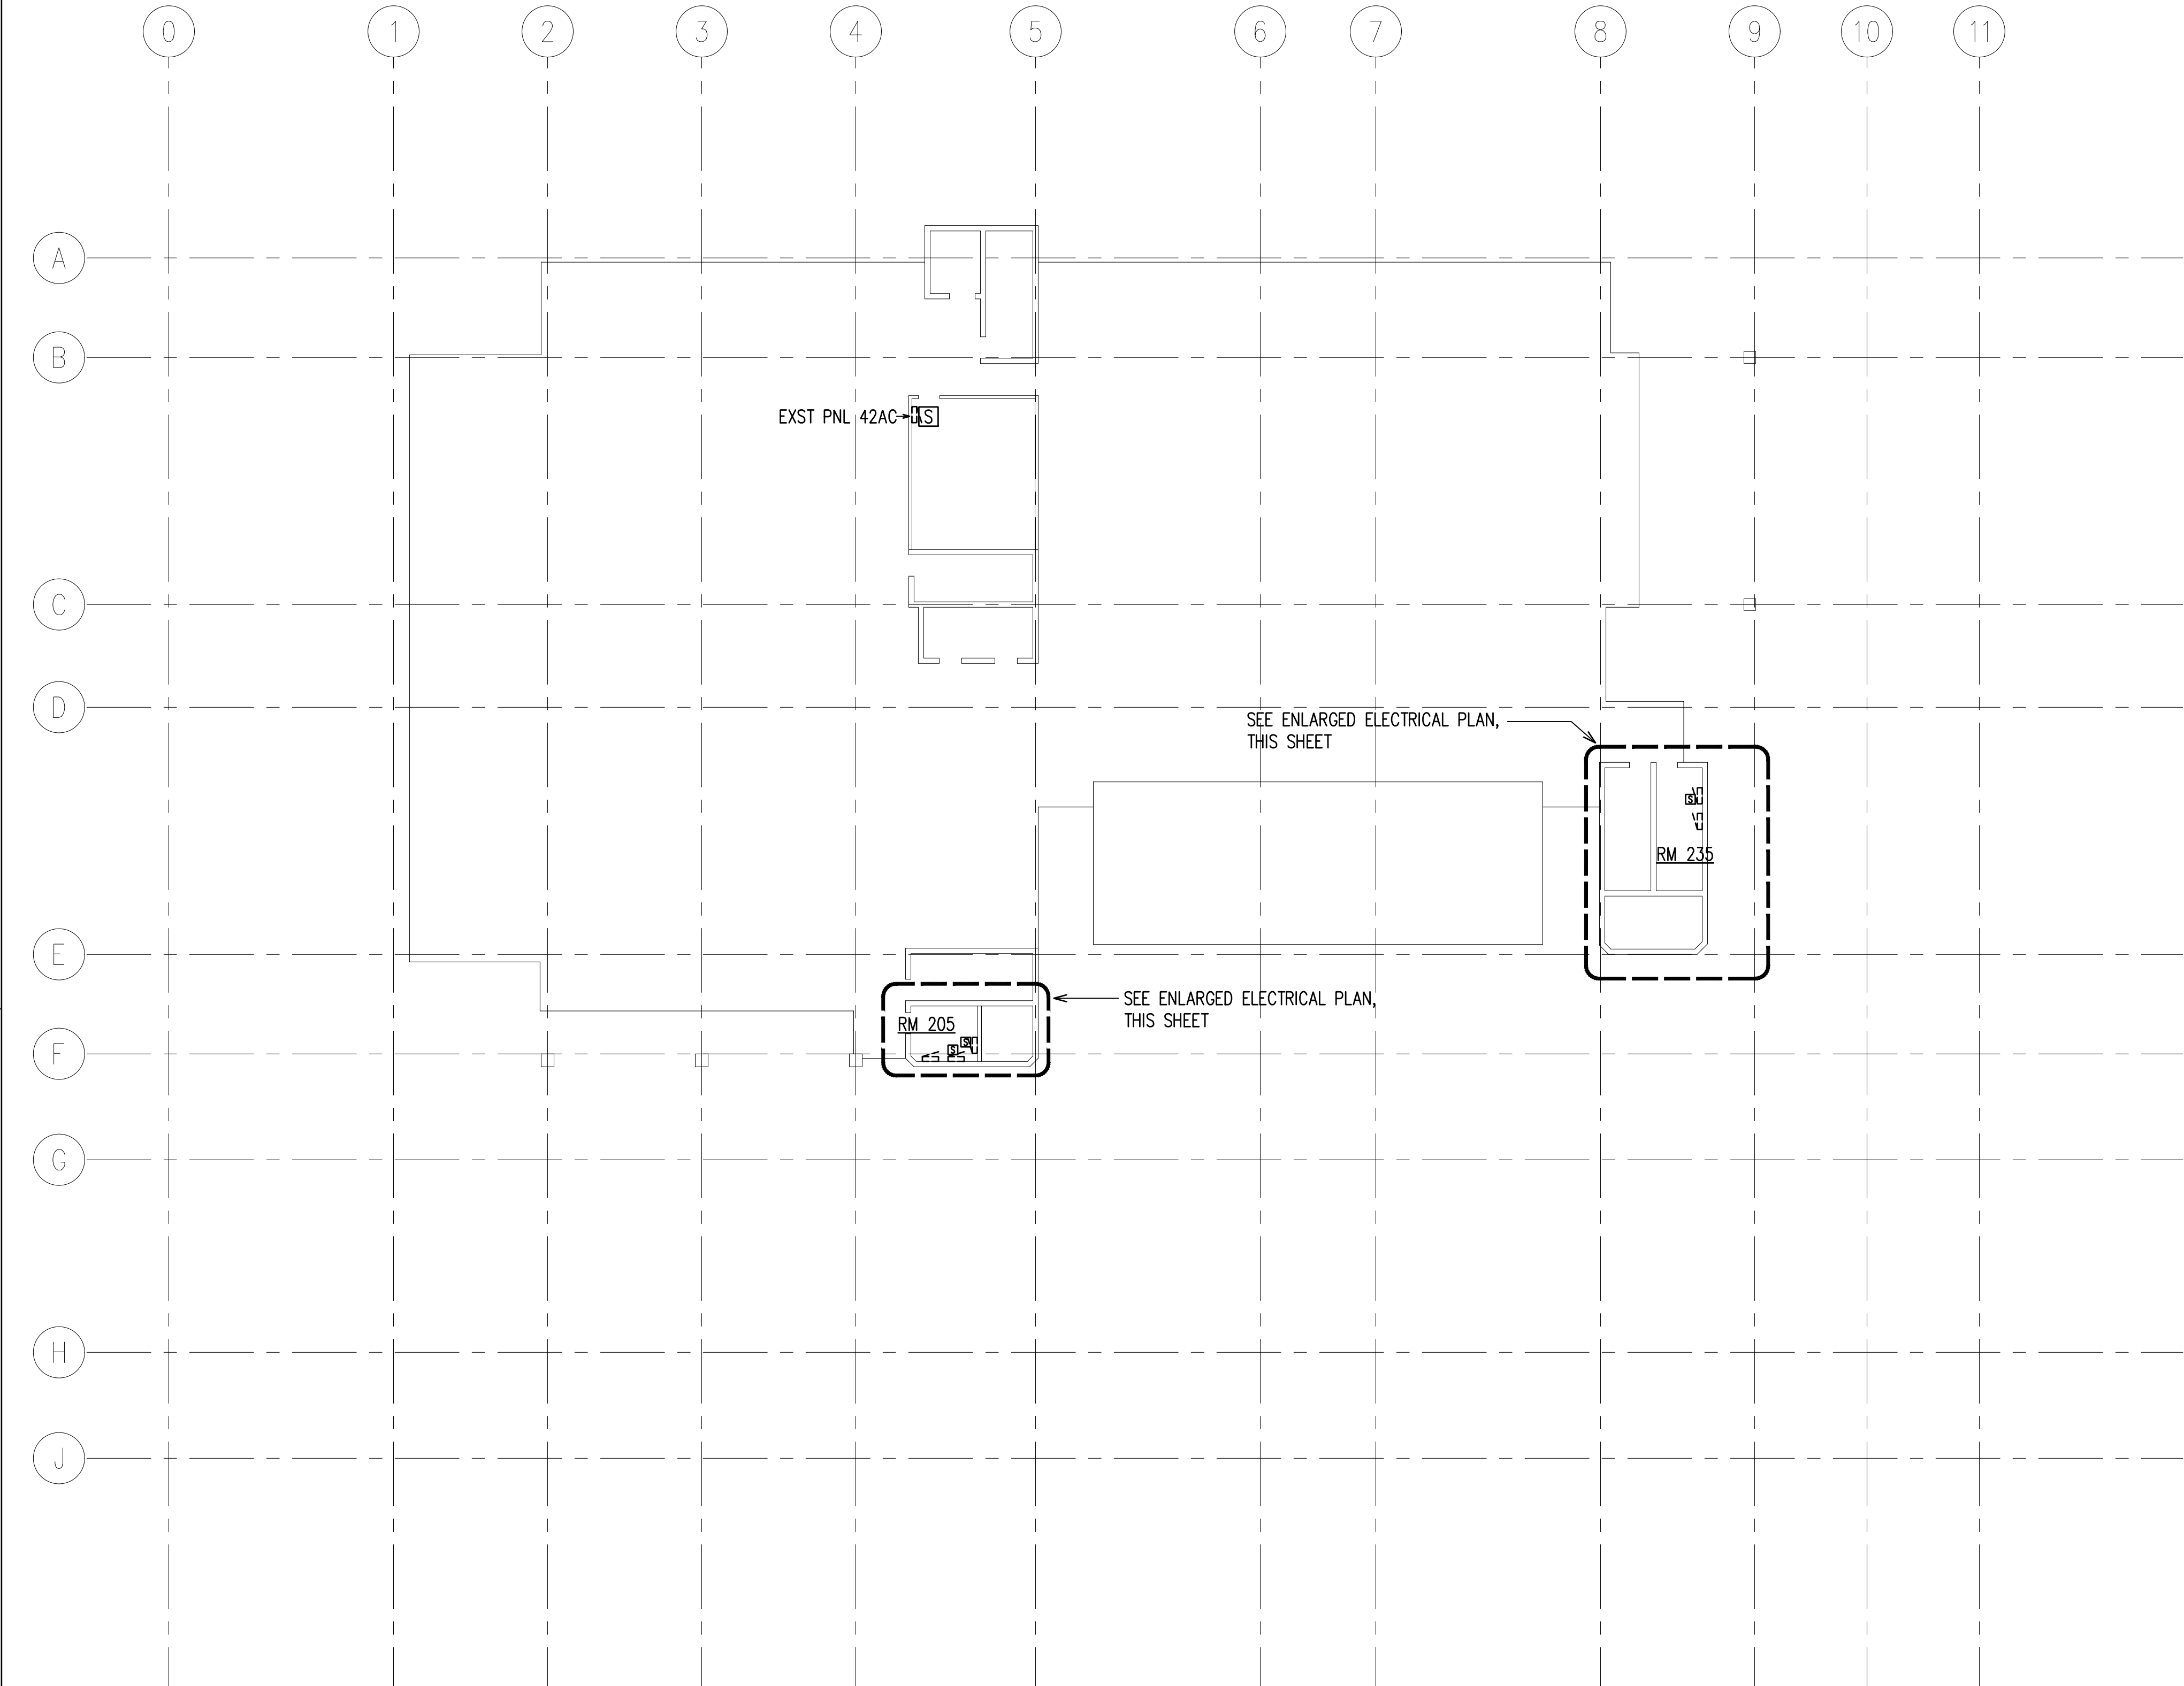



ENLARGED ELECTRICAL PLAN – RM 205
SCALE: 1/8"=1'-0"

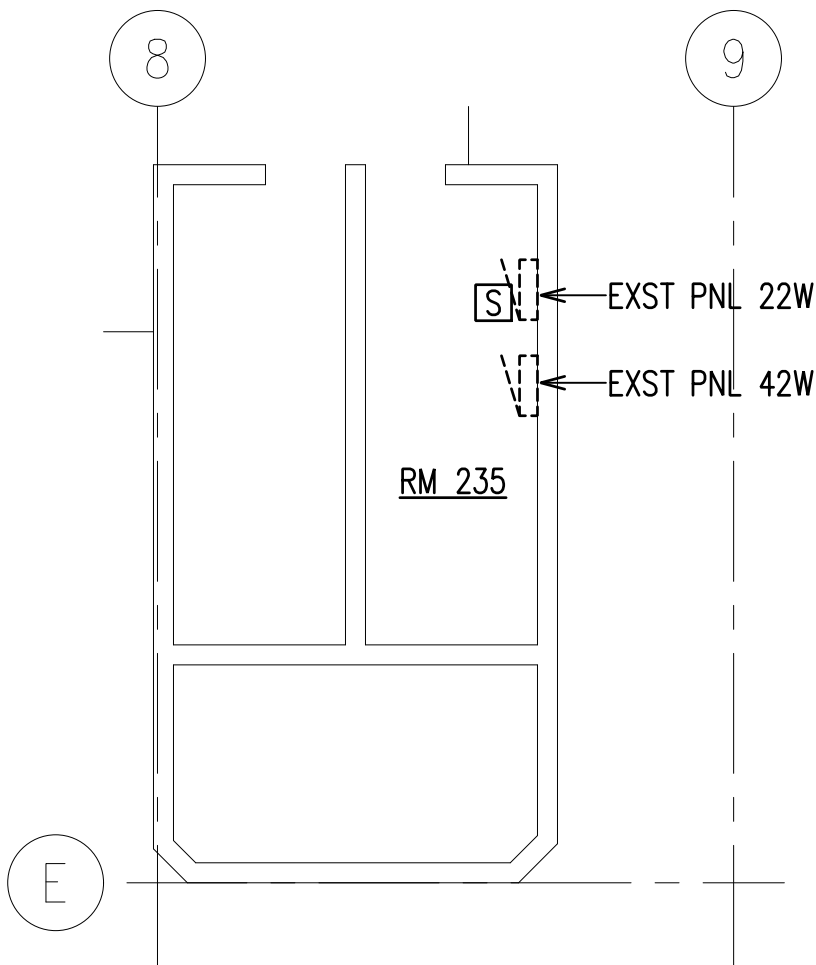



ENLARGED ELECTRICAL PLAN – RM 235
SCALE: 1/8"=1'-0"

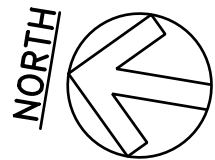

ELECTRICAL PLAN – 2ND FLOOR
SCALE: 1/16"=1'-0"


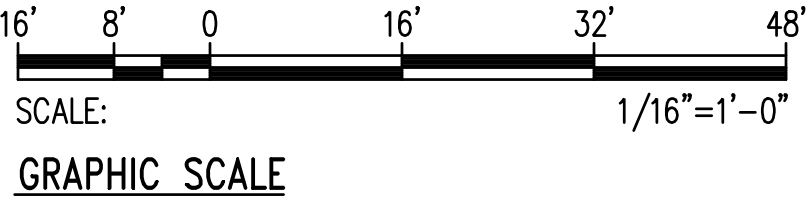
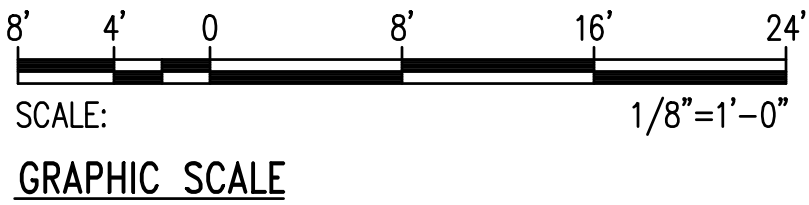


REVISION NO.		SYM.	DESCRIPTION	SHT. OF	DATE	APPROVED: ADMINISTRATIVE DIRECTOR OF COURTS
THIS WORK WAS PREPARED BY ME OR UNDER MY SUPERVISION AND CONSTRUCTION OF THIS PROJECT WILL BE UNDER MY OBSERVATION. <i>Ryan S. Karamatsu</i> Digitally signed by Ryan Karamatsu 2026.05.08 11:13:55-10100 EXP. DATE: 4-30-28						
THE JUDICIARY STATE OF HAWAII'						
HOAPILI HALE POWER QUALITY SYSTEM IMPROVEMENTS 2145 MAIN STREET, WAILUKU, HAWAII, 96793 TAX MAP KEY: 3-4-013:013 WAILUKU MAUI HAWAII						
ELECTRICAL PLAN - 2ND FLOOR						
RONALD N.S. HO & ASSOC., INC.			JUDICIARY PROJECT NO.	DRAWING NO.		
DESIGNED BY: RK	CHECKED BY: RK	2526-02-076		E205		
DRAWN BY: CAD	APPROVED BY: RK	DATE: FEB 2026	SHEET 8 OF 13 SHTS			
SCALE: AS SHOWN						

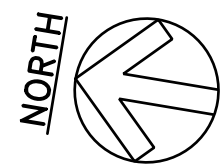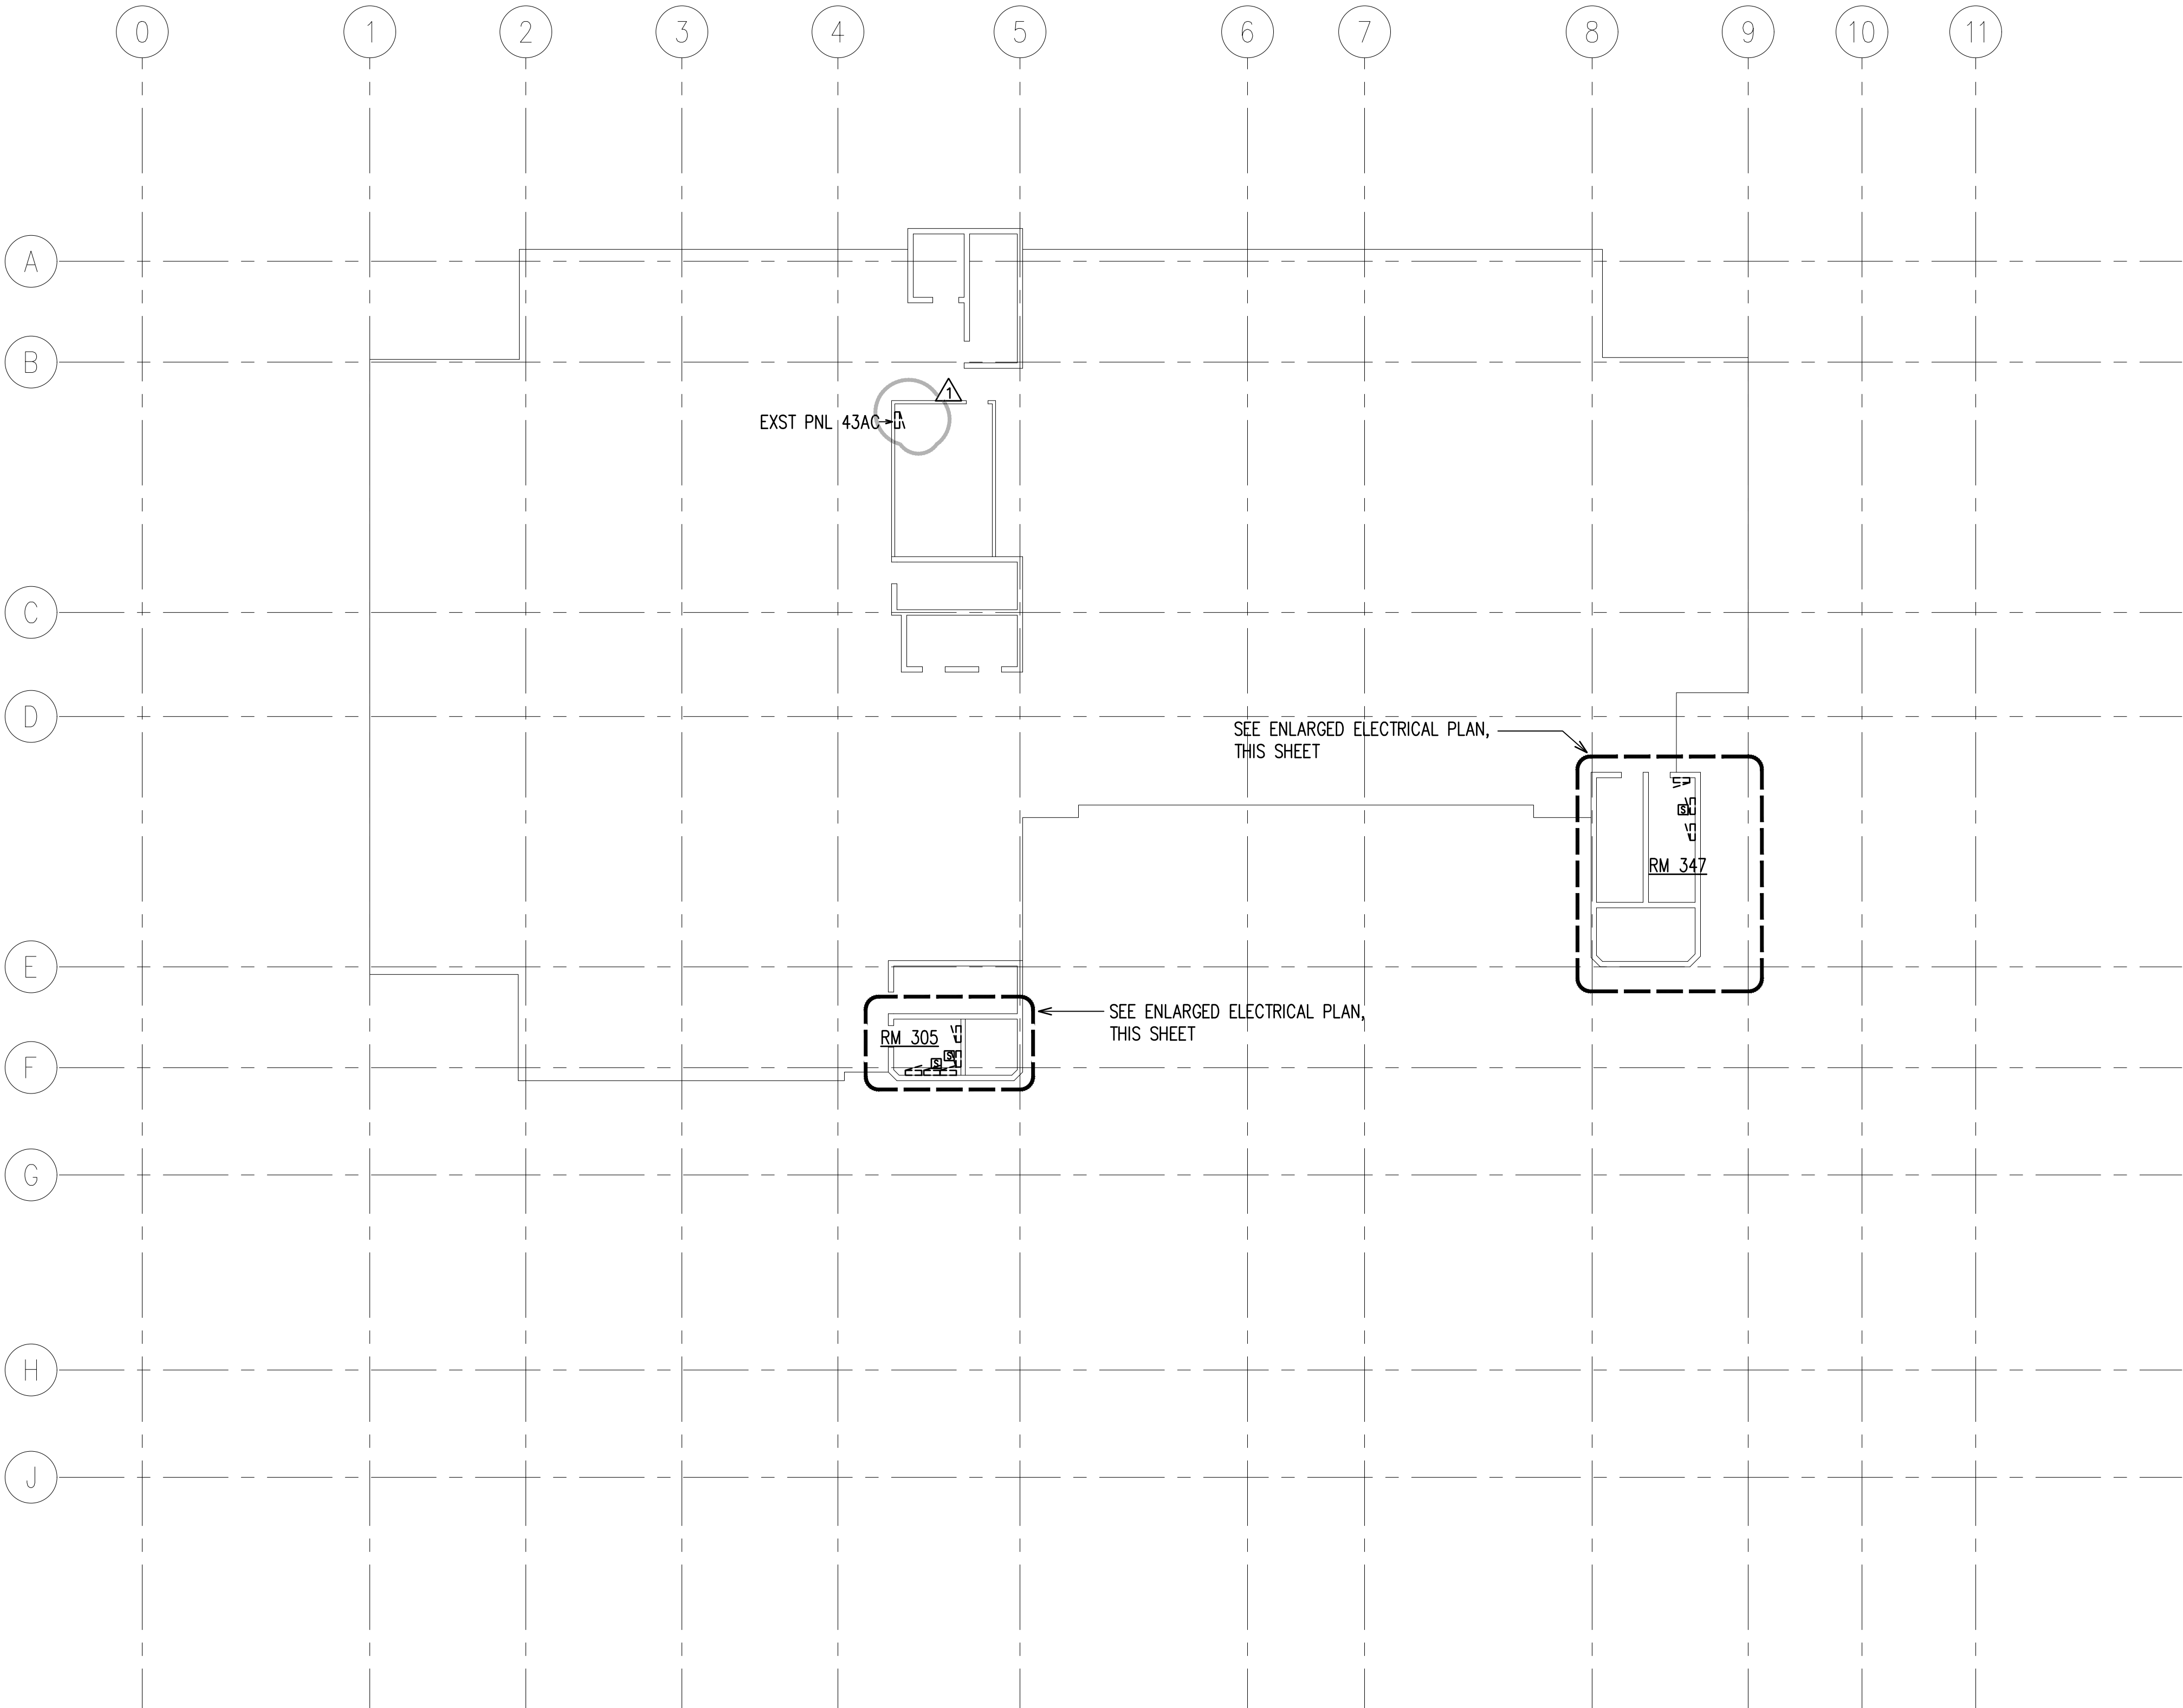


ELECTRICAL PLAN – 3RD FLOOR

SCALE: 1/16"=1'-0"

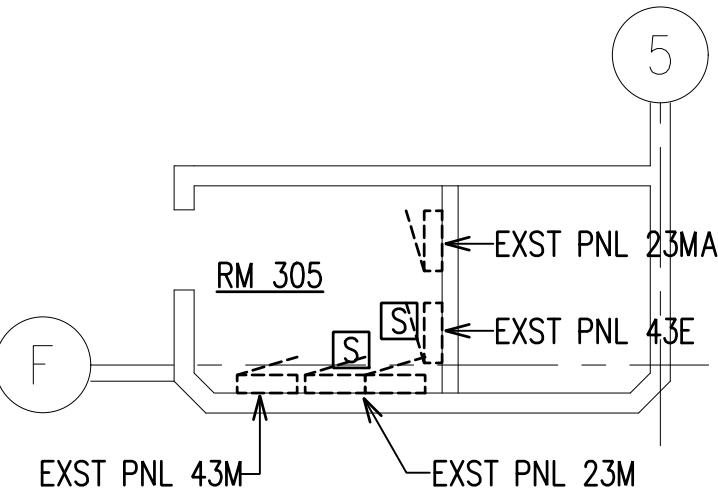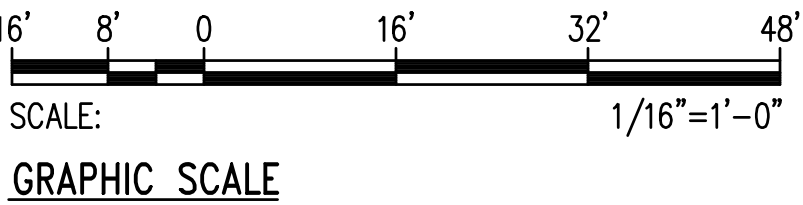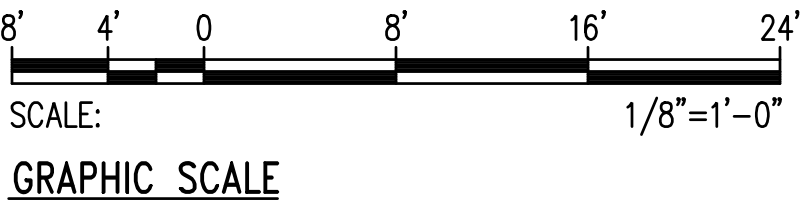


ENLARGED ELECTRICAL PLAN – RM 305



SCALE: 1/8"=1'-0"

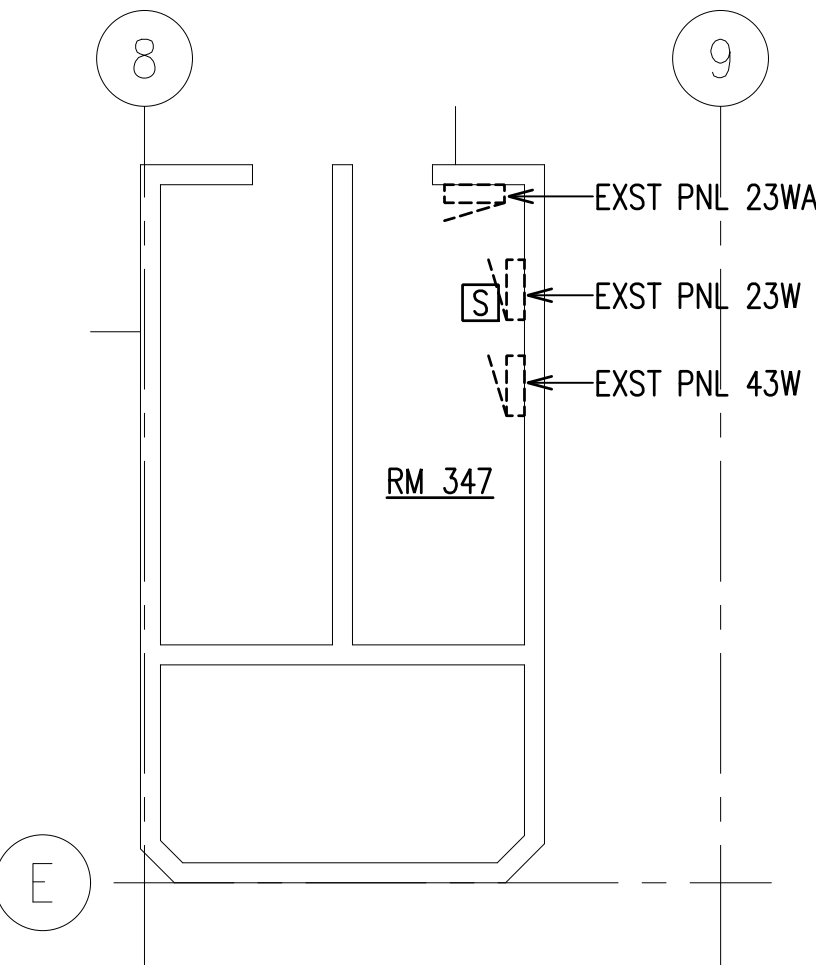


ENLARGED ELECTRICAL PLAN – RM 347

SCALE: 1/8"=1'-0"

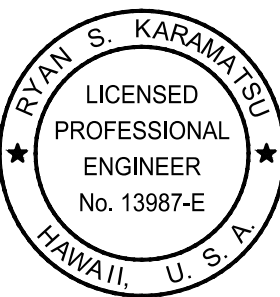
REV 1	△	REVISION 1		5/5/26	
REVISION NO.	SYM.	DESCRIPTION	SHT. OF _____	DATE	APPROVED: _____ ADMINISTRATIVE DIRECTOR OF COURTS
			THE JUDICIARY STATE OF HAWAII'		
			HOAPILI HALE POWER QUALITY SYSTEM IMPROVEMENTS 2145 MAIN STREET, WAILUKU, HAWAII, 96793 TAX MAP KEY: 3-4-013:013		
			WAILUKU	MAUI	HAWAII
			ELECTRICAL PLAN - 3RD FLOOR		
			RONALD N.S. HO & ASSOC., INC.		
DESIGNED BY: RK CHECKED BY: RK			JUDICIARY PROJECT NO. 2526-02-076	DRAWING NO. E206	
			DRAWN BY: CAD APPROVED BY: RK	DATE FEB 2026	SHEET 9 13 SHTS
EXP. DATE: 4-30-28			SCALE: AS SHOWN		

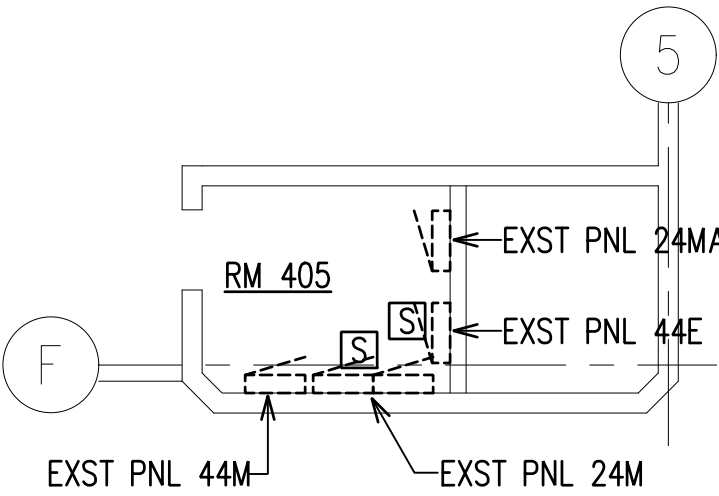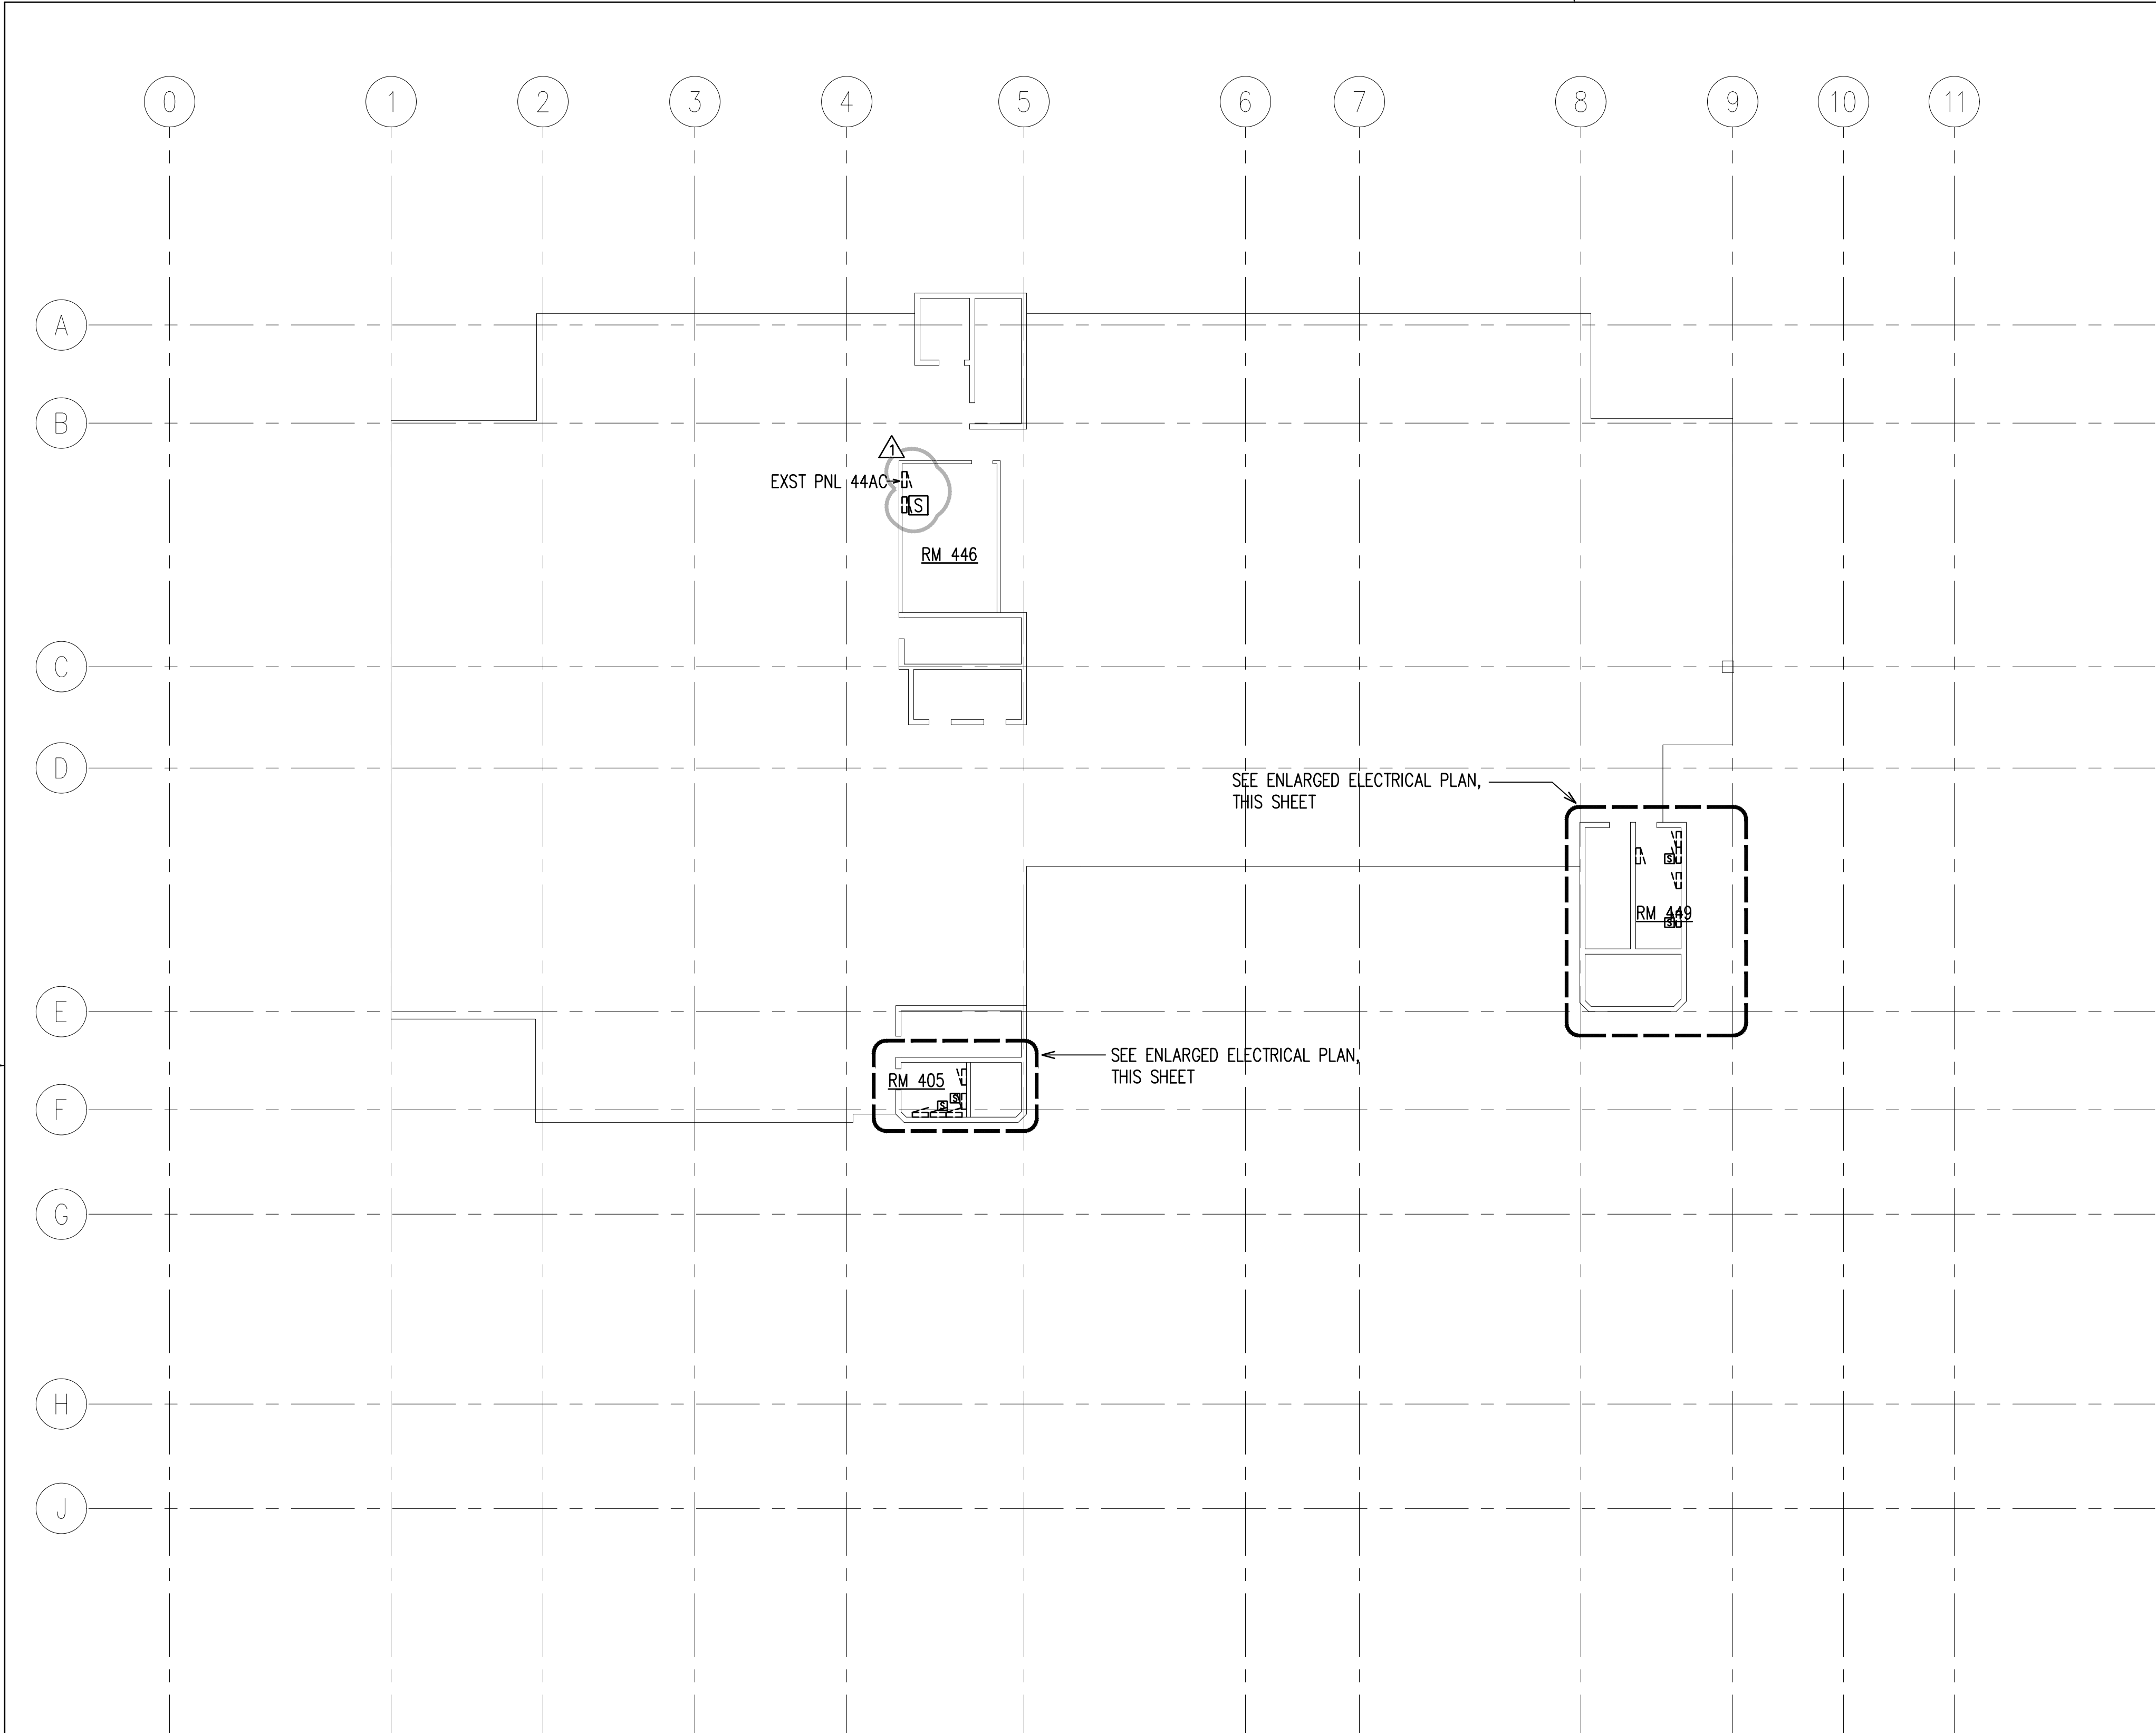



ENLARGED ELECTRICAL PLAN – RM 405
SCALE: 1/8"=1'-0"

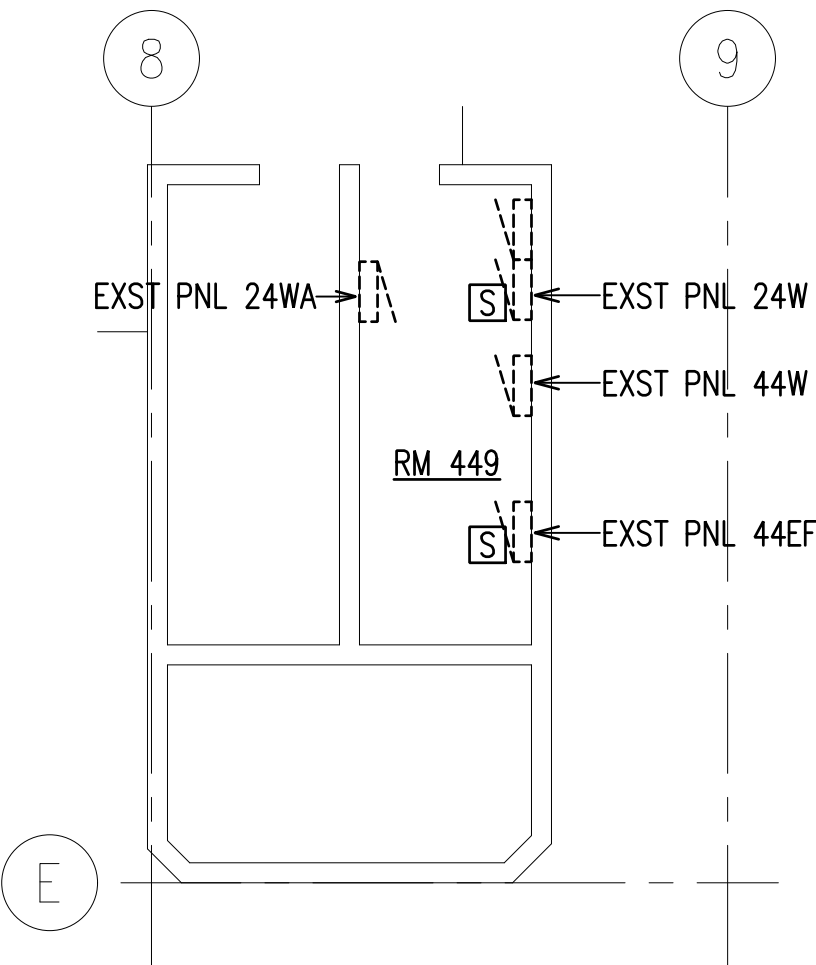



ENLARGED ELECTRICAL PLAN – RM 440
SCALE: 1/8"=1'-0"

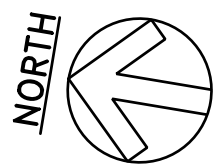


ELECTRICAL PLAN – 4TH FLOOR
SCALE: 1/16"=1'-0"

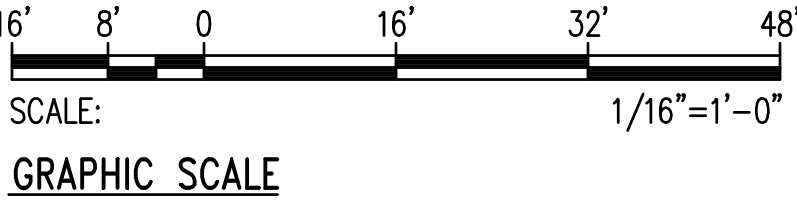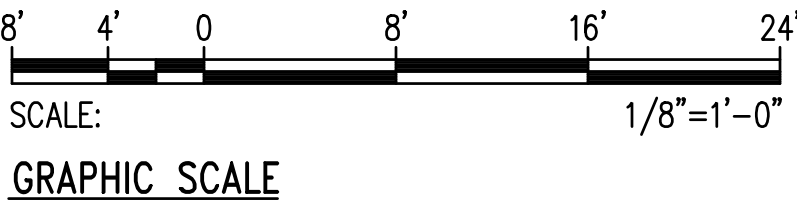


REV 1	△	REVISION 1		5/5/26	
REVISION NO.	SYM.	DESCRIPTION	SHT. OF	DATE	APPROVED: ADMINISTRATIVE DIRECTOR OF COURTS
RYAN S. KARAMATSU LICENSED PROFESSIONAL ENGINEER No. 13987-E HAWAII, U.S.A. THIS WORK WAS PREPARED BY ME OR UNDER MY SUPERVISION AND CONSTRUCTION OF THIS PROJECT WILL BE UNDER MY OBSERVATION. <i>Ryan S. Karamatsu</i> Digitally signed by Ryan Karamatsu 2026.05.08 11:13:59-10100 EXP. DATE: 4-30-28			THE JUDICIARY STATE OF HAWAII HOAPILI HALE POWER QUALITY SYSTEM IMPROVEMENTS 2145 MAIN STREET, WAILUKU, HAWAII, 96793 TAX MAP KEY: 3-4-013:013 WAILUKU MAUI HAWAII ELECTRICAL PLAN - 4TH FLOOR		
RONALD N.S. HO & ASSOC., INC.			JUDICIARY PROJECT NO.	DRAWING NO.	
DESIGNED BY: RK		CHECKED BY: RK	2526-02-076	E207	
DRAWN BY: CAD		APPROVED BY: RK	DATE: FEB 2026	SHEET 10	OF 13
SCALE: AS SHOWN			SHTS		

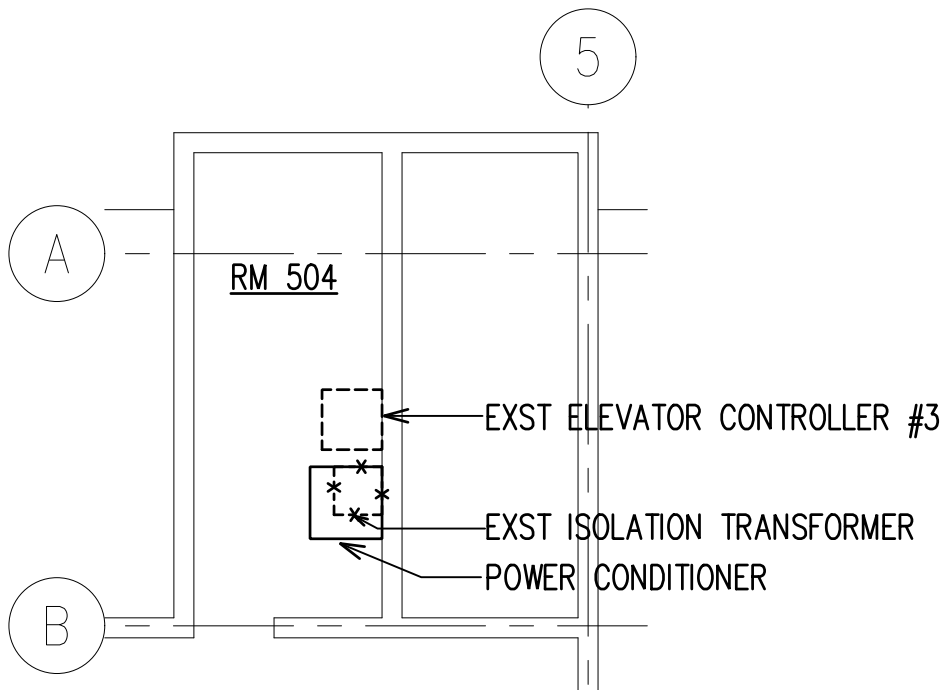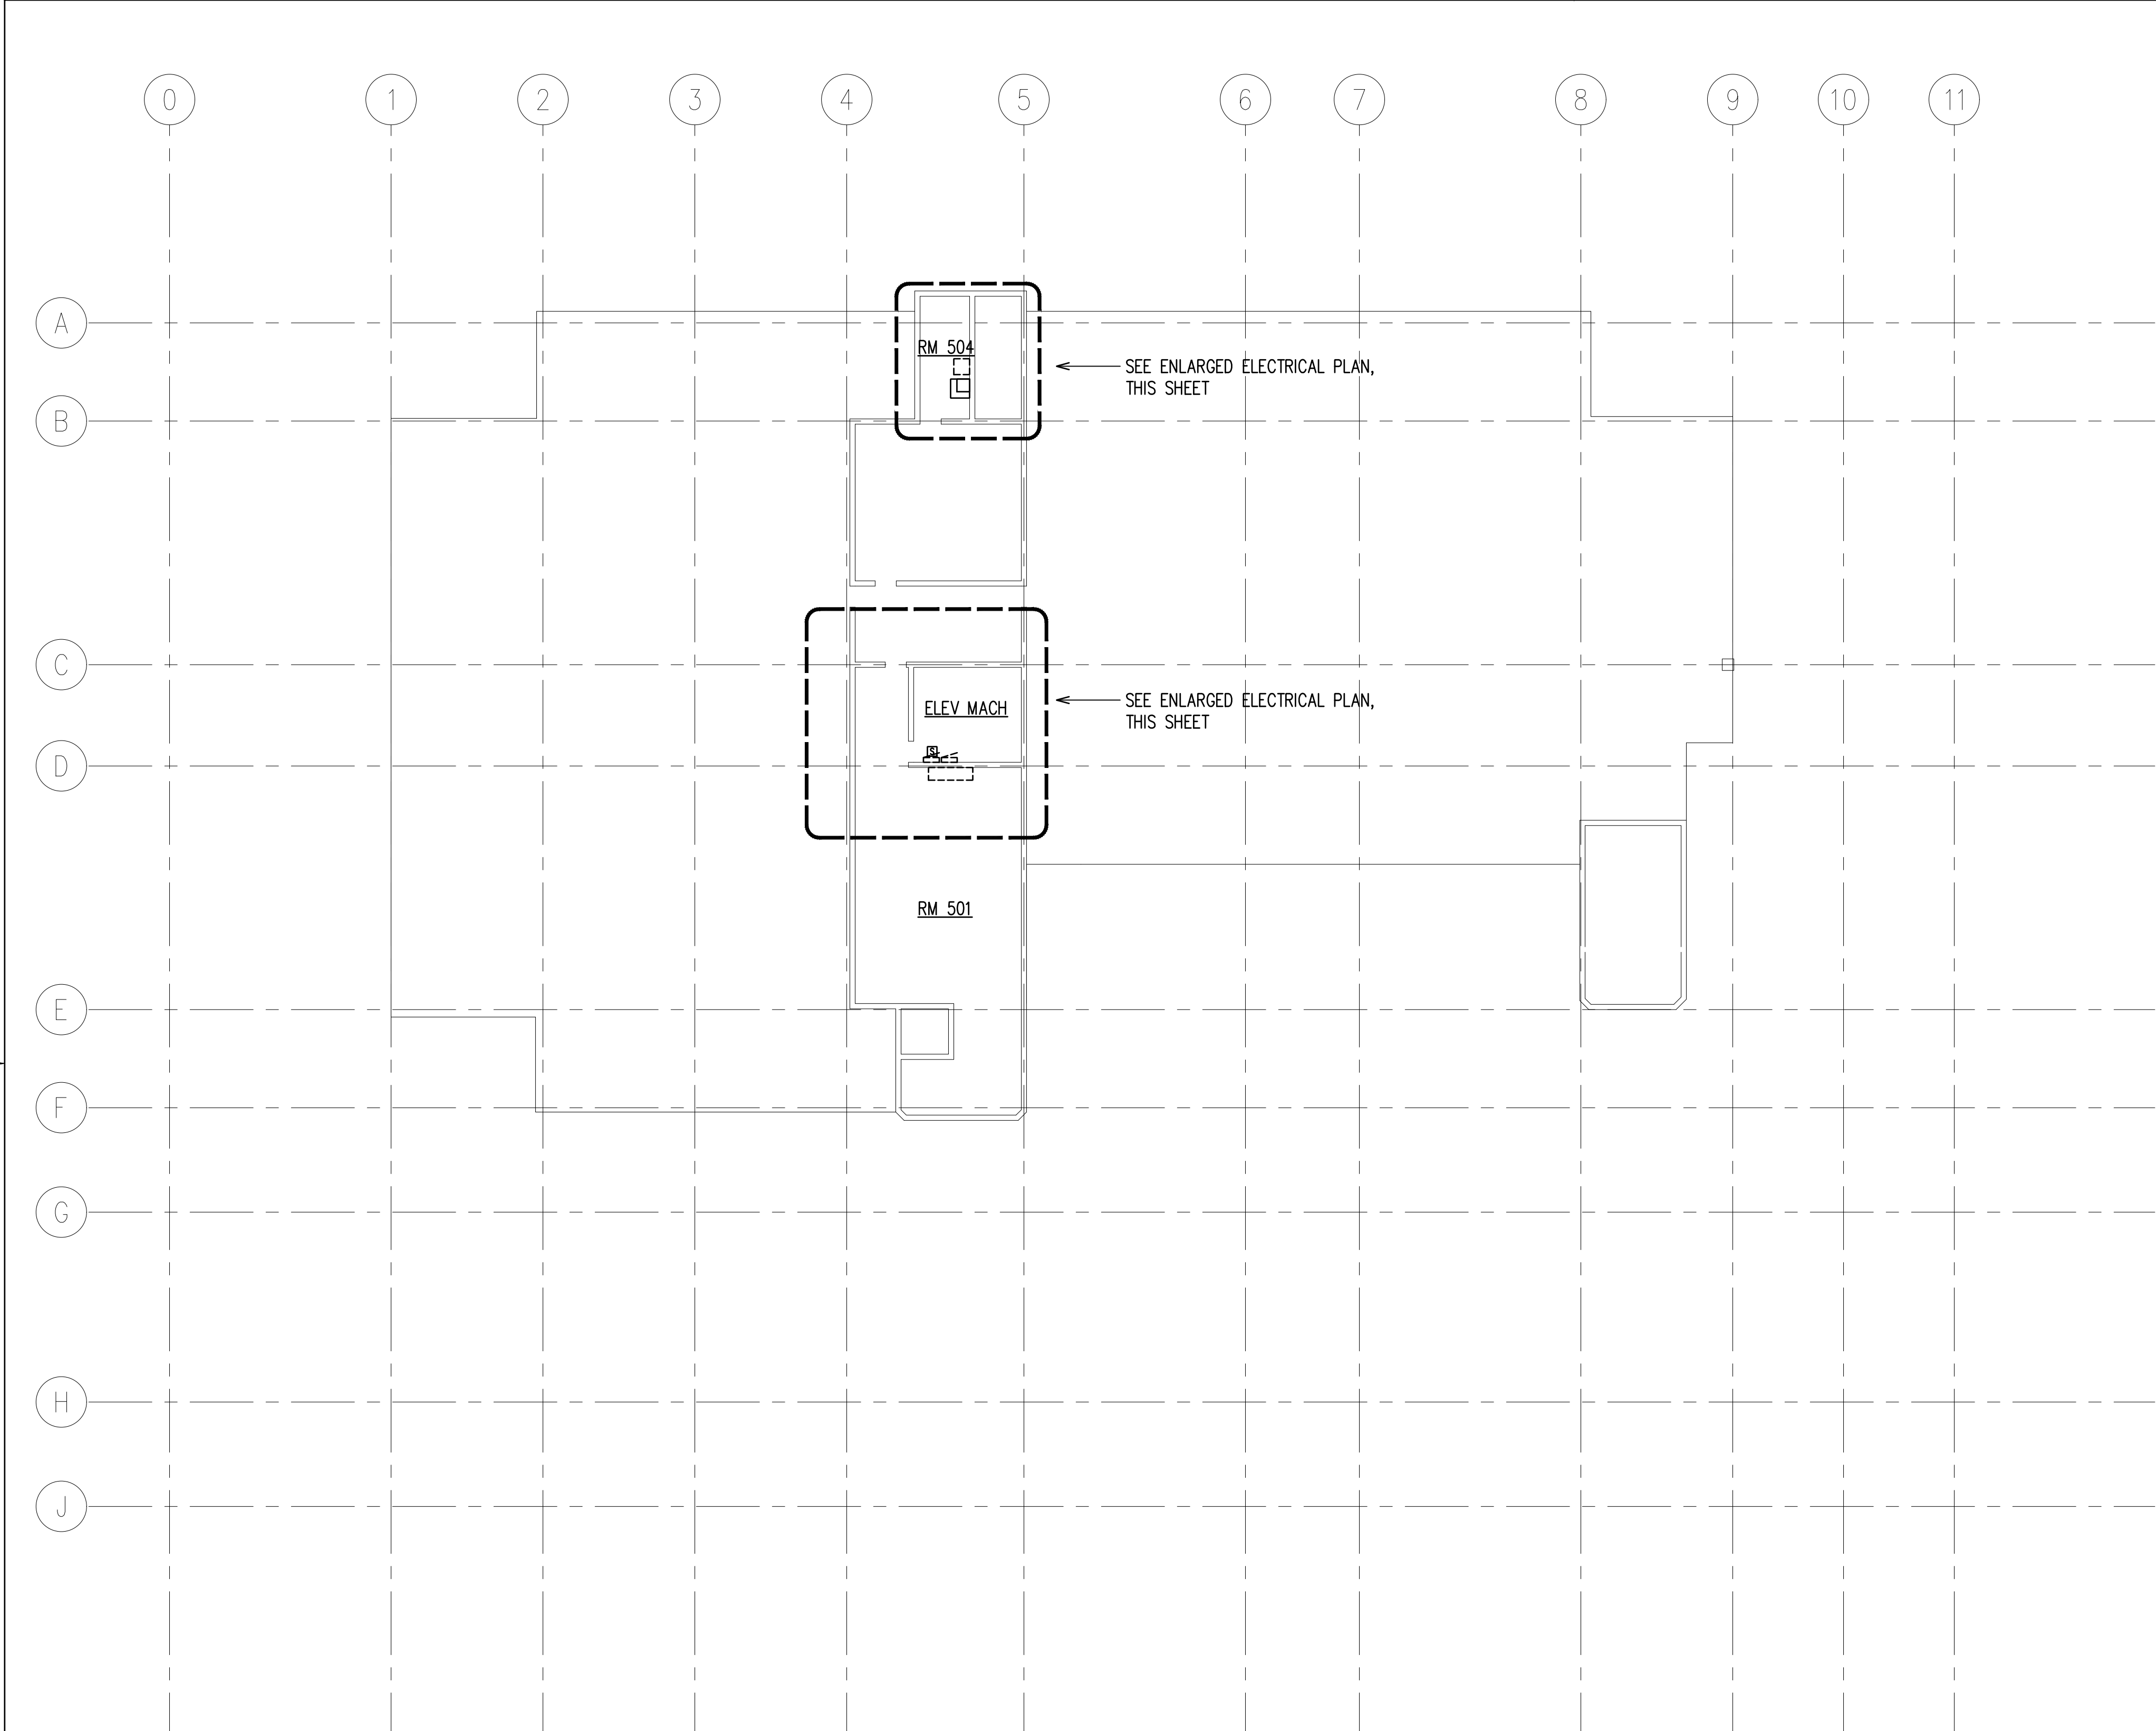



ENLARGED ELECTRICAL PLAN – RM 504
SCALE: 1/8"=1'-0"

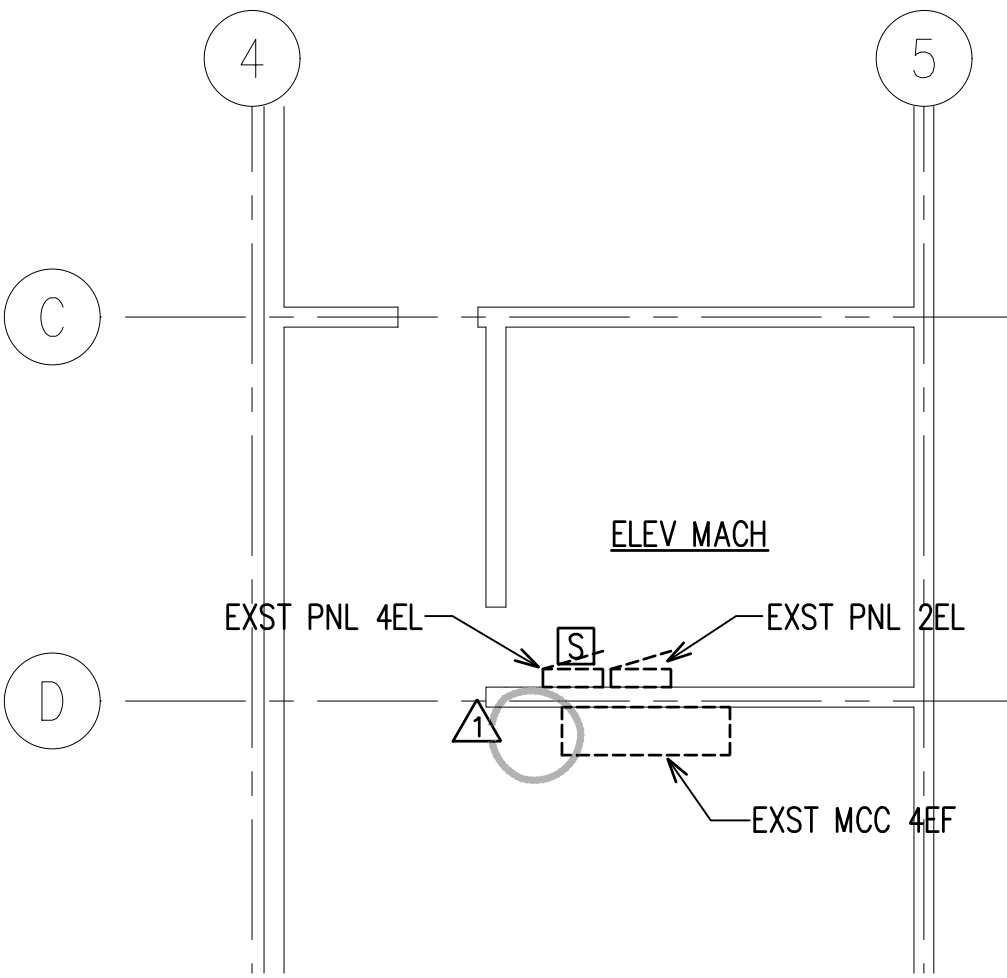


ENLARGED ELECTRICAL PLAN – ELEV MACH
SCALE: 1/8"=1'-0"

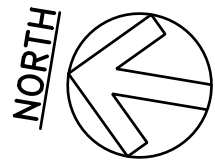

ELECTRICAL PLAN – ROOF
SCALE: 1/16"=1'-0"

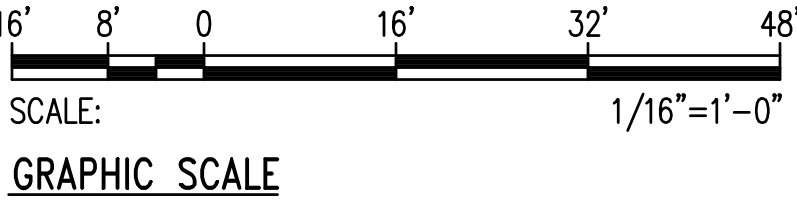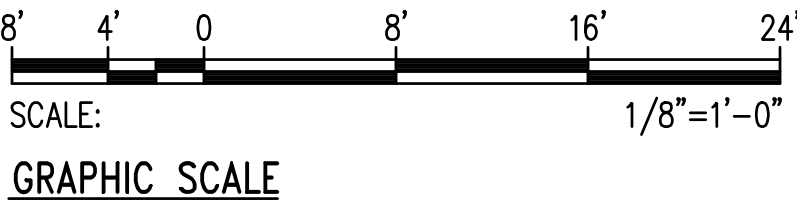

REV 1	⚠	REVISION 1		5/5/26	
REVISION NO.	SYM.	DESCRIPTION	SHT. OF	DATE	APPROVED: ADMINISTRATIVE DIRECTOR OF COURTS
			THE JUDICIARY STATE OF HAWAII'		
			HOAPI LI HALE POWER QUALITY SYSTEM IMPROVEMENTS 2145 MAIN STREET, WAILUKU, HAWAII, 96793 TAX MAP KEY: 3-4-013:013		
			WAILUKU	MAUI	HAWAII
			ELECTRICAL PLAN - ROOF		
			RONALD N.S. HO & ASSOC., INC.		JUDICIARY PROJECT NO.
DESIGNED BY: RK		CHECKED BY: RK	2526-02-076		E208
DRAWN BY: CAD		APPROVED BY: RK	DATE: FEB 2026	SHEET: 11 13	
SCALE: AS SHOWN			OF 13 SHEETS		
EXP. DATE: 4-30-28					

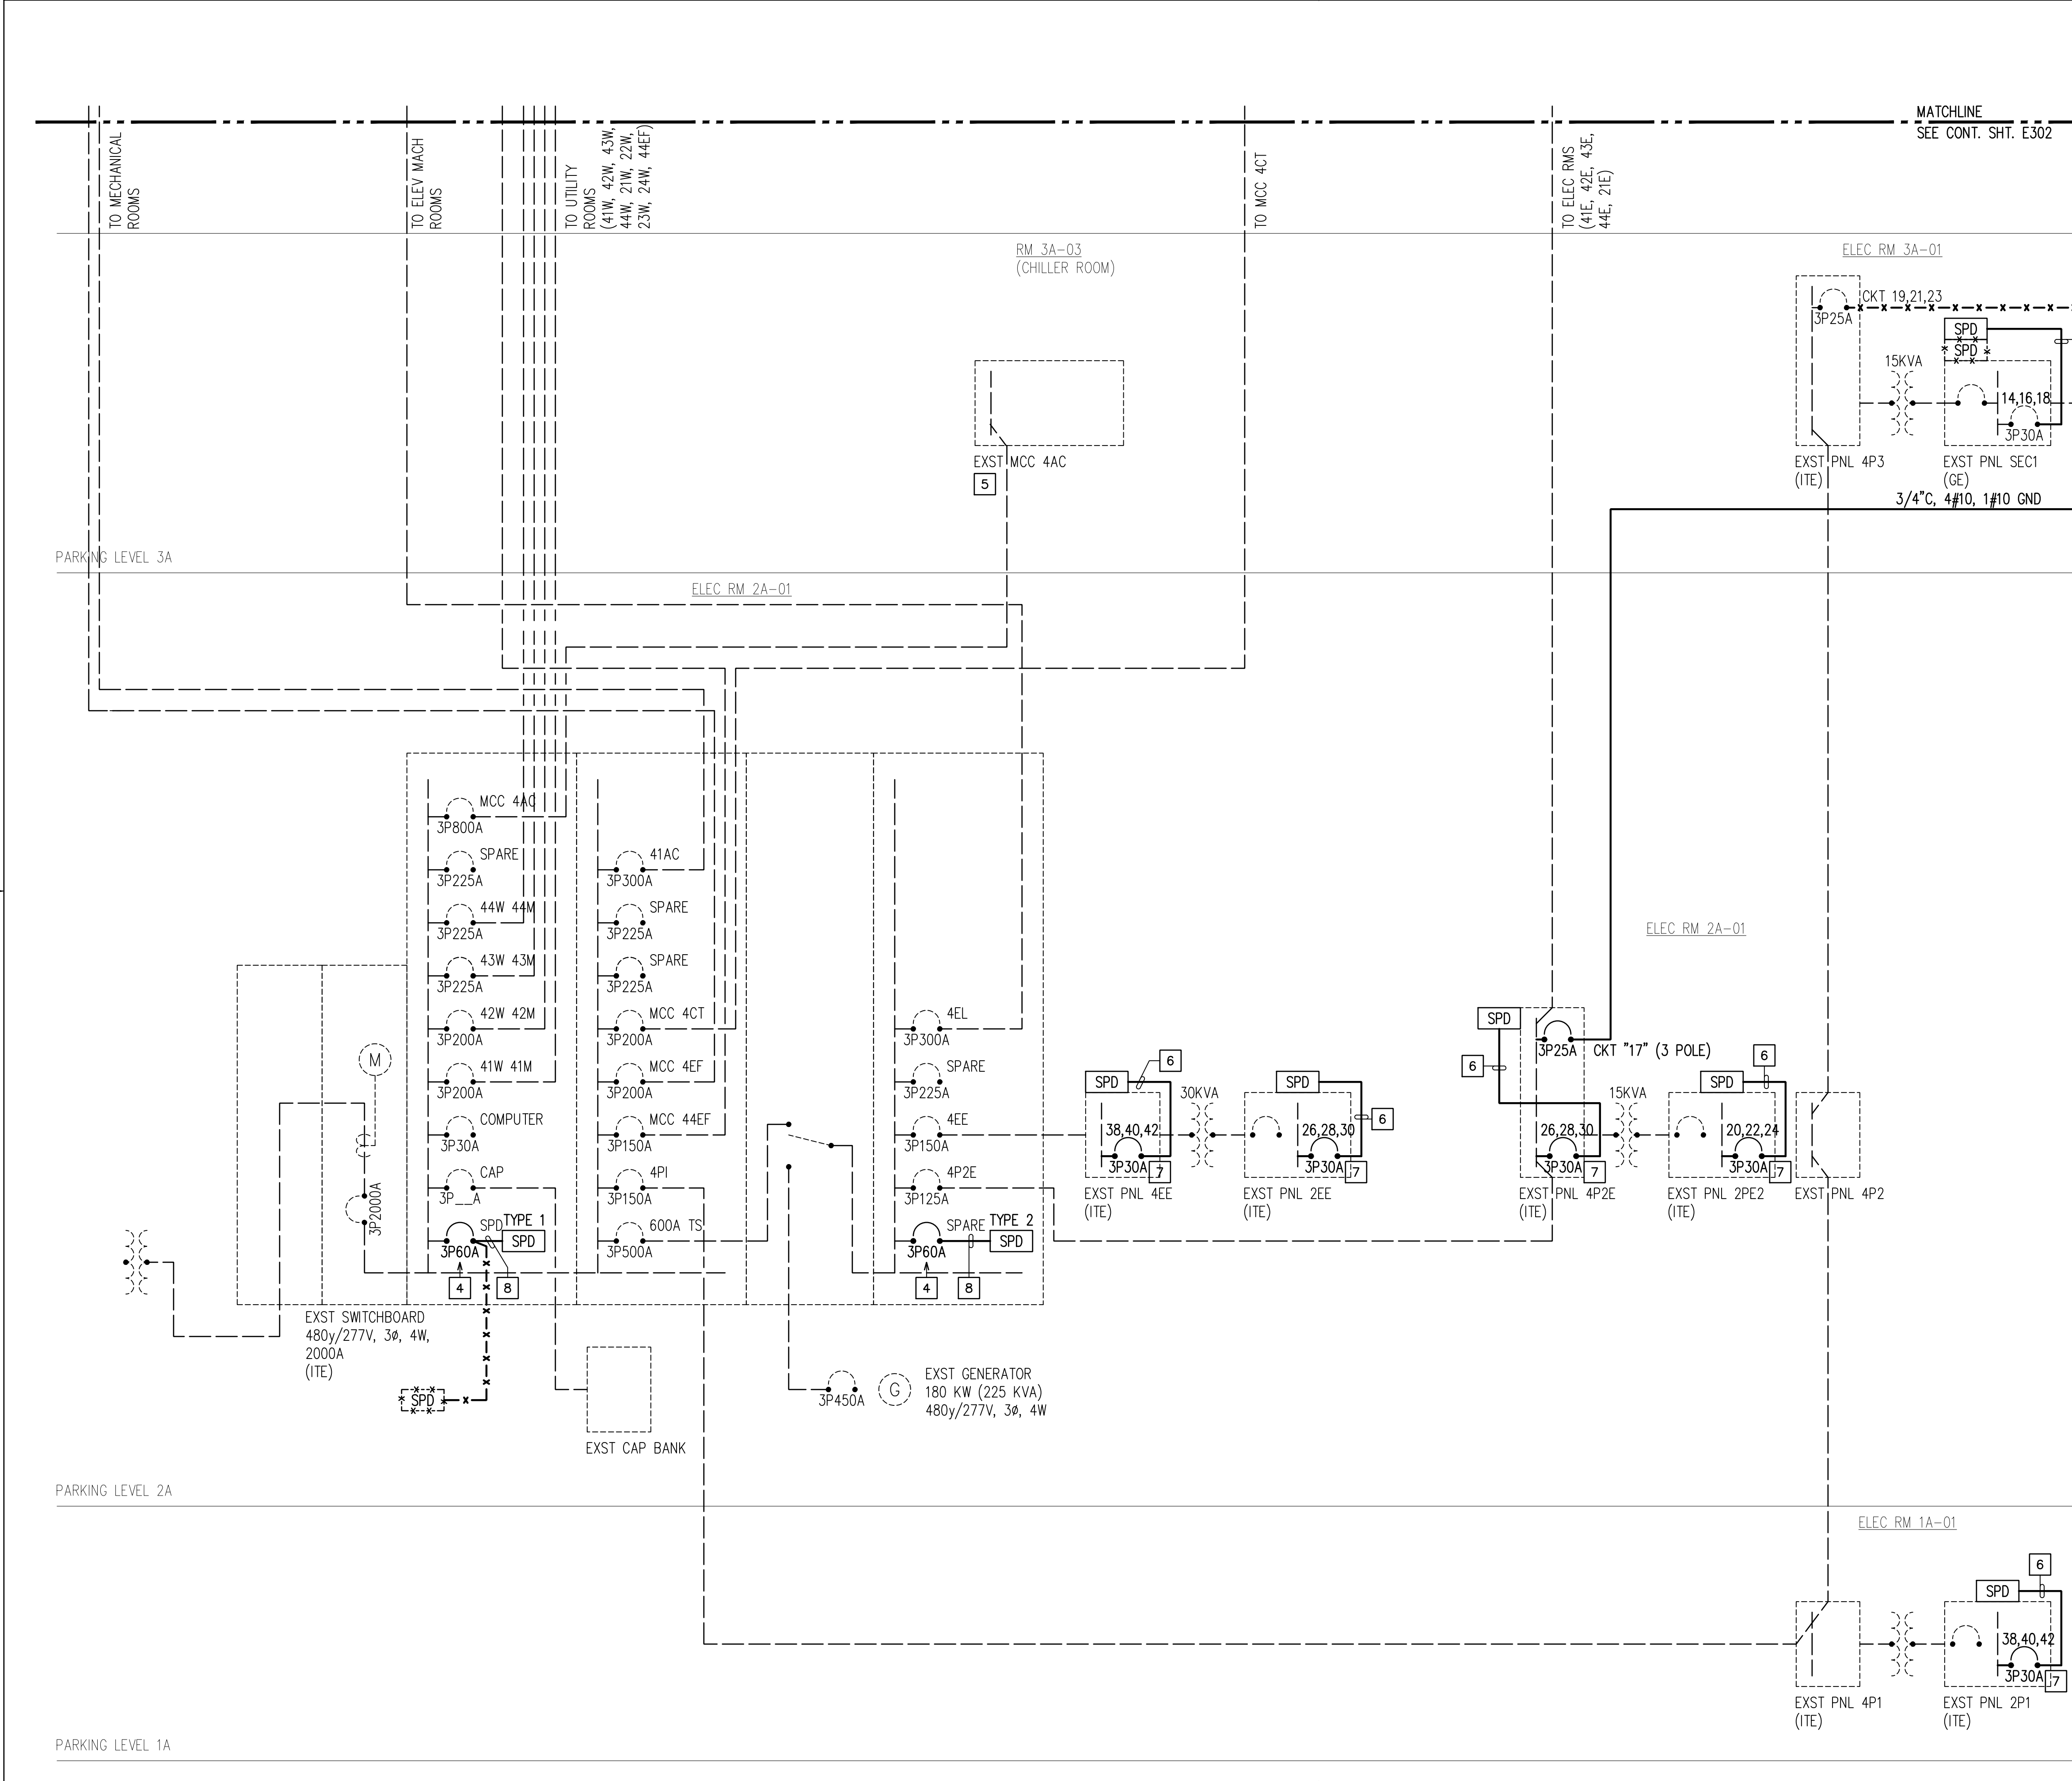


- NOTE(S):
- DASHED LINES DENOTES EXISTING; SOLID LINES DENOTE NEW.
 - NOT ALL JUNCTION BOXES SHOWN FOR CLARITY.
 - PROVIDE SURGE PROTECTION DEVICE AT ELECTRICAL EQUIPMENT. ELECTRICAL LEADS TO SURGE PROTECTION DEVICE SHALL NOT EXCEED 24" LONG.
 - PROVIDE NEW CIRCUIT BREAKER. REMOVE EXISTING SPARE CIRCUIT BREAKER.
 - NO AVAILABLE SPARE CIRCUIT BREAKERS OR PFBS.
 - 3/4"C, 4#10, 1#12 GND.
 - PROVIDE NEW CIRCUIT BREAKER IN EXISTING PFB
 - 4#6, 1#10 GND.

ONE-LINE DIAGRAM 1

NTS

REV 1	⚠	REVISION 1		5/5/26	
REVISION NO.	SYM.	DESCRIPTION	SHT. OF _____	DATE	APPROVED: _____ ADMINISTRATIVE DIRECTOR OF COURTS
			THE JUDICIARY STATE OF HAWAII		
			HOAPIILI HALE POWER QUALITY SYSTEM IMPROVEMENTS 2145 MAIN STREET, WAILUKU, HAWAII, 96793 TAX MAP KEY: 3-4-013:013		
			WAILUKU	MAUI	HAWAII
			ONE-LINE DIAGRAM 1		
			RONALD N.S. HO & ASSOC., INC.		
DESIGNED BY: RK			CHECKED BY: RK	2526-02-076	DRAWING NO. E301
DRAWN BY: CAD			APPROVED BY: RK	DATE: FEB 2026	
SCALE: AS SHOWN					
THIS WORK WAS PREPARED BY ME OR UNDER MY SUPERVISION AND CONSTRUCTION OF THIS PROJECT WILL BE UNDER MY OBSERVATION. <i>Ryan S. Karamatsu</i> Digitally signed by Ryan Karamatsu 2026.05.08 11:14:53-101007					
EXP. DATE: 4-30-28					

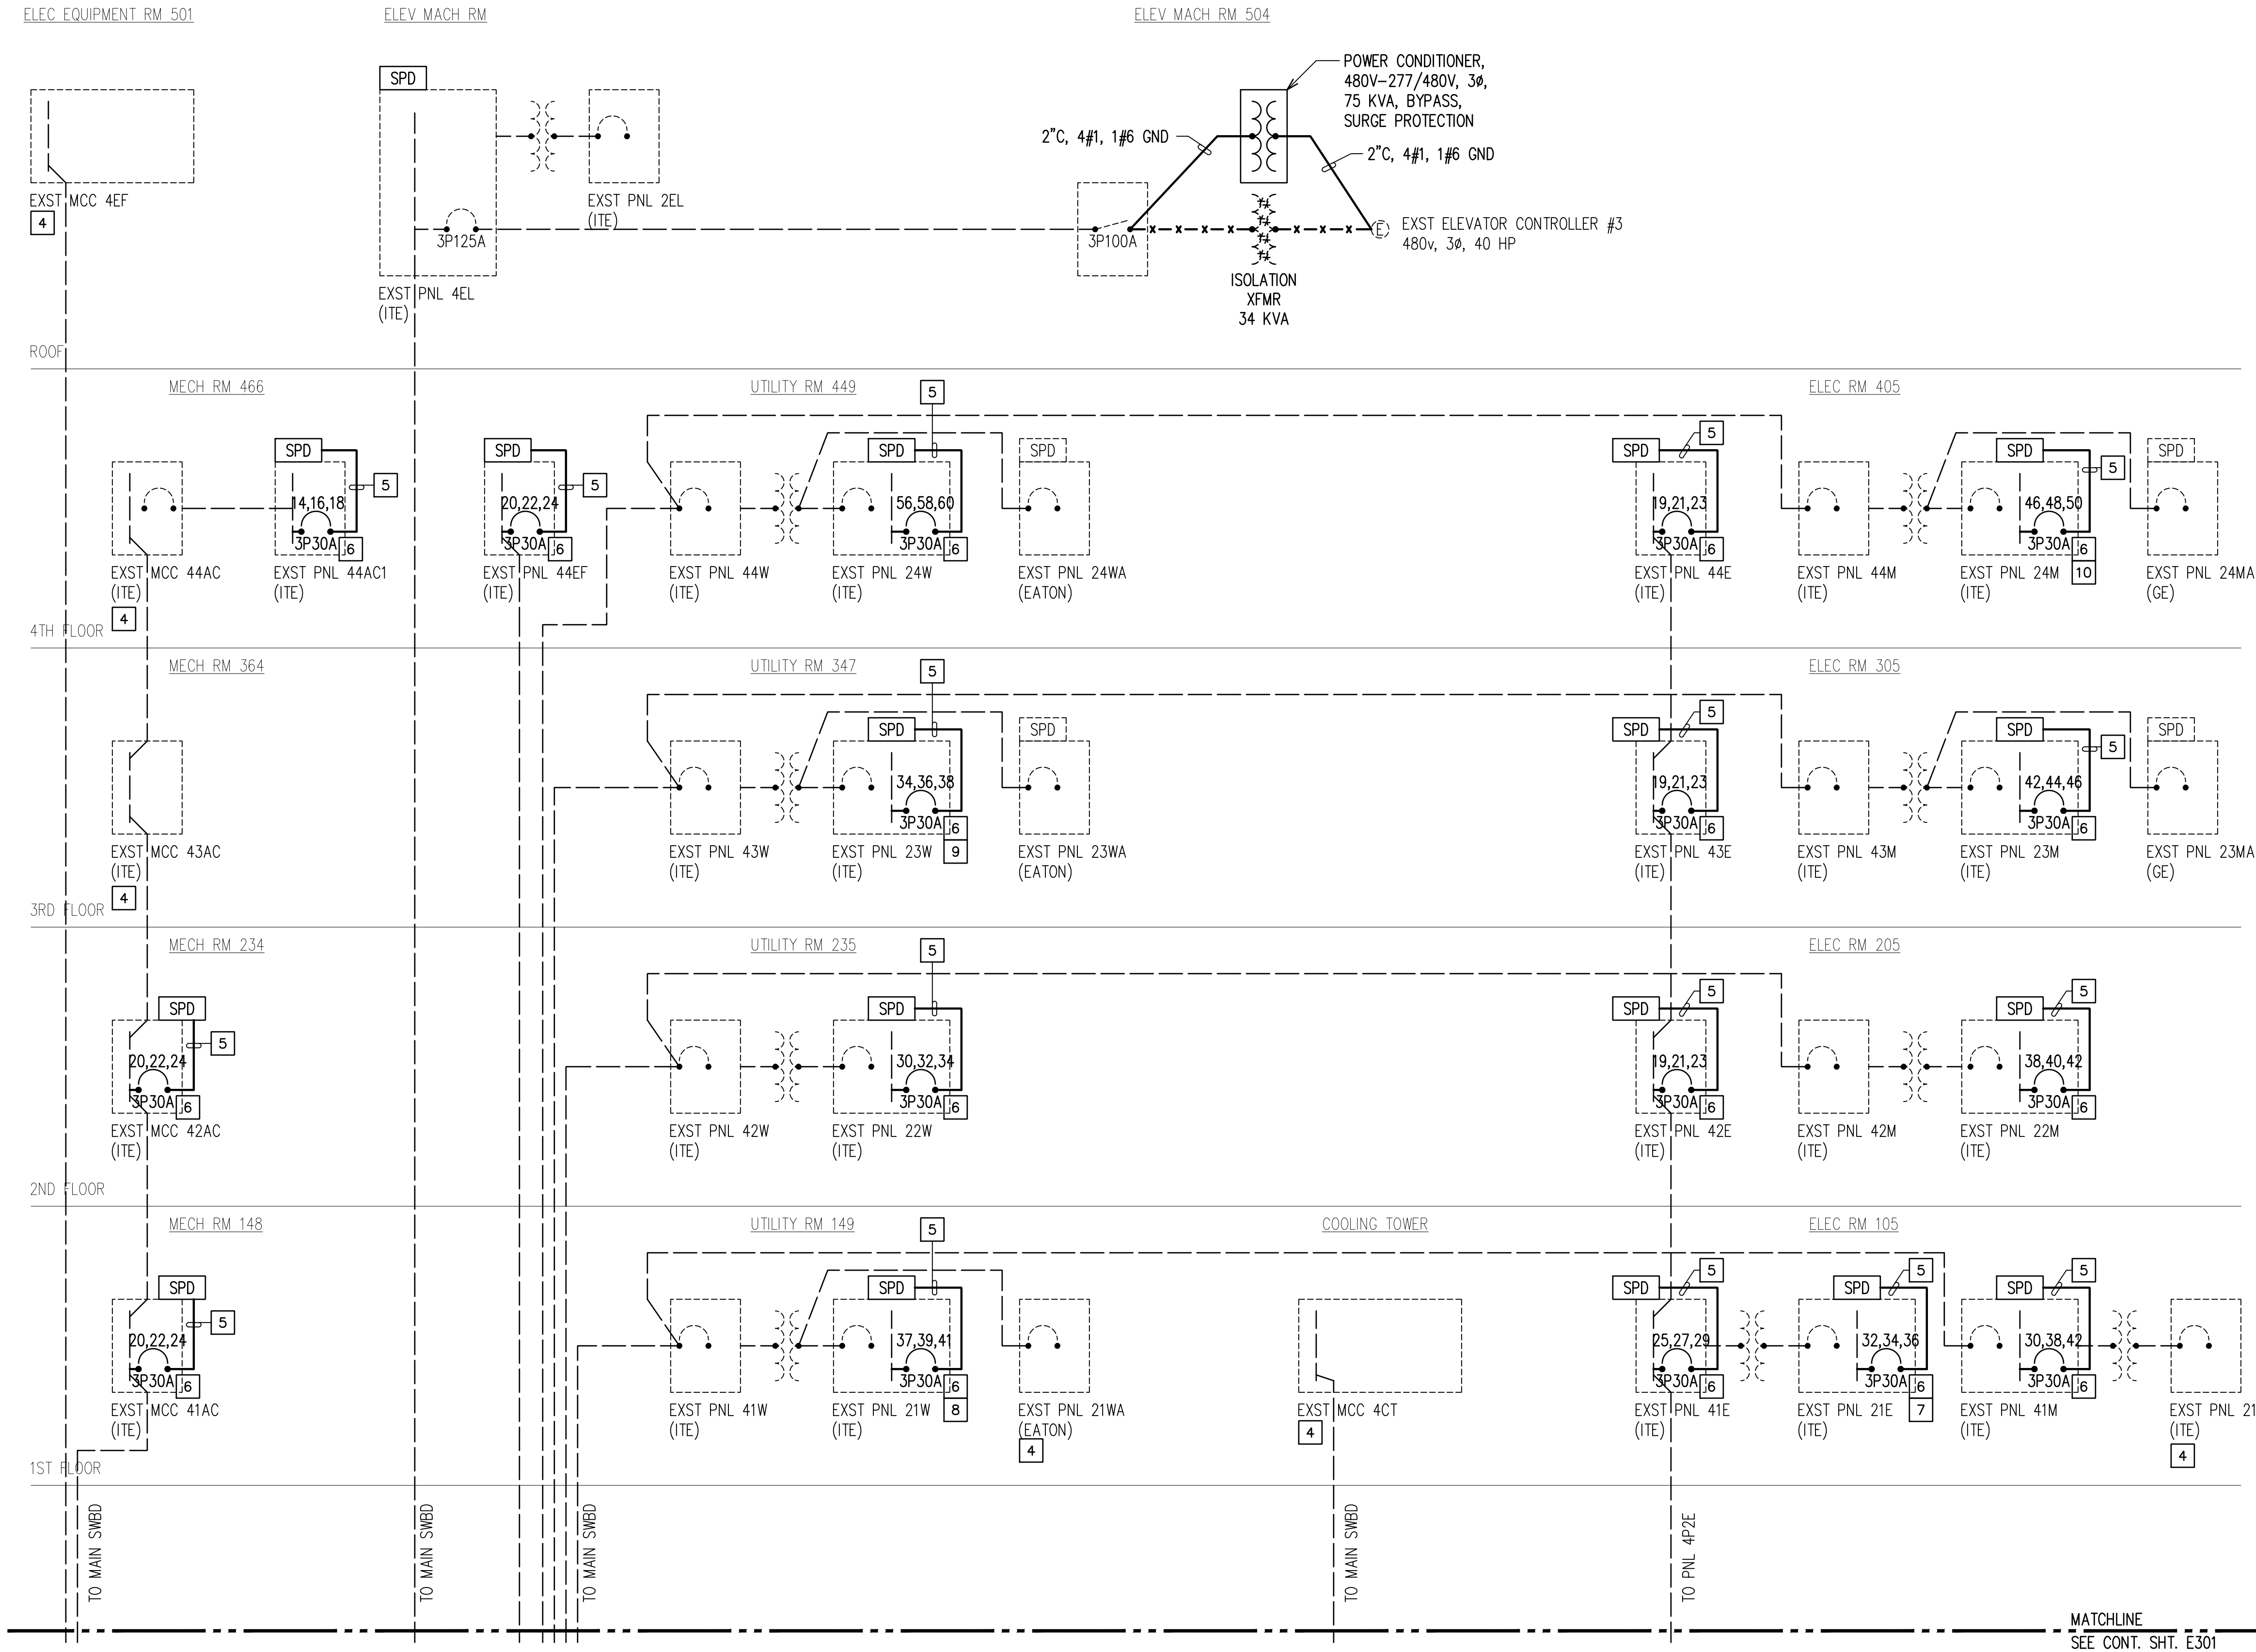

- NOTE(S):
- DASHED LINES DENOTES EXISTING; SOLID LINES DENOTE NEW.
 - NOT ALL HANDHOLES, MANHOLES, AND JUNCTION BOXES SHOWN.
 - PROVIDE SURGE PROTECTION DEVICE AT ELECTRICAL EQUIPMENT. ELECTRICAL LEADS TO SURGE PROTECTION DEVICE SHALL NOT EXCEED 24" LONG.
 - NO AVAILABLE SPARE CIRCUIT BREAKERS OR PFBs.
 - 3/4"C, 4#10, 1#12 GND.
 - PROVIDE NEW CIRCUIT BREAKER IN EXISTING PFB
 - REMOVE EXISTING 1-POLE SPARE CIRCUIT BREAKER FROM CKT 32.
 - REMOVE EXISTING 2-POLE SPARE CIRCUIT BREAKER FROM CIRCUITS 37 AND 39.
 - RELOCATE EXISTING CIRCUIT 34 (EF) TO CIRCUIT 33.
 - RELOCATE EXISTING CIRCUIT 50 TO CIRCUIT 58

ONE-LINE DIAGRAM 2

NTS

REV 1	△	REVISION 1		5/5/26				
REVISION NO.	SYM.	DESCRIPTION	SHT. OF	DATE	APPROVED: ADMINISTRATIVE DIRECTOR OF COURTS			
RYAN S. KARAMATSU LICENSED PROFESSIONAL ENGINEER No. 13987-E HAWAII, U.S.A. THE JUDICIARY STATE OF HAWAII HOAPILI HALE POWER QUALITY SYSTEM IMPROVEMENTS 2145 MAIN STREET, WAILUKU, HAWAII, 96793 TAX MAP KEY: 3-4-013:013 WAILUKU MAUI HAWAII ONE-LINE DIAGRAM 2 <td colspan="3">RONALD N.S. HO & ASSOC., INC.</td> <td>JUDICIARY PROJECT NO.</td> <td>DRAWING NO.</td>			RONALD N.S. HO & ASSOC., INC.			JUDICIARY PROJECT NO.	DRAWING NO.	
			DESIGNED BY: RK	CHECKED BY: RK	2526-02-076		E302	
			DRAWN BY: CAD	APPROVED BY: RK	DATE: FEB 2026	SHEET: 13		
			SCALE: AS SHOWN			OF 13 SHTS		
			THIS WORK WAS PREPARED BY ME OR UNDER MY SUPERVISION AND CONSTRUCTION OF THIS PROJECT WILL BE UNDER MY OBSERVATION.					
EXP. DATE: 4-30-28								