

STATE OF HAWAII
DEPARTMENT OF DEFENSE
OFFICE OF THE ADJUTANT GENERAL
3949 DIAMOND HEAD ROAD
HONOLULU, HAWAII 96816-4495

August 14, 2026

ADDENDUM NO. 1

PN15210009 & 15210012 Kalaeloa Building 1874 & Building 1898
Construction of Two Stand-by Emergency Generators, Kalaeloa, Oahu, State
of Hawai'i, Department of Defense,
Hawaii Army National Guard, Job No. CA-202004-C6

The items listed hereinafter are hereby made a part of the contract for the above-mentioned project and shall govern the work taking precedence over previously issued contract documents governing the items mentioned. Receipt of this addendum is to be acknowledged on page OF-7 of the proposer's packet.

The following documents have been modified and/or added to the bid packet of JULY 2026:

- A. KALAELOA (BUILDING 1874) CONSTRUCTION OF STAND-BY EMERGENCY GENERATOR INSTALLATIONS DRAWINGS (7 SHEETS, E001, E101, E102, E103, E104, E201, E202)
- B. KALAELOA (BUILDING 1898) CONSTRUCTION OF STAND-BY EMERGENCY GENERATOR INSTALLATIONS DRAWING(4 SHEETS, E101,E201,E203,E402,)

Below are the answers to the questions submitted prior to the due date of 08/13/2026:

1. Please clarify the 3 lump sum prices in the proposal. Is the first item the same as the second? The third, additive alternat 1 refers to a Post Contract Document 1 which is not included in the plans.

A. No, the first lump sum is the total lump sum for line items 2 and 3. Line item 2 is the sum for Bldg. 1874 and Bldg. 1898 gensets and related components as indicated in the attached drawings. Item 3 is the sum for Addendum No. 1 for Building 1874 and 1898 electrical removal work as indicated in the addendum #1.

2. On sheet E-104 Note 3 calls for de-energizing the existing transformer. Is the intent to disconnect the medium voltage splice in the manhole or turn off the secondary at the transformer.

A. The de-energizing of the existing transformers will be performed by the respective utility companies. The Contractor will arrange for the work with the utility companies.

3. Do the bypass isolation switches need to be closed transition or if they will be fine to be open transition?

A. The bypass isolation switches will need to be closed transition.

Stephen F. Logan
Major General
Adjutant General


Posted: August 14, 2026

END OF ADDENDUM NO. 1

D

- C

BK BOWERS + KUBOTA CONSULTING
Management • Planning • Architectural/Engineering Design • Construction Management

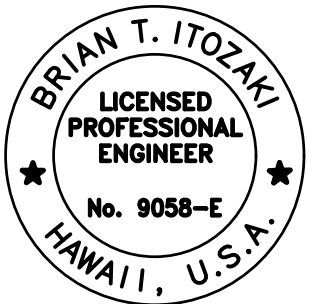

Signature: Bruce Z... 04/30/2028
Expiration Date of the License

THIS WORK WAS PREPARED BY ME OR UNDER
MY SUPERVISION AND CONSTRUCTION OF
THIS PROJECT WILL BE UNDER MY
OBSERVATION.

[illegible]

MITTAL PHASE

MITTAL DATE 3/12/2026

S	SM	DRW	AG	CHK	BI
---	----	-----	----	-----	----

	CO	
--	----	--

FACILITY MANAGEMENT OFFICE HAWAII ARMY NATIONAL GUARD	DESIGN AND PROJECT MANAGEMENT BRANCH
KALAELOA BLDG. 01874 KAPOLEI, OAHU KALAELOA (BUILDING 1874) CONSTRUCTION OF STAND-BY EMERGENCY GENERATOR INSTALLATIONS	
SYMBOL LIST, GENERAL NOTES	

SCALE: AS NOTED

DATE JOB NO.

LAELOA (BLDG 1874) CA-202004-C

FEDERAL PROJECT NO.


PAGE 9 OF 18

E001




1

A

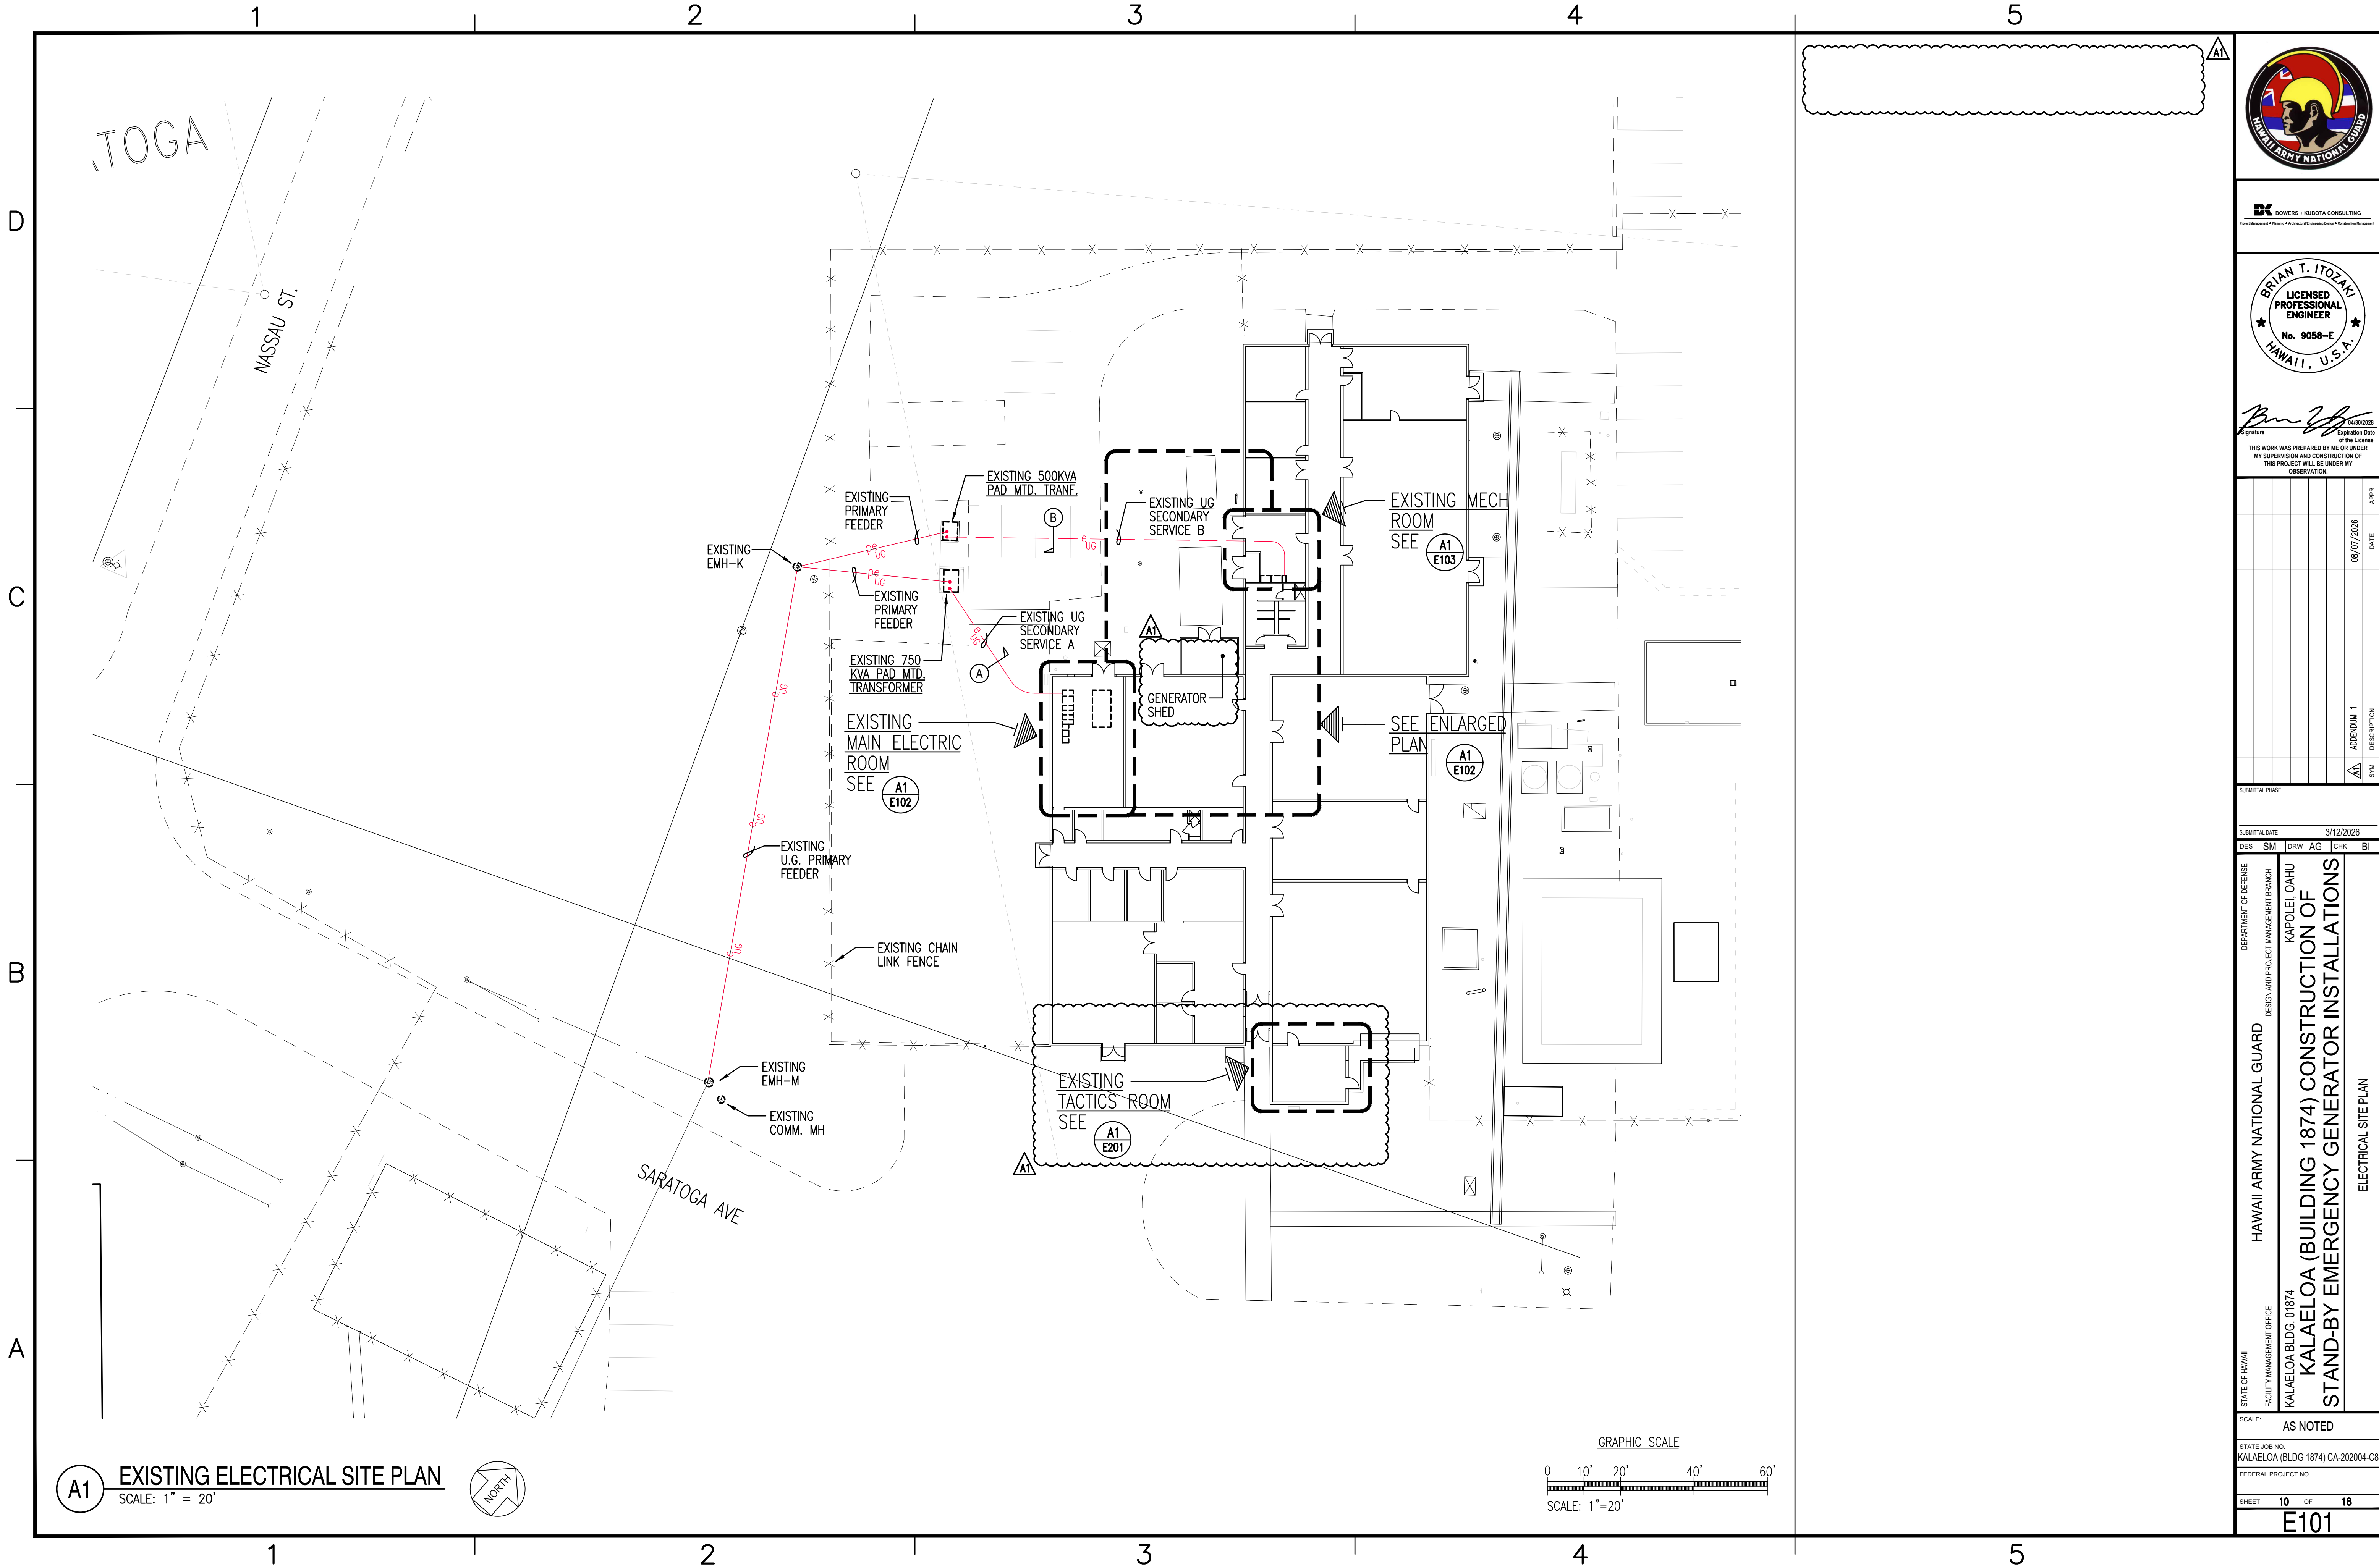

BOWERS + KUBOTA CONSULTING
Project Management • Planning • Architectural/Engineering Design • Construction Management

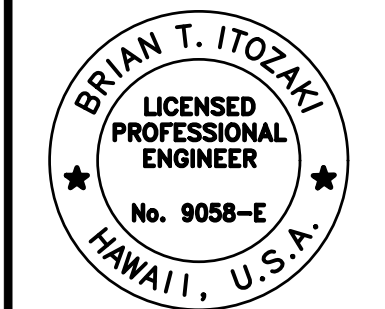

Brian T. Itozaki
Signature
04/30/2023
Expiration Date
THIS WORK WAS PREPARED BY ME OR UNDER MY SUPERVISION AND CONSTRUCTION OF THIS PROJECT WILL BE UNDER MY OBSERVATION.

DATE	DESCRIPTION	SYN	APP
08/07/2026	ADDENDUM 1		

DES	SM	DRW	AG	CHK	BI

DEPARTMENT OF DEFENSE
HAWAII ARMY NATIONAL GUARD
DESIGN AND PROJECT MANAGEMENT BRANCH
KAPOLEI, OAHU
STATE OF HAWAII
FACILITY MANAGEMENT OFFICE
KALAELOA BLDG. 01874
KALAELOA (BLDG 1874) CONSTRUCTION OF
STAND-BY EMERGENCY GENERATOR INSTALLATIONS
ELECTRICAL SITE PLAN




SCALE: AS NOTED

STATE JOB NO. KALAELOA (BLDG 1874) CA-202004-C8


FEDERAL PROJECT NO.

SHEET 10 OF 18

E101

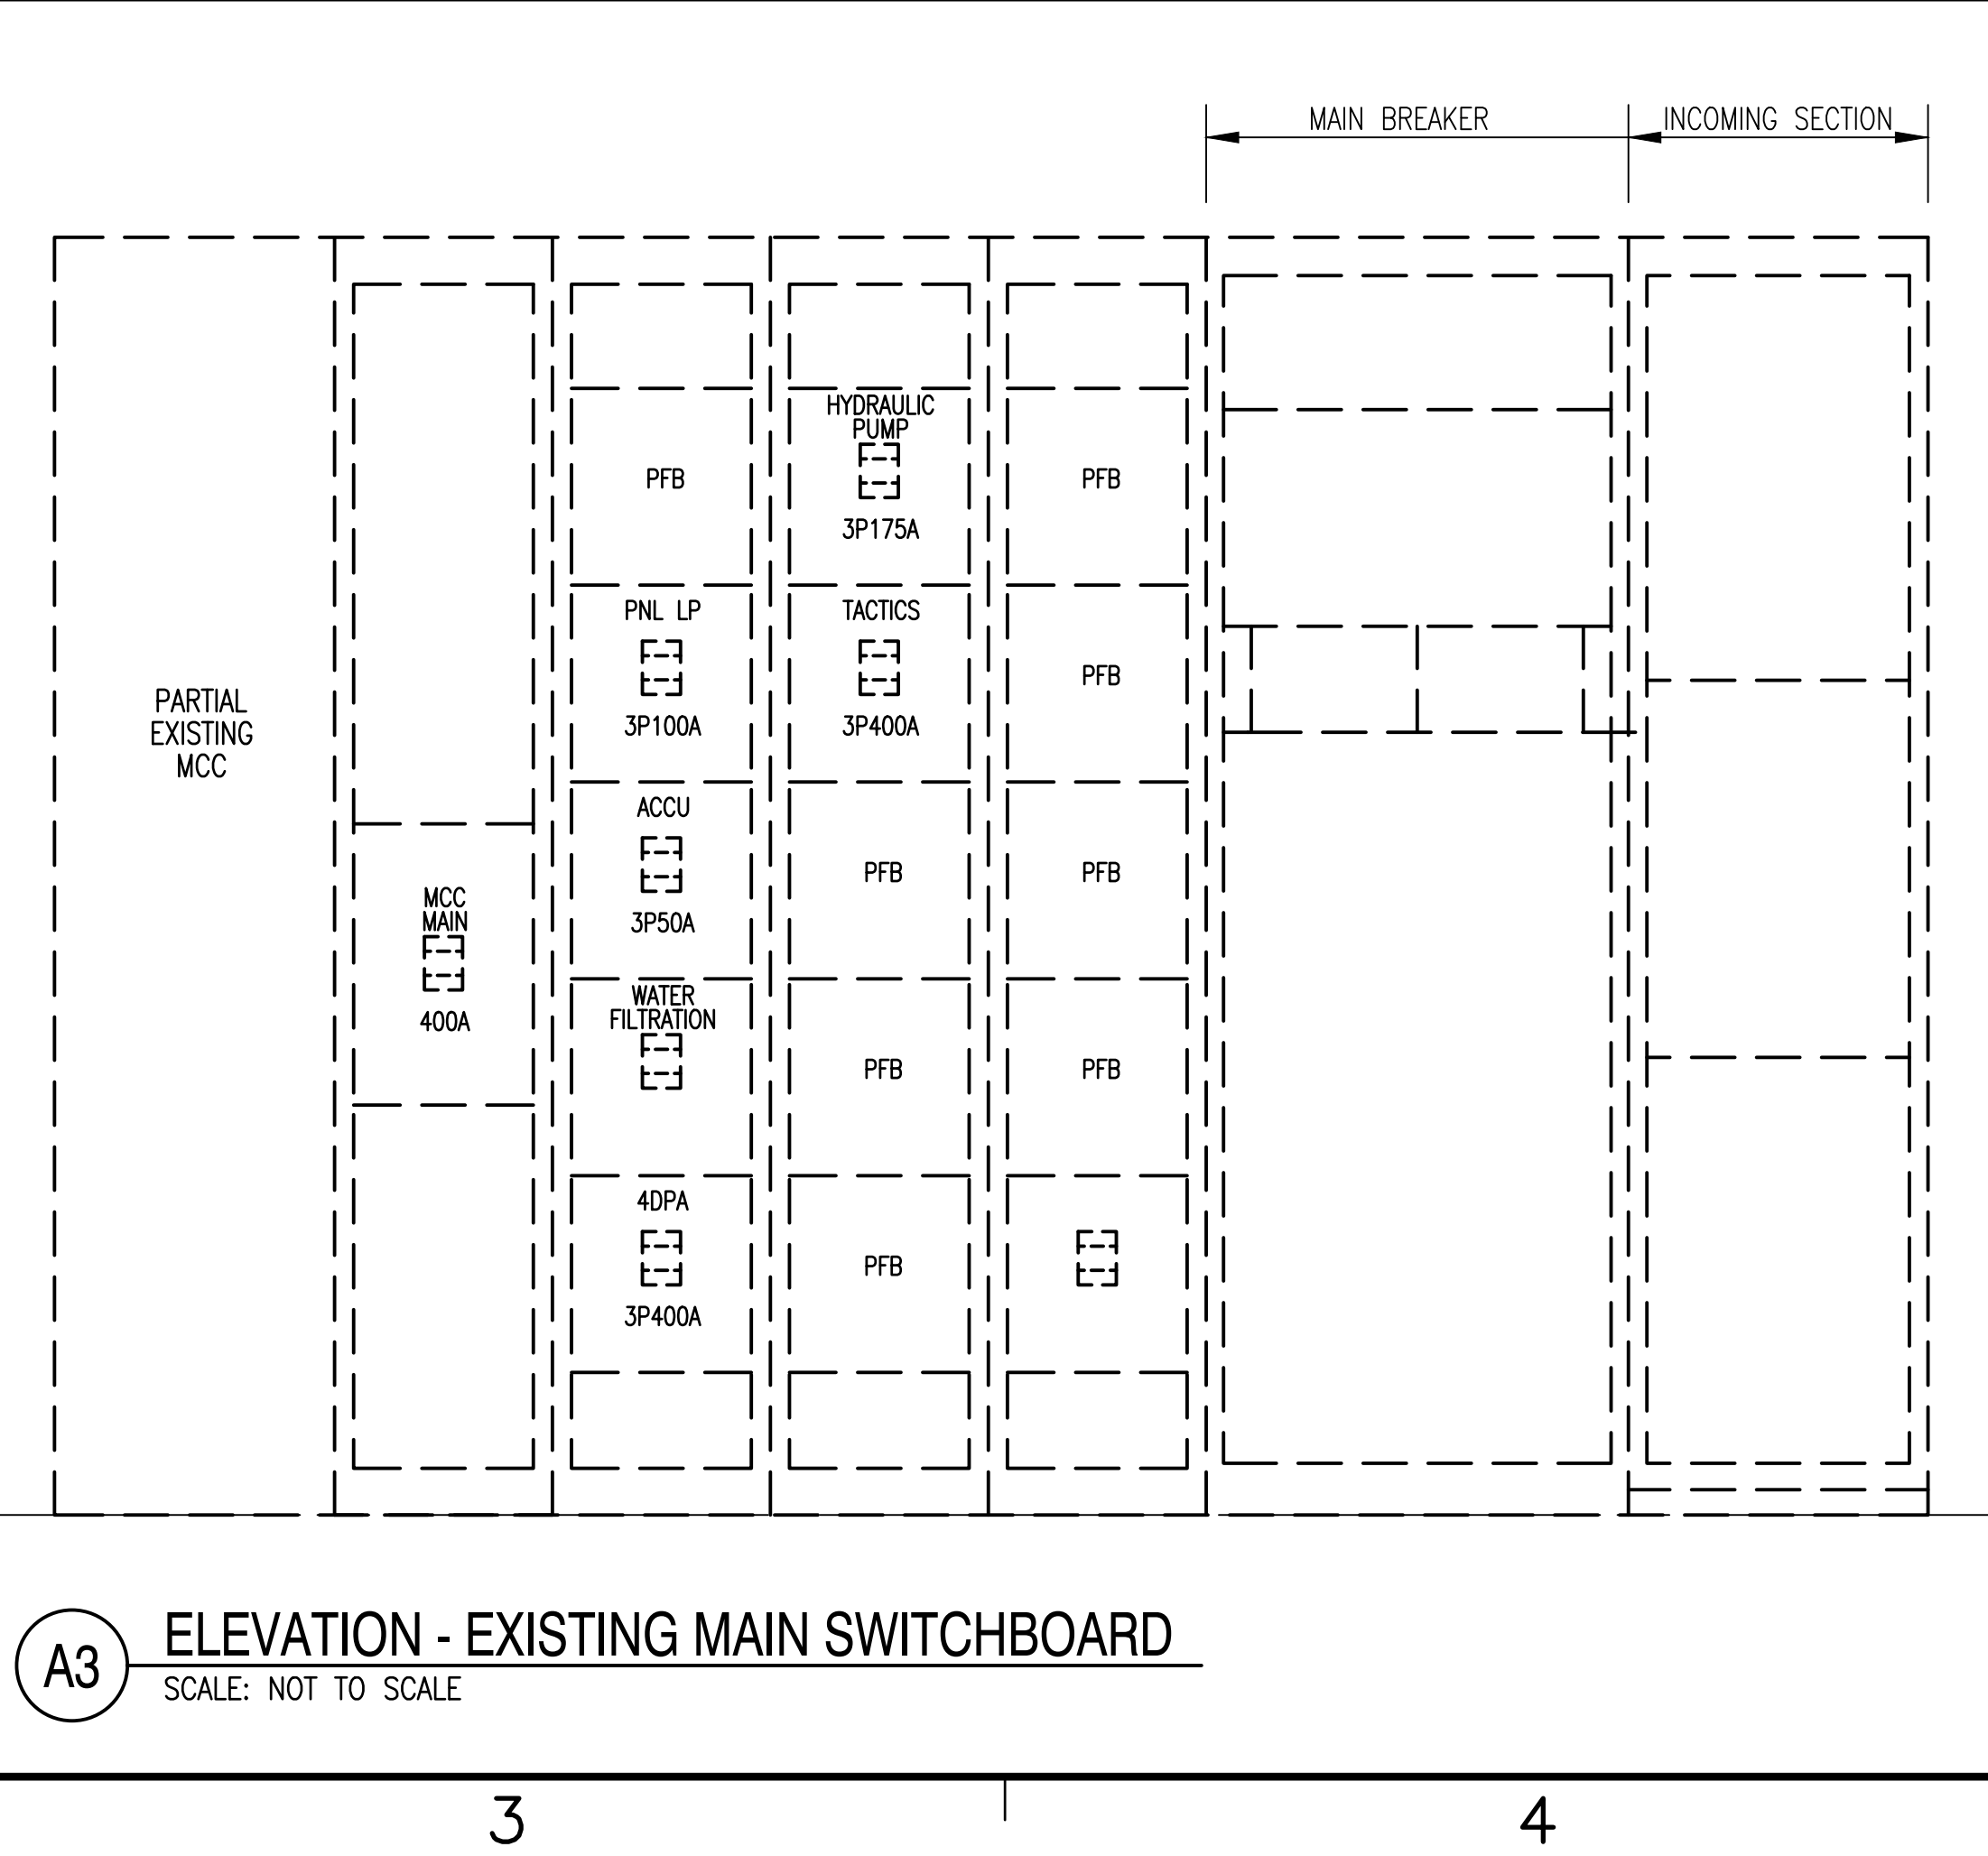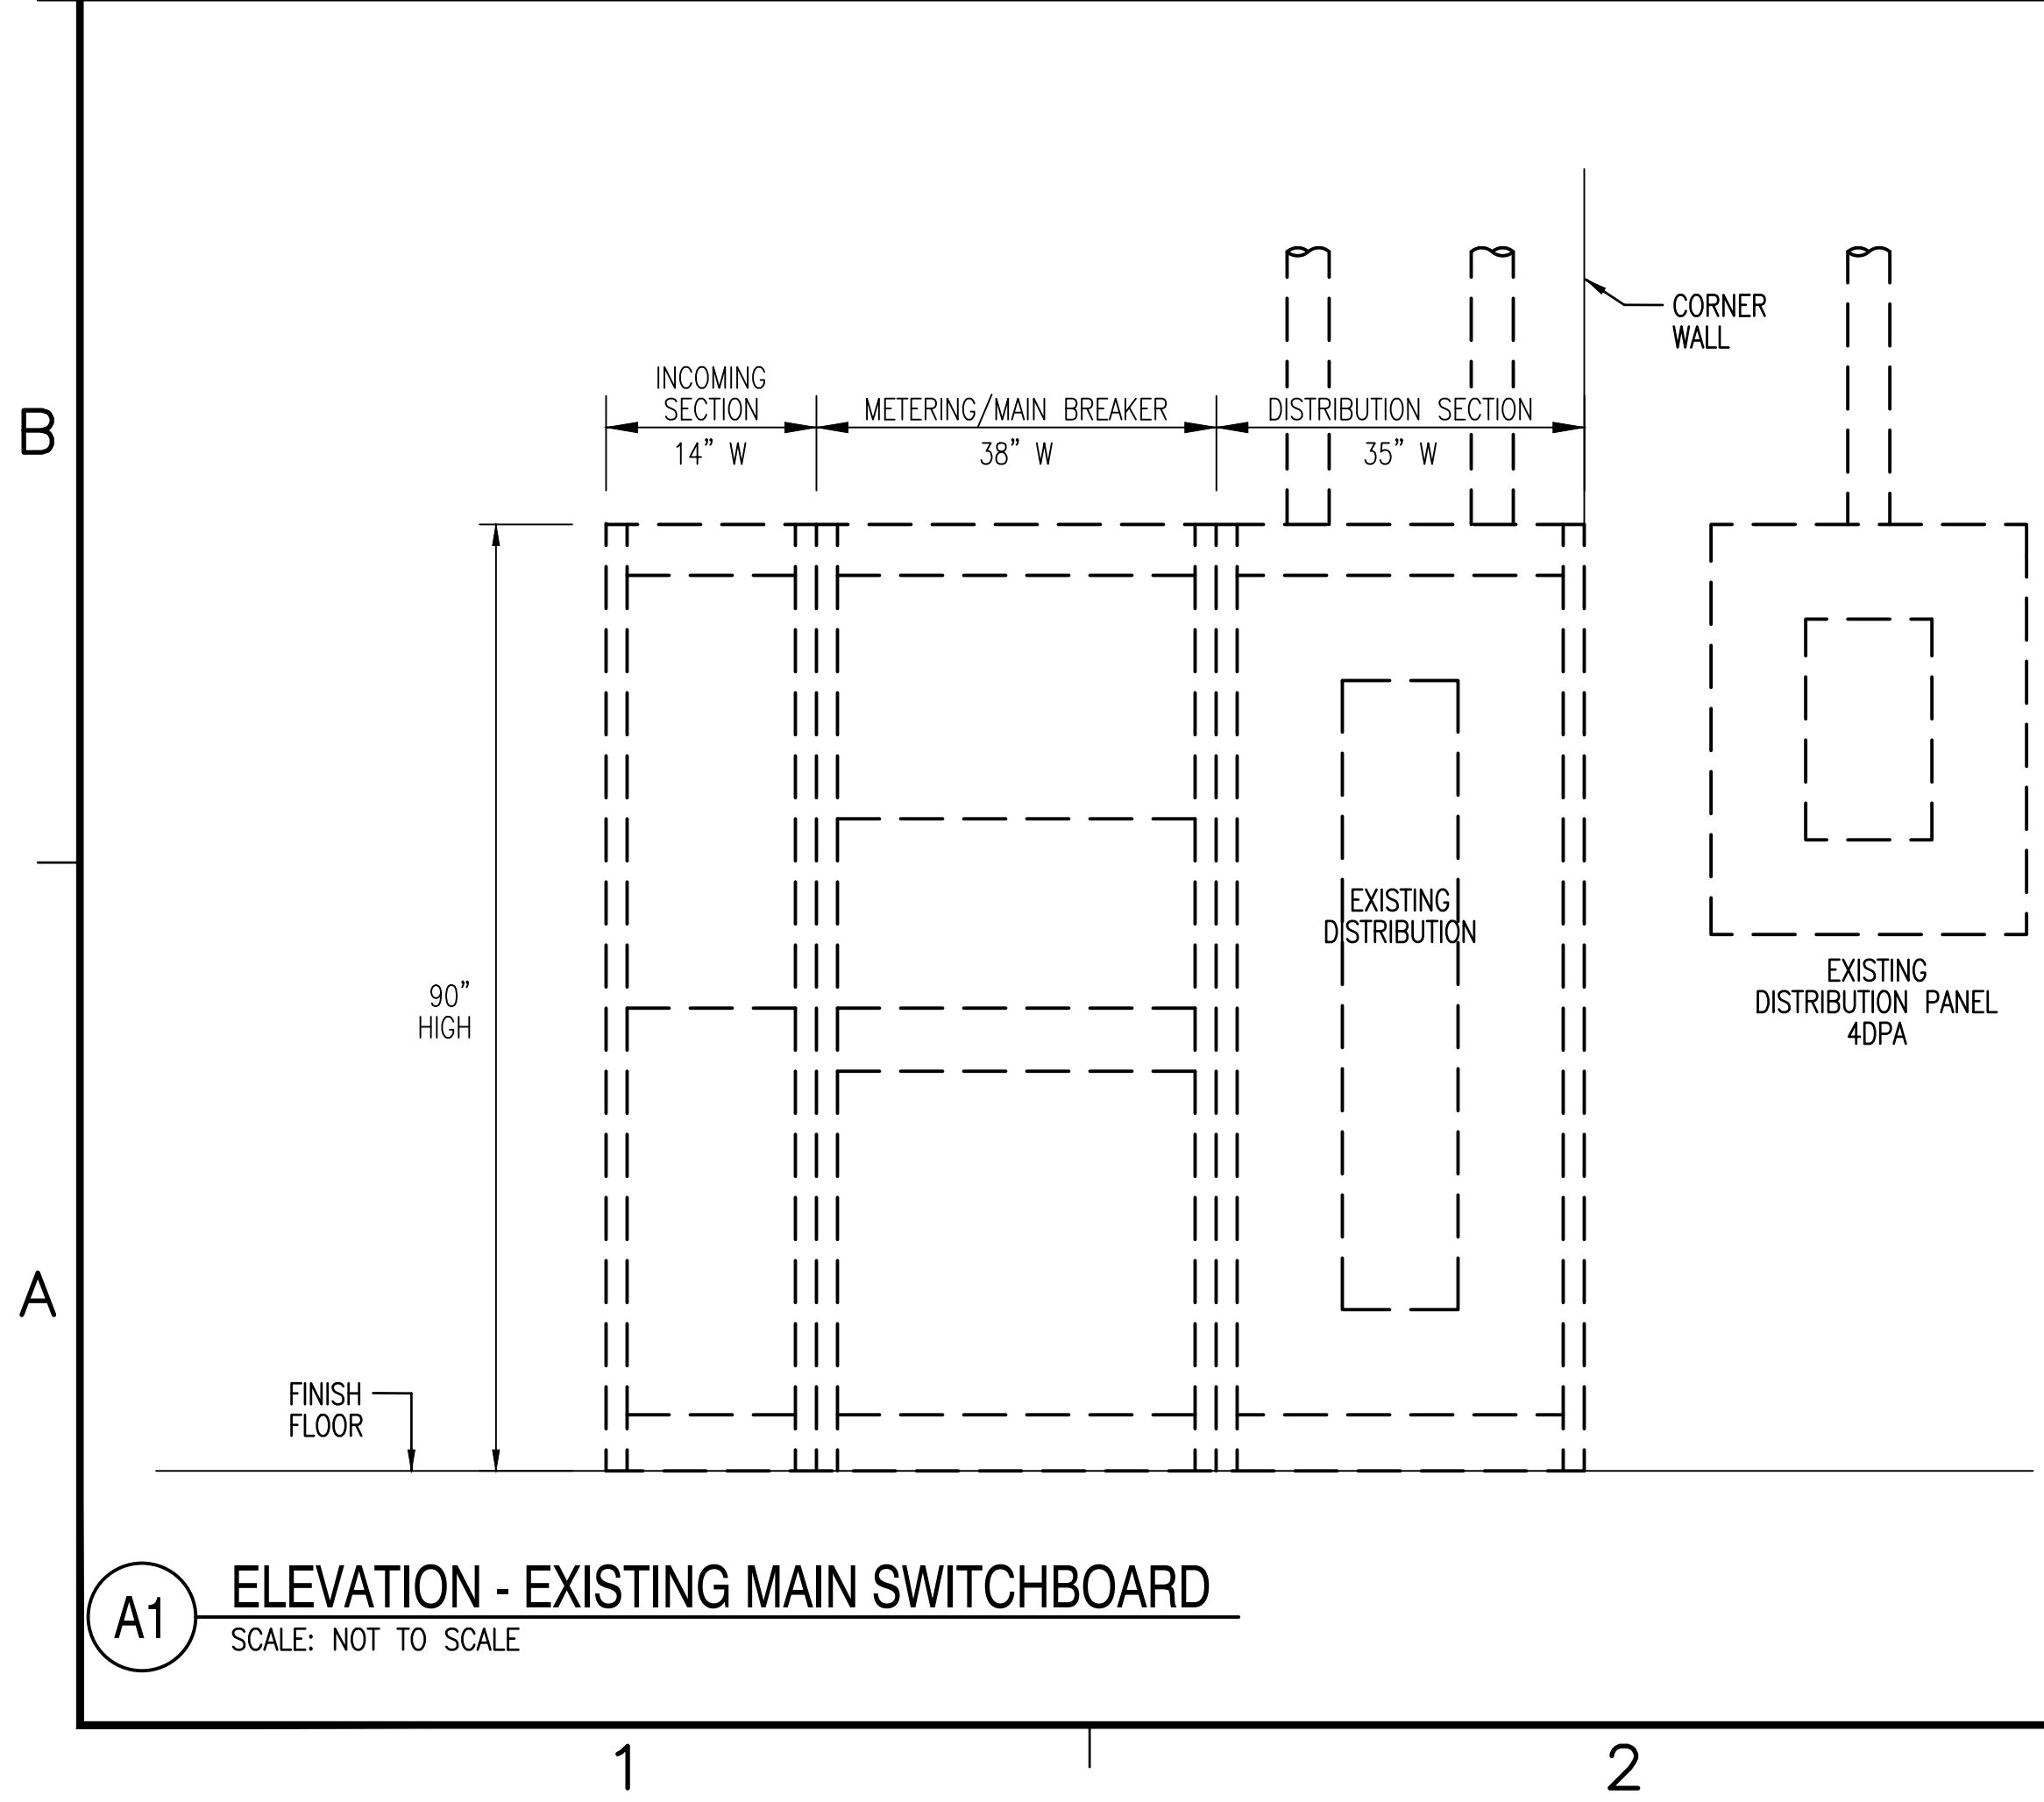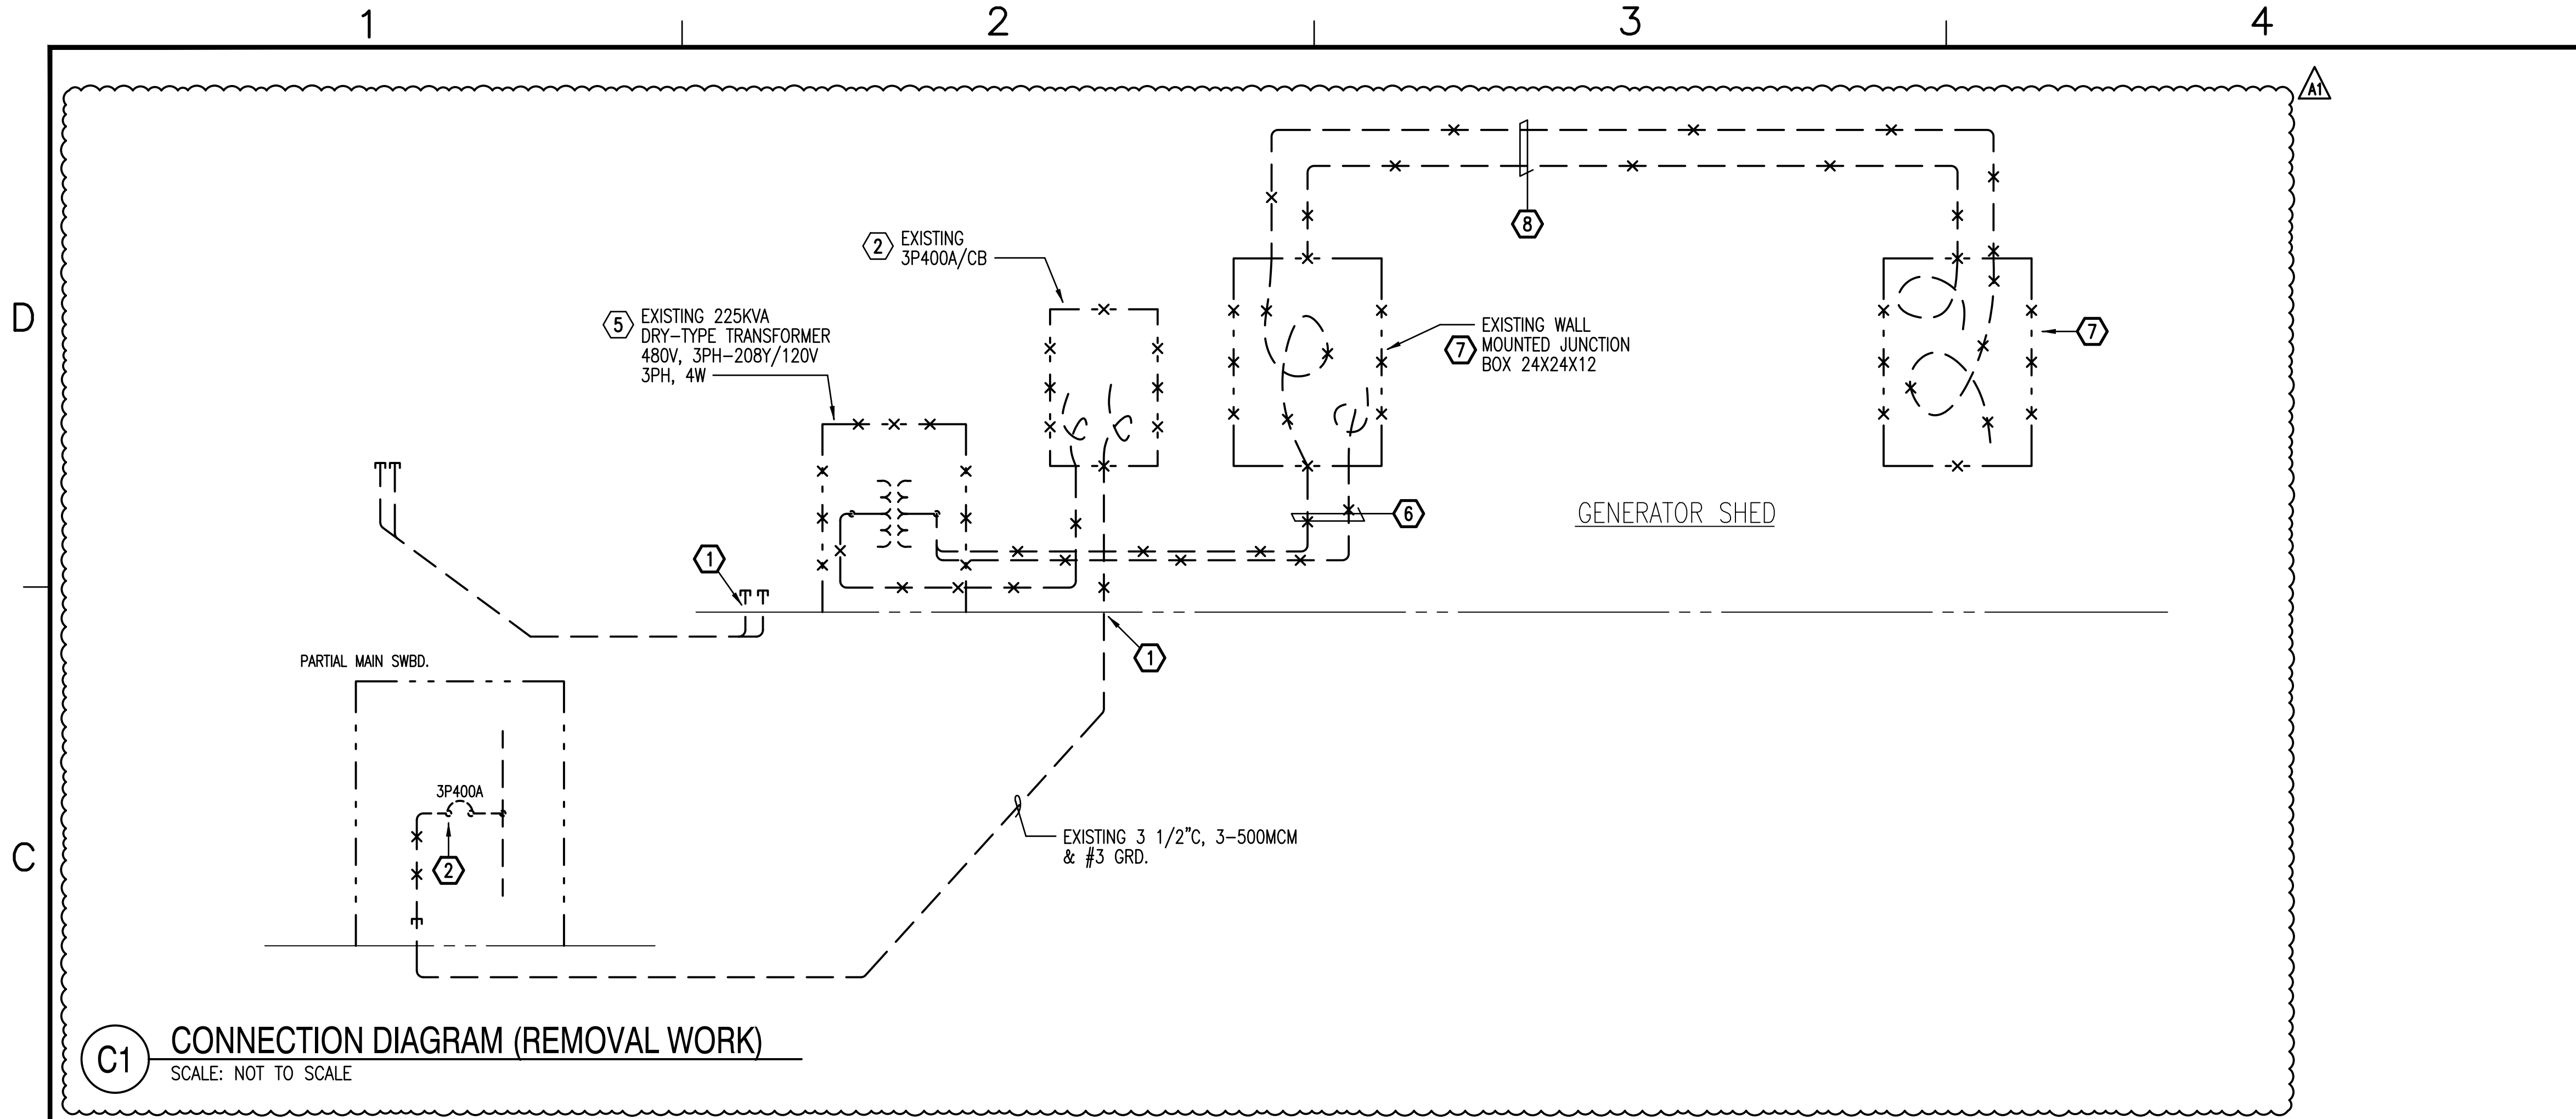

BOWERS + KUBOTA CONSULTING
Project Management • Planning • Architectural/Engineering Design • Construction Management

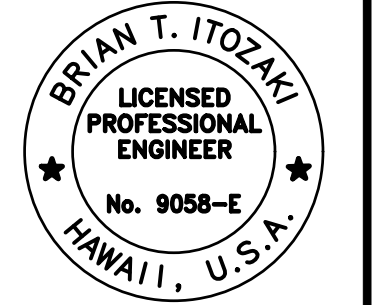

Signature: *Brian T. Itozaki*
Expiration Date: 04/30/2023
THIS WORK WAS PREPARED BY ME OR UNDER MY SUPERVISION AND CONSTRUCTION OF THIS PROJECT WILL BE UNDER MY OBSERVATION.

ADDENDUM	DESCRIPTION	DATE	APPROVED
1		08/07/2026	

DES	SM	DRW	AG	CHK	BI

DEPARTMENT OF DEFENSE
HAWAII ARMY NATIONAL GUARD
DESIGN AND PROJECT MANAGEMENT BRANCH
KAPOLEI, OAHU
KALAELOA BLDG. 01874
KALAELOA (BUILDING 1874) CONSTRUCTION OF STAND-BY EMERGENCY GENERATOR INSTALLATIONS
SWITCHBOARD ELEVATIONS


SCALE: AS NOTED

STATE JOB NO. KALAELOA (BLDG 1874) CA-202004-C8

FEDERAL PROJECT NO.

SHEET 12 OF 18

E103

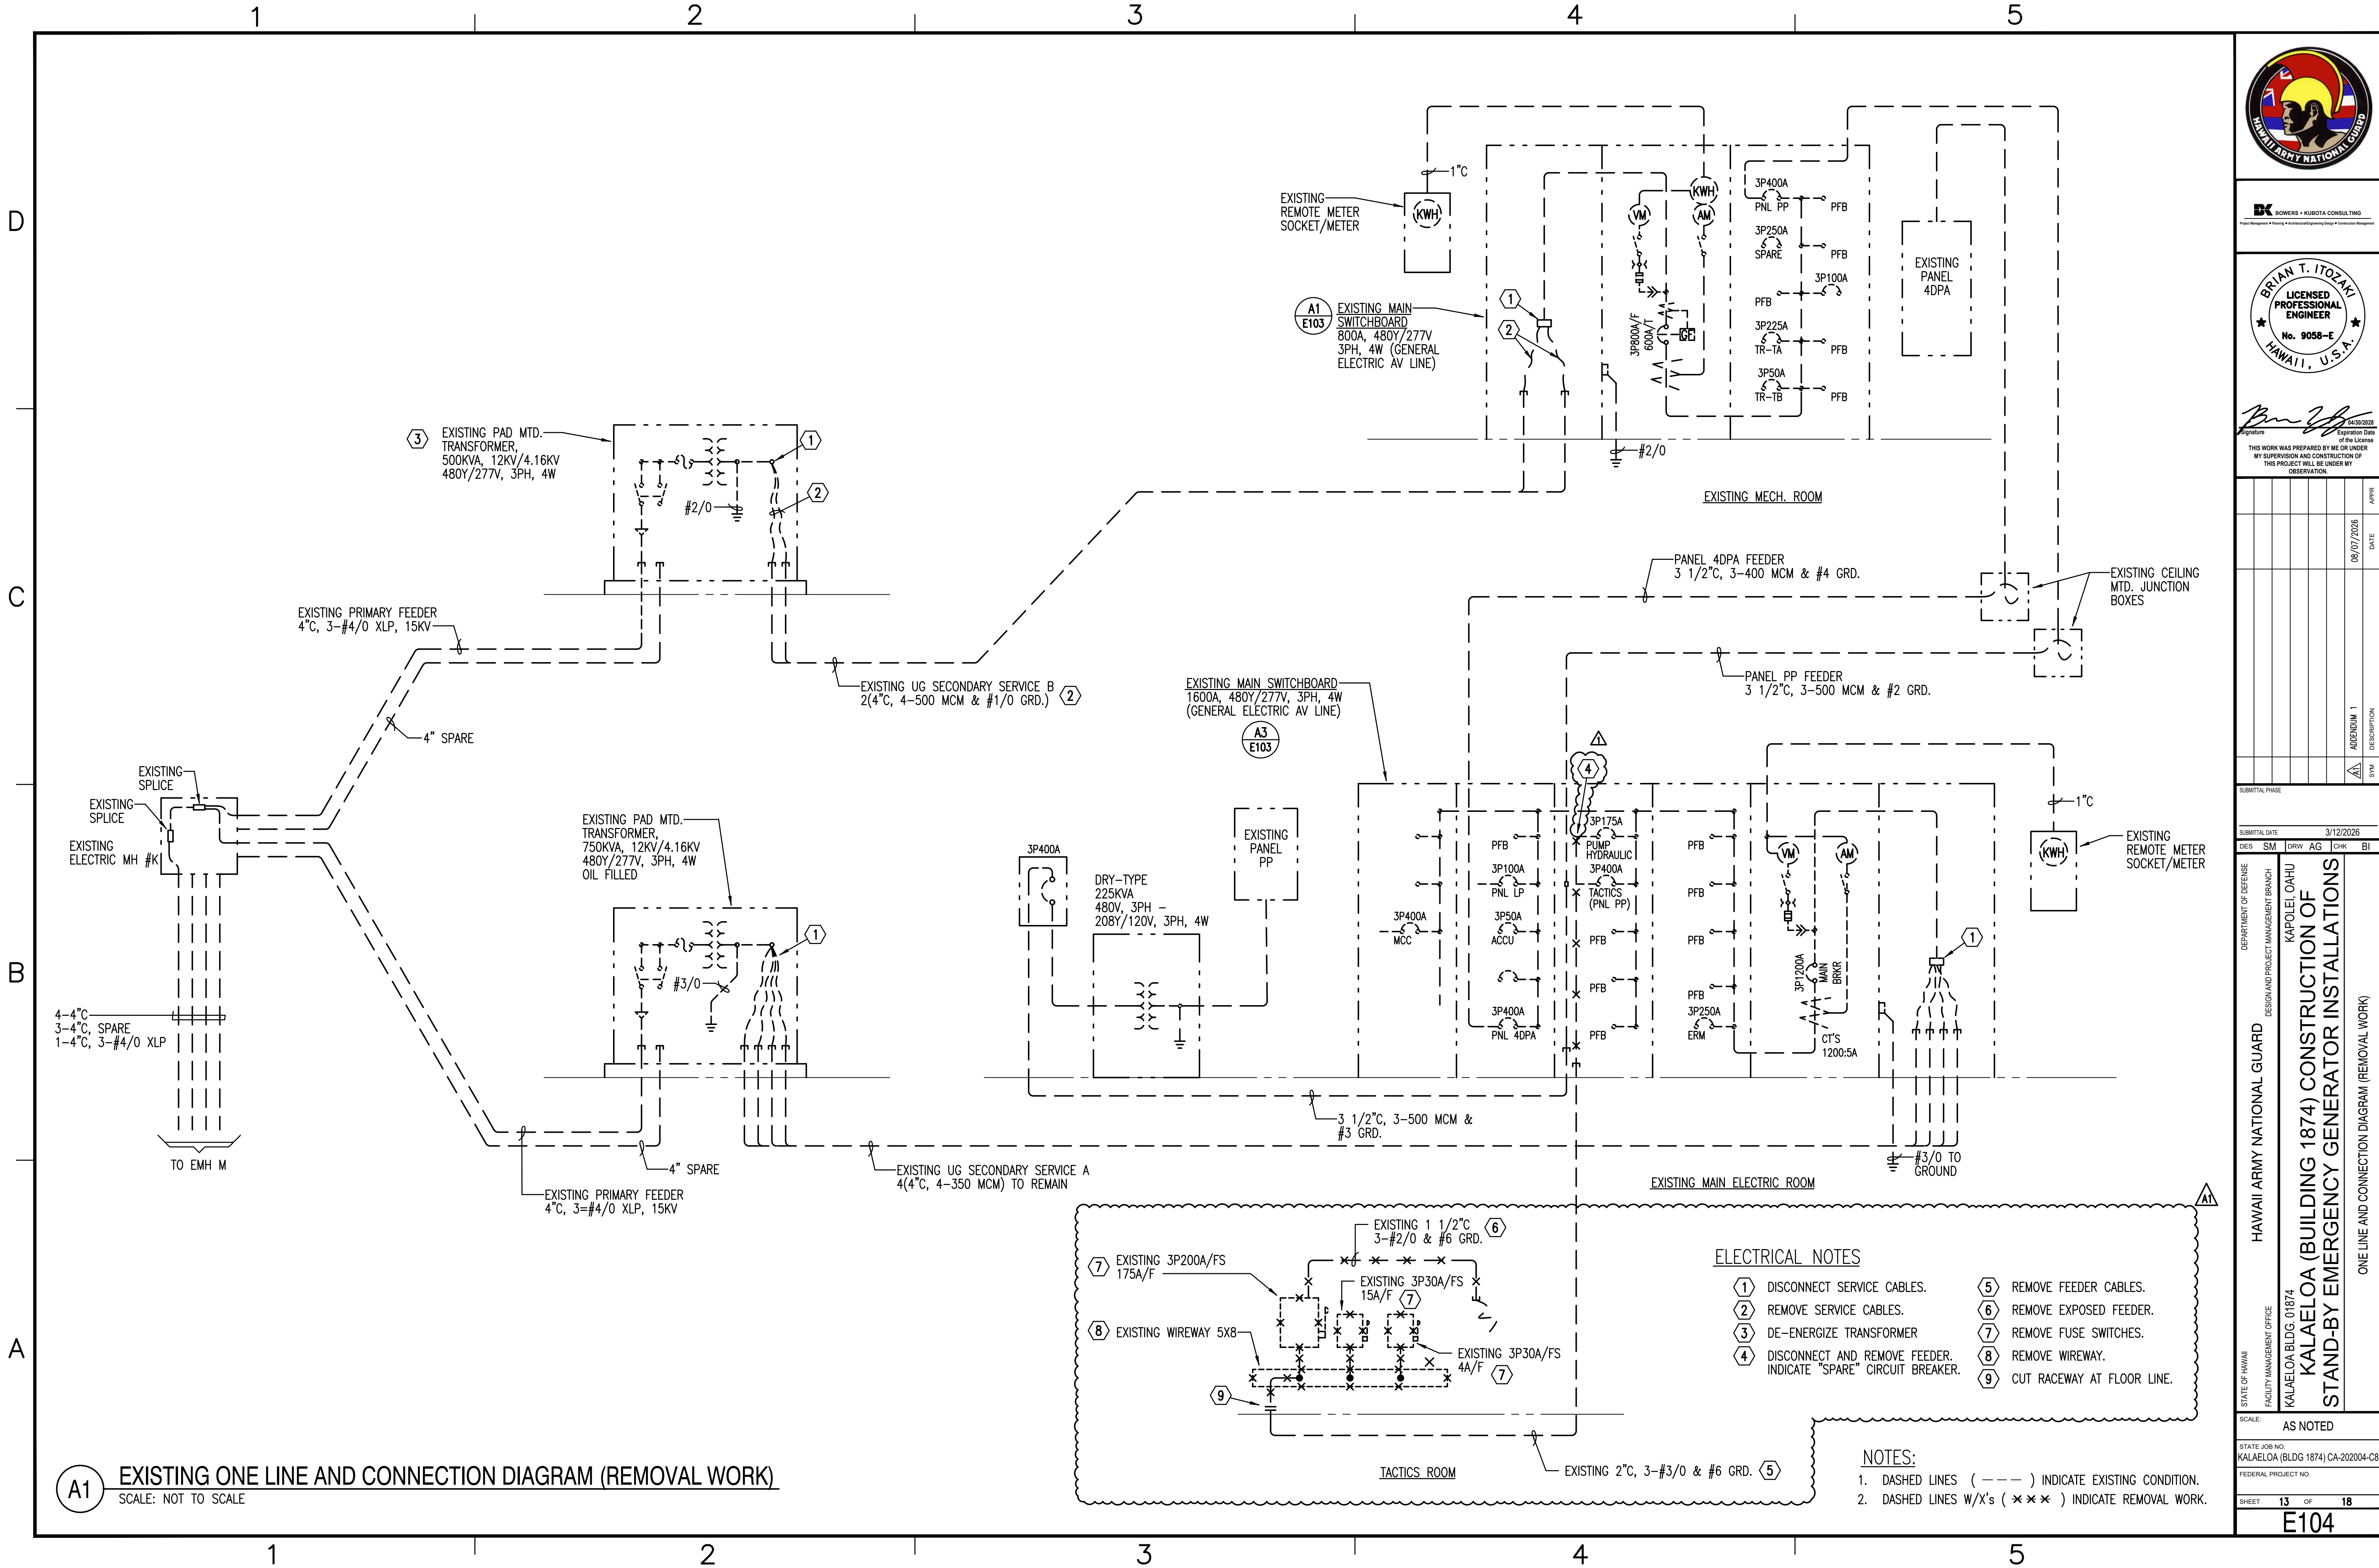

BOWERS + KUBOTA CONSULTING
Project Management • Planning • Architectural/Engineering Design • Construction Management



Signature: *Brian T. Itozaki*
Expiration Date: 04/30/2023
THIS WORK WAS PREPARED BY ME OR UNDER MY SUPERVISION AND CONSTRUCTION OF THIS PROJECT WILL BE UNDER MY OBSERVATION.

DATE	DESCRIPTION
08/07/2026	ADDENDUM 1
	SW

SUBMITTAL PHASE
SUBMITTAL DATE: 3/12/2026

DES	SM	DRW	AG	CHK	BI

DEPARTMENT OF DEFENSE
HAWAIIAN NATIONAL GUARD
DESIGN AND PROJECT MANAGEMENT BRANCH
KAPOLEI, OAHU
KALAELOA BLDG. 01874
KALAELOA (BLDG 1874) CONSTRUCTION OF
STAND-BY EMERGENCY GENERATOR INSTALLATIONS
ONE LINE AND CONNECTION DIAGRAM (REMOVAL WORK)



SCALE: AS NOTED


STATE JOB NO. KALAELOA (BLDG 1874) CA-202004-C8

FEDERAL PROJECT NO.

SHEET 13 OF 18

E104

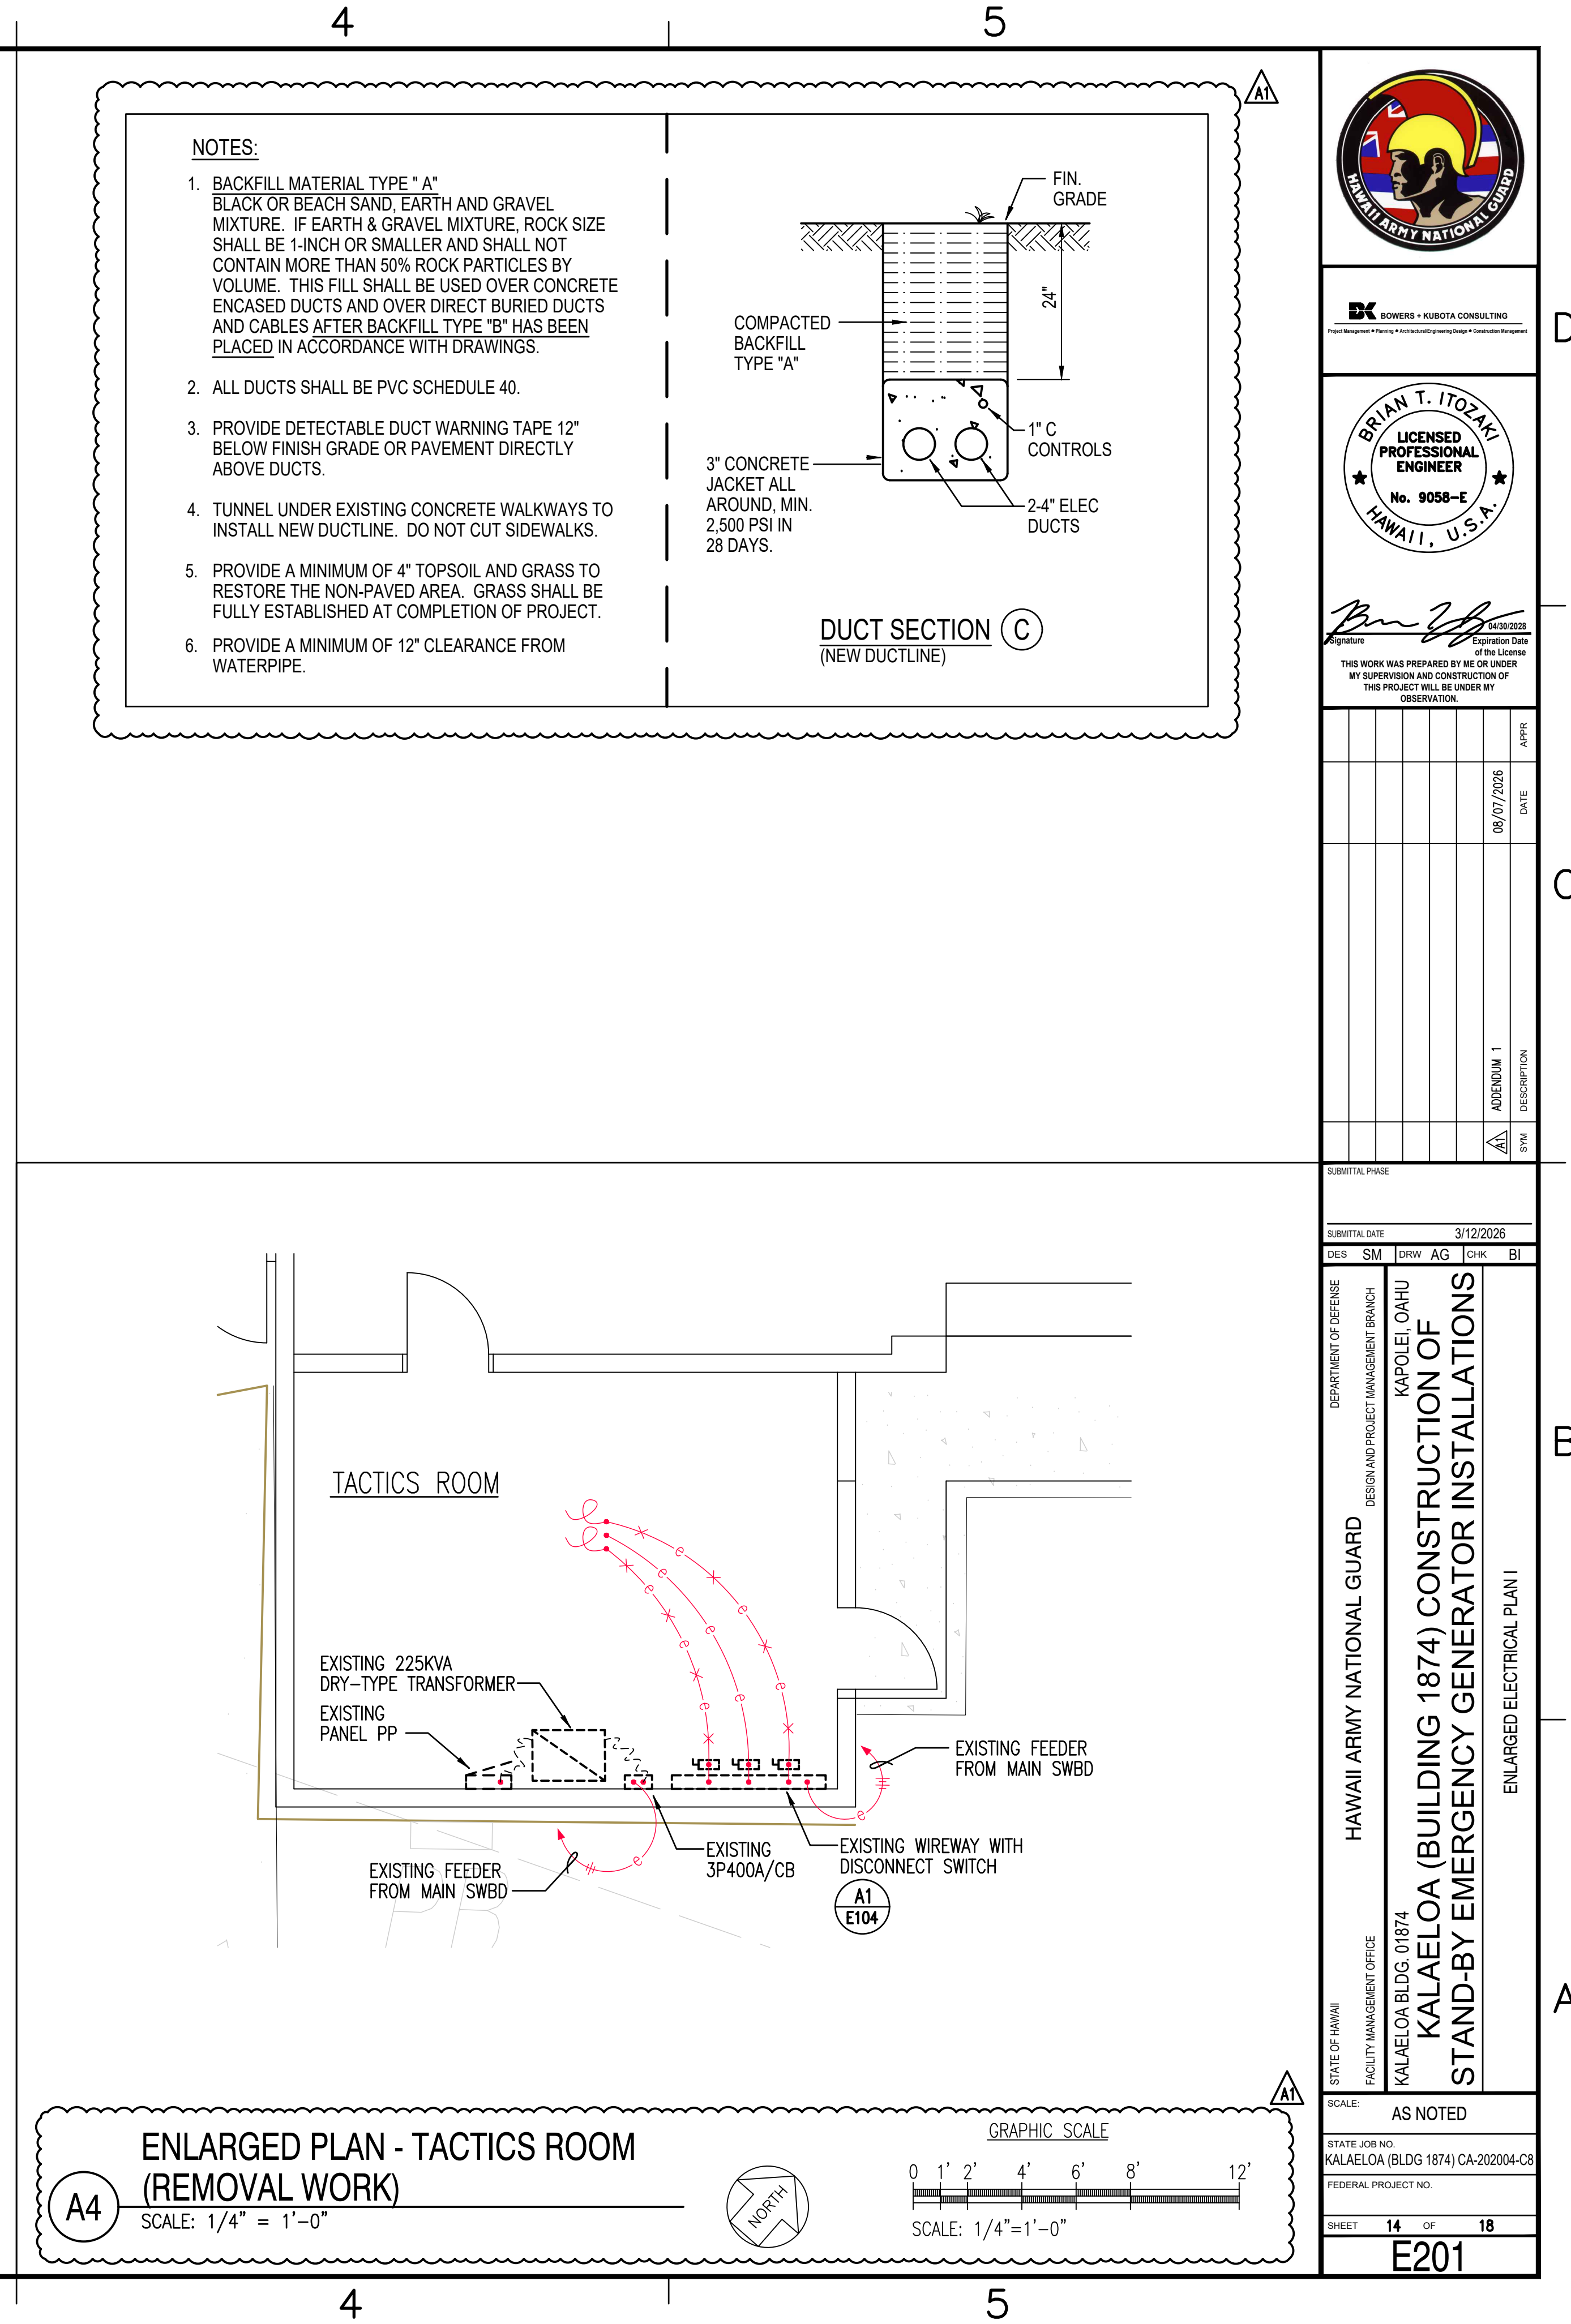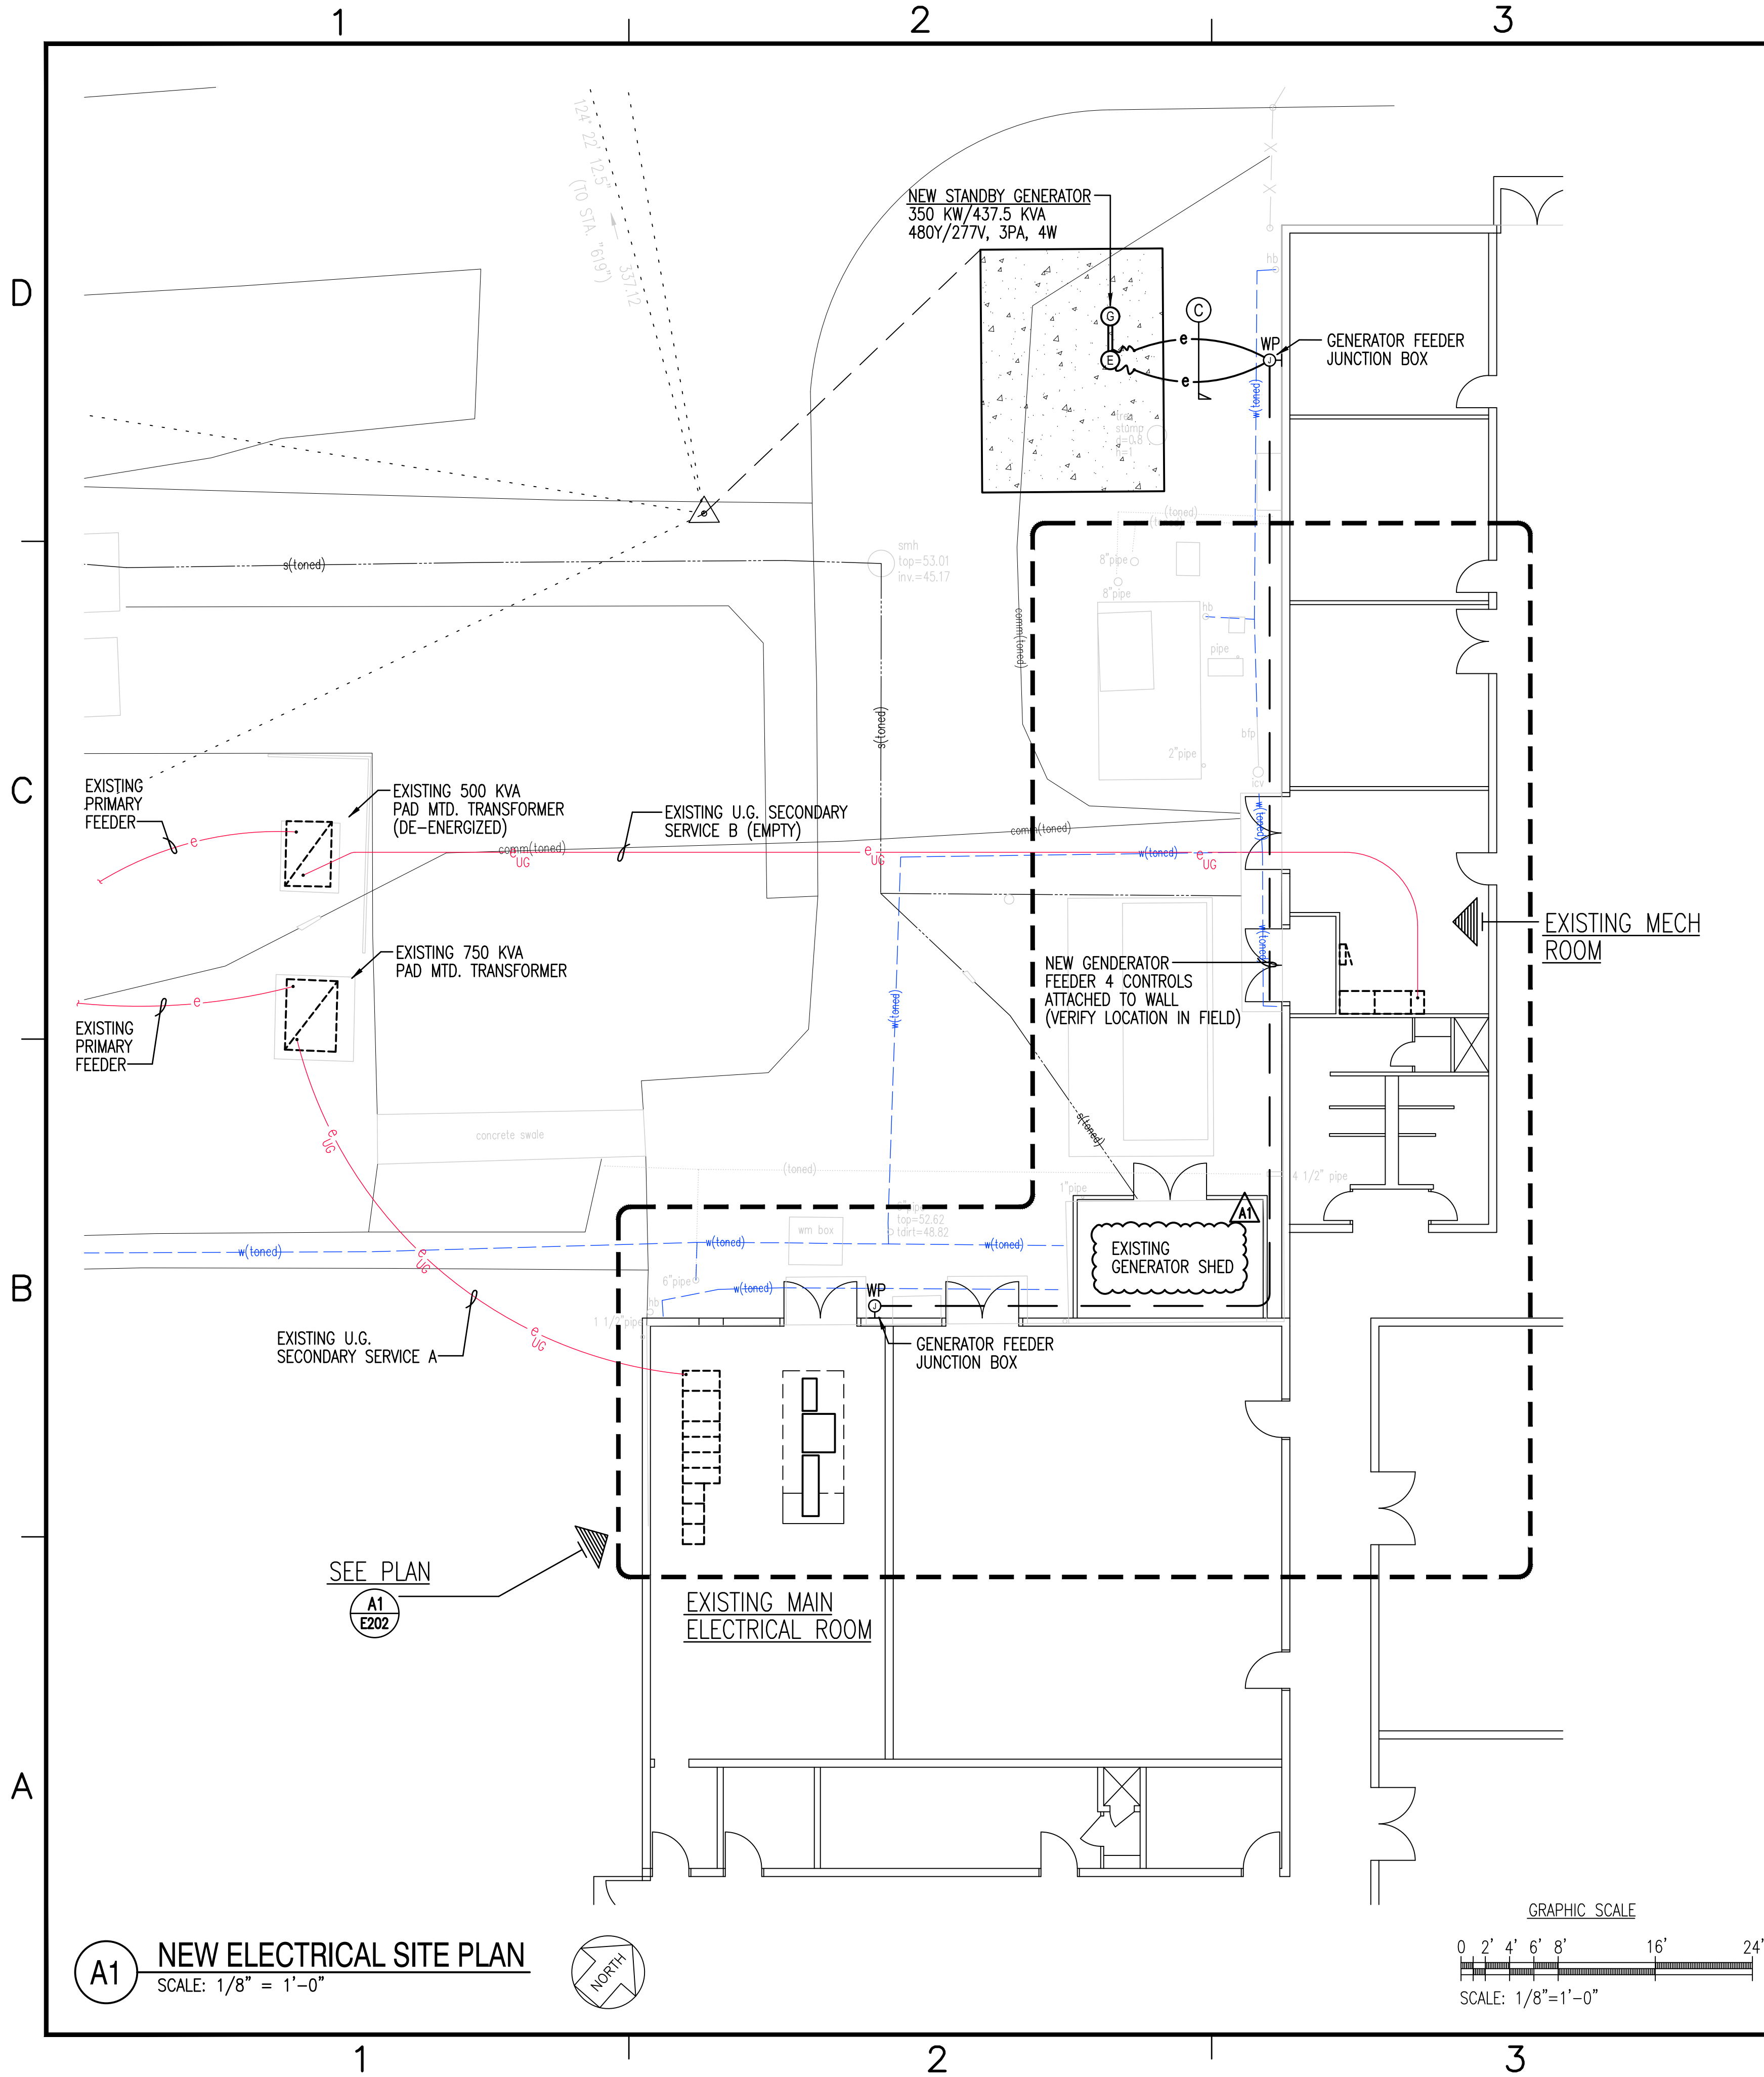

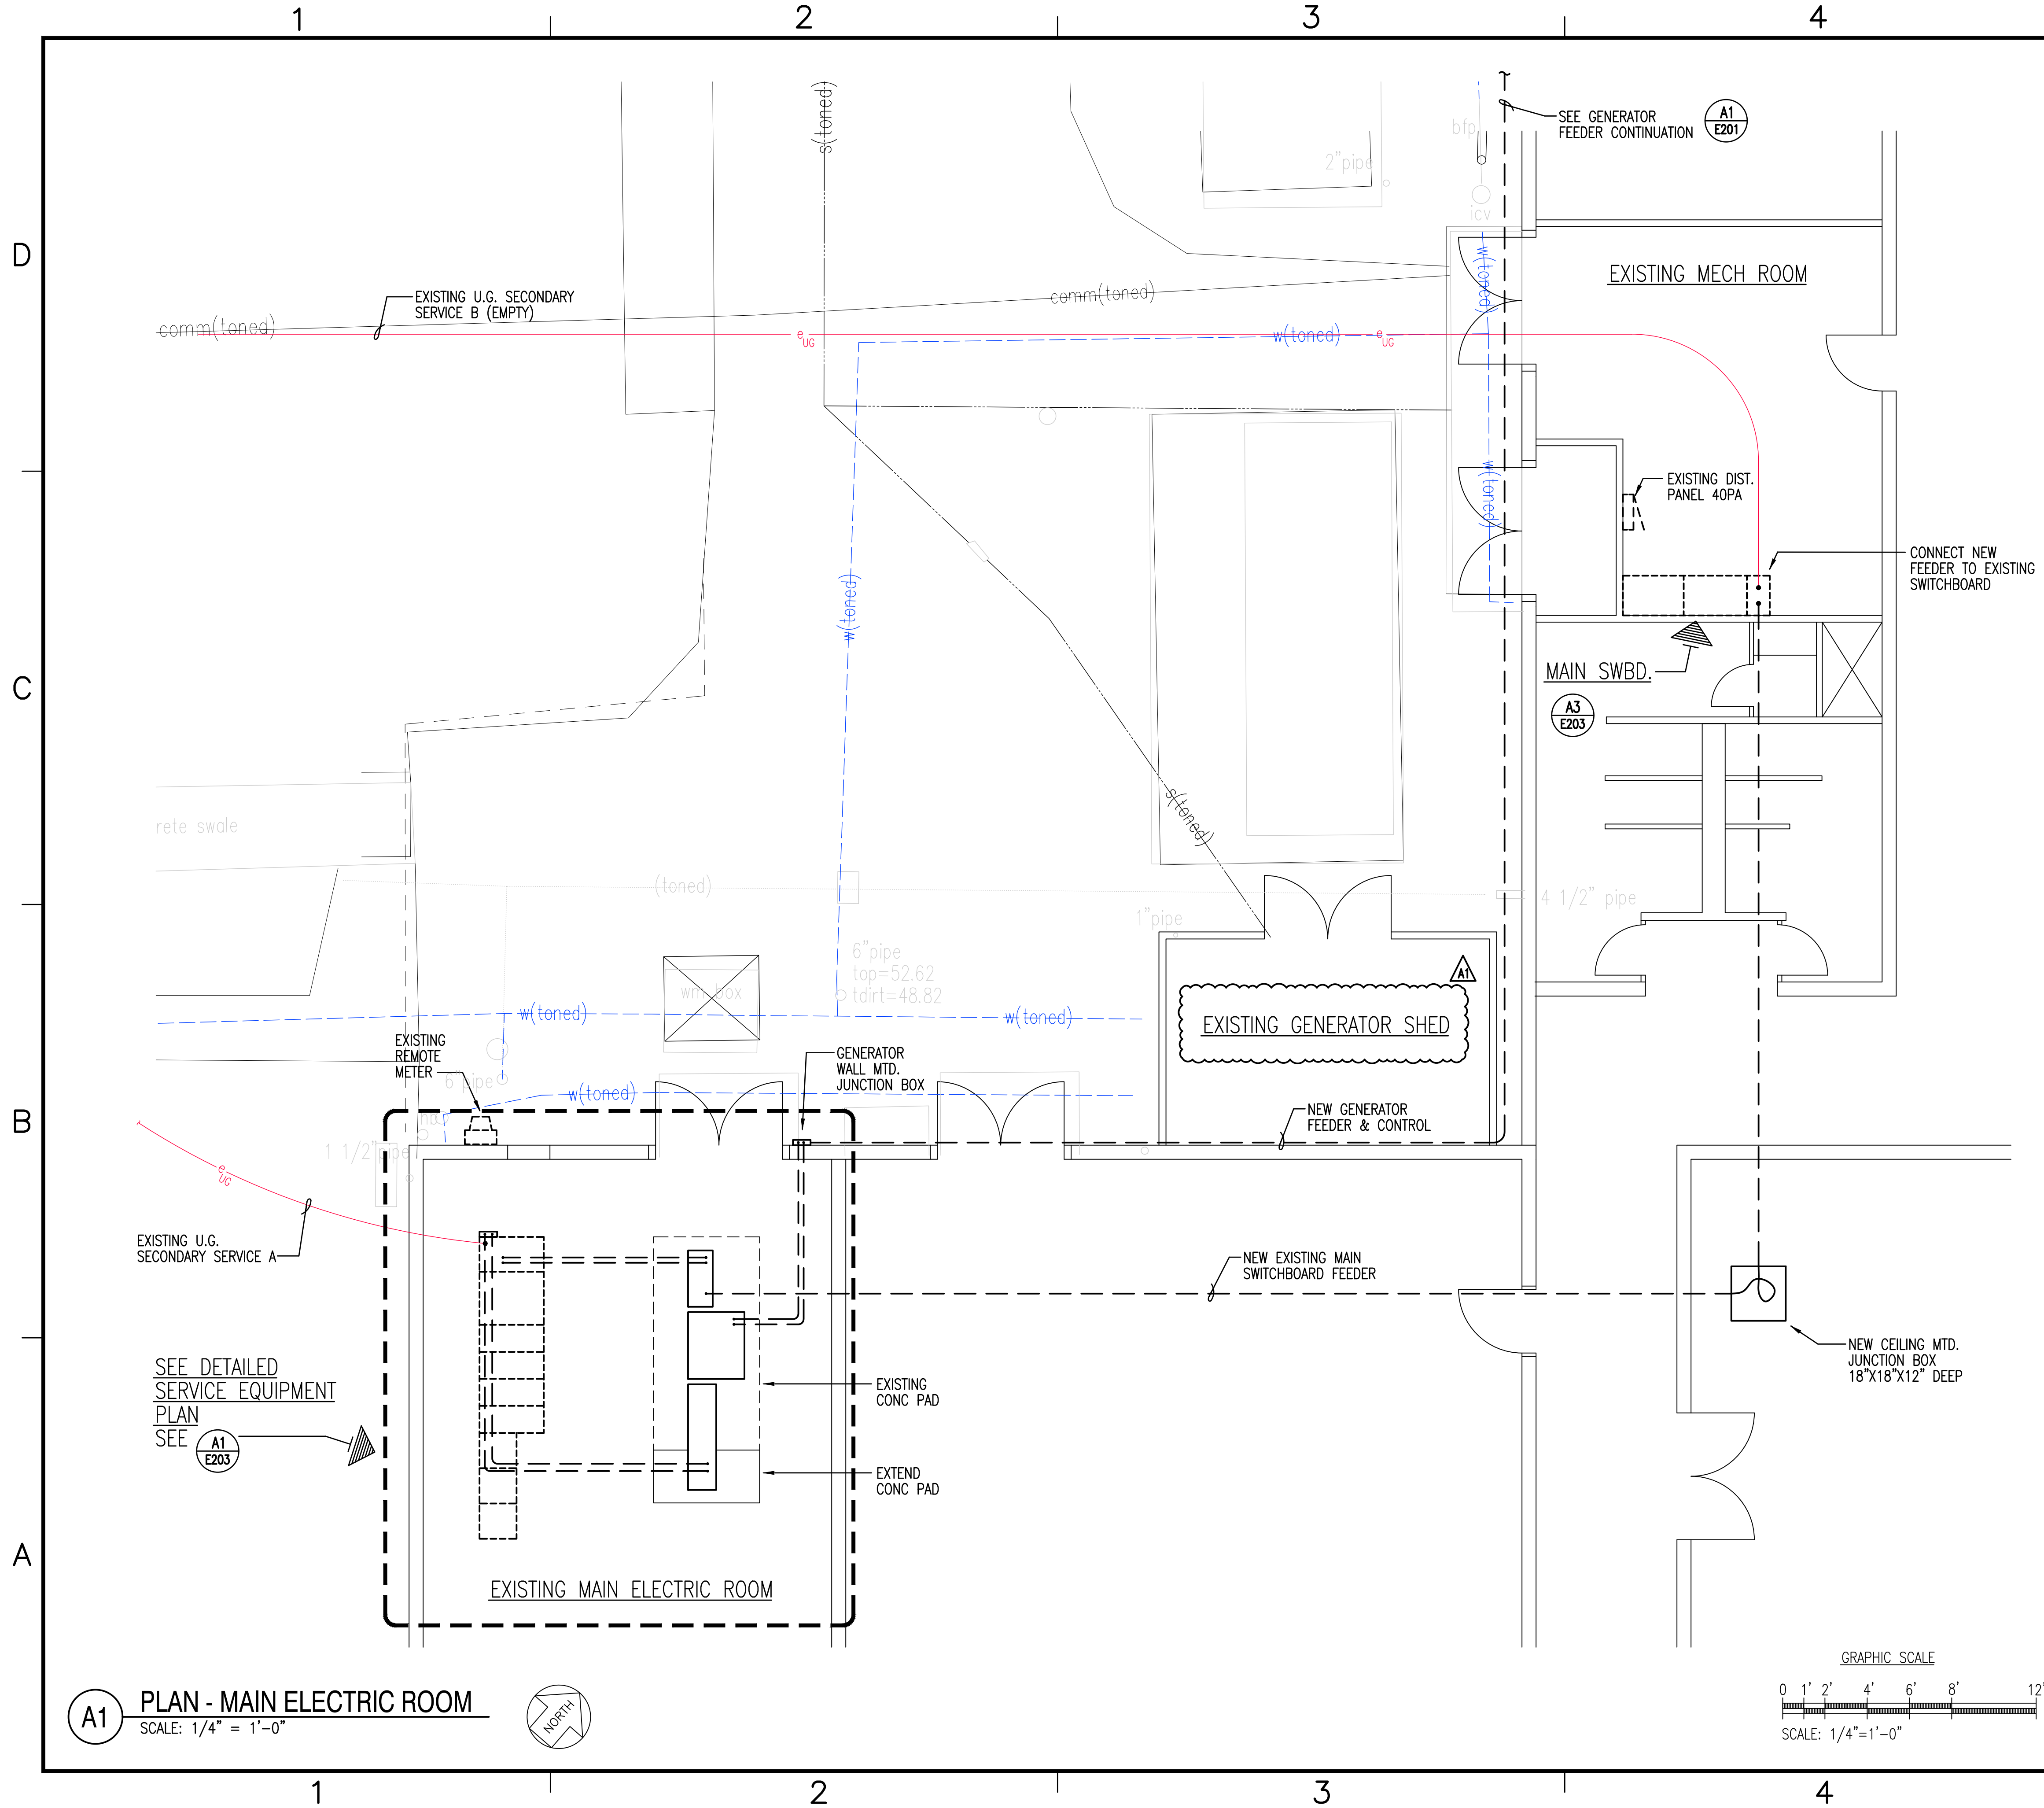


ELECTRICAL NOTES (REMOVAL WORK)

- 1 DISCONNECT AND REMOVE WALL MTD. 3P30A SWITCH. CUT RACEWAY AT FLOOR LINE.
- 2 REMOVE WALL MOUNTED JUNCTION BOX. CUT RACEWAY AT FLOOR LINE.
- 3 -
- 4 CUT RACEWAYS AT FLOOR LINE.
- 5 REMOVE FEEDER OFF OF 3P400A/CO.
- 6 REMOVE EXISTING FEEDERS.
- 7 REMOVE WALL MOUNTED CIRCUIT BREAKER AND FEEDER TO TRANSFORMER.
- 8 REMOVE DRY-TYPE TRANSFORMER.
- 9 REMOVE FEEDERS.
- 10 REMOVE WALL MOUNTED JUNCTION BOX.
- 11 REMOVE EXTERIOR WALL MOUNTED FEEDERS.



BOWERS + KUBOTA CONSULTING
Public Management • Planning • Architectural Engineering Design • Construction Management

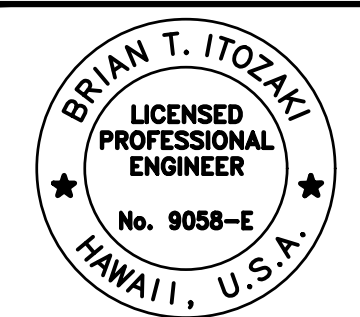

Brian T. Itozaki
Signature
04/30/2023
Expiration Date
THIS WORK WAS PREPARED BY ME OR UNDER MY SUPERVISION AND CONSTRUCTION OF THIS PROJECT WILL BE UNDER MY OBSERVATION.

ADDENDUM	DATE	DESCRIPTION
1	08/07/2026	UPPER

DES	SM	DRW	AG	CHK	BI

DEPARTMENT OF DEFENSE
HAWAII ARMY NATIONAL GUARD
DESIGN AND PROJECT MANAGEMENT BRANCH
KAPOLEI, OAHU
KALAELOA BLDG. 01874
KALAELOA (BUILDING 1874) CONSTRUCTION OF
STAND-BY EMERGENCY GENERATOR INSTALLATIONS
ENLARGED ELECTRICAL PLAN II


SCALE: AS NOTED

STATE JOB NO. KALAELOA (BLDG 1874) CA-202004-C8


FEDERAL PROJECT NO.

SHEET 15 OF 18

E202

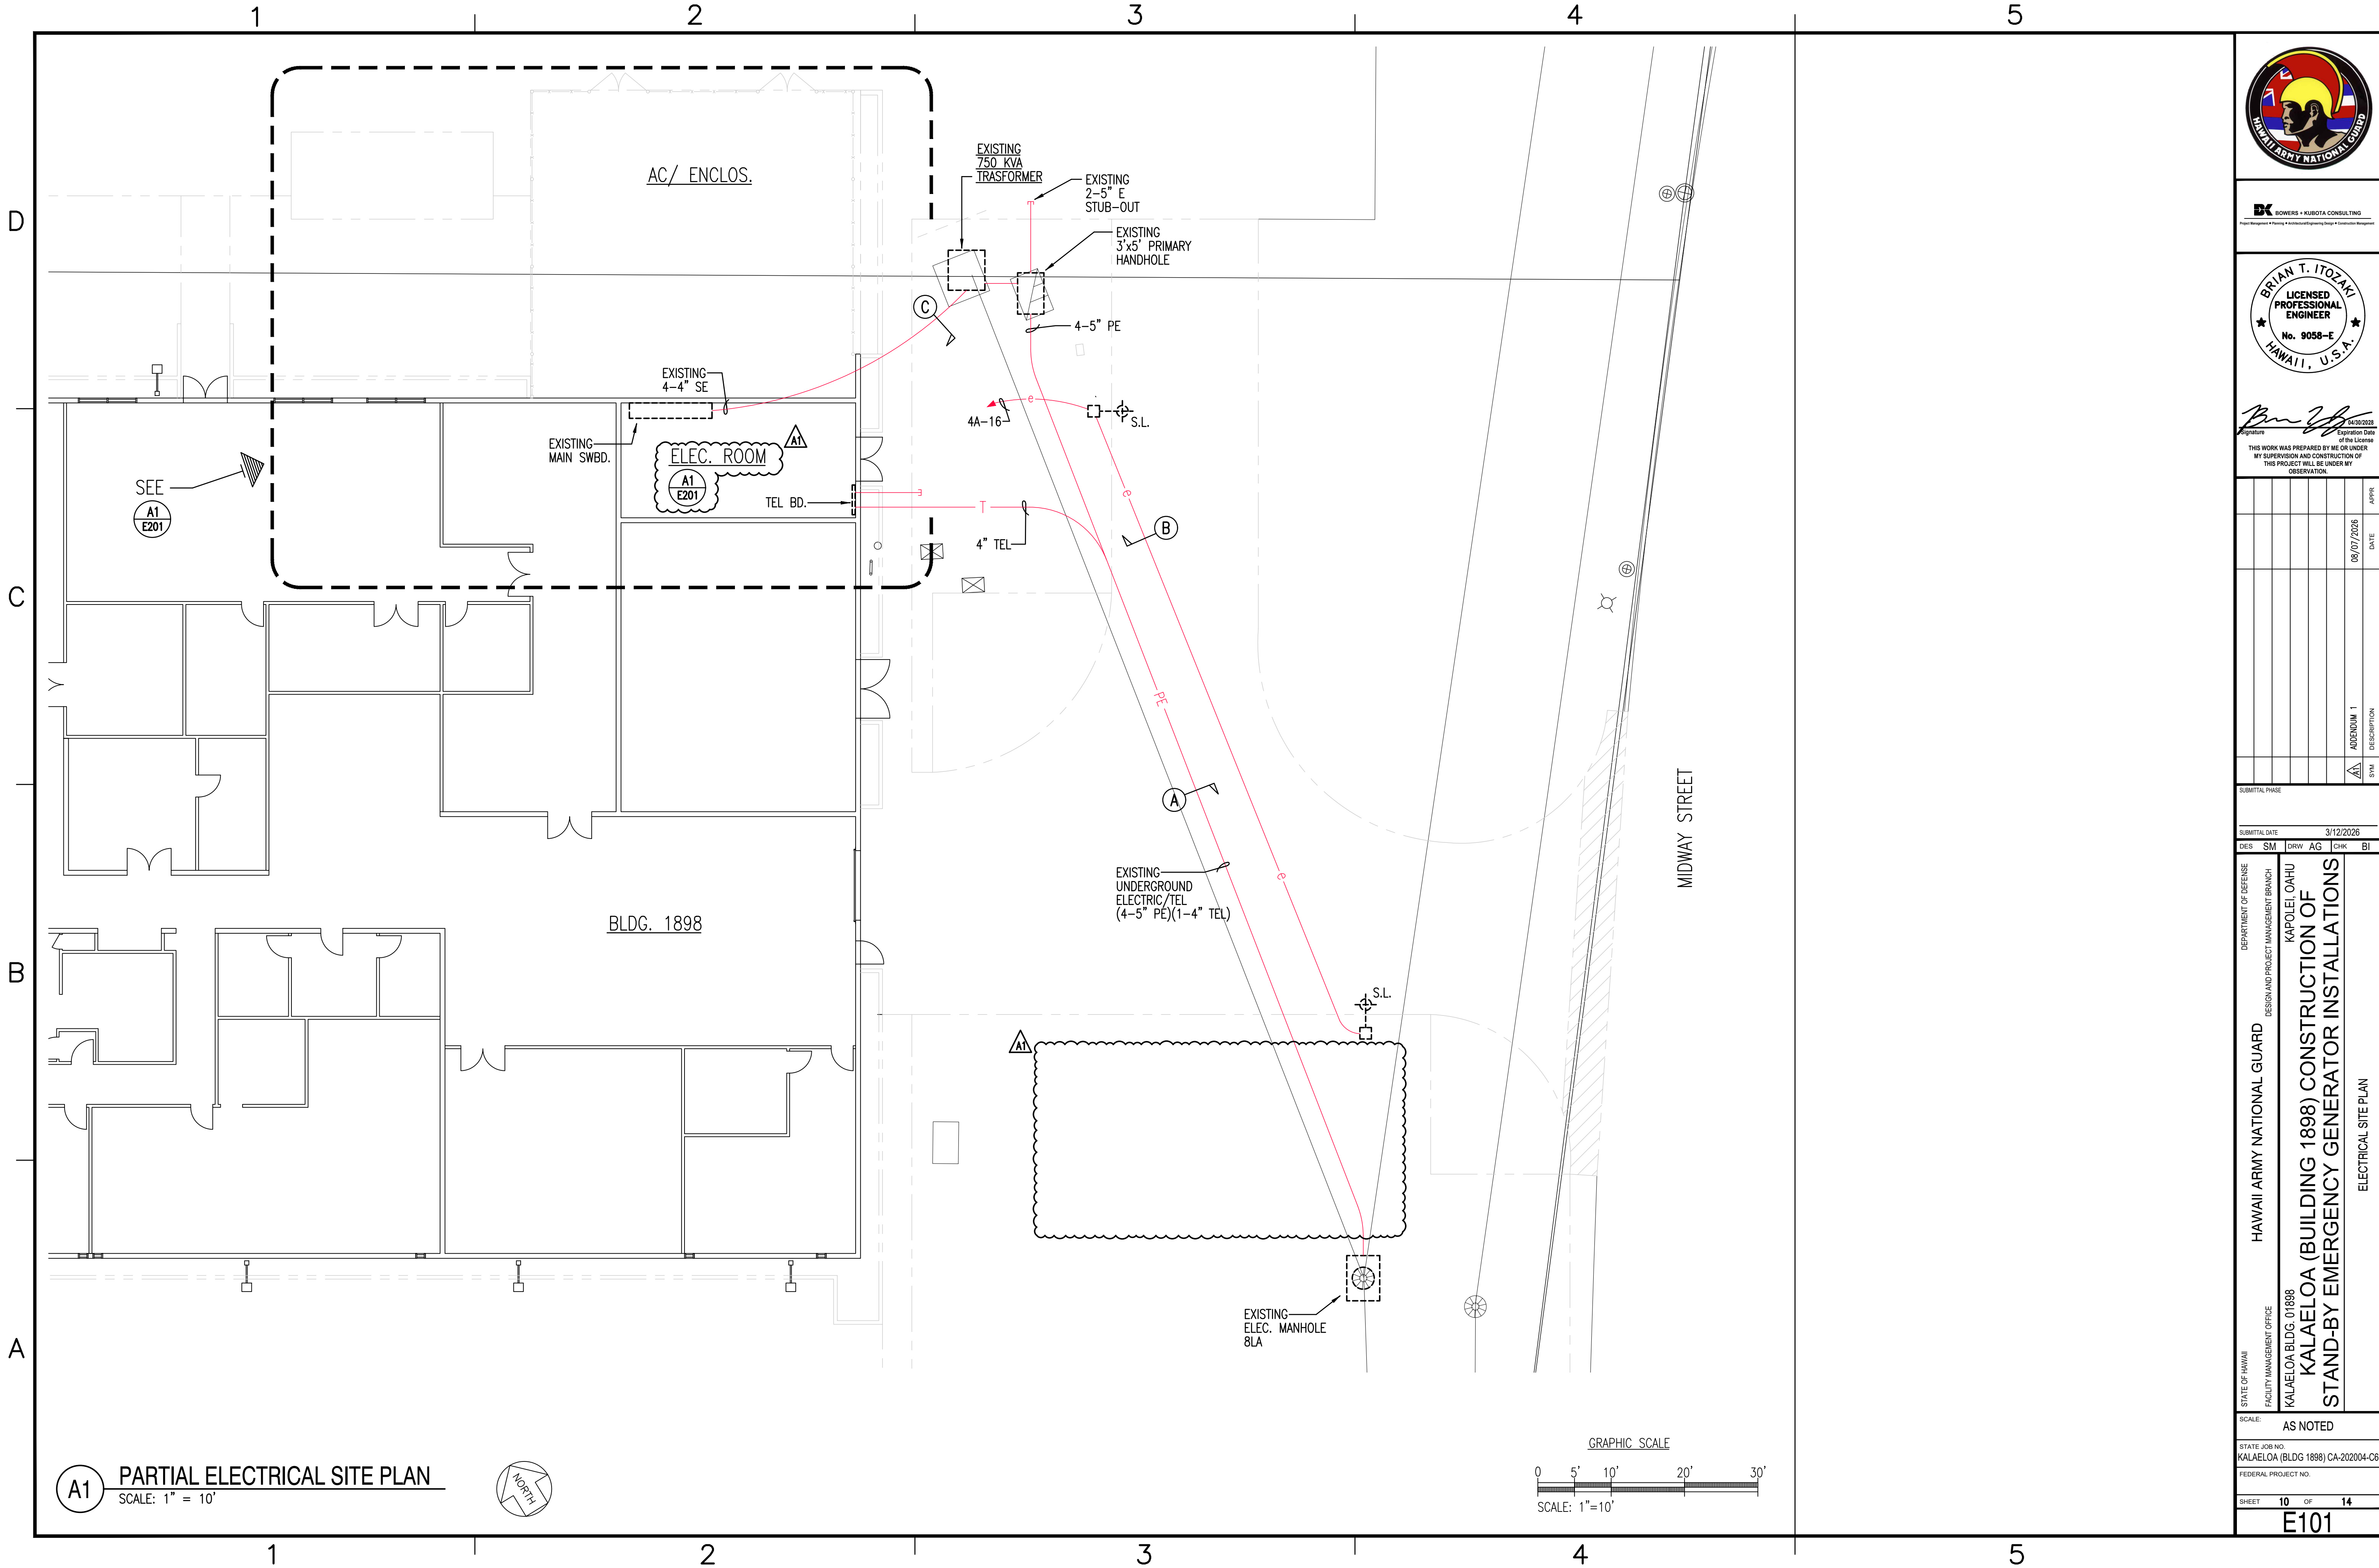

BOWERS + KUBOTA CONSULTING

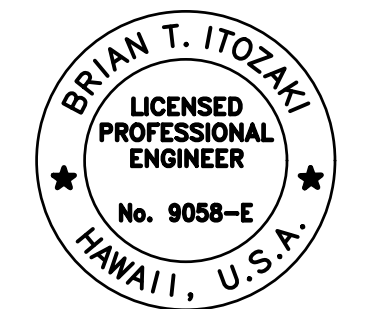

Signature: *Brian T. Itozaki*
Expiration Date: 04/30/2026
THIS WORK WAS PREPARED BY ME OR UNDER MY SUPERVISION AND CONSTRUCTION OF THIS PROJECT WILL BE UNDER MY OBSERVATION.

DATE	DESCRIPTION	SYN	APP
08/07/2026	ADDENDUM 1		

DES	SM	DRW	AG	CHK	BI

STATE OF HAWAII
FACILITY MANAGEMENT OFFICE
HAWAII ARMY NATIONAL GUARD
DESIGN AND PROJECT MANAGEMENT BRANCH
KAPOLEI, OAHU
KALAELOA BLDG. 01898
KALAELOA (BLDG 1898) CONSTRUCTION OF STAND-BY EMERGENCY GENERATOR INSTALLATIONS
ELECTRICAL SITE PLAN


SCALE: AS NOTED

STATE JOB NO. KALAELOA (BLDG 1898) CA-202004-C6


FEDERAL PROJECT NO.

SHEET 10 OF 14



E101

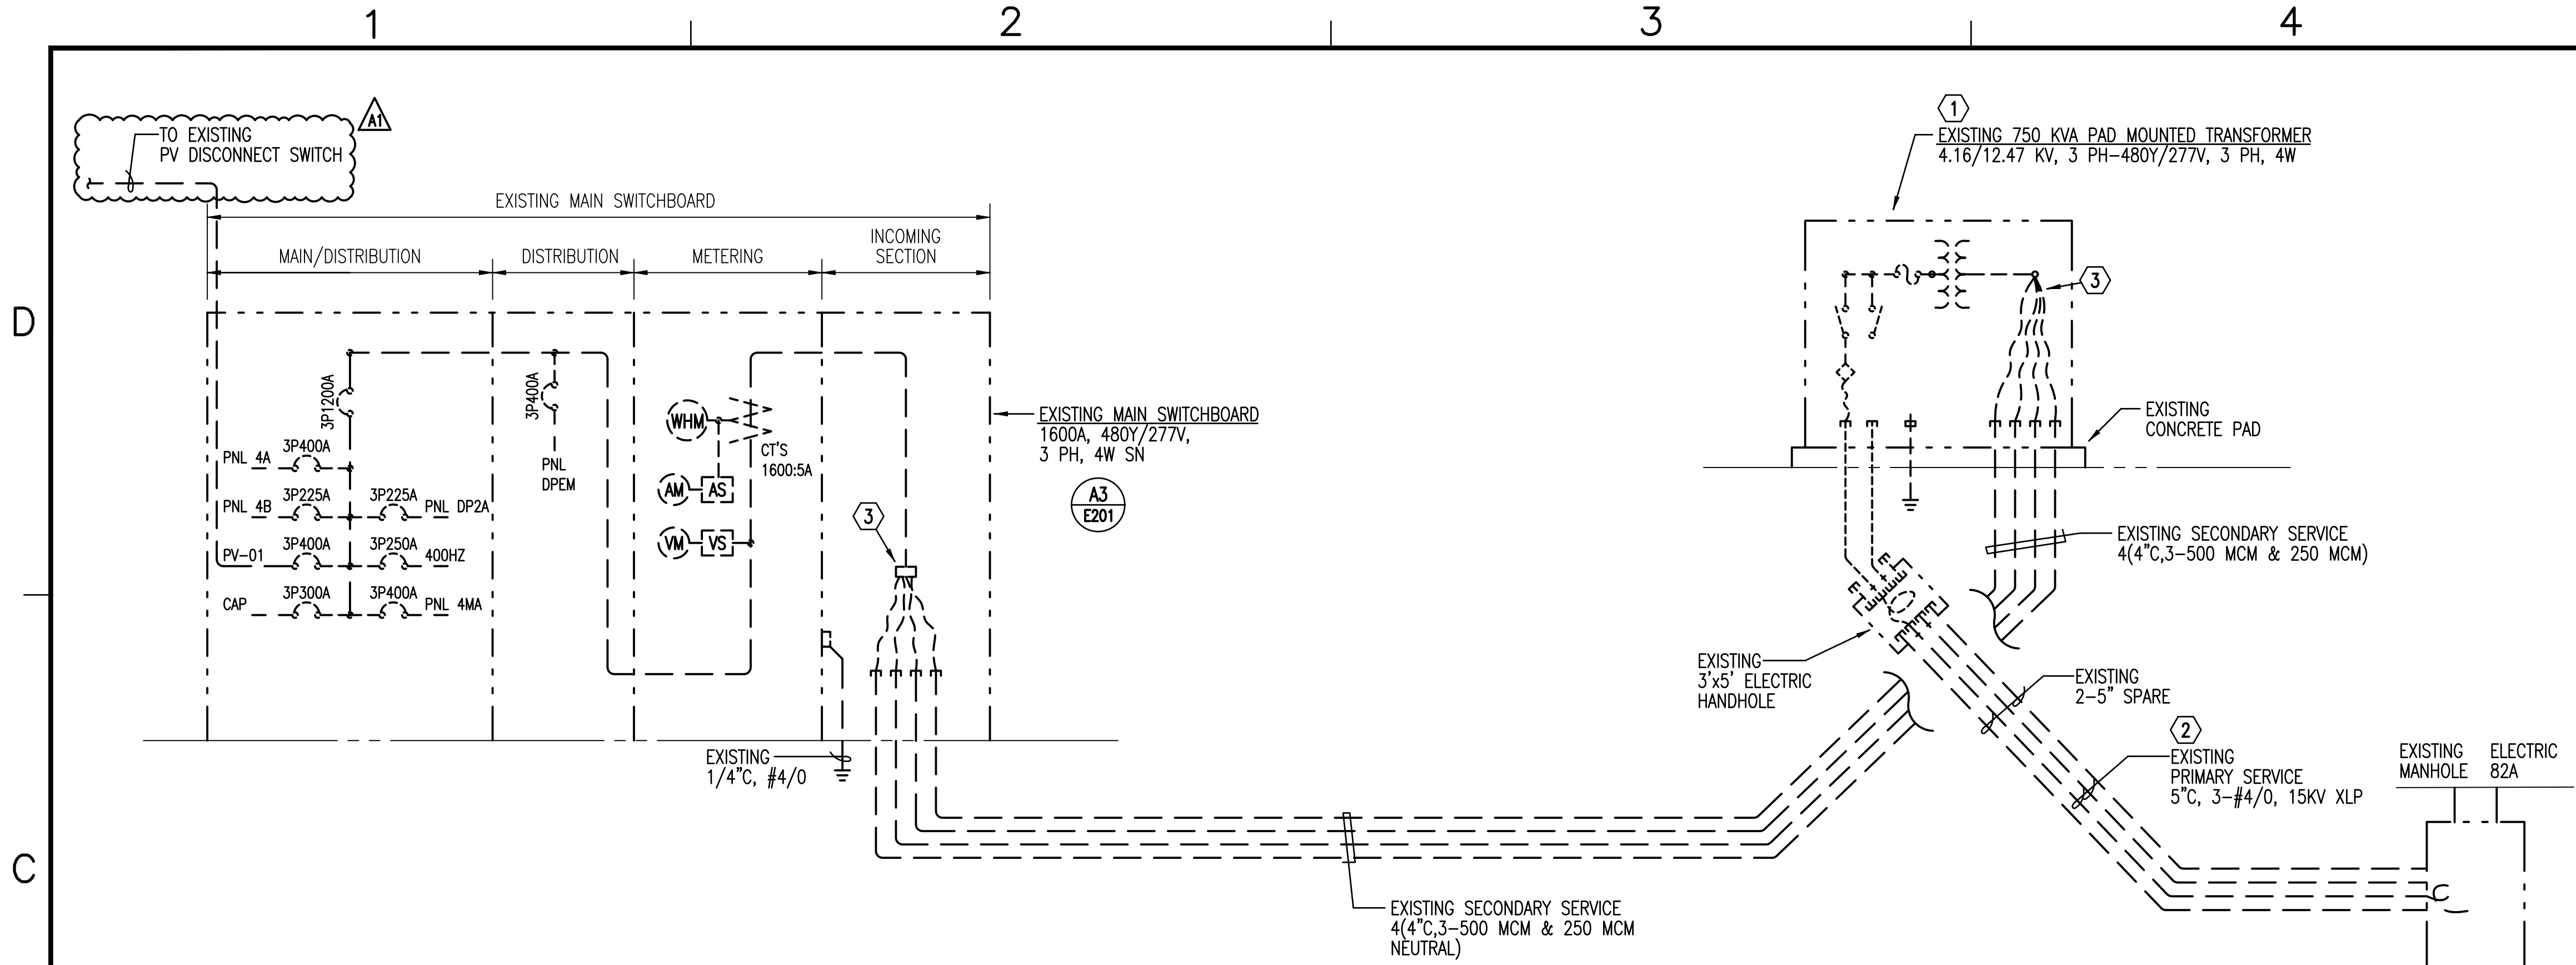

C1 EXISTING ONE LINE DIAGRAM (REMOVAL WORK)
NOT TO SCALE

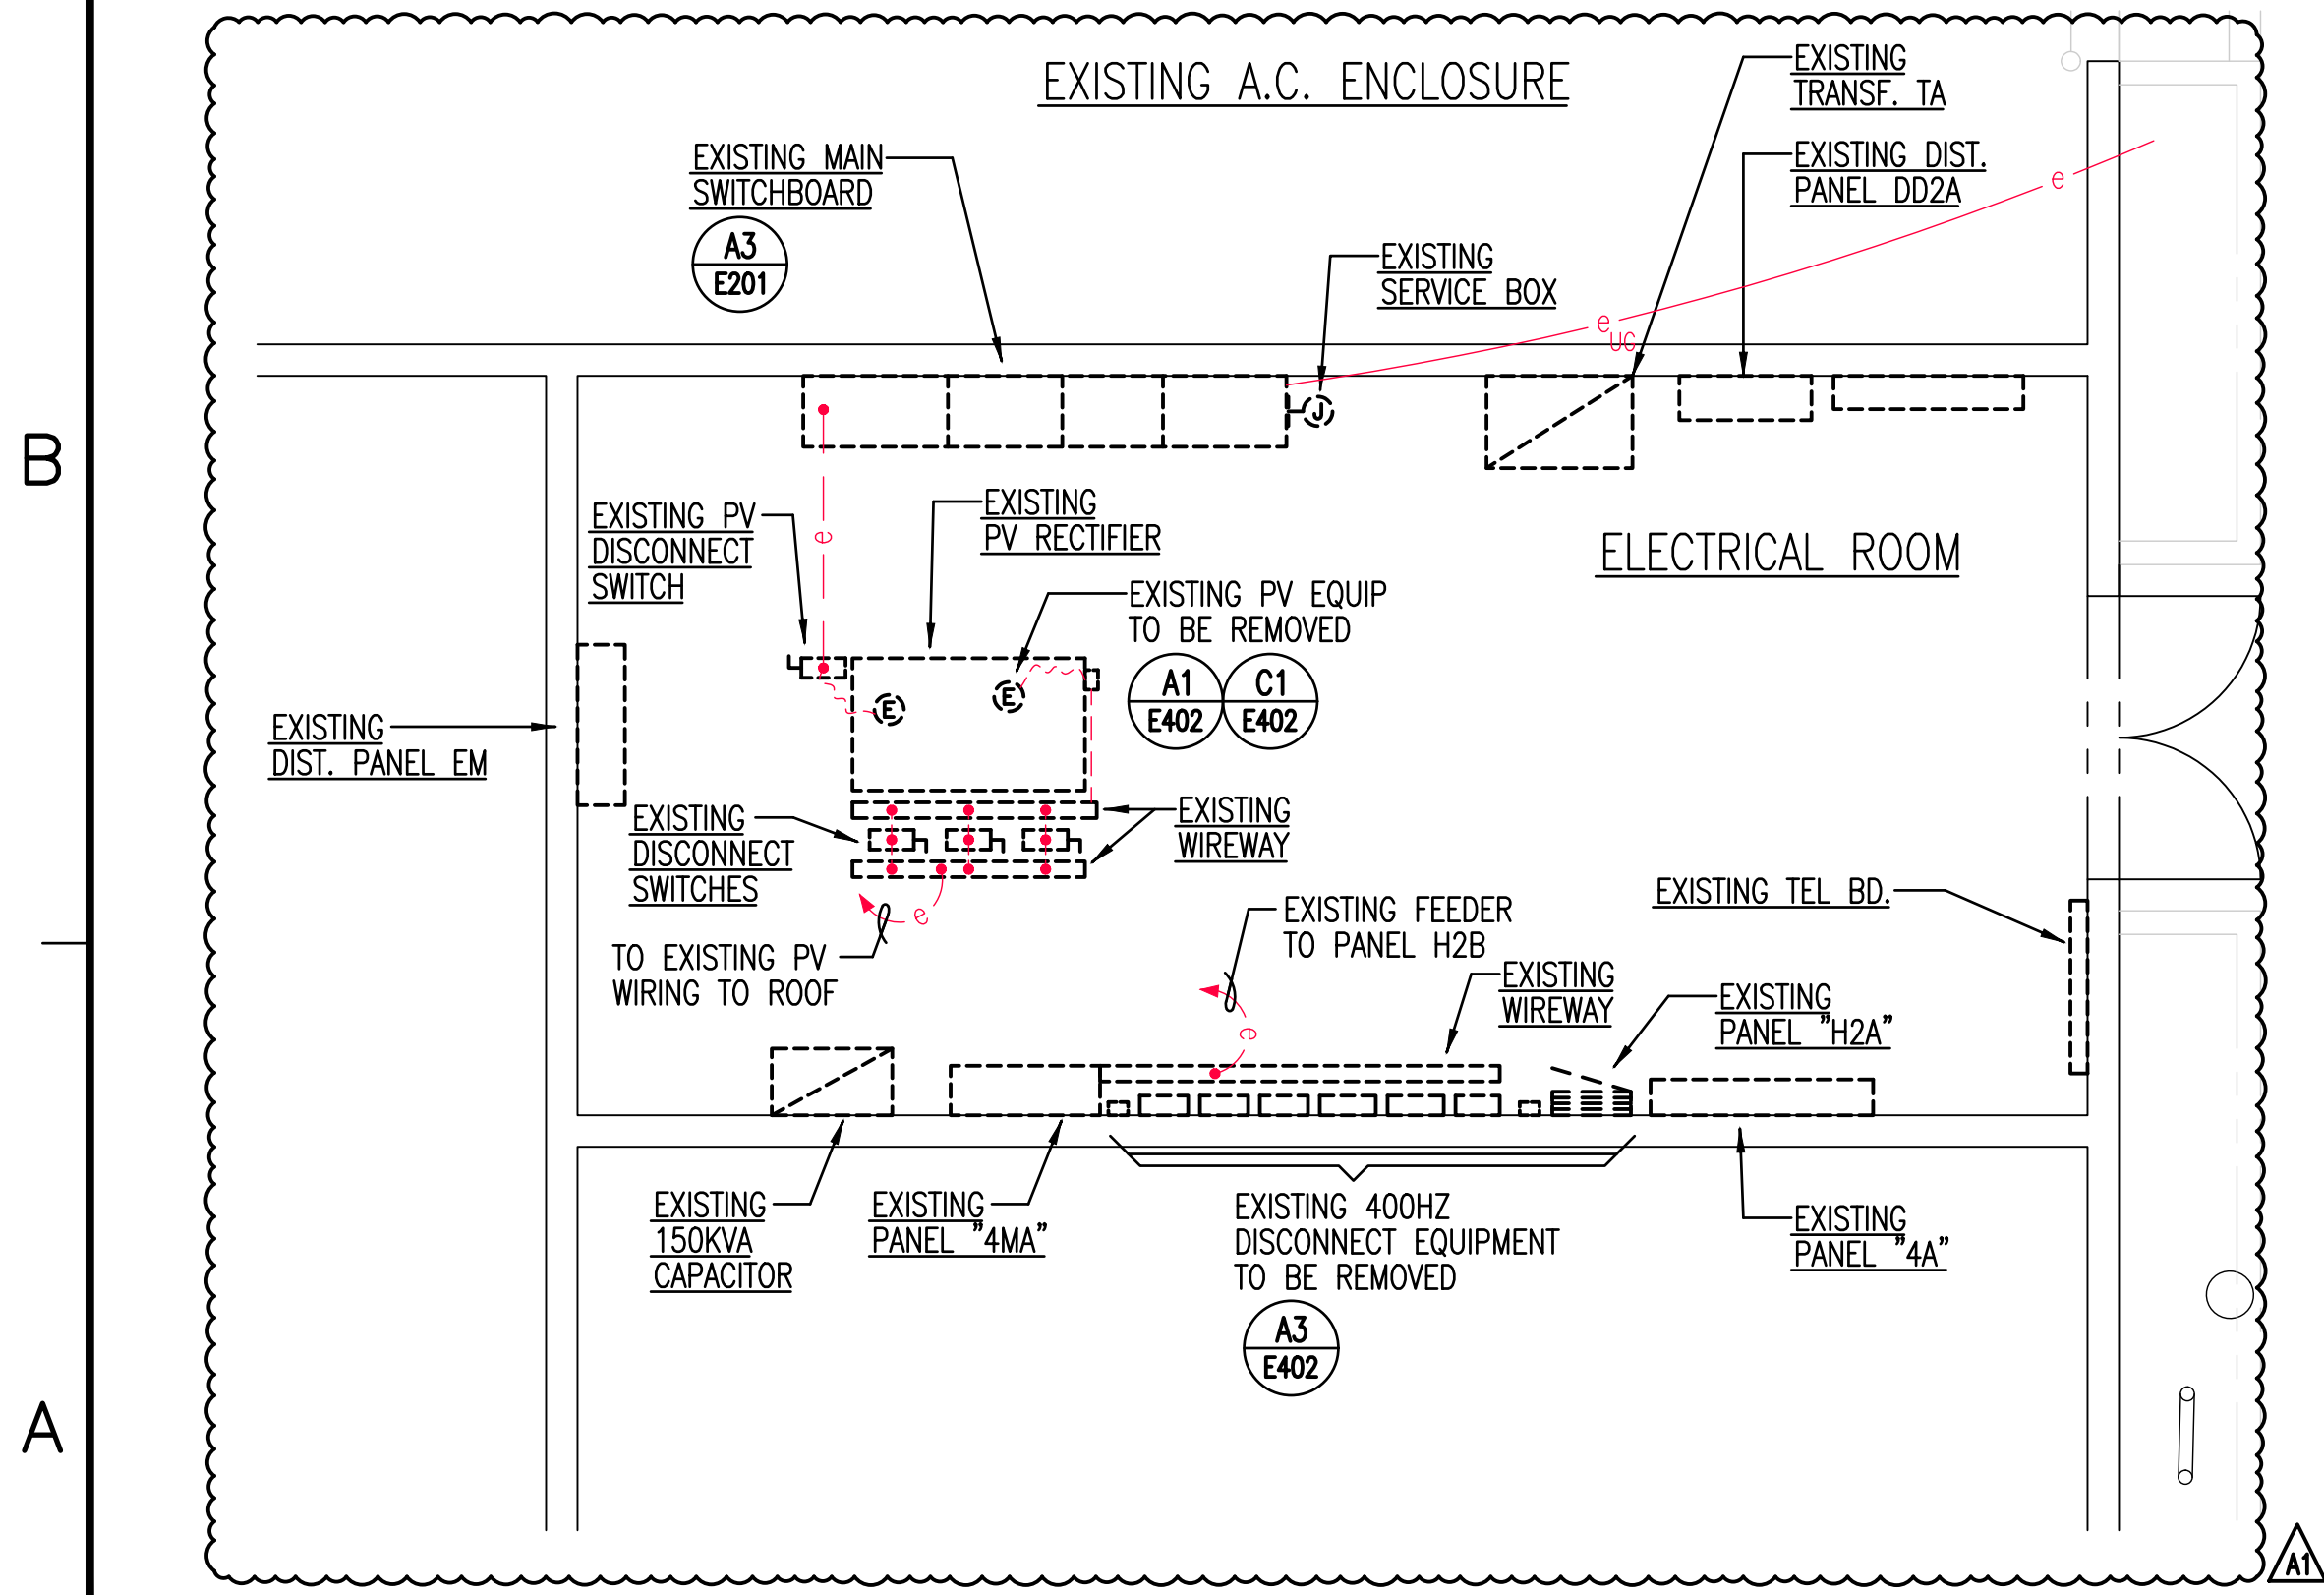

A1 ENLARGED PLAN - EXISTING ELECTRICAL ROOM
SCALE: 1/4" = 1' - 0"

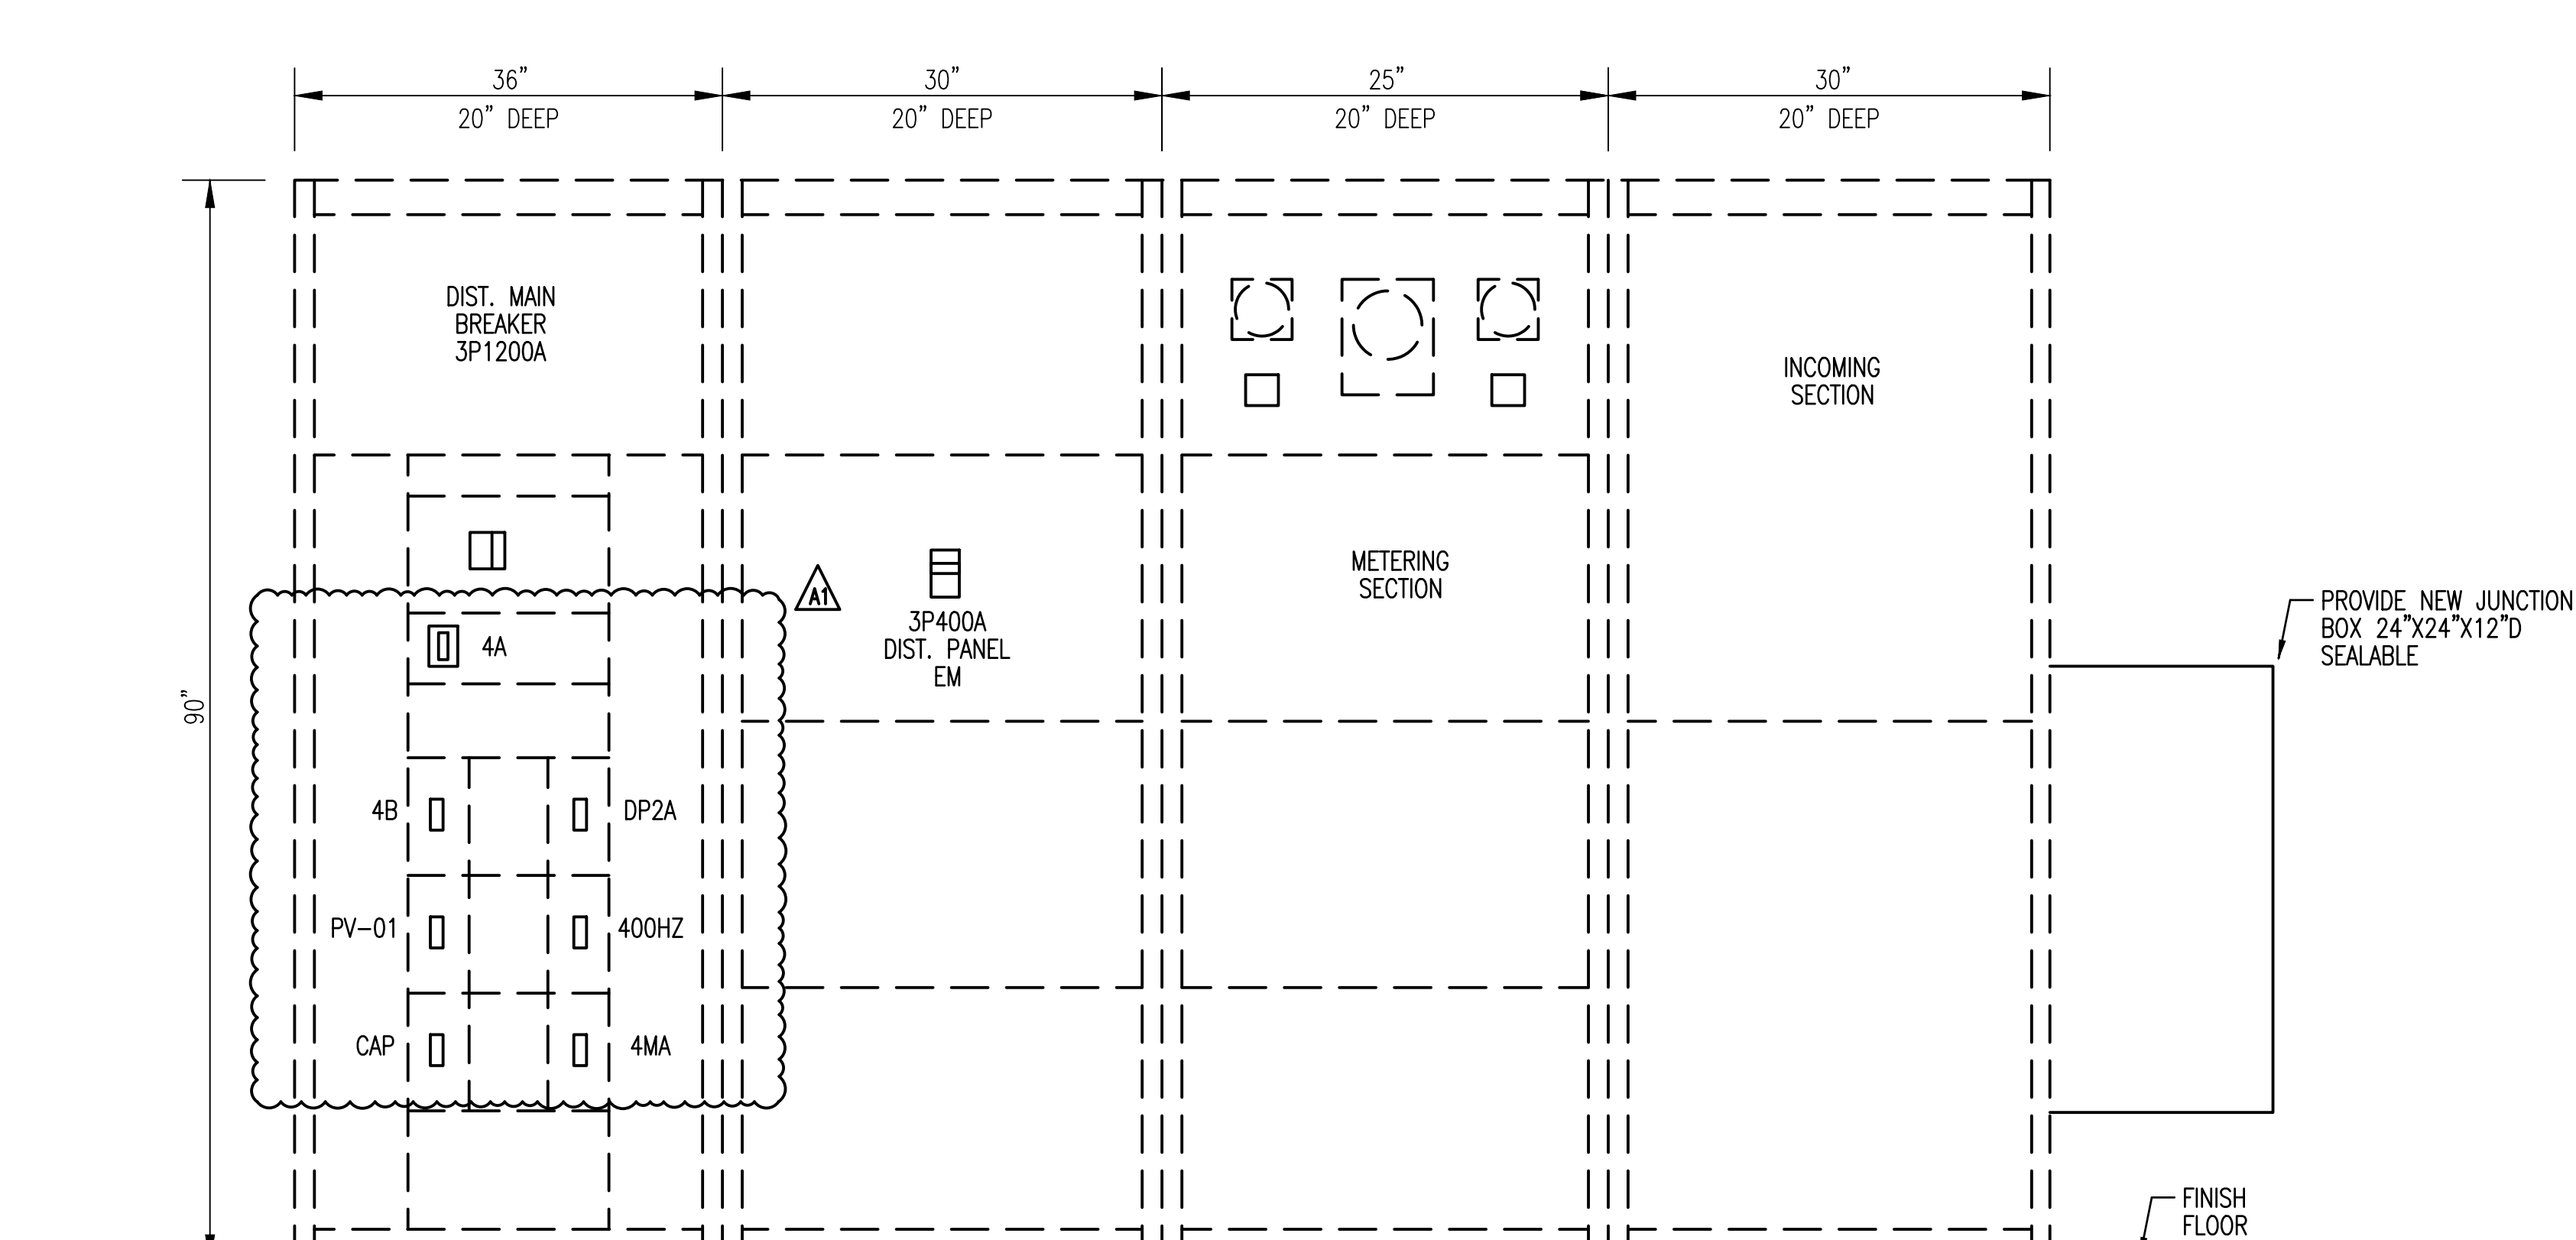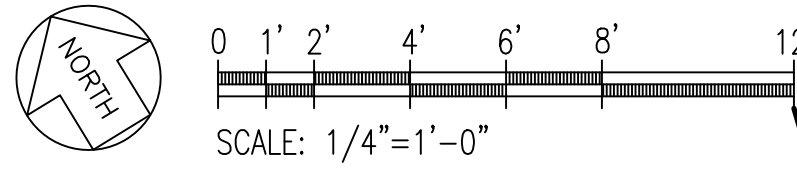


A3 ELEVATION - EXISTING MAIN SWITCHBOARD
NOT TO SCALE

ELECTRICAL NOTES (EXISTING/REMOVAL WORK)

- ① PAD MOUNTED TRANSFORMER TO REMAIN.
- ② PRIMARY SERVICE TO REMAIN.
- ③ SECONDARY SERVICE TO BE MODIFIED. DISCONNECT FOUR SETS OF 3-500 MCM & 250 MCM NEUTRAL.



BOWERS + KUBOTA CONSULTING
Public Manager • Planning • Architectural Engineering Design • Construction Management

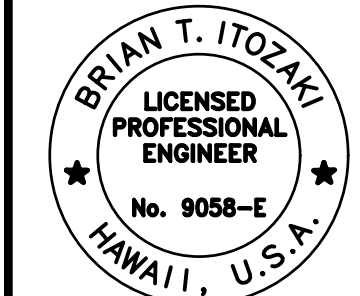


Signature: *Brian T. Itozaki*
Expiration Date: 04/30/2023
THIS WORK WAS PREPARED BY ME OR UNDER MY SUPERVISION AND CONSTRUCTION OF THIS PROJECT WILL BE UNDER MY OBSERVATION.

DATE	DESCRIPTION	BY	CHK
08/07/2026	ADDENDUM 1	SW	

DES	SM	DRW	AG	CHK	BI

DEPARTMENT OF DEFENSE
HAWAII ARMY NATIONAL GUARD
DESIGN AND PROJECT MANAGEMENT BRANCH
KAPOLEI, OAHU
KALAELOA BLDG. 01888
KALAELOA (BUILDING 1898) CONSTRUCTION OF
STAND-BY EMERGENCY GENERATOR INSTALLATIONS
ENLARGED ELEC RM PLAN & ONE LINE DIAGRAMS - EXISTING


SCALE: AS NOTED
STATE JOB NO. KALAELOA (BLDG 1898) CA-202004-C6
FEDERAL PROJECT NO.
SHEET 11 OF 14
E201

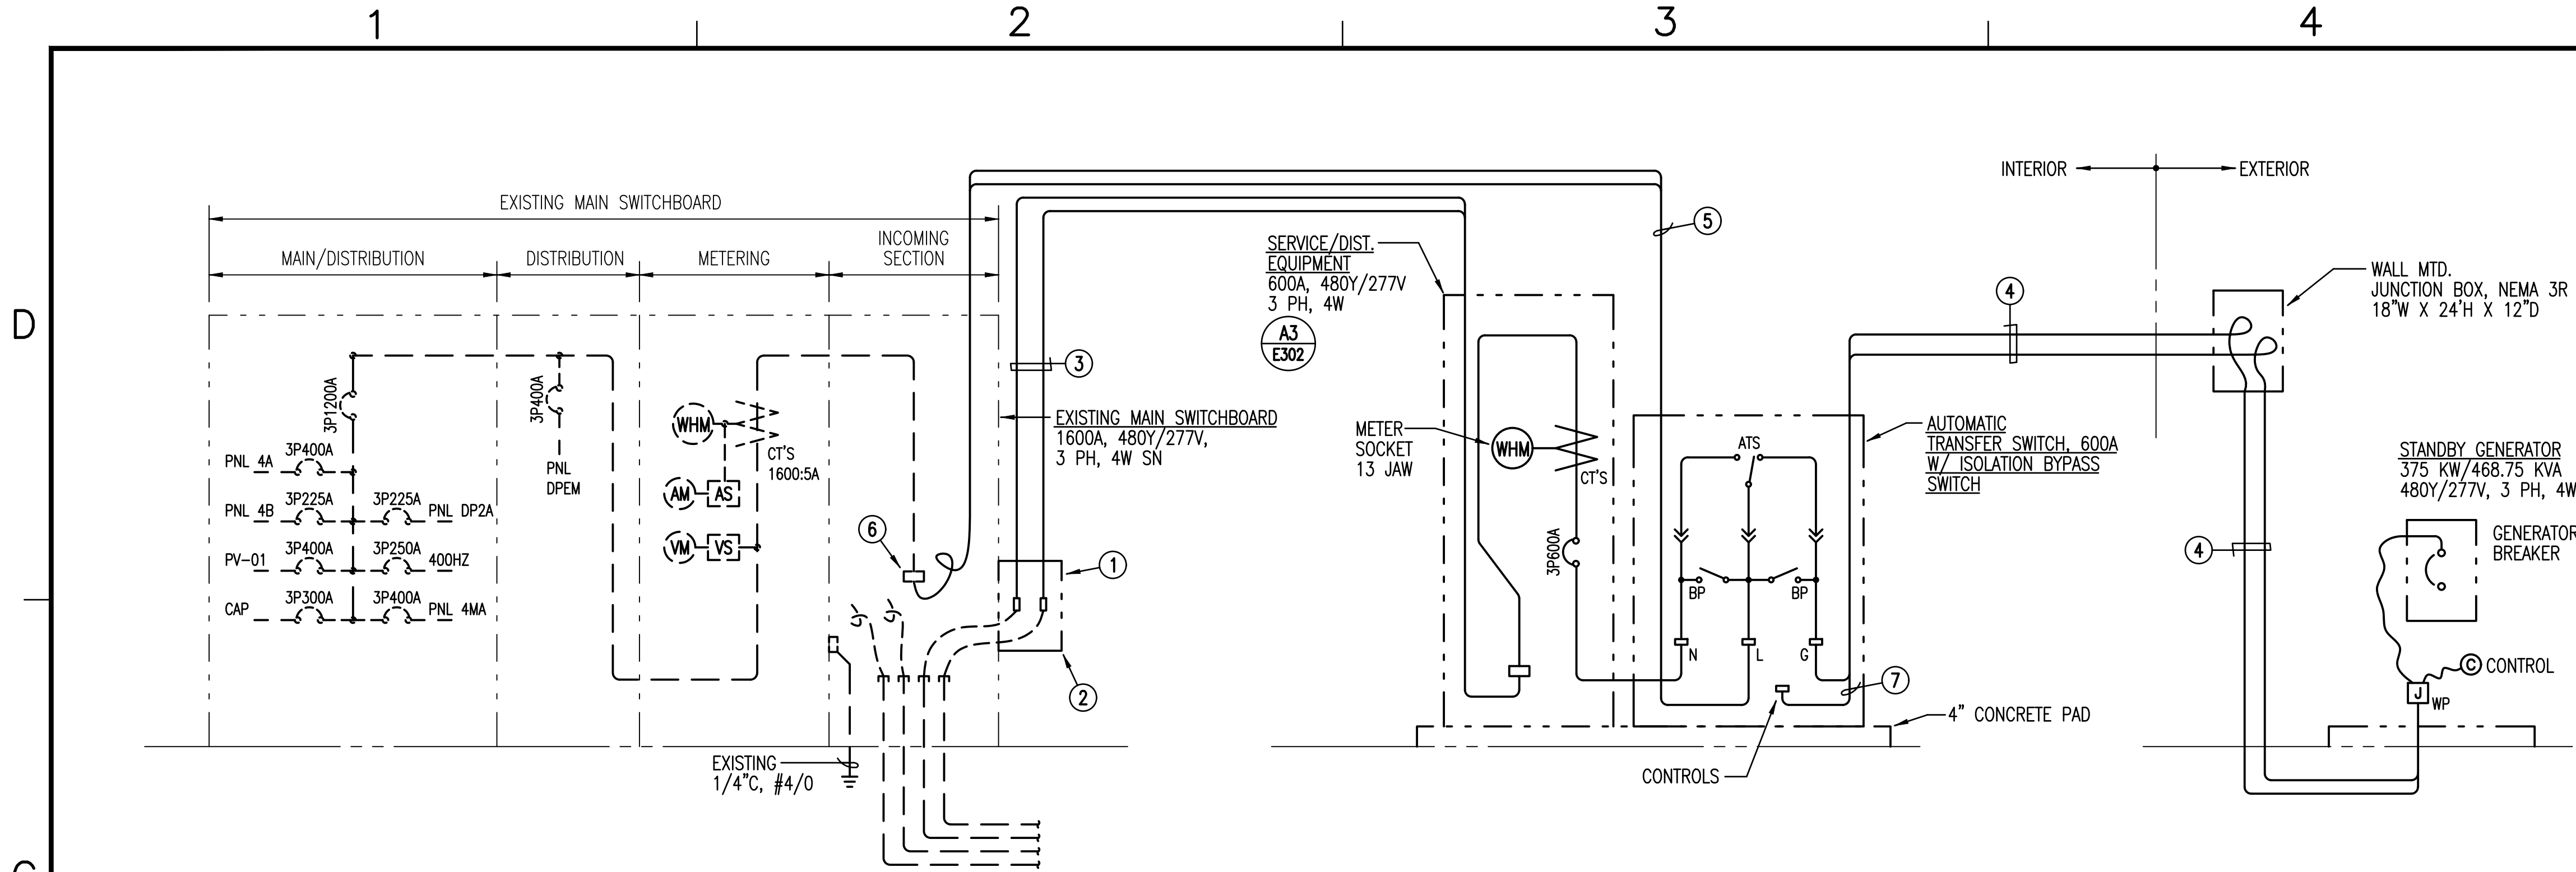

C1 NEW ONE LINE DIAGRAM
NOT TO SCALE

ELECTRICAL NOTES (EXISTING/NEW WORK)


- 1 PROVIDE NEW JUNCTION BOX, SEALABLE, 24"x24"x12"D.
- 2 CONNECT 2 SETS (4-500MCM).
- 3 PROVIDE SECONDARY SERVICE 2(4"C, 4-500MCM).
- 4 PROVIDE GENERATOR FEEDER 2(4"C, 4-500MCM) & 1"C, 7-#14.
- 5 PROVIDE STANDBY POWER FEEDER 2(4"C, 4-500MCM).
- 6 CONNECT FEEDER TO SWBD. LUGS.
- 7 CONTROL WIRING, 7-#14.

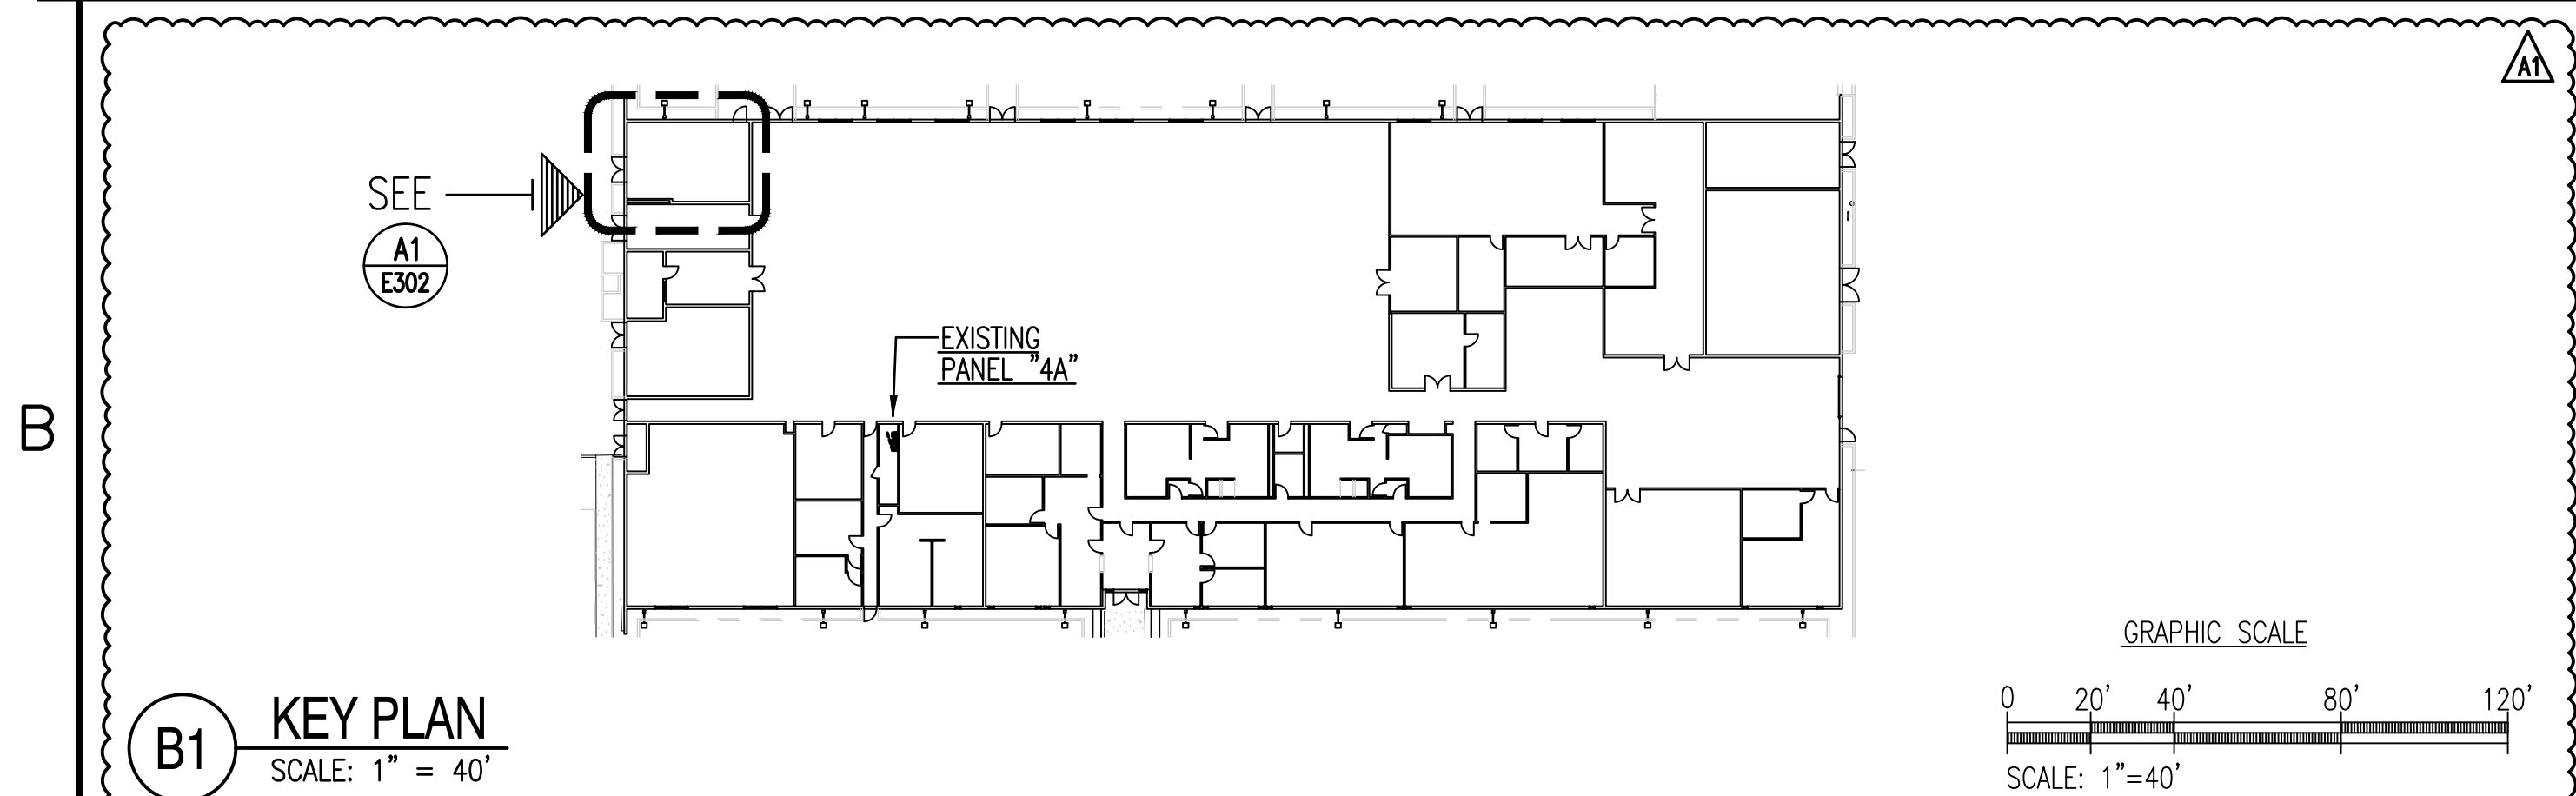


B1 KEY PLAN
SCALE: 1" = 40'

ELECTRICAL NOTES (EXISTING/REMOVAL WORK)

- 1 REMOVE EXISTING BATTERY CHARGER.
- 2 REMOVE EXISTING 3P30A SWITCH.

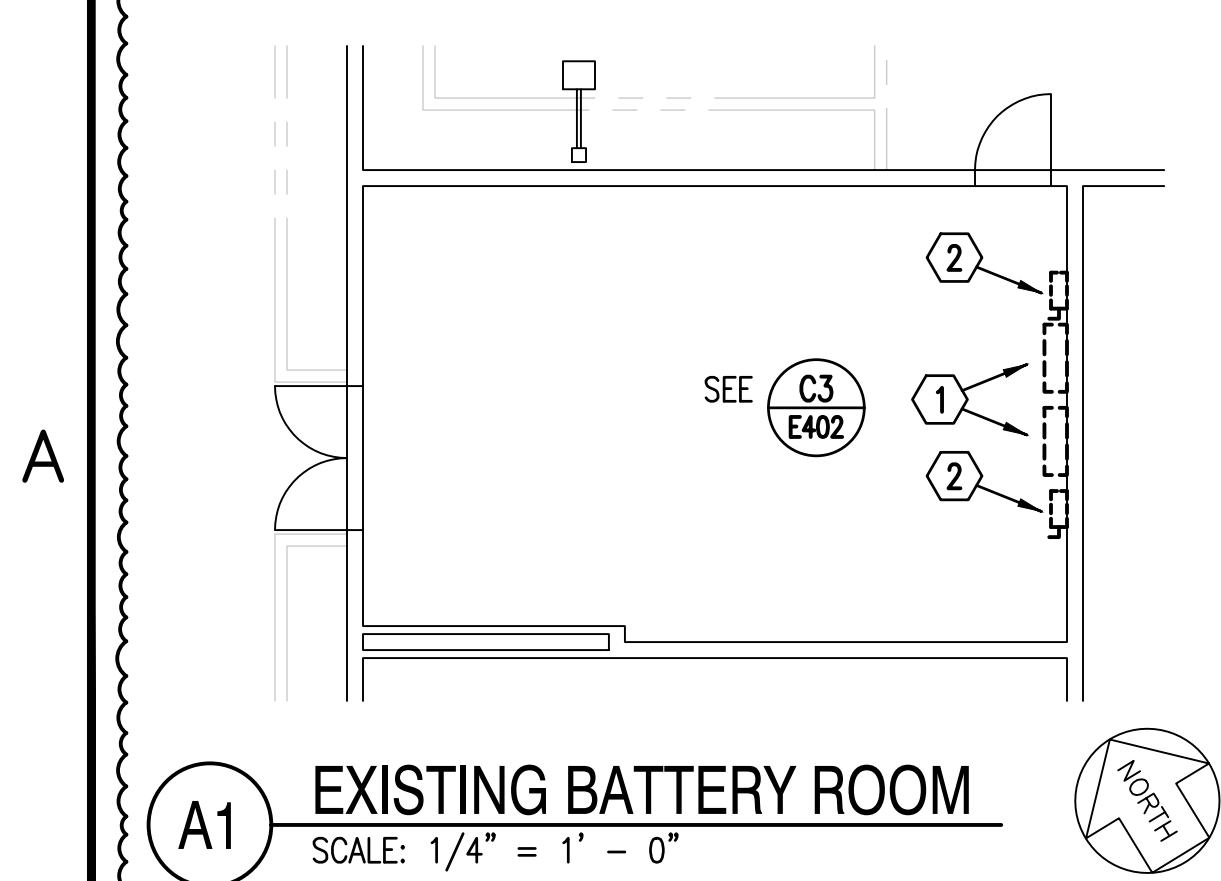


A1 EXISTING BATTERY ROOM
SCALE: 1/4" = 1' - 0"

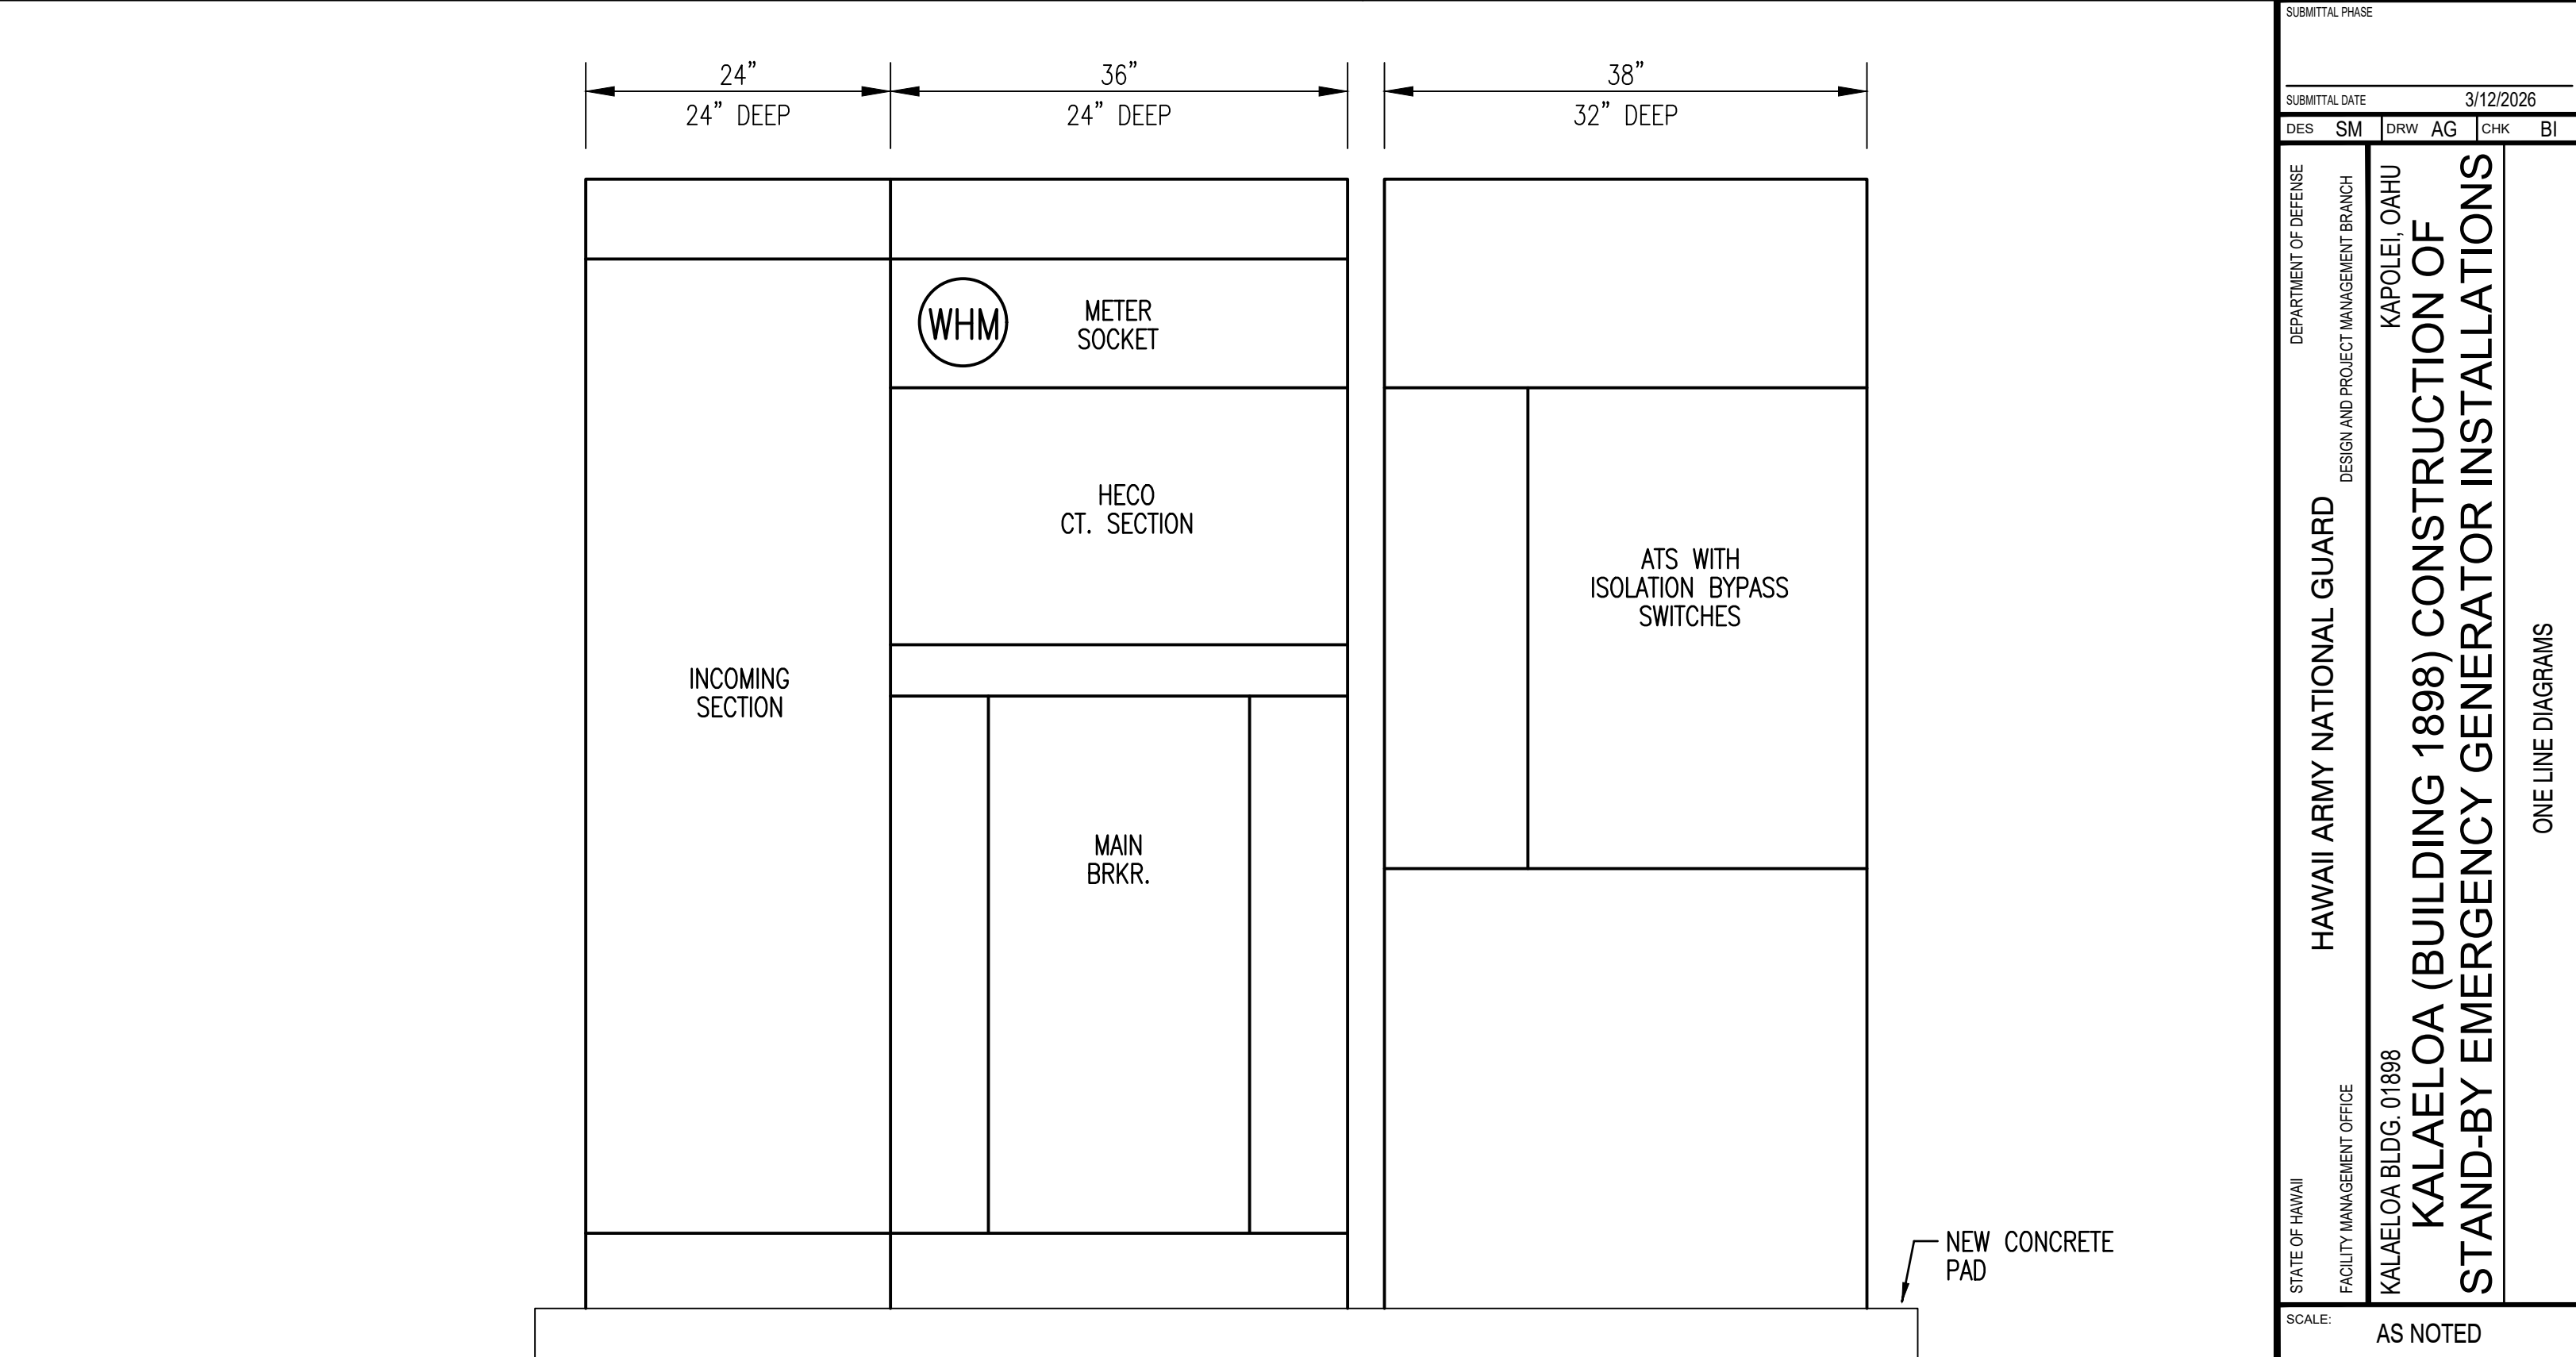

A3 ELEVATION - NEW SERVICE/DISTRIBUTION EQUIPMENT
NOT TO SCALE



BOWERS + KUBOTA CONSULTING
Public Management • Planning • Architectural Engineering Design • Construction Management

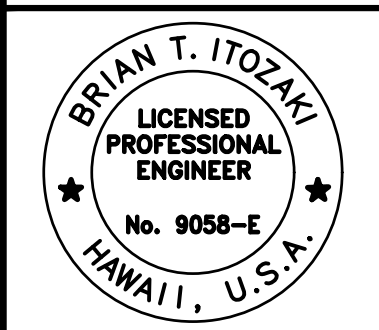

Brian T. Itozaki
Signature
04/30/2023
Expiration Date
THIS WORK WAS PREPARED BY ME OR UNDER
MY SUPERVISION AND CONSTRUCTION OF
THIS PROJECT WILL BE UNDER MY
OBSERVATION.

DATE	DESCRIPTION	BY
08/07/2026	ADDENDUM 1	SW

DES	SM	DRW	AG	CHK	BI

DEPARTMENT OF DEFENSE
HAWAII ARMY NATIONAL GUARD
DESIGN AND PROJECT MANAGEMENT BRANCH
KAPOLEI, OAHU
KALAELOA BLDG. 01888
KALAELOA (BUILDING 1898) CONSTRUCTION OF
STAND-BY EMERGENCY GENERATOR INSTALLATIONS
ONE LINE DIAGRAMS


SCALE: AS NOTED

STATE JOB NO. KALAELOA (BLDG 1898) CA-202004-C6


FEDERAL PROJECT NO.

SHEET 13 OF 14


E302

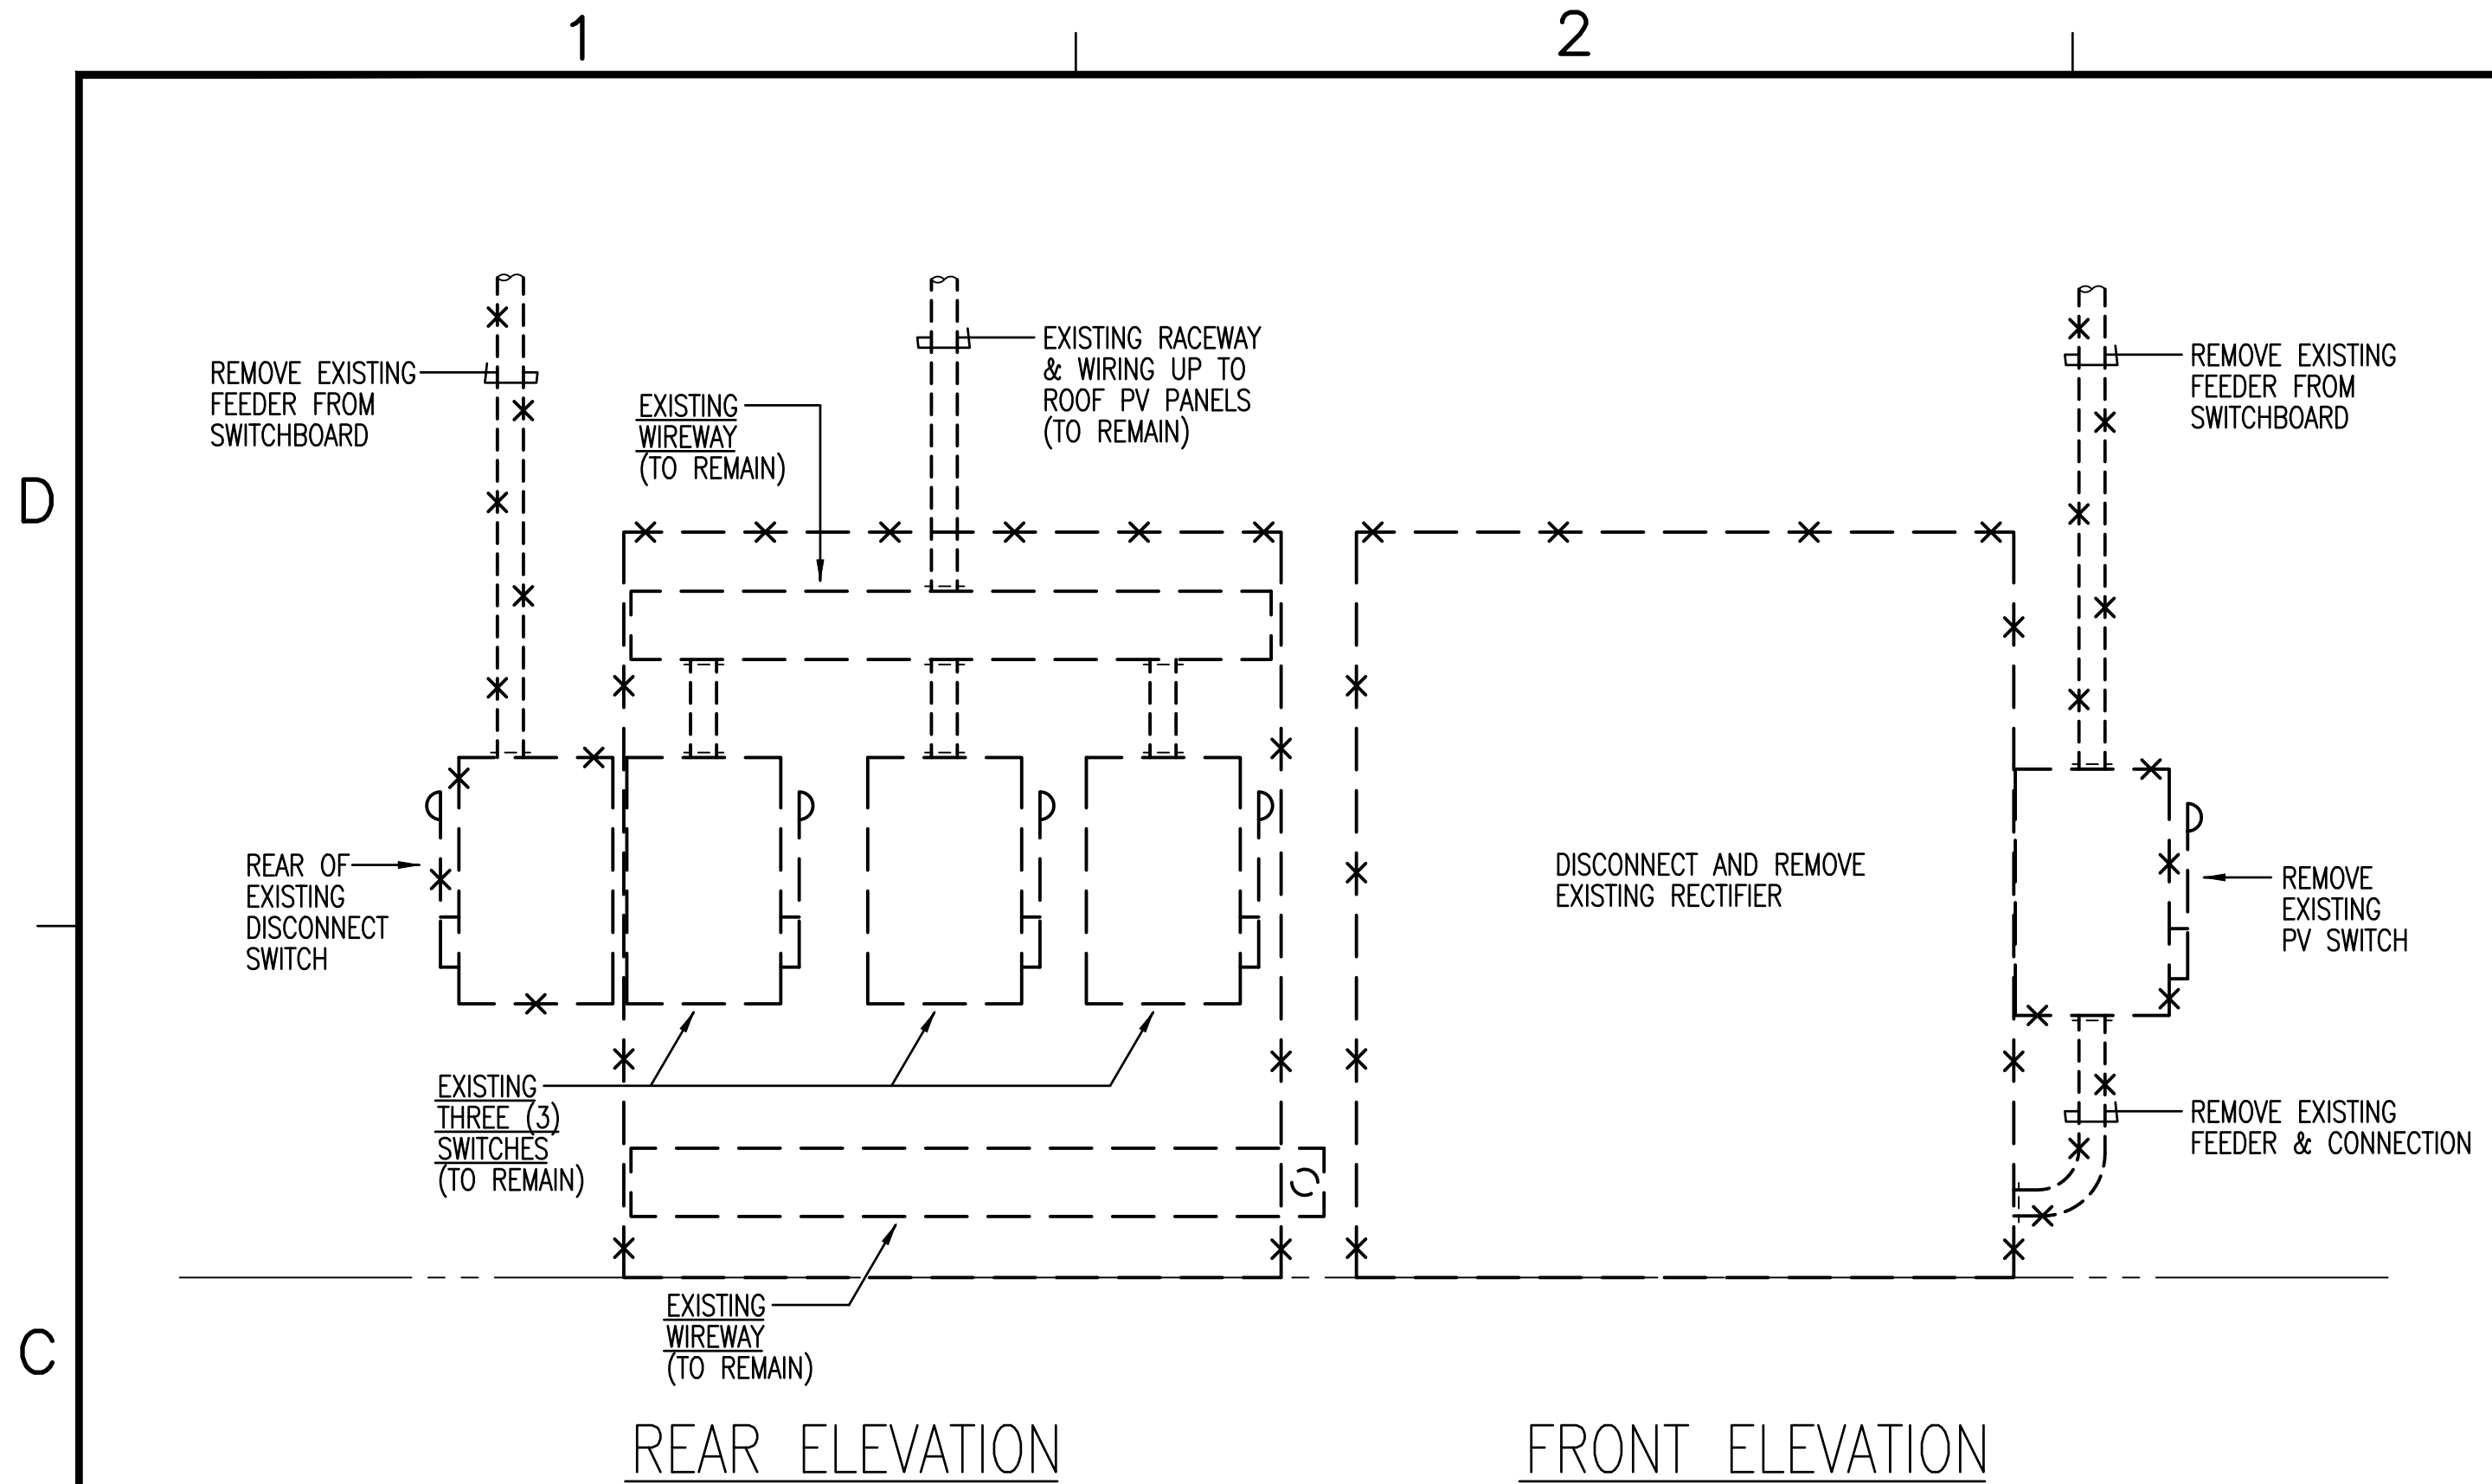

C1 EXISTING PV SYSTEM ELEVATION- (REMOVAL WORK)
NOT TO SCALE

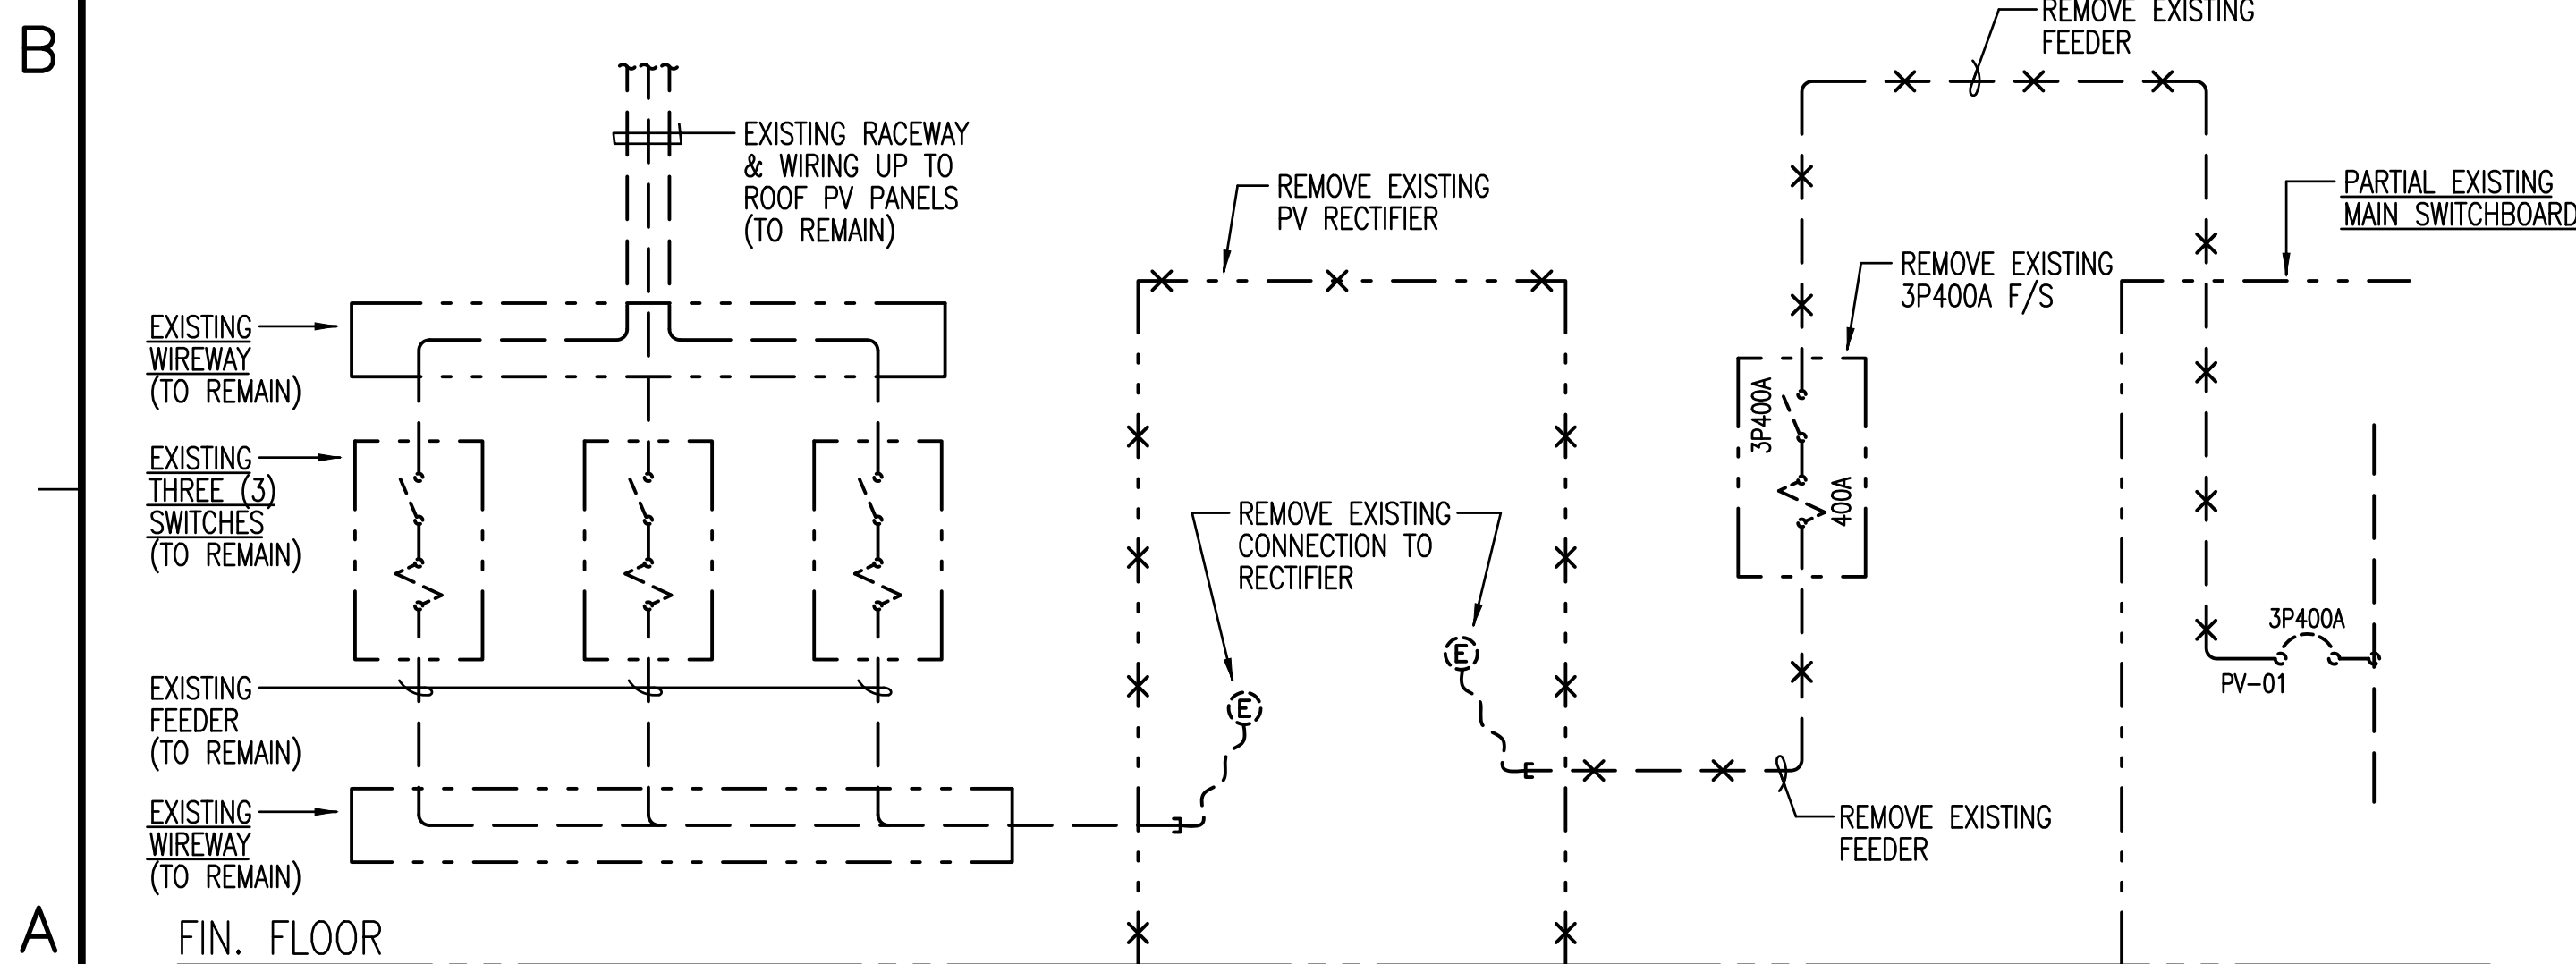


A1 EXISTING PV SYSTEM CONNECTION DIAGRAM - (REMOVAL WORK)
NOT TO SCALE

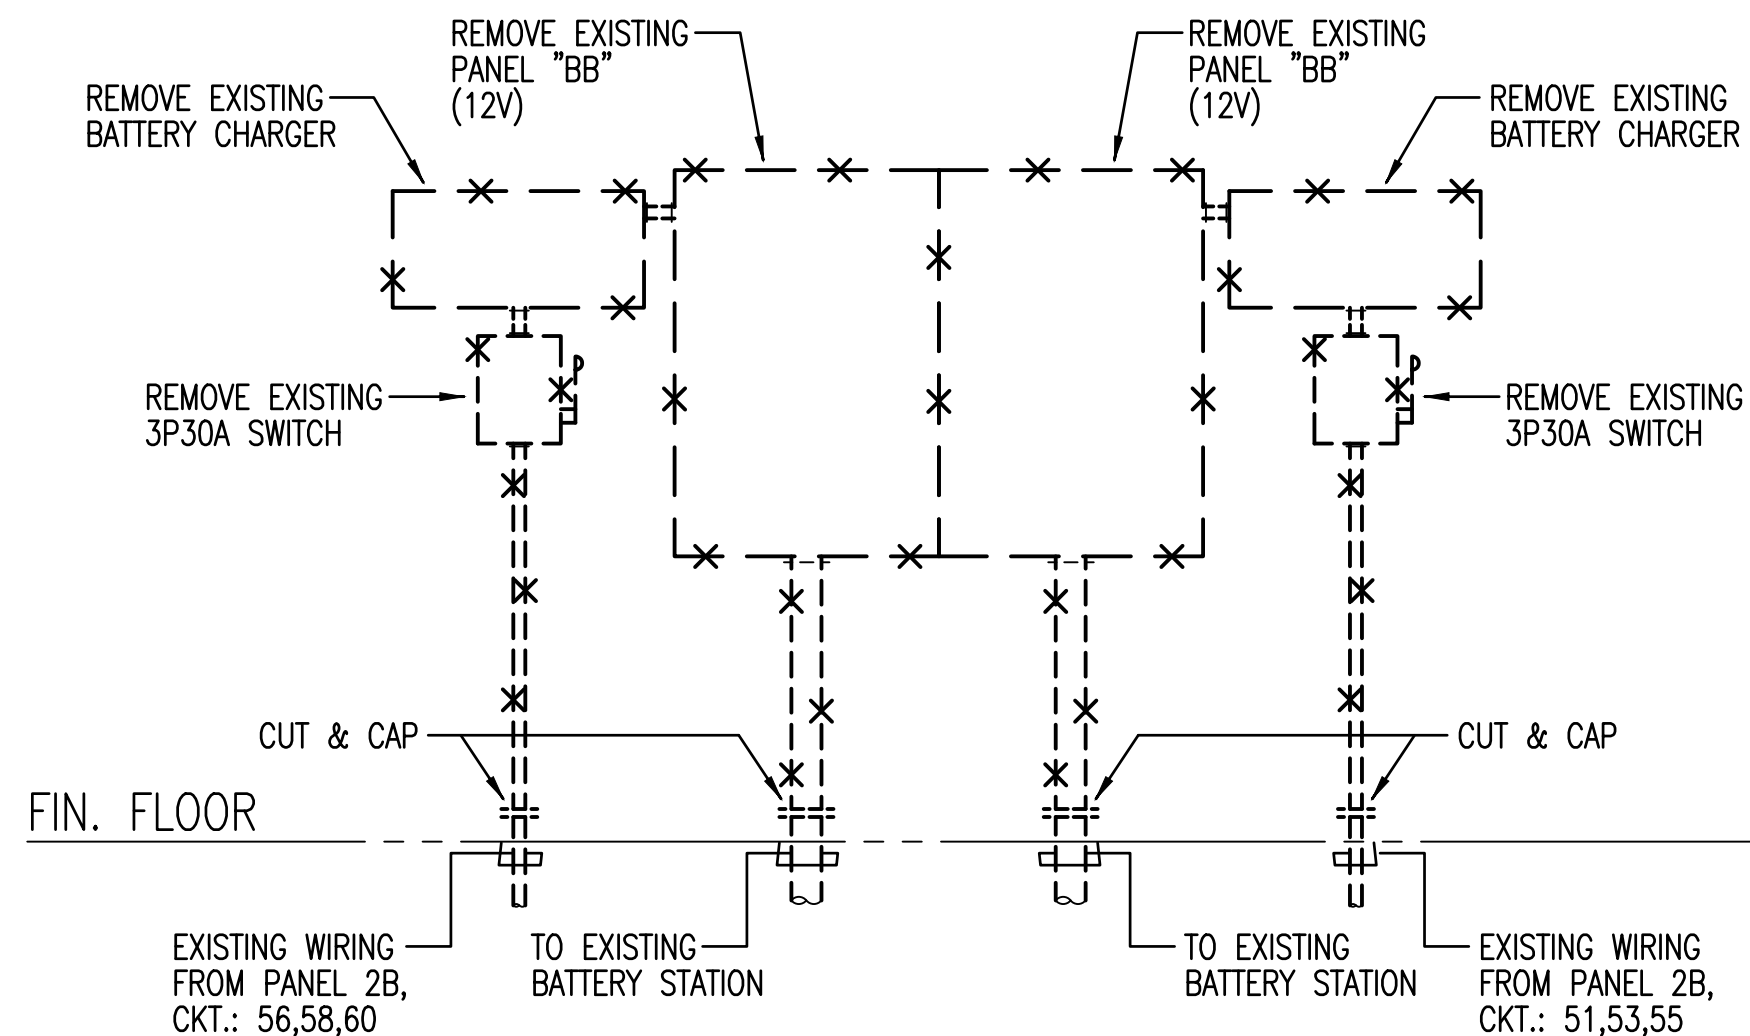

C3 EXISTING BATTERY CHARGER CONNECTION DIAGRAM - (REMOVAL WORK)
NOT TO SCALE

ELECTRICAL NOTES (EXISTING/REMOVAL WORK)


- 1 REMOVE EXISTING 3P200A CIRCUIT BREAKER AND WIRING.
- 2 REMOVE EXISTING 3PDT200A TRANSFER SWITCH AND WIRING.
- 3 REMOVE EXISTING 200A, 4W RECEPTACLE AND WIRING.
- 4 REMOVE EXISTING 8x8 WIREWAY AND WIRING.
- 5 INTERCEPT WIRING.
- 6 REMOVE PANEL.
- 7 REMOVE EQUIP.

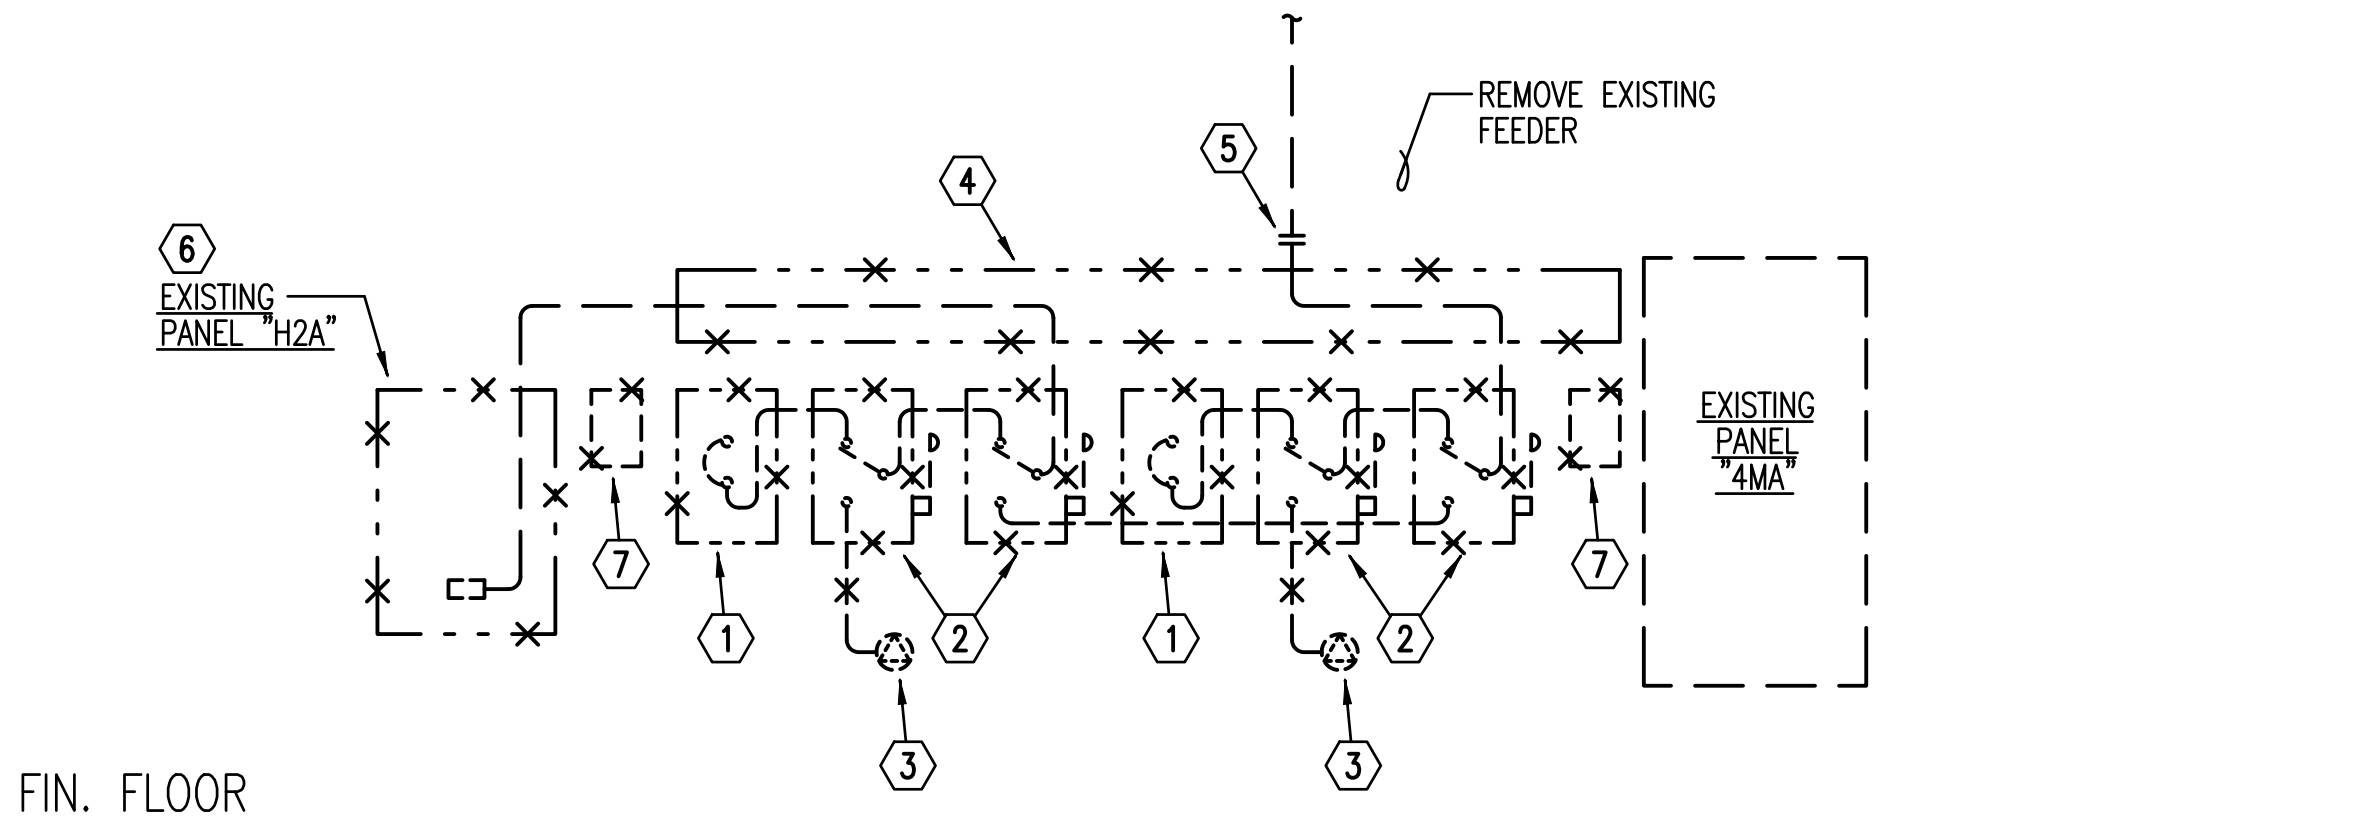

A3 400HZ SYSTEM CONNECTION DIAGRAM - (REMOVAL WORK)
NOT TO SCALE



BK BOWERS + KUBOTA CONSULTING
Public Management • Planning • Architecture/Engineering Design • Construction Management

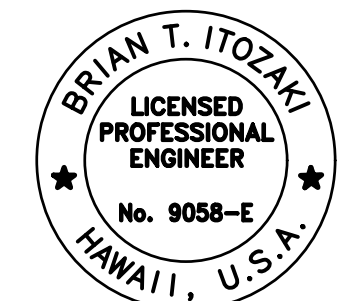

Brian T. Itozaki
Signature
04/30/2023
Expiration Date
THIS WORK WAS PREPARED BY ME OR UNDER
MY SUPERVISION AND CONSTRUCTION OF
THIS PROJECT WILL BE UNDER MY
OBSERVATION.

ADDENDUM	DESCRIPTION	DATE	APPROVED
1		08/07/2026	

DES	SM	DRW	AG	CHK	BI

DEPARTMENT OF DEFENSE
HAWAII ARMY NATIONAL GUARD
DESIGN AND PROJECT MANAGEMENT BRANCH
KAPOLEI, OAHU
KALAELOA BLDG. 01/888
KALAELOA (BLDG 1898) CONSTRUCTION OF
STAND-BY EMERGENCY GENERATOR INSTALLATIONS
DETAILS I

SCALE: AS NOTED

STATE JOB NO. KALAELOA (BLDG 1898) CA-202004-C6

FEDERAL PROJECT NO.

SHEET 13 OF 14

E402